


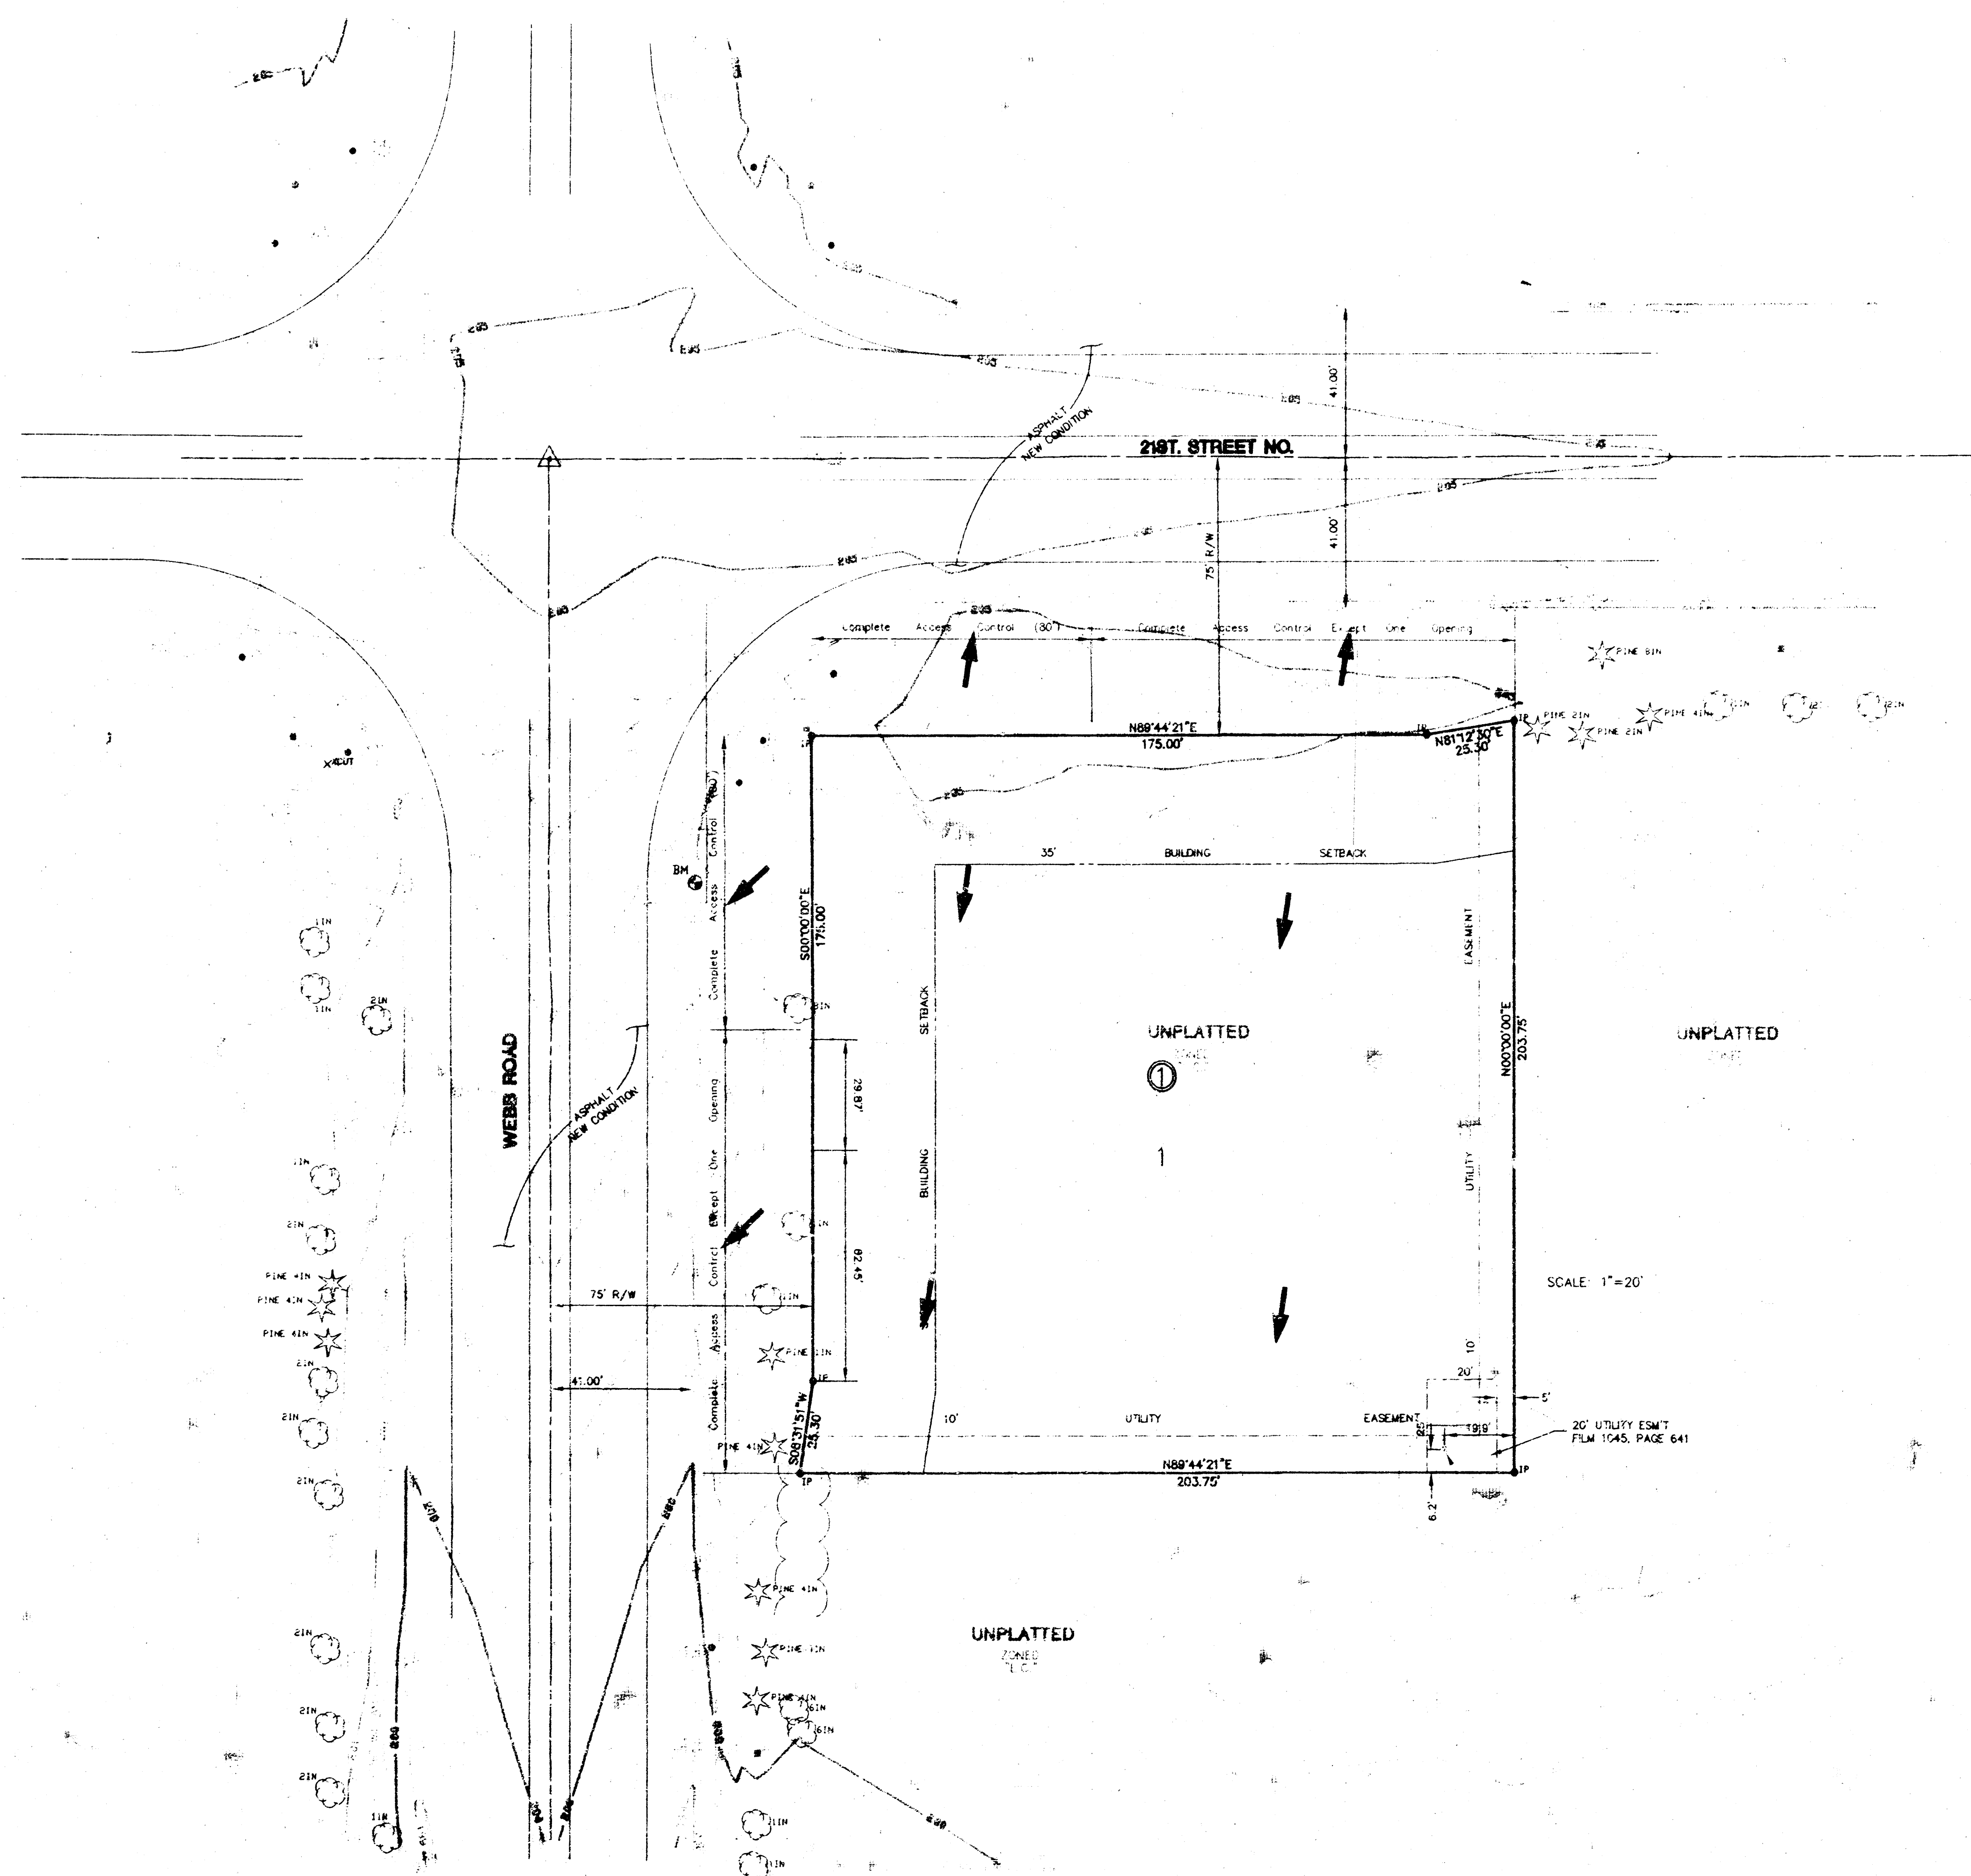

SCALE: 1"=30'

SCALE: 1"=20'

TOTAL PETROLEUM
PROJECT NAME

DRAINAGE AND

UTILITY PLAN

DESIGN TITLE

GJA DESIGN GJA DRAWN BY

GJA CHECKED BY DATE 12/6/94

DRNGUTL JOB NO. 1 SHEET OF 1



MID-KANSAS ENGINEERING
CONSULTANTS, INC.
411 N. WEBB ROAD
WICHITA, KS. 67206
316-684-9600