


DRAINAGE PLAN

VIA CHRISTI REGIONAL MEDICAL CENTER, INC.

TO WICHITA, SEDGWICK COUNTY, KANSAS

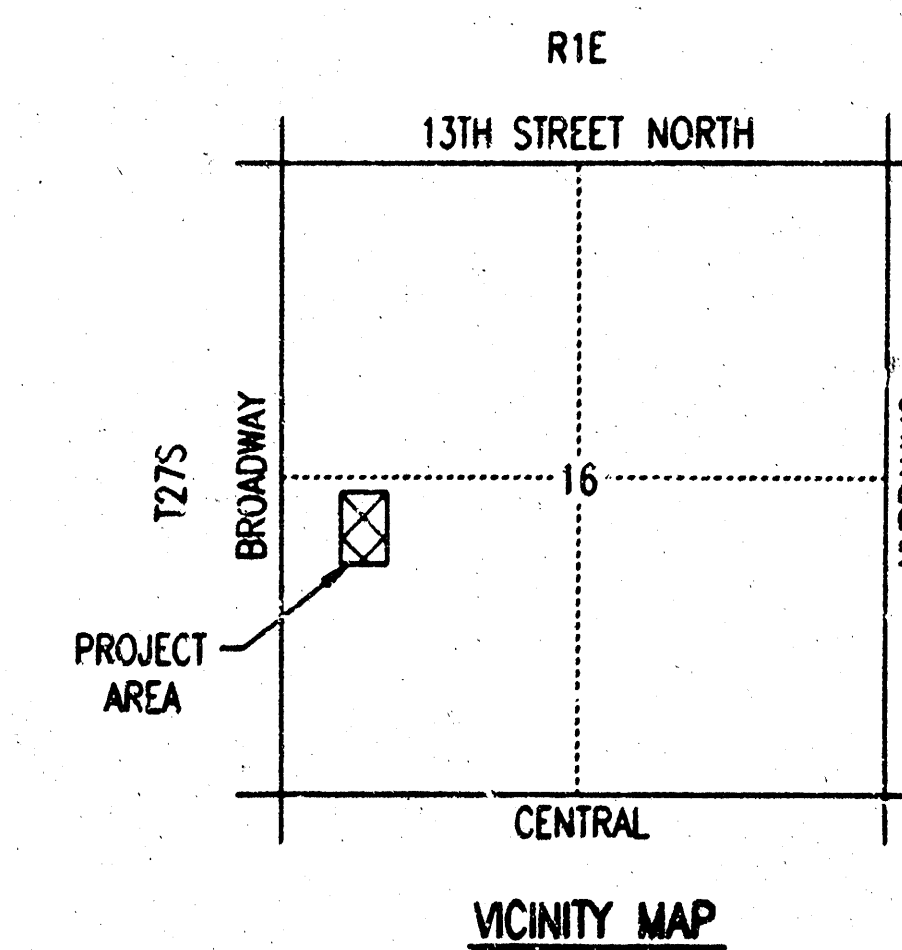

SCALE: 1" = 50'


● = 3/4" IRON PIPE W/PEC CAP UNLESS OTHERWISE NOTED

B.M. 9: Chiseled "d" in Top N. End 10" Concrete Curb at Back of Walk
600± N. of Murdock

Elev.=114.84 City Datum

ALL AREAS OF THE PLAT ARE DEVELOPED, THEREFORE THERE WILL BE NO INCREASE IN RUNOFF FROM EXISTING CONDITIONS. DRAINAGE FROM LOT 1, BLOCK 1 SHALL BE ROUTED TO TOPEKA OR MURDOCK VIA FLUMES, PRIVATE STORM SEWER SYSTEMS, DYES OR OTHER APPROVED DRAINAGE DEVICES.

STORM WATER FLOW DIRECTION

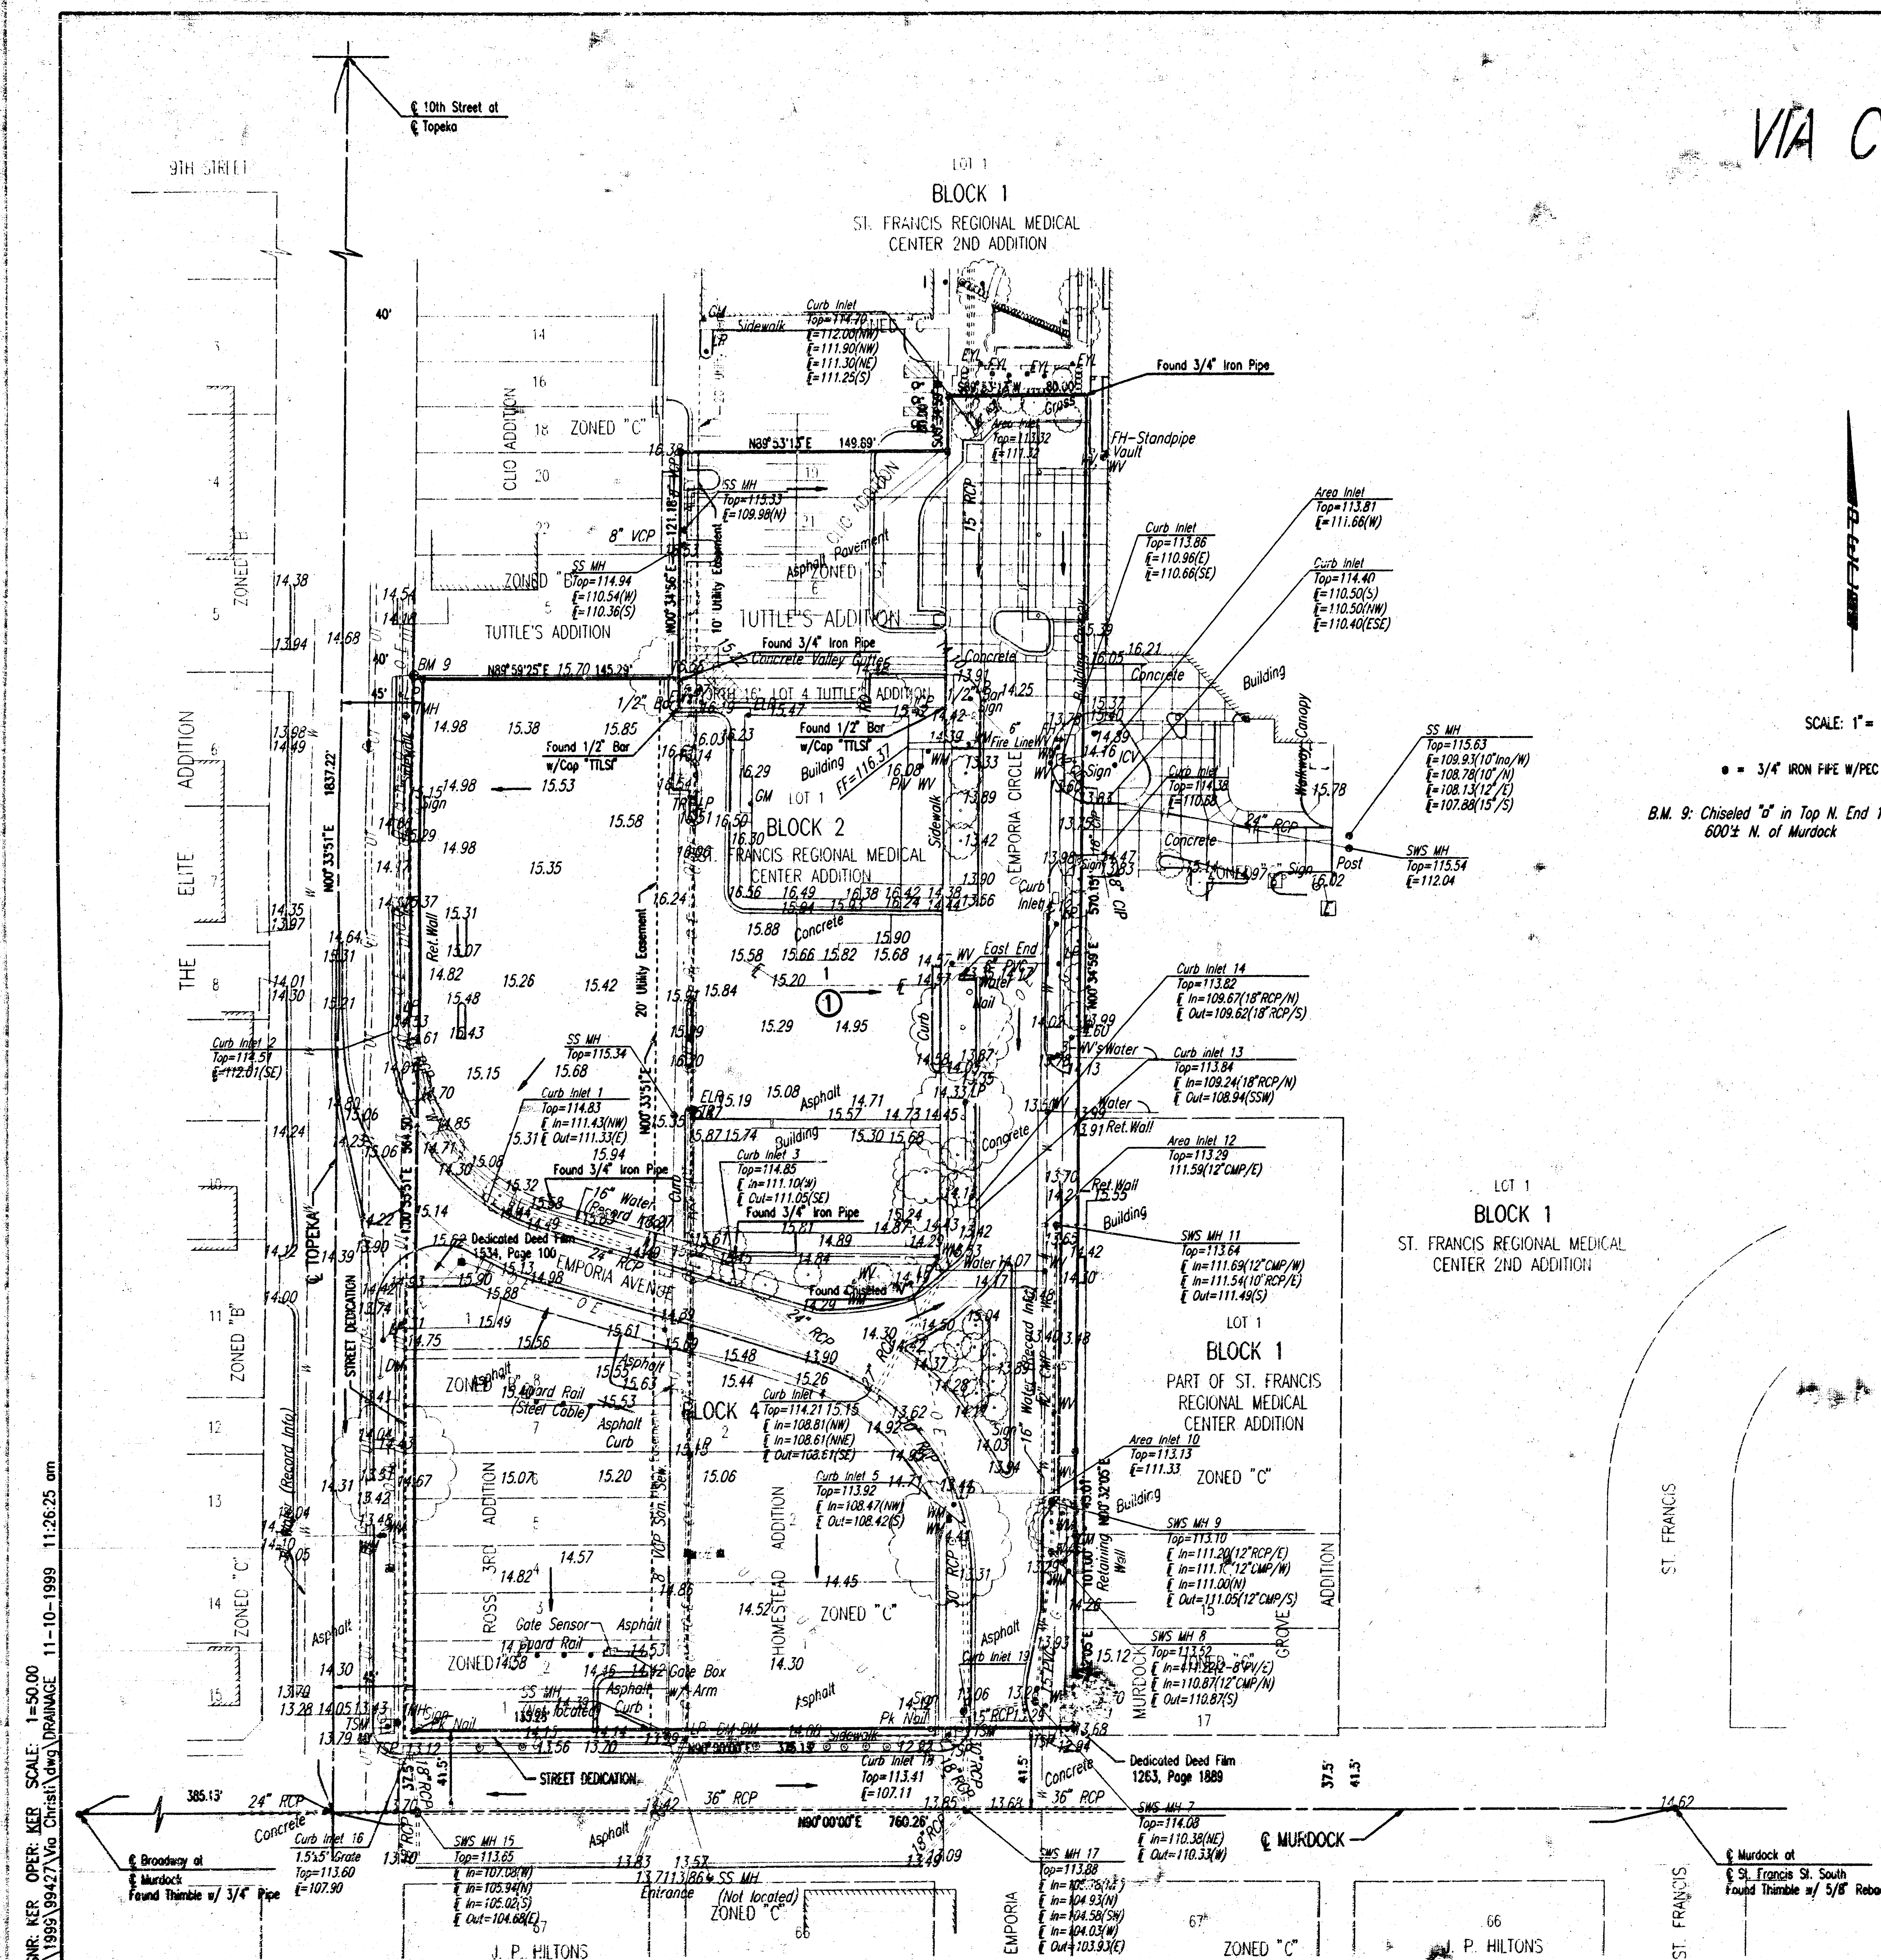

SSNR: KER OPER: KER SCALE: 1=50.00
 2-1998 89427 Vn Christi Dwg DRAINAGE 11-10-1999 11:26:25 nm