


FYHA REGION NO.	STATE	PROJECT NO.	YEAR	SHEET NO.	TOTAL SHEETS
7	KS.	87-U-1362-01	199	113	149

SCALE: 1" = 100'

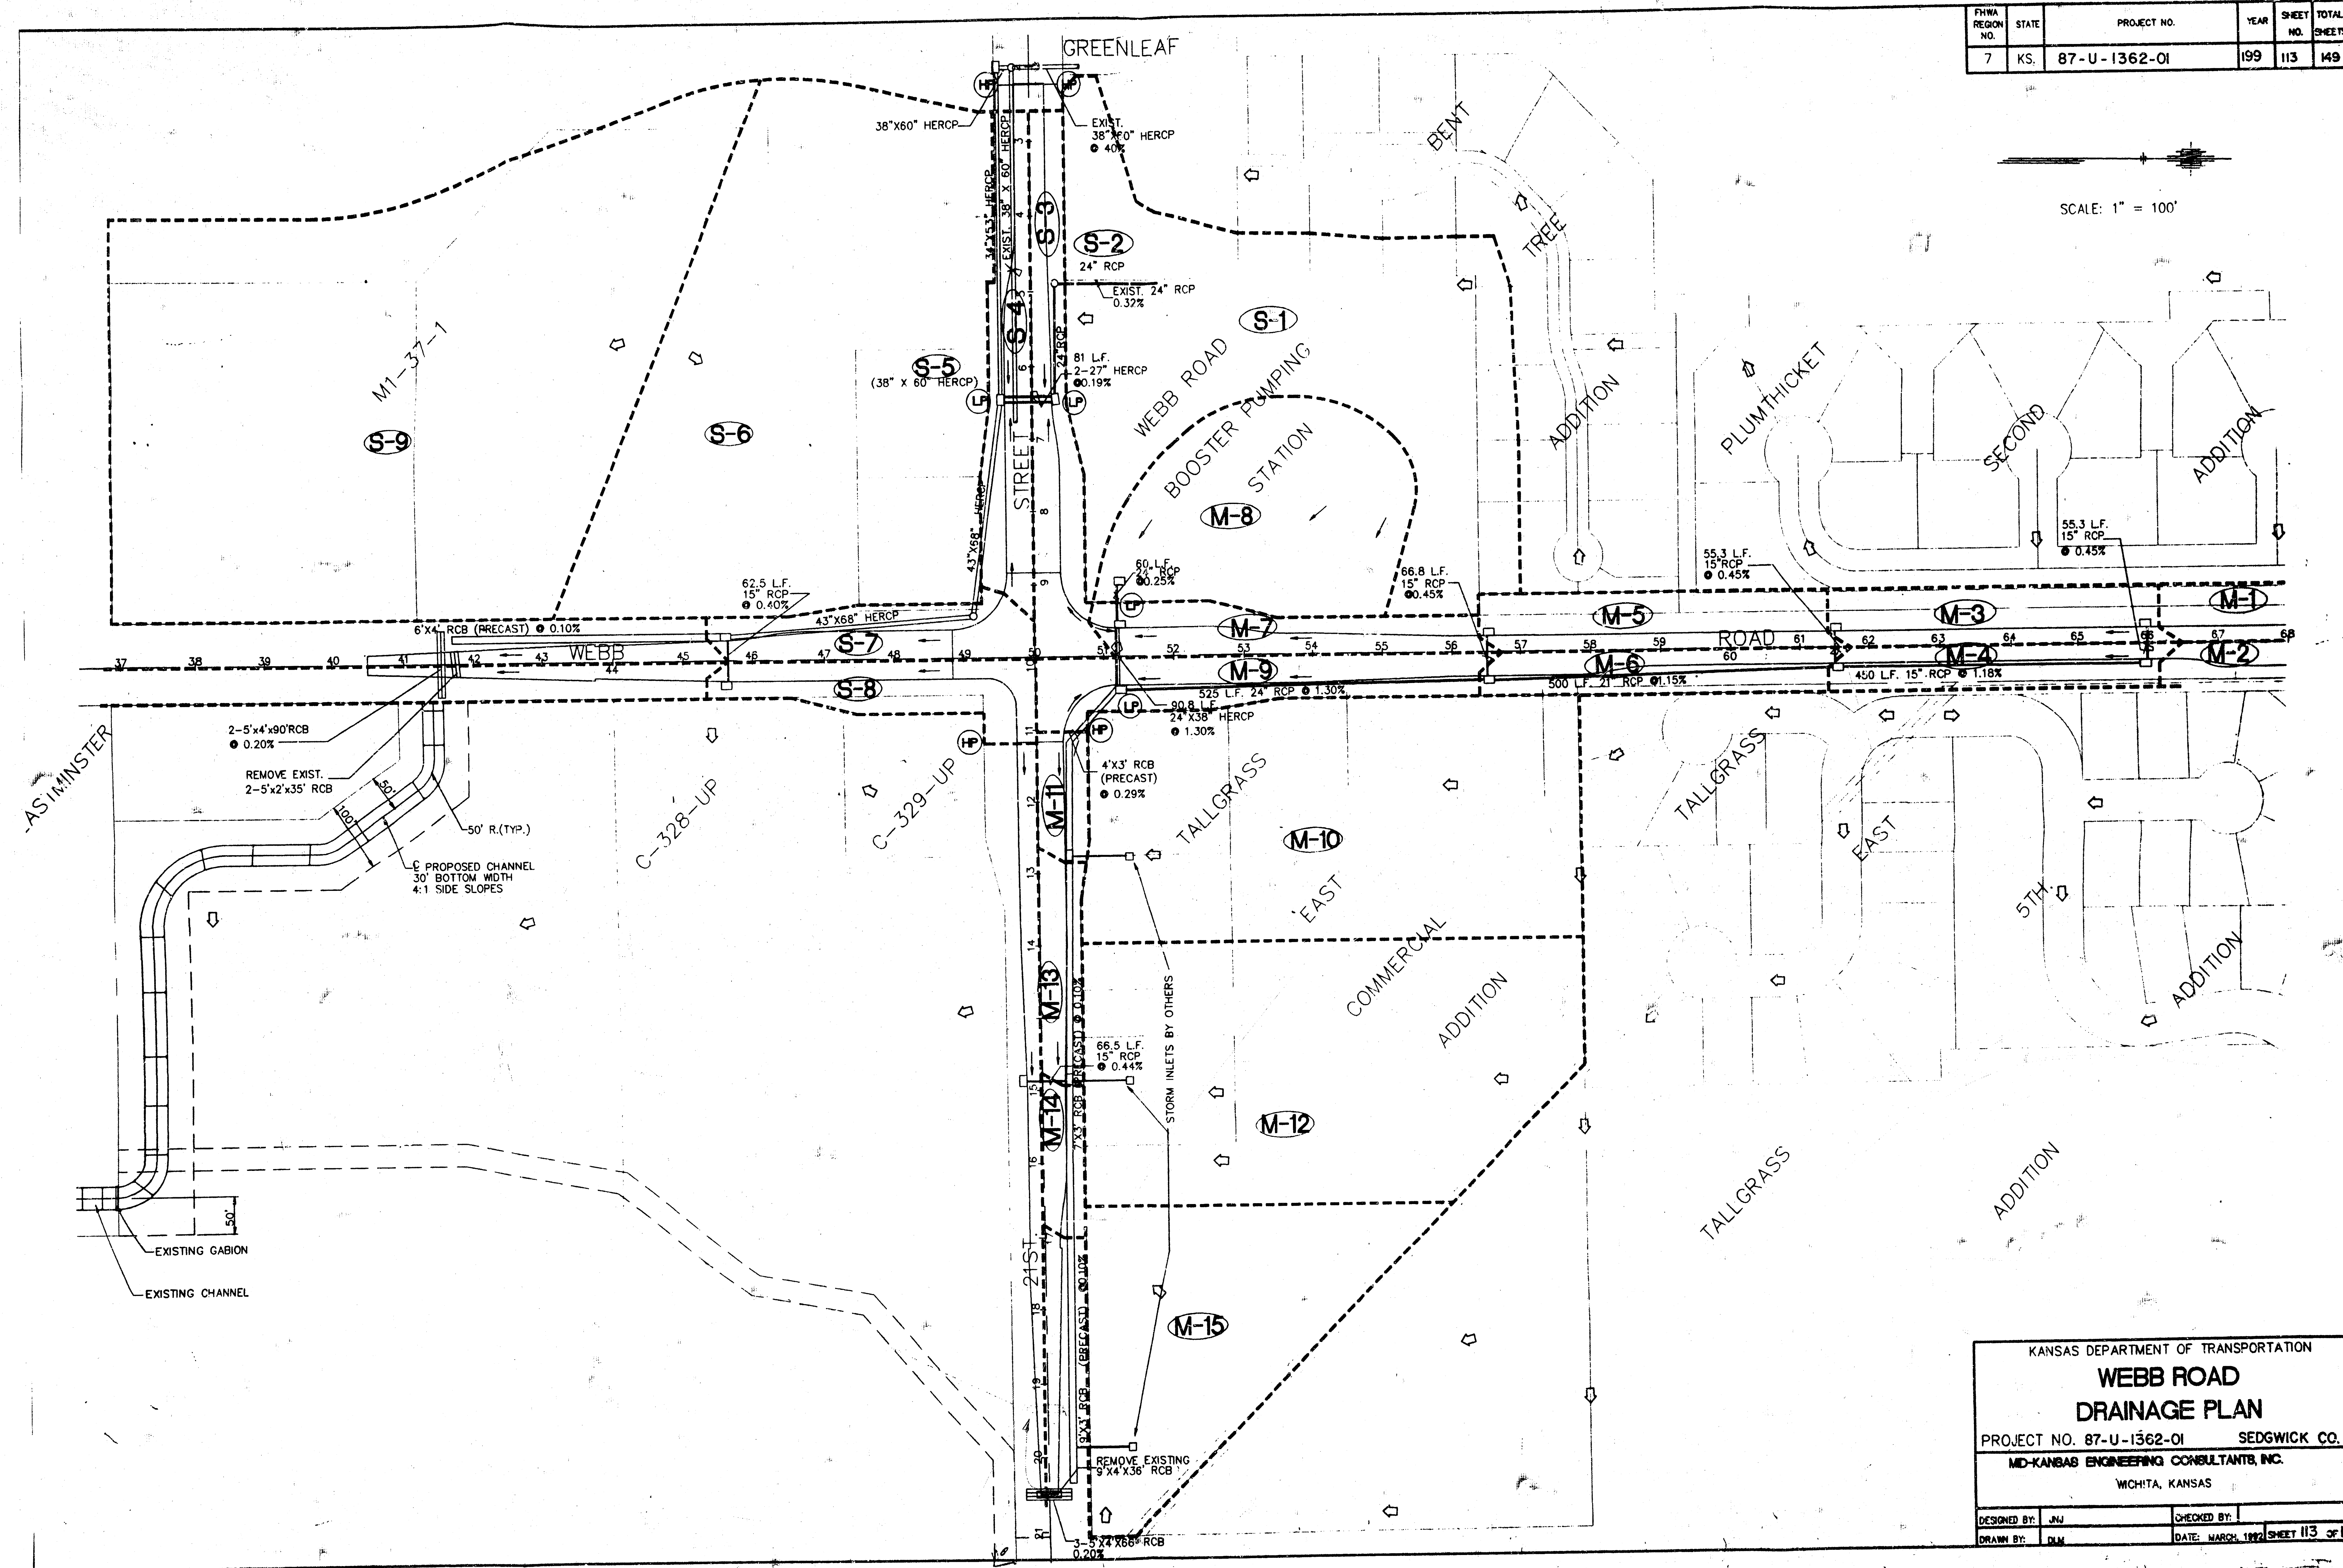

KANSAS DEPARTMENT OF TRANSPORTATION			
WEBB ROAD			
DRAINAGE PLAN			
PROJECT NO. 87-U-1362-01		SEDGWICK CO.	
MO-KANSAS ENGINEERING CONSULTANTS, INC.			
WICHITA, KANSAS			
DESIGNED BY: JLN	CHECKED BY:		
DRAWN BY: JLN	DATE: MARCH 1992	SHEET 113	OF 149