



FHWA REGION NO.	STATE	PROJECT NO.	YEAR	SHEET NO.	TOTAL SHEETS
7	KANSAS	54-87 K-6657-01	2002	641A	1122

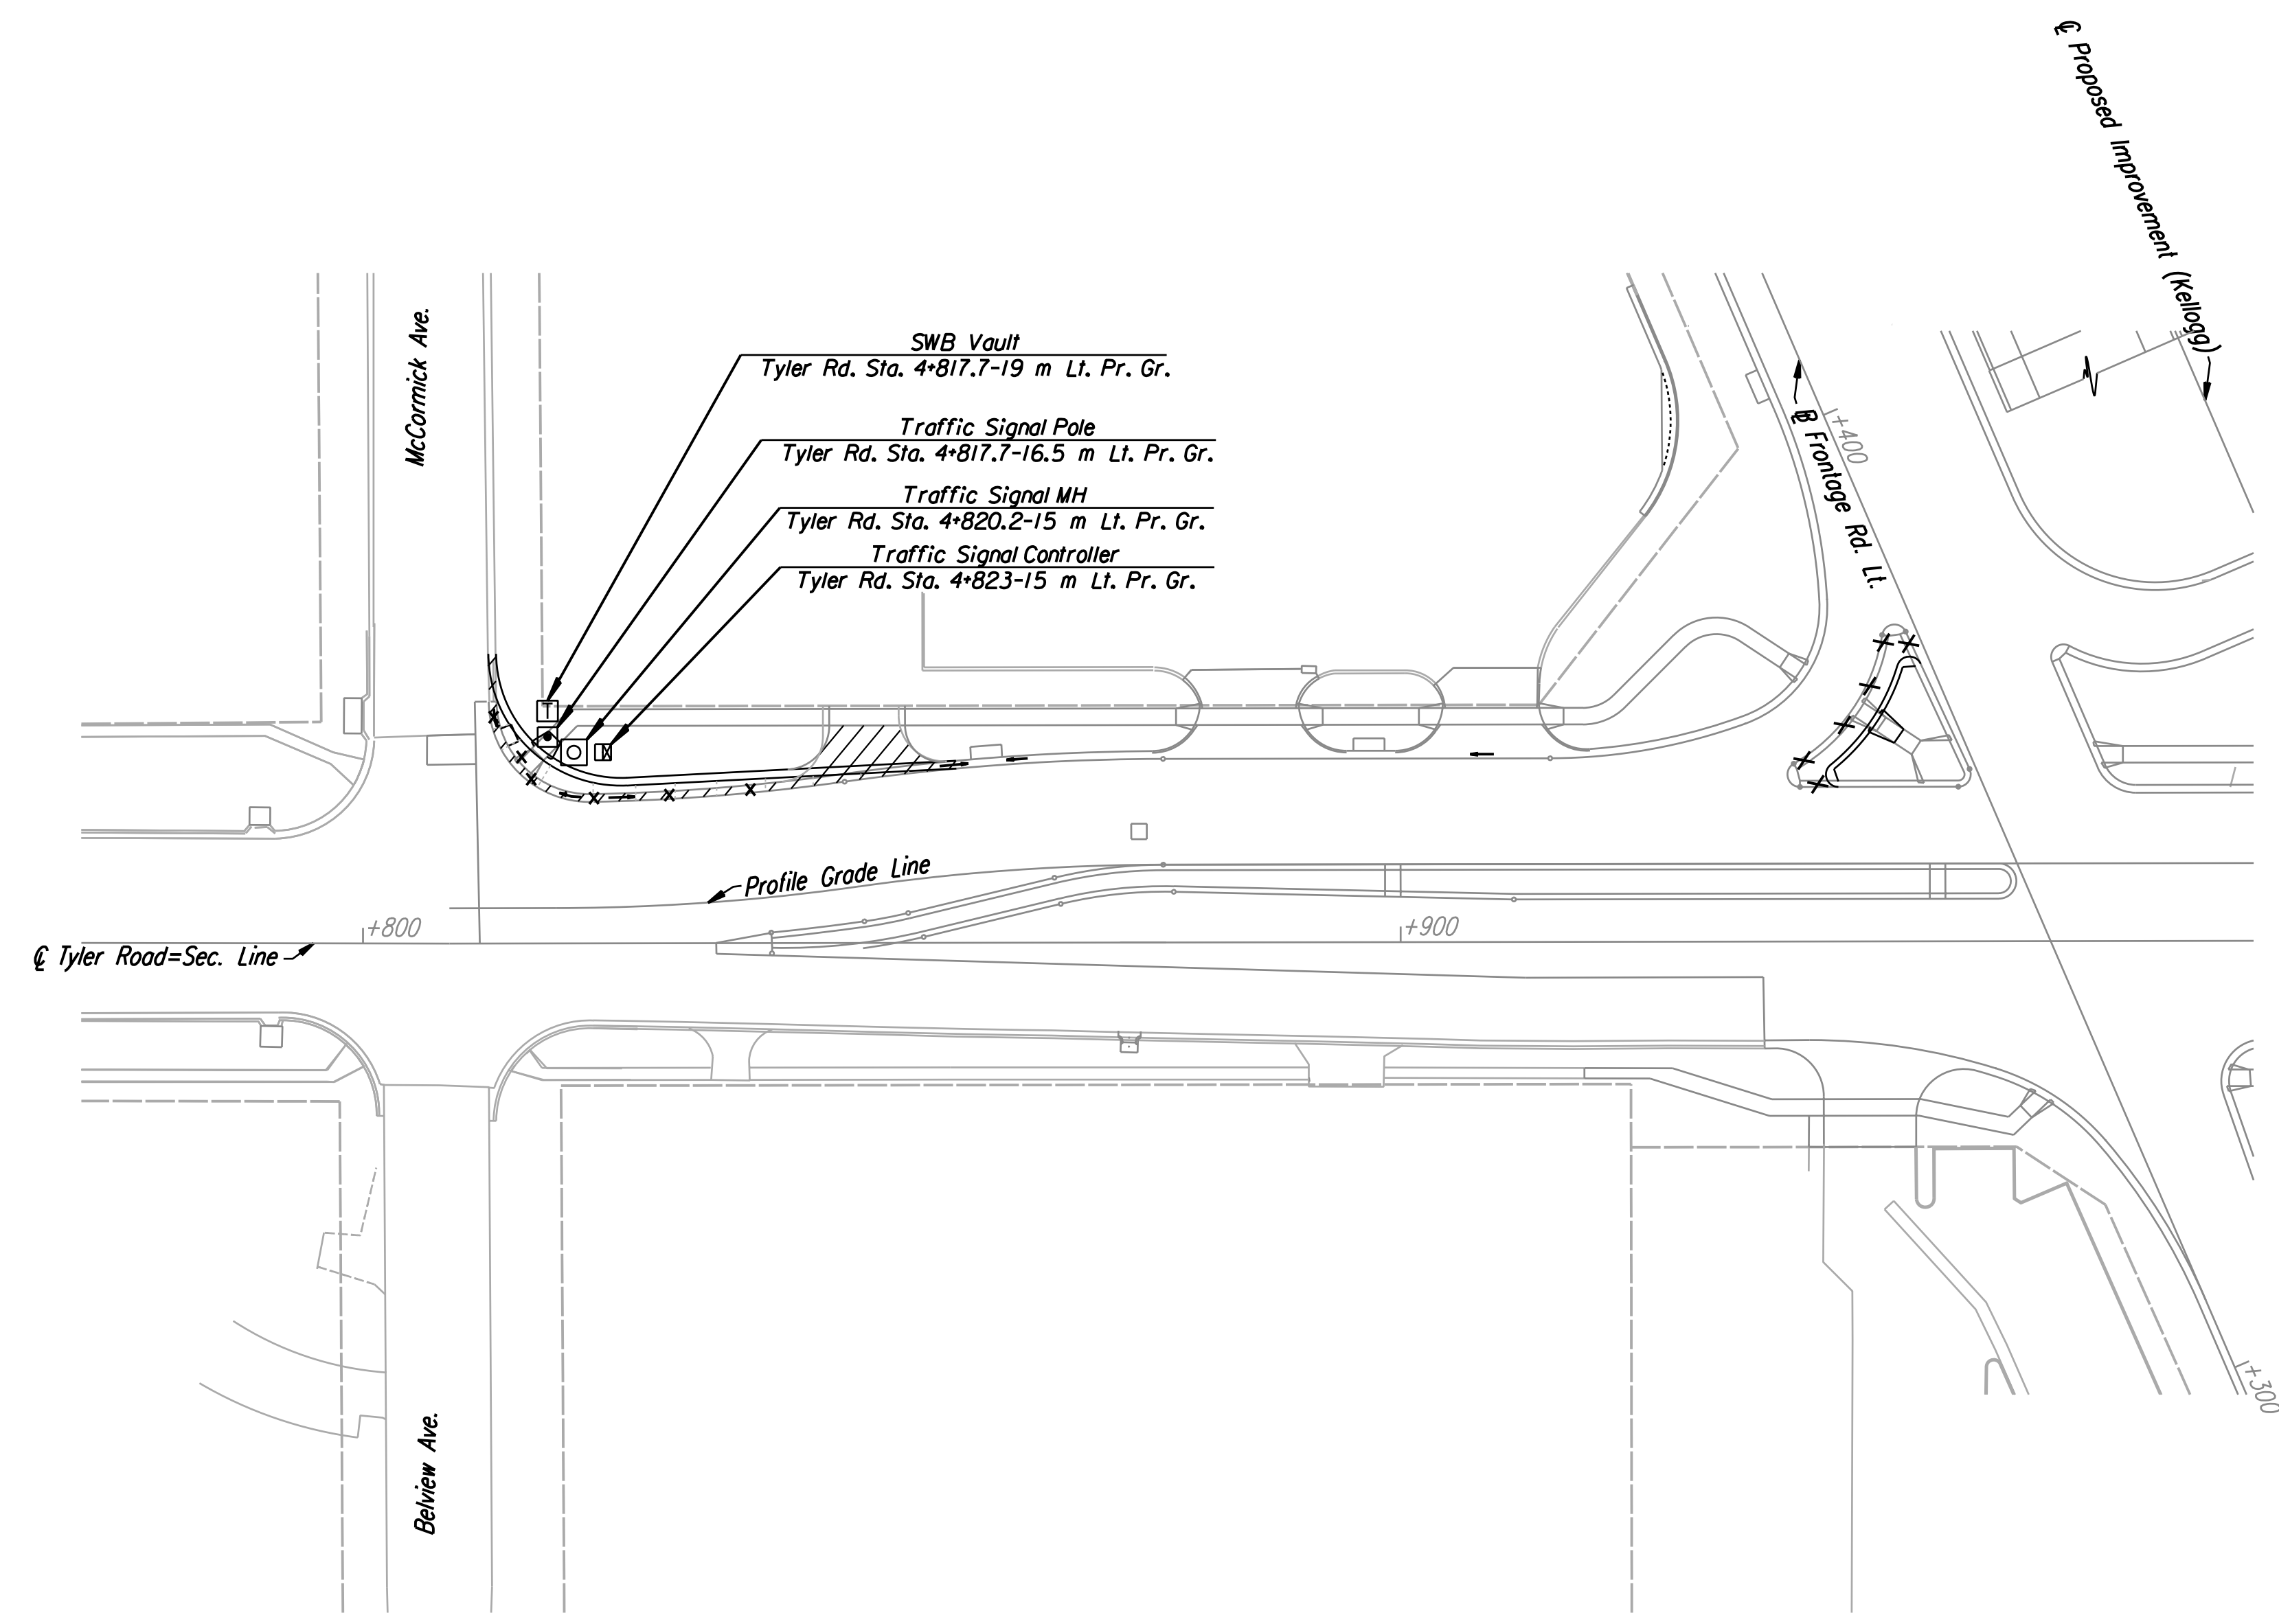

DSNR: JPM OPER: SVB SCALE: 1:250  
 I:/1997/97362/As-Builts/dgn's/Vol\_3/Sh 641a-Tyler-Lighting\_Plan.dgn Last Rev: 9-18-07 By: gdr

**RECORD DRAWING**

1			
No.	Revisions	By	Date
CITY OF WICHITA LIGHTING PLAN TYLER ROAD STA. 4+700 TO STA. 4+920 SEDGWICK COUNTY			
 <b>Professional Engineering Consultants, P.A.</b> <small>303 S. TOPEKA • WICHITA, KANSAS 67202          316-262-2691 • FAX 316-262-3003</small>			
Designed by	JPM	Checked by	WDH
Drawn by	SVB	Date	April, 2002
		Job No.	97362