



| REGION NO. | STATE  | PROJECT NO.           | YEAR | SHEET NO. | TOTAL SHEETS |
|------------|--------|-----------------------|------|-----------|--------------|
| 7          | KANSAS | (BC) 96-87-K044-1(28) | 1978 | 111       | 143          |

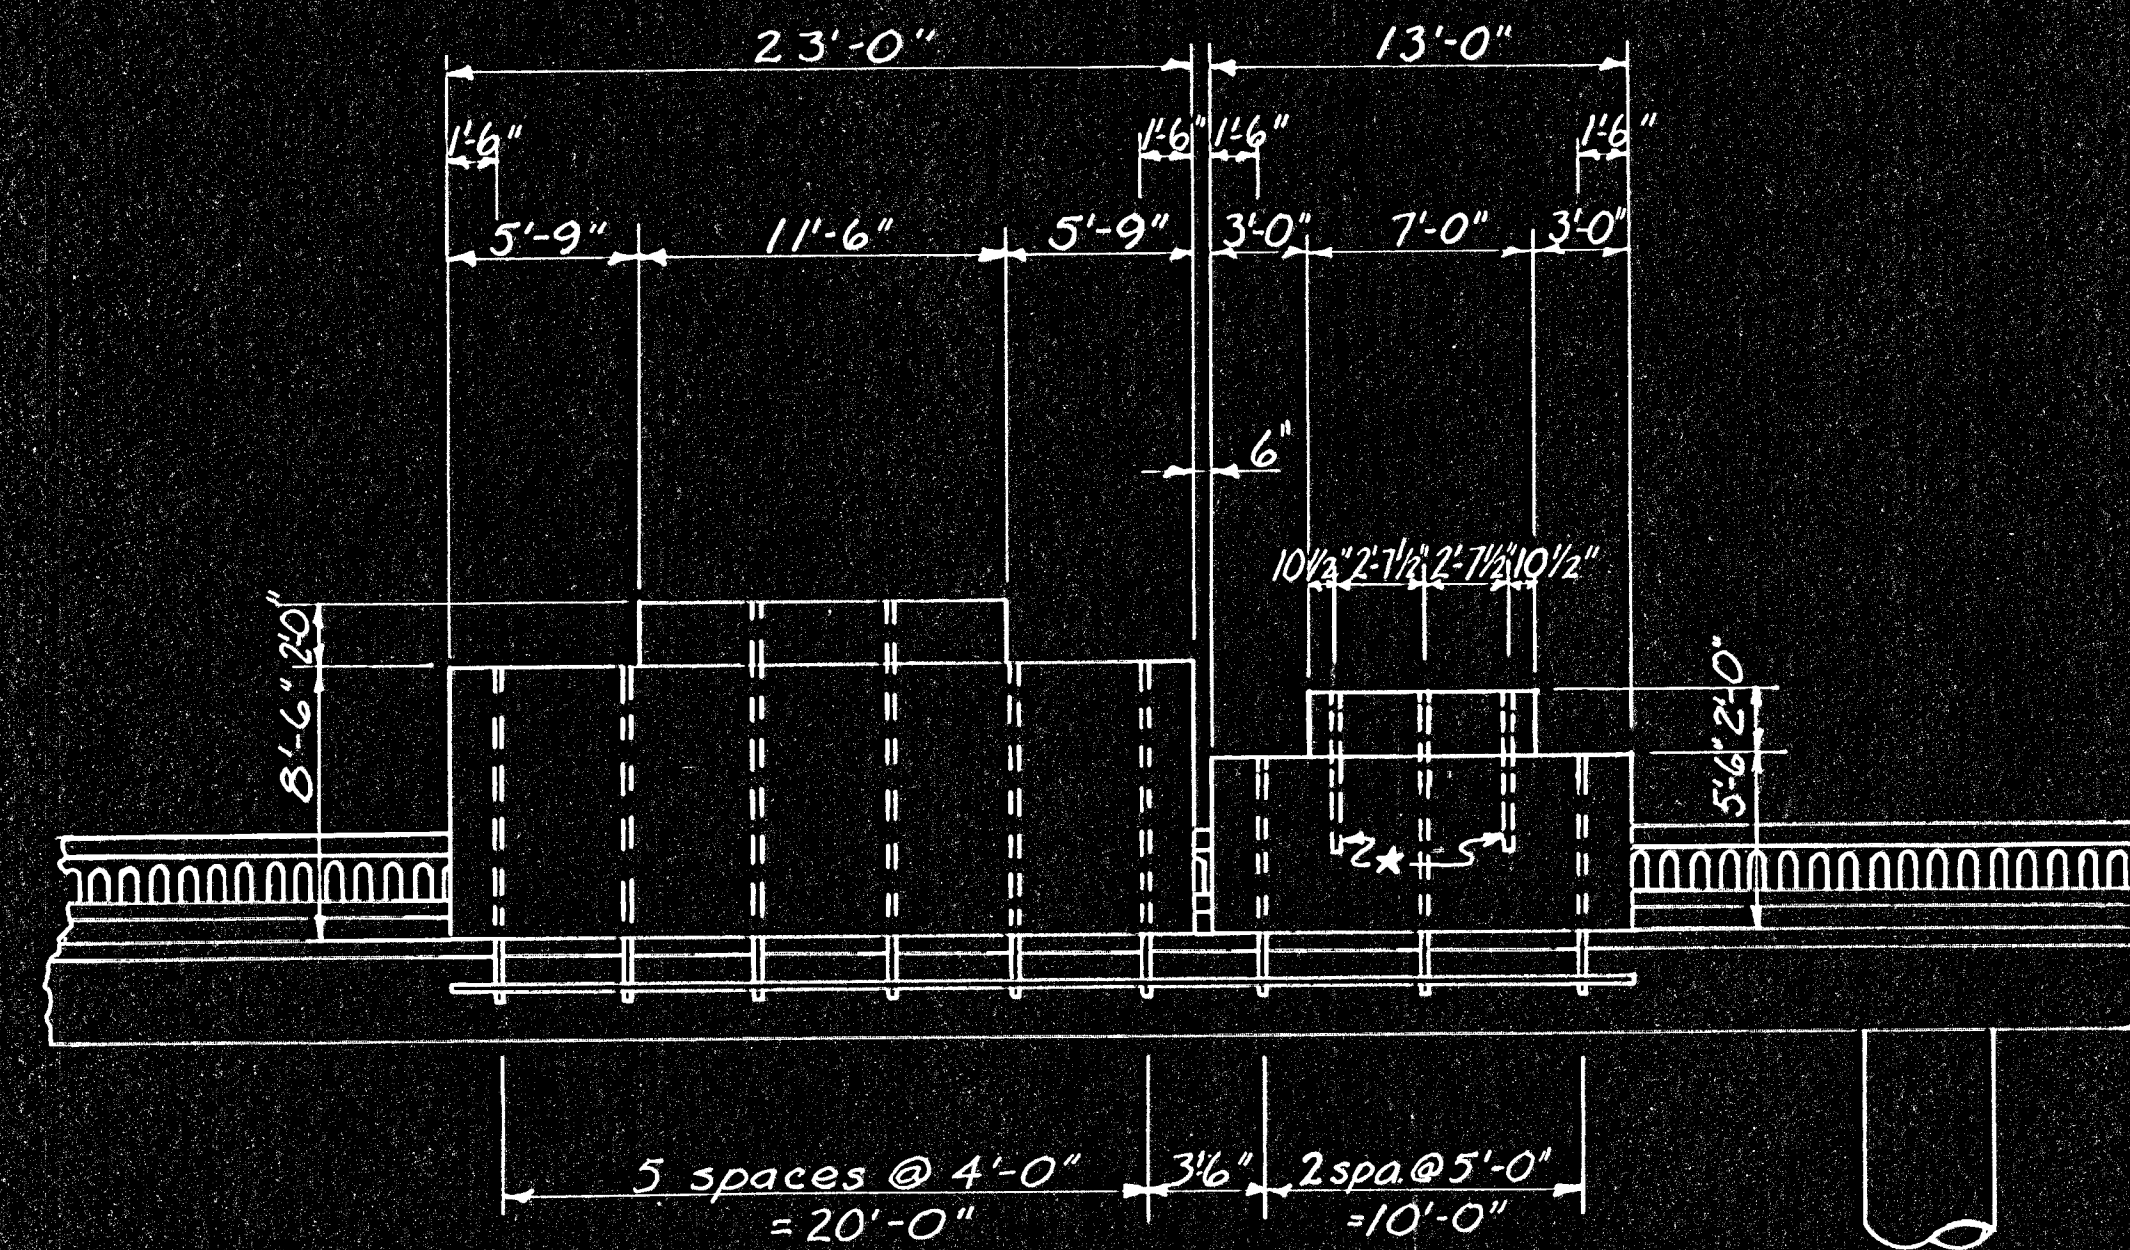

ELEVATION

\*Note: Mount the Exit Number sign with two 3 I 225 x 5'-0" aluminum beams. Refer to the "Mounting of Structural Sign Panel" sheet. These beams shall be included in the linear feet of the bid item "3 I 2.25 Aluminum I-Beam."

Note: Bridge Mounted Sign Attachment shall be grounded by means of #6 A.W.G. insulated copper ground wire carried on structure and down pier in 1/2" conduit. Conduit clamps on 6" centers. See "Sign Lighting Fixtures and Electrical Details" sheet.

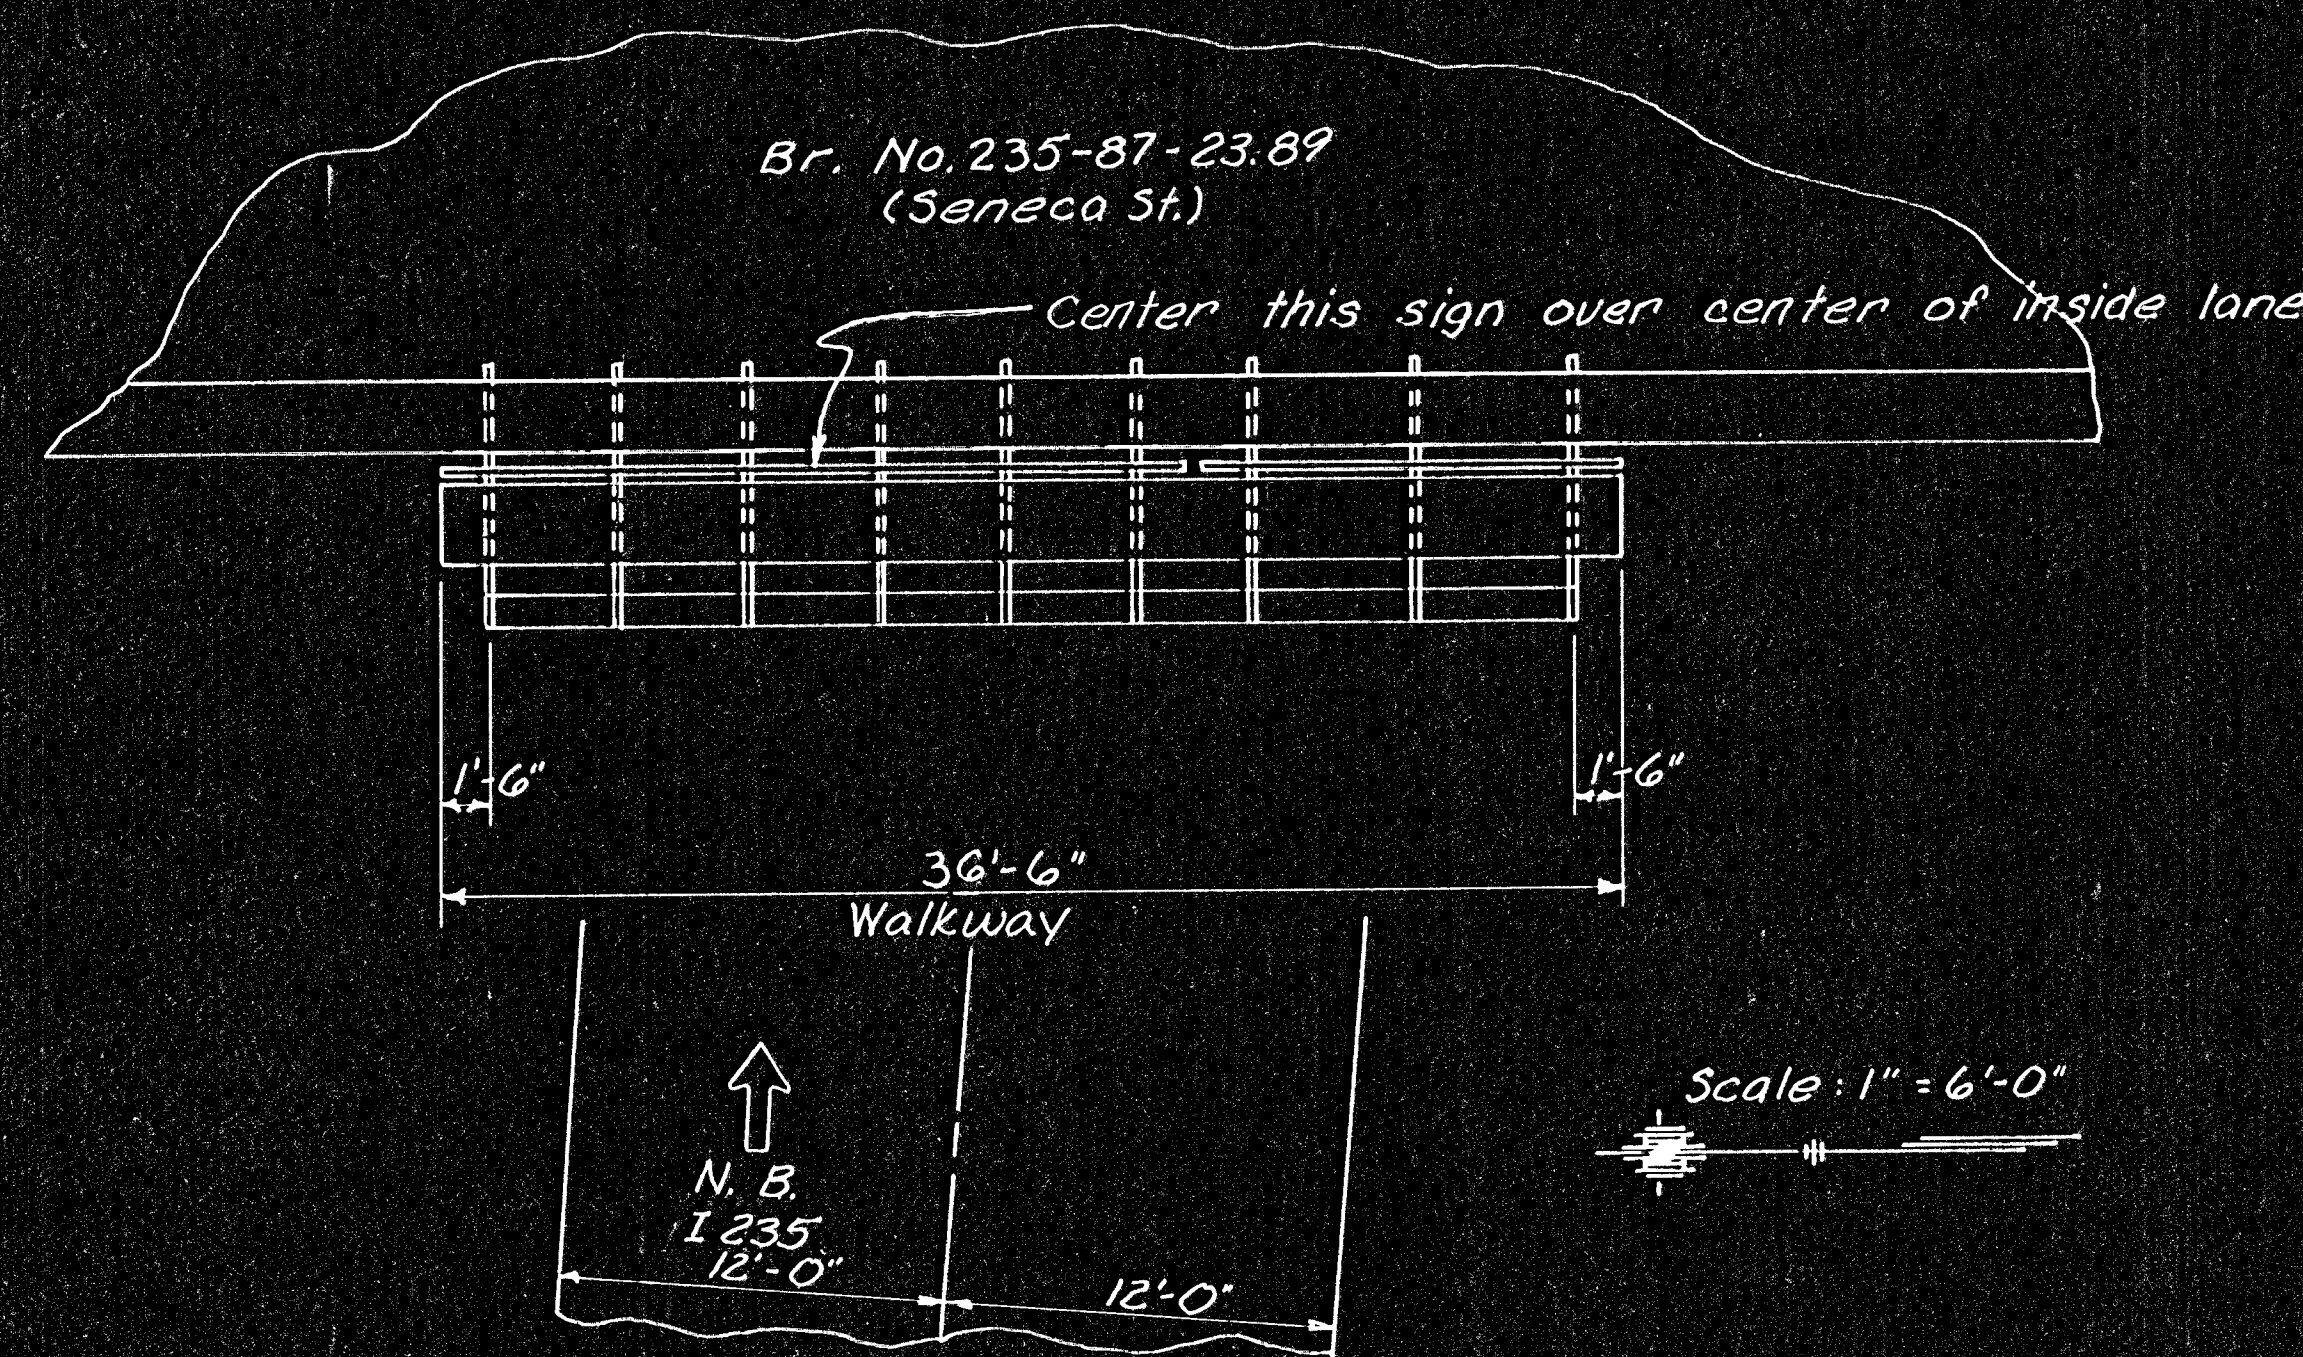

PLAN

Scale: 1" = 6'-0"

|     |      |           |  |  |           |
|-----|------|-----------|--|--|-----------|
| 3   |      |           |  |  |           |
| 2   |      |           |  |  |           |
| 1   |      |           |  |  |           |
| NO. | DATE | REVISIONS |  |  | BY APP'D. |

KANSAS DEPARTMENT OF TRANSPORTATION

N.B. I235 BR. NO. 235-87-2389

CONSTRUCTION LAYOUT  
BRIDGE MOUNTED SIGN ATTACHMENT

PROJ. NO. (BC) 96-87-K044-1(28) SEDGWICK CO.

|                      |        |            |        |            |                  |
|----------------------|--------|------------|--------|------------|------------------|
| SHEET NO. 111 OF 143 |        | SCALE      | APP'D. | QUANTITIES | TRACED           |
| DESIGNED             | L.E.S. | DETAILED   | L.E.S. | QUAN. CK.  | S.A.             |
| DESIGN CK.           | DRE    | DETAIL CK. | DRE    |            | TRACE CK. L.E.S. |