


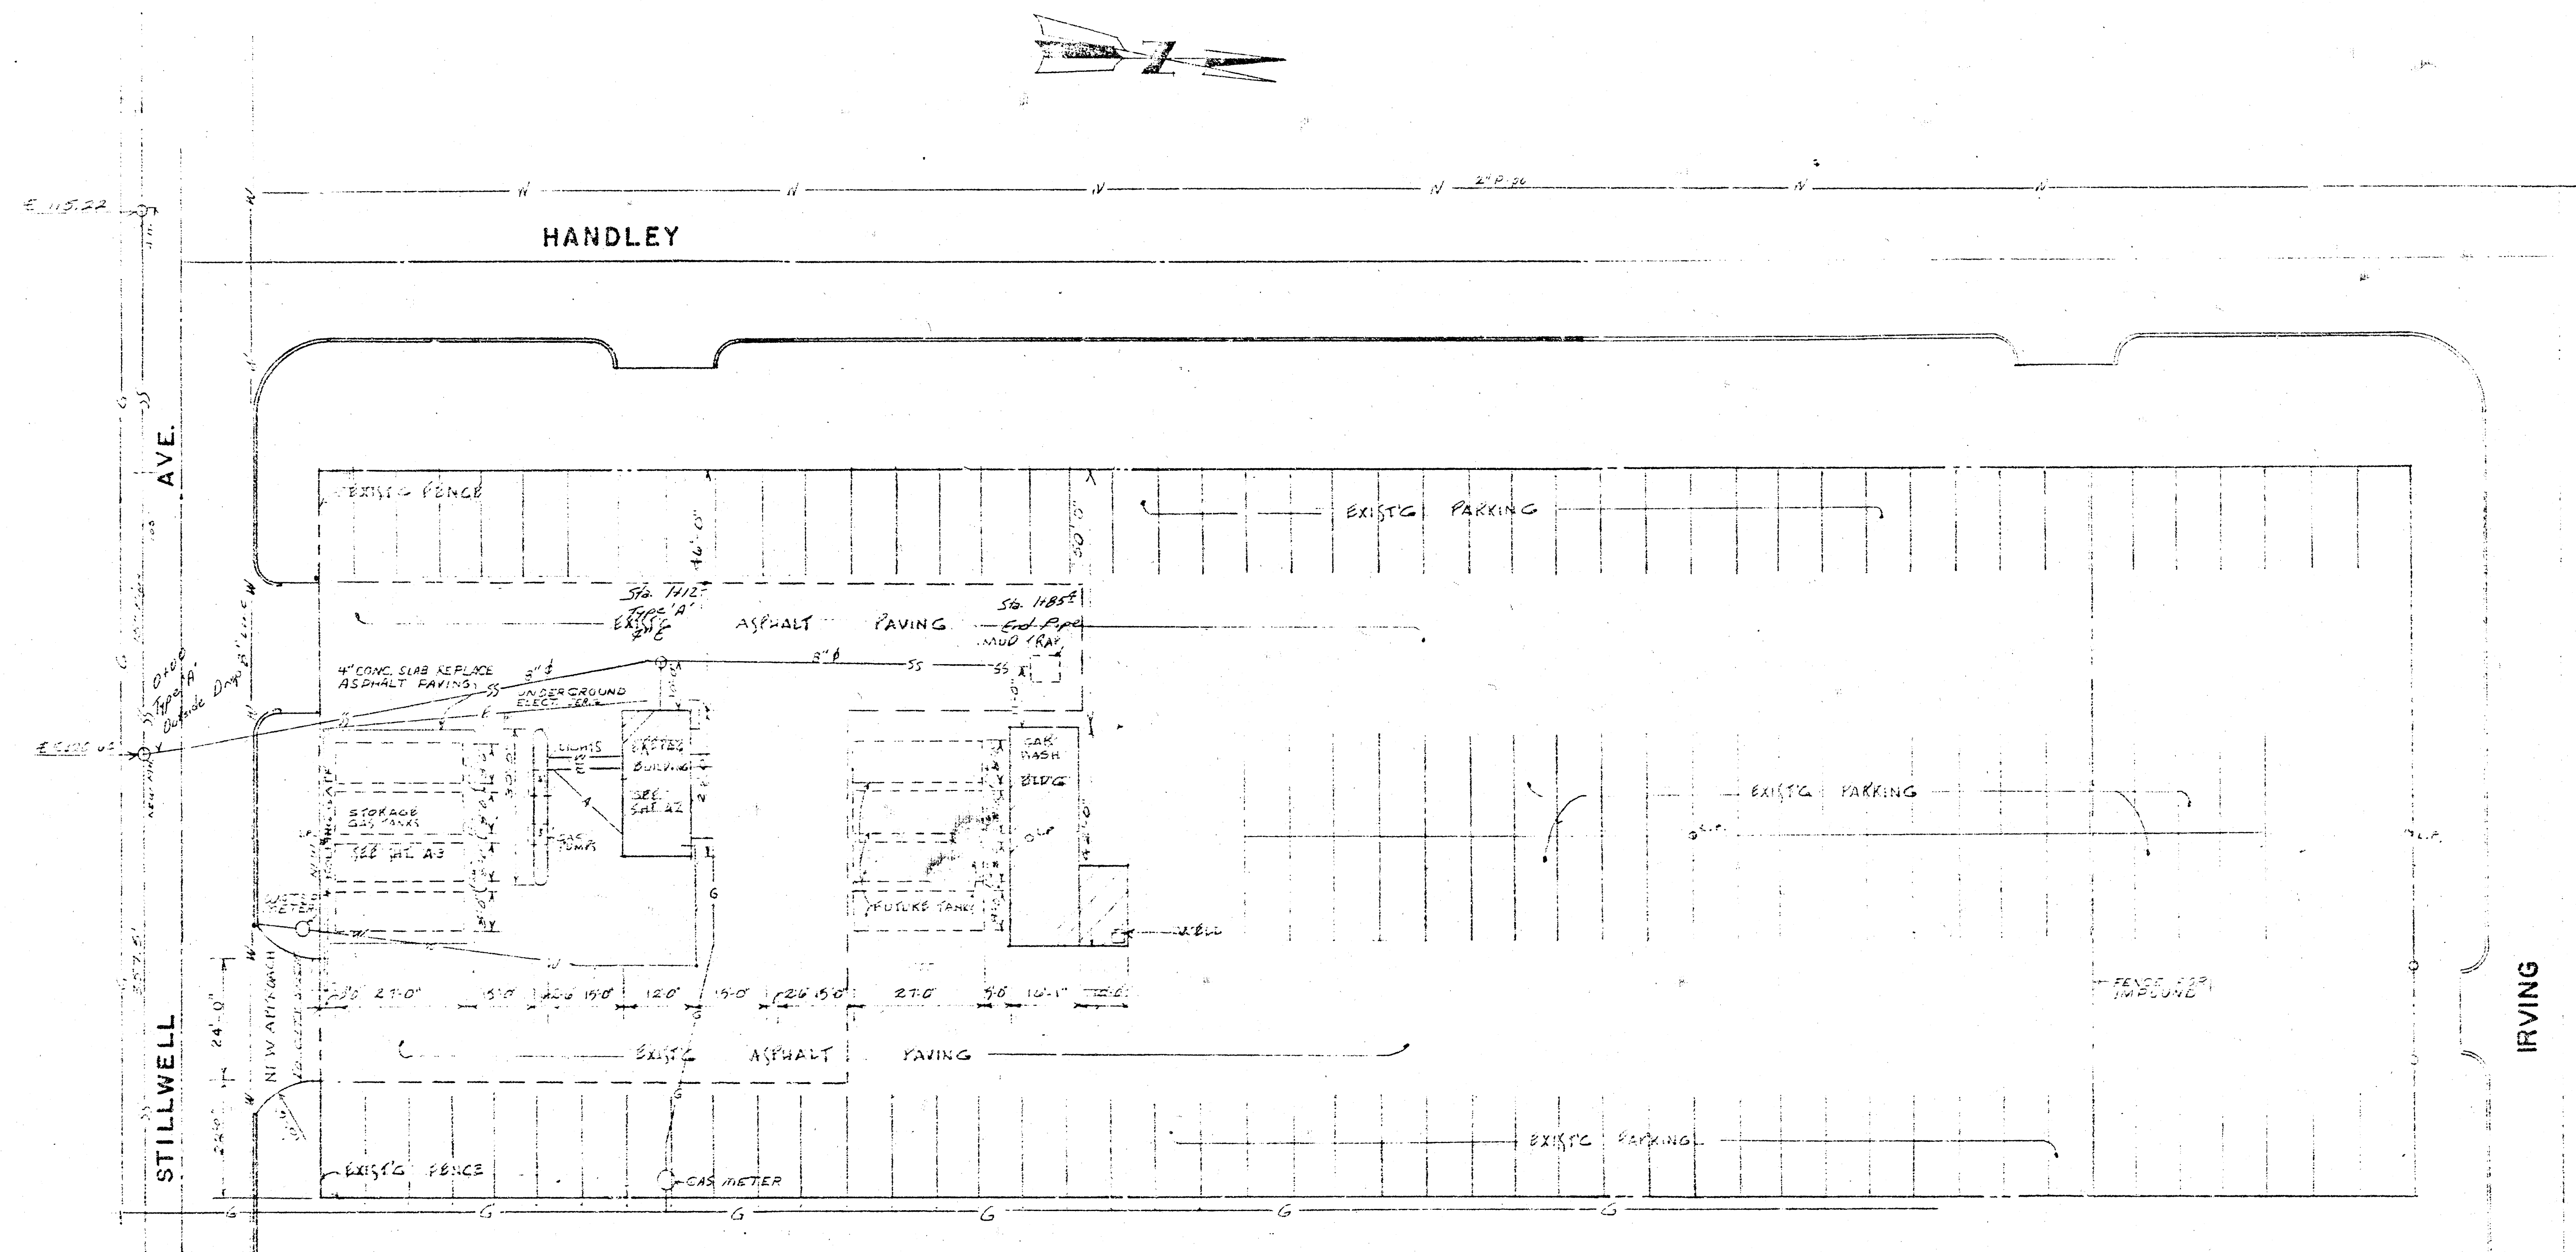

NOTE TO CONTRACTOR
 This project will be constructed under the supervision of the CITY ENGINEER and conforming to the SPECIFICATIONS of the CITY OF WICHITA. The CONTRACTOR will be responsible for all costs of inspection.


8-31-77

APPROVED AS NOTED
 By CITY ENGINEER OF WICHITA
 Sanitary Sewers *PCT*
 Storm Sewers _____
 Driveway Approaches _____

SITE PLAN
 SCALE 20' 0" = 1"

LOCAL PROJECT ON
 LOTS 20-1 & 20-2 OF LOT 24
 FRANKLIN TRACT ADDITION
 WICHITA, KANSAS

GENERAL NOTE:
 INSTALL 208 V. SINGLE PHASE CONTROL CIRCUIT & POWER CIRCUIT FOR 2 HP SUBMERSIBLE PUMP AS REQUIRED BY PUMP MANUFACTURER.

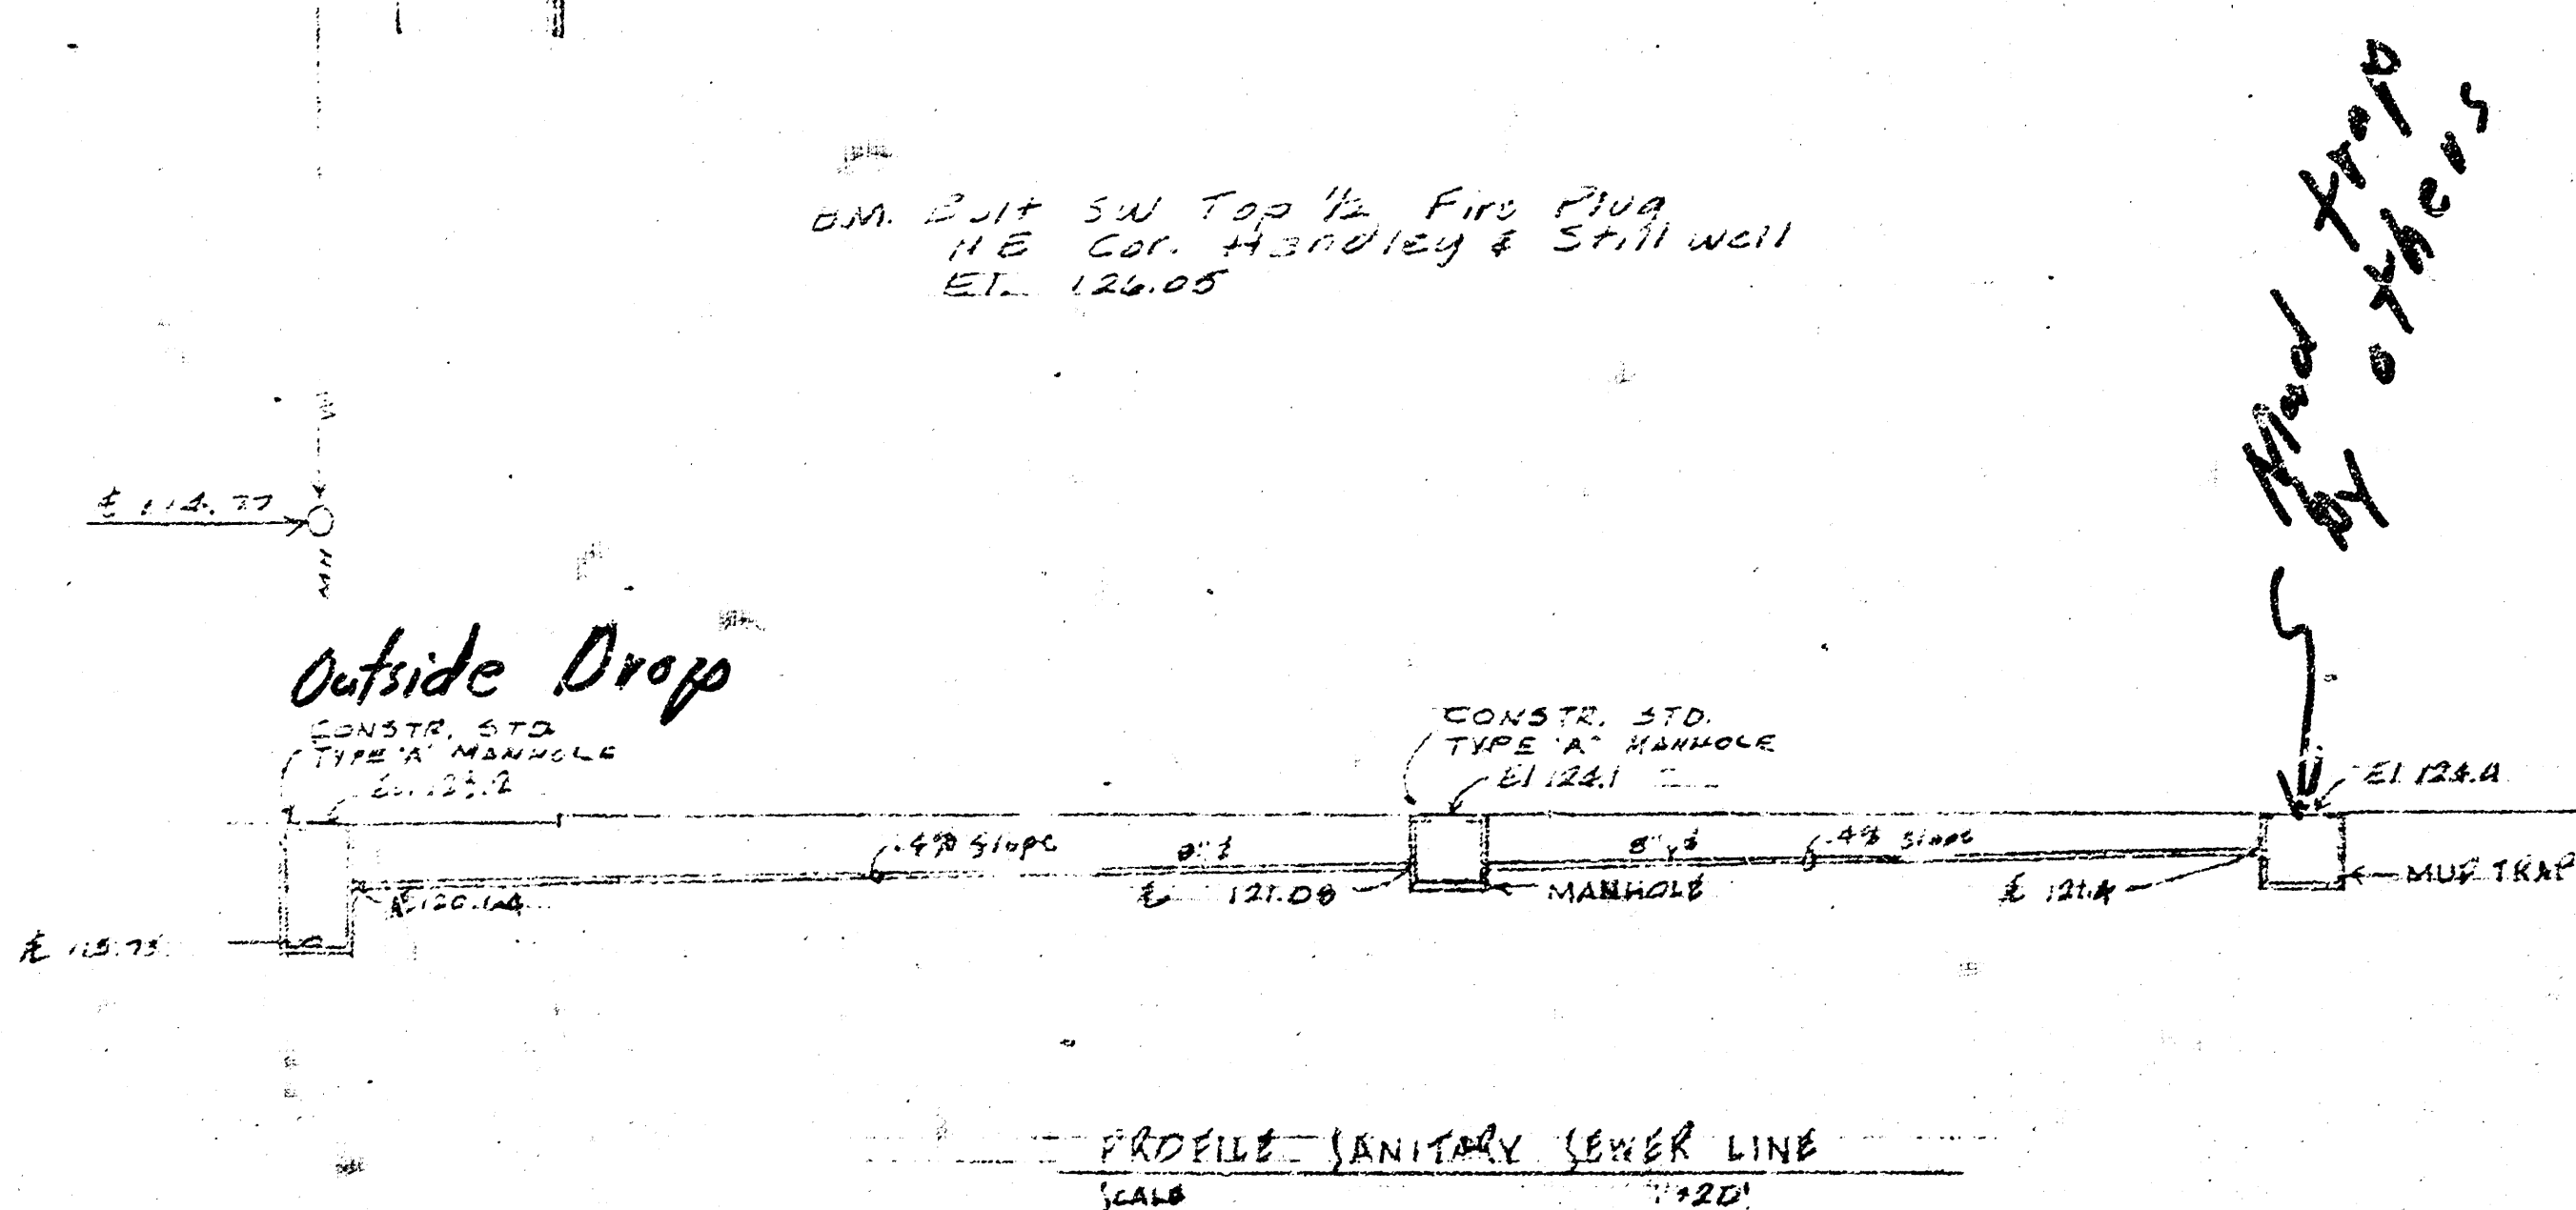

As Bldg. Permitted
E.I.R. REG-1
SERVICE STATION AND CAR WASH FACILITY
 808-76-288-20089-000-000-008
 PREPARED BY
SEDGWICK COUNTY DEPARTMENT OF PUBLIC WORKS

REVISED	SCALE	DESIGNED	TRACED	CHECKED	SHEET NO.
	AS NOTED	GCM, LUKS	N.J. GRAMM		Δ-1
	DATE				
	PLANFILE		TOTAL SHEETS		