
 
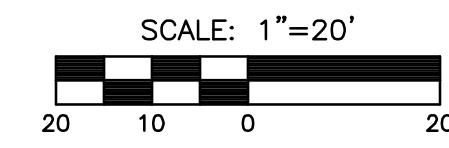



**PAVING & INCIDENTAL DRAINAGE PLANS FOR  
FOLIAGE CENTER ADDITION  
13th STREET LEFT TURN LANES**

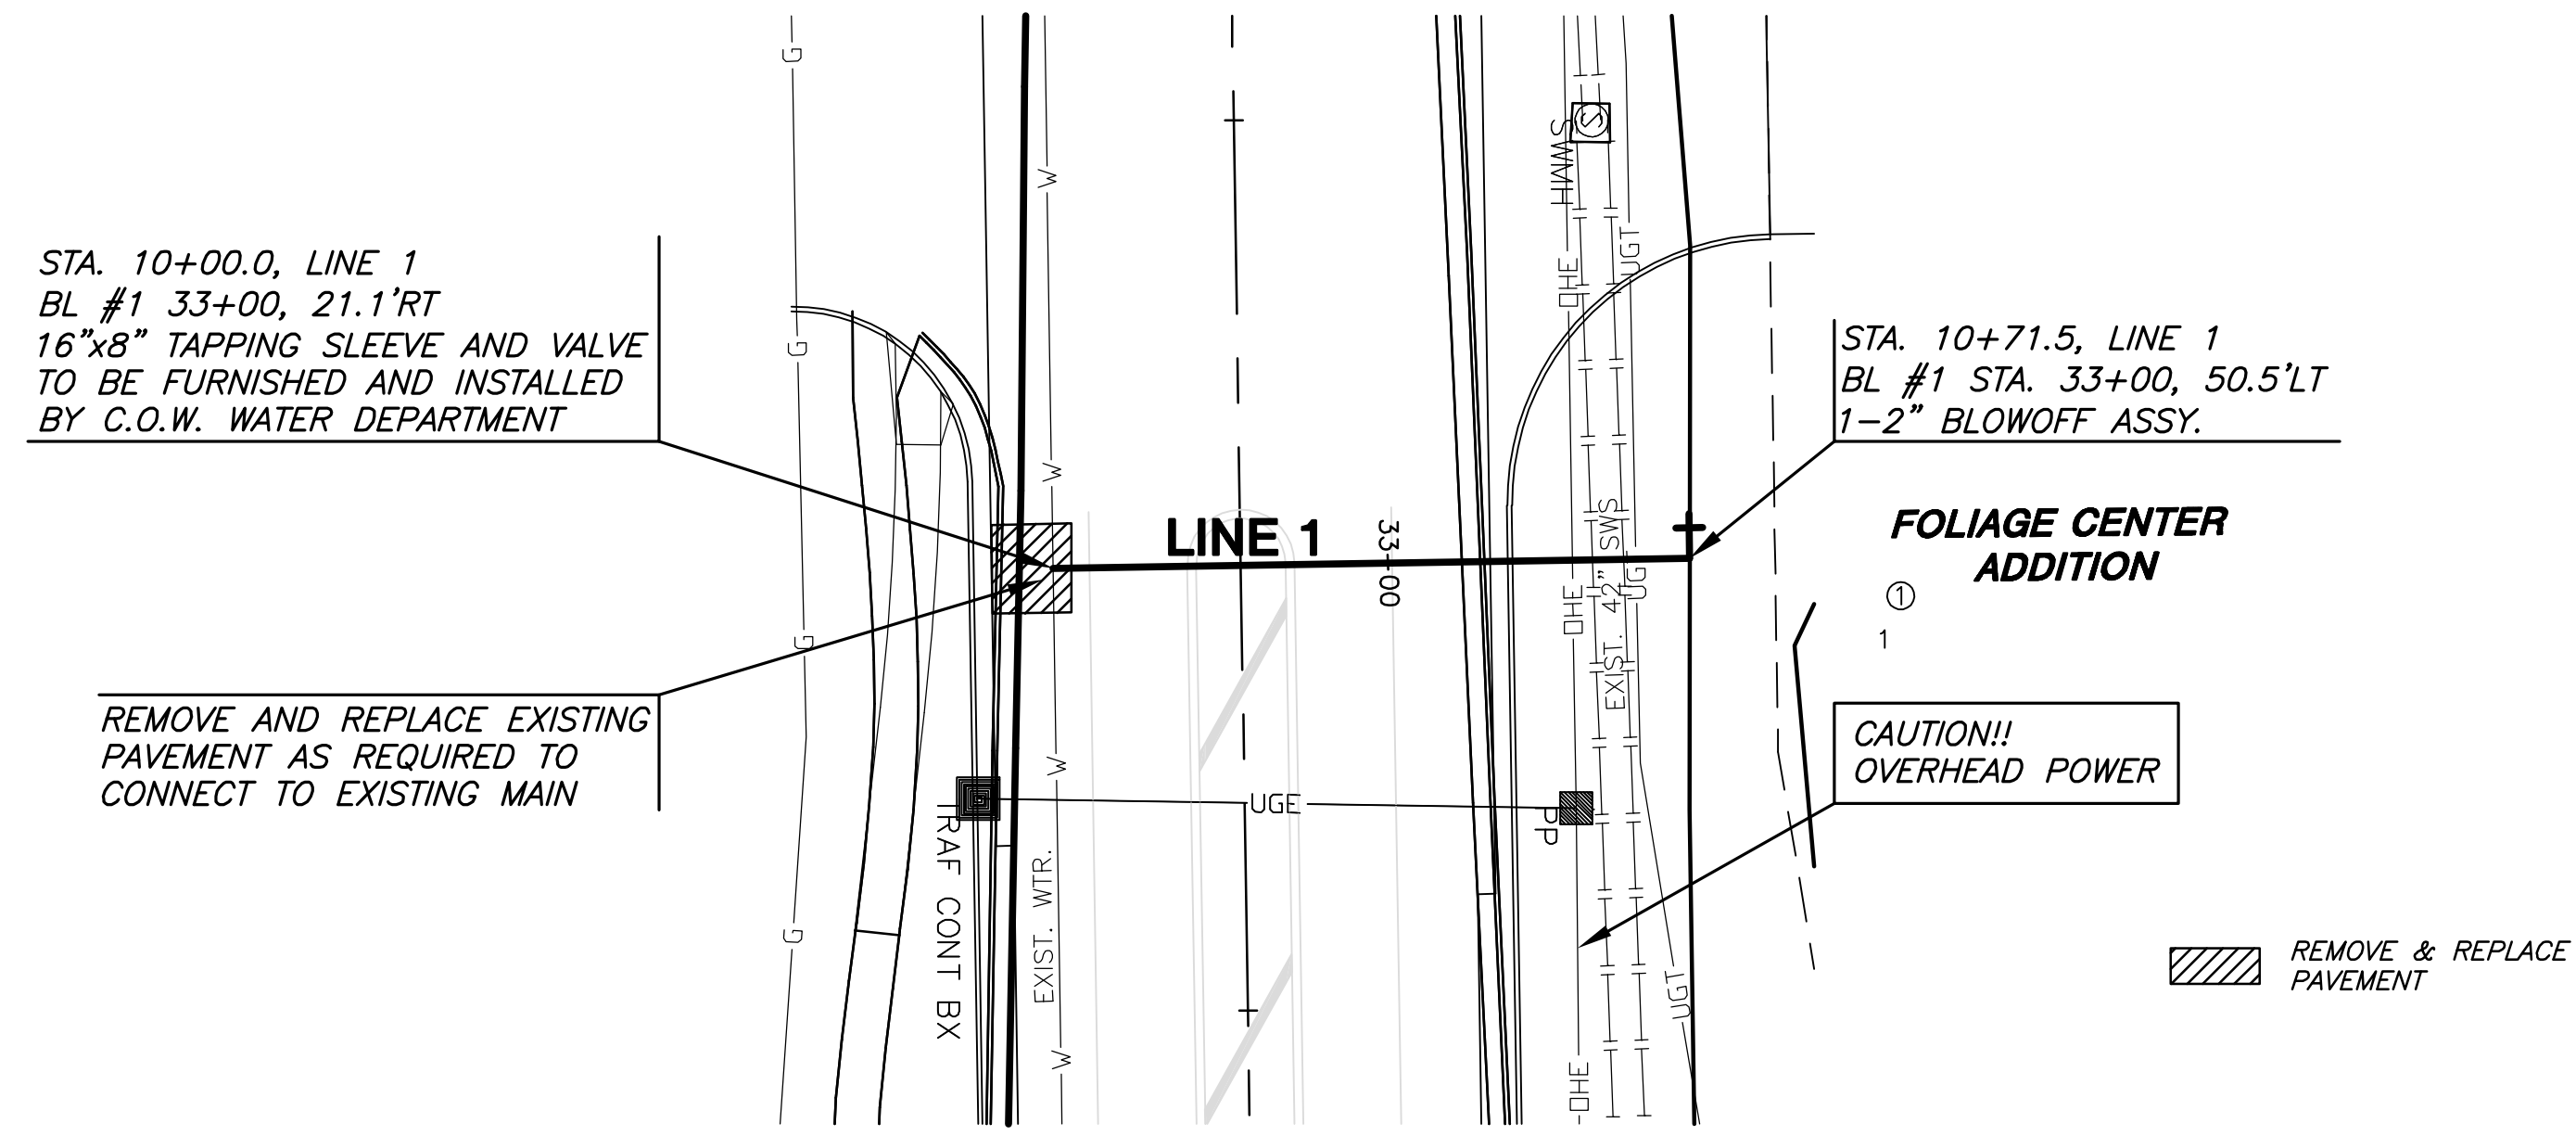

**WATER PLAN LINE 1**

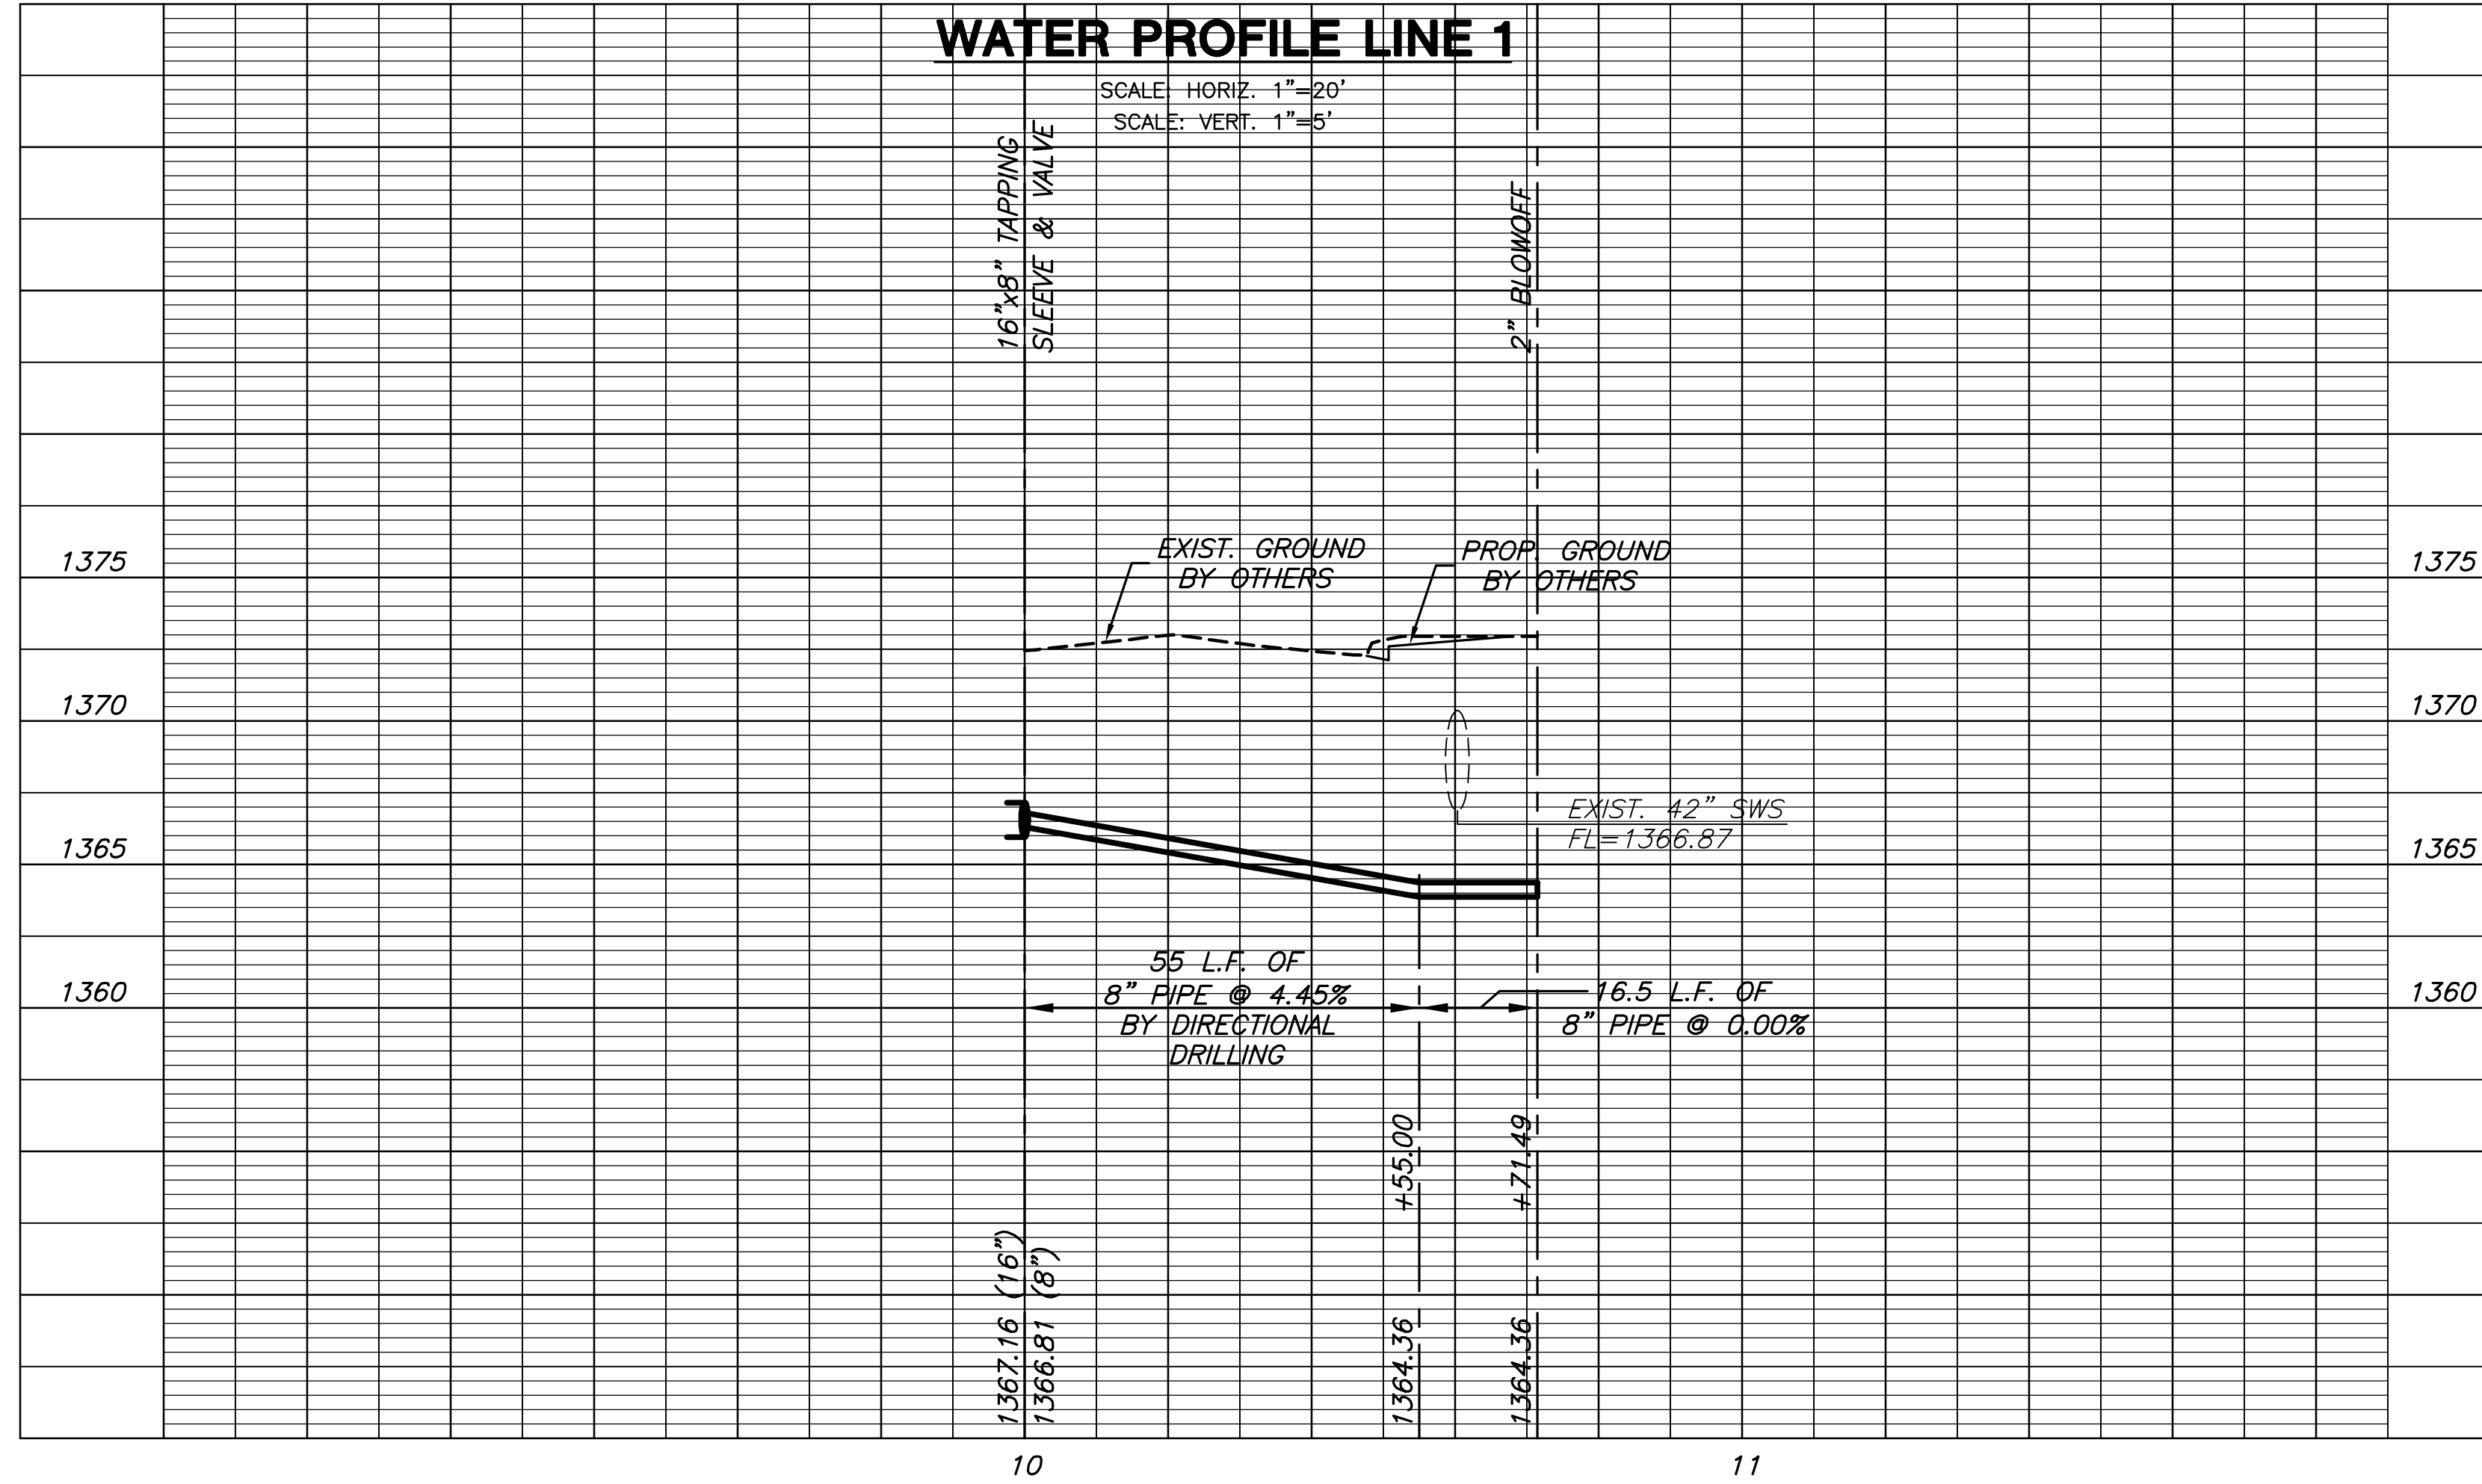

**WATER LINE 1**  
SHEET TITLE  
04274  
PROJECT NUMBER

DESIGN BY: SRS  
DRAWN BY: TKL  
CHECKED BY: DFL

ISSUED: June 2008  
REVISED:

SHEET NO.  
7 of 23