

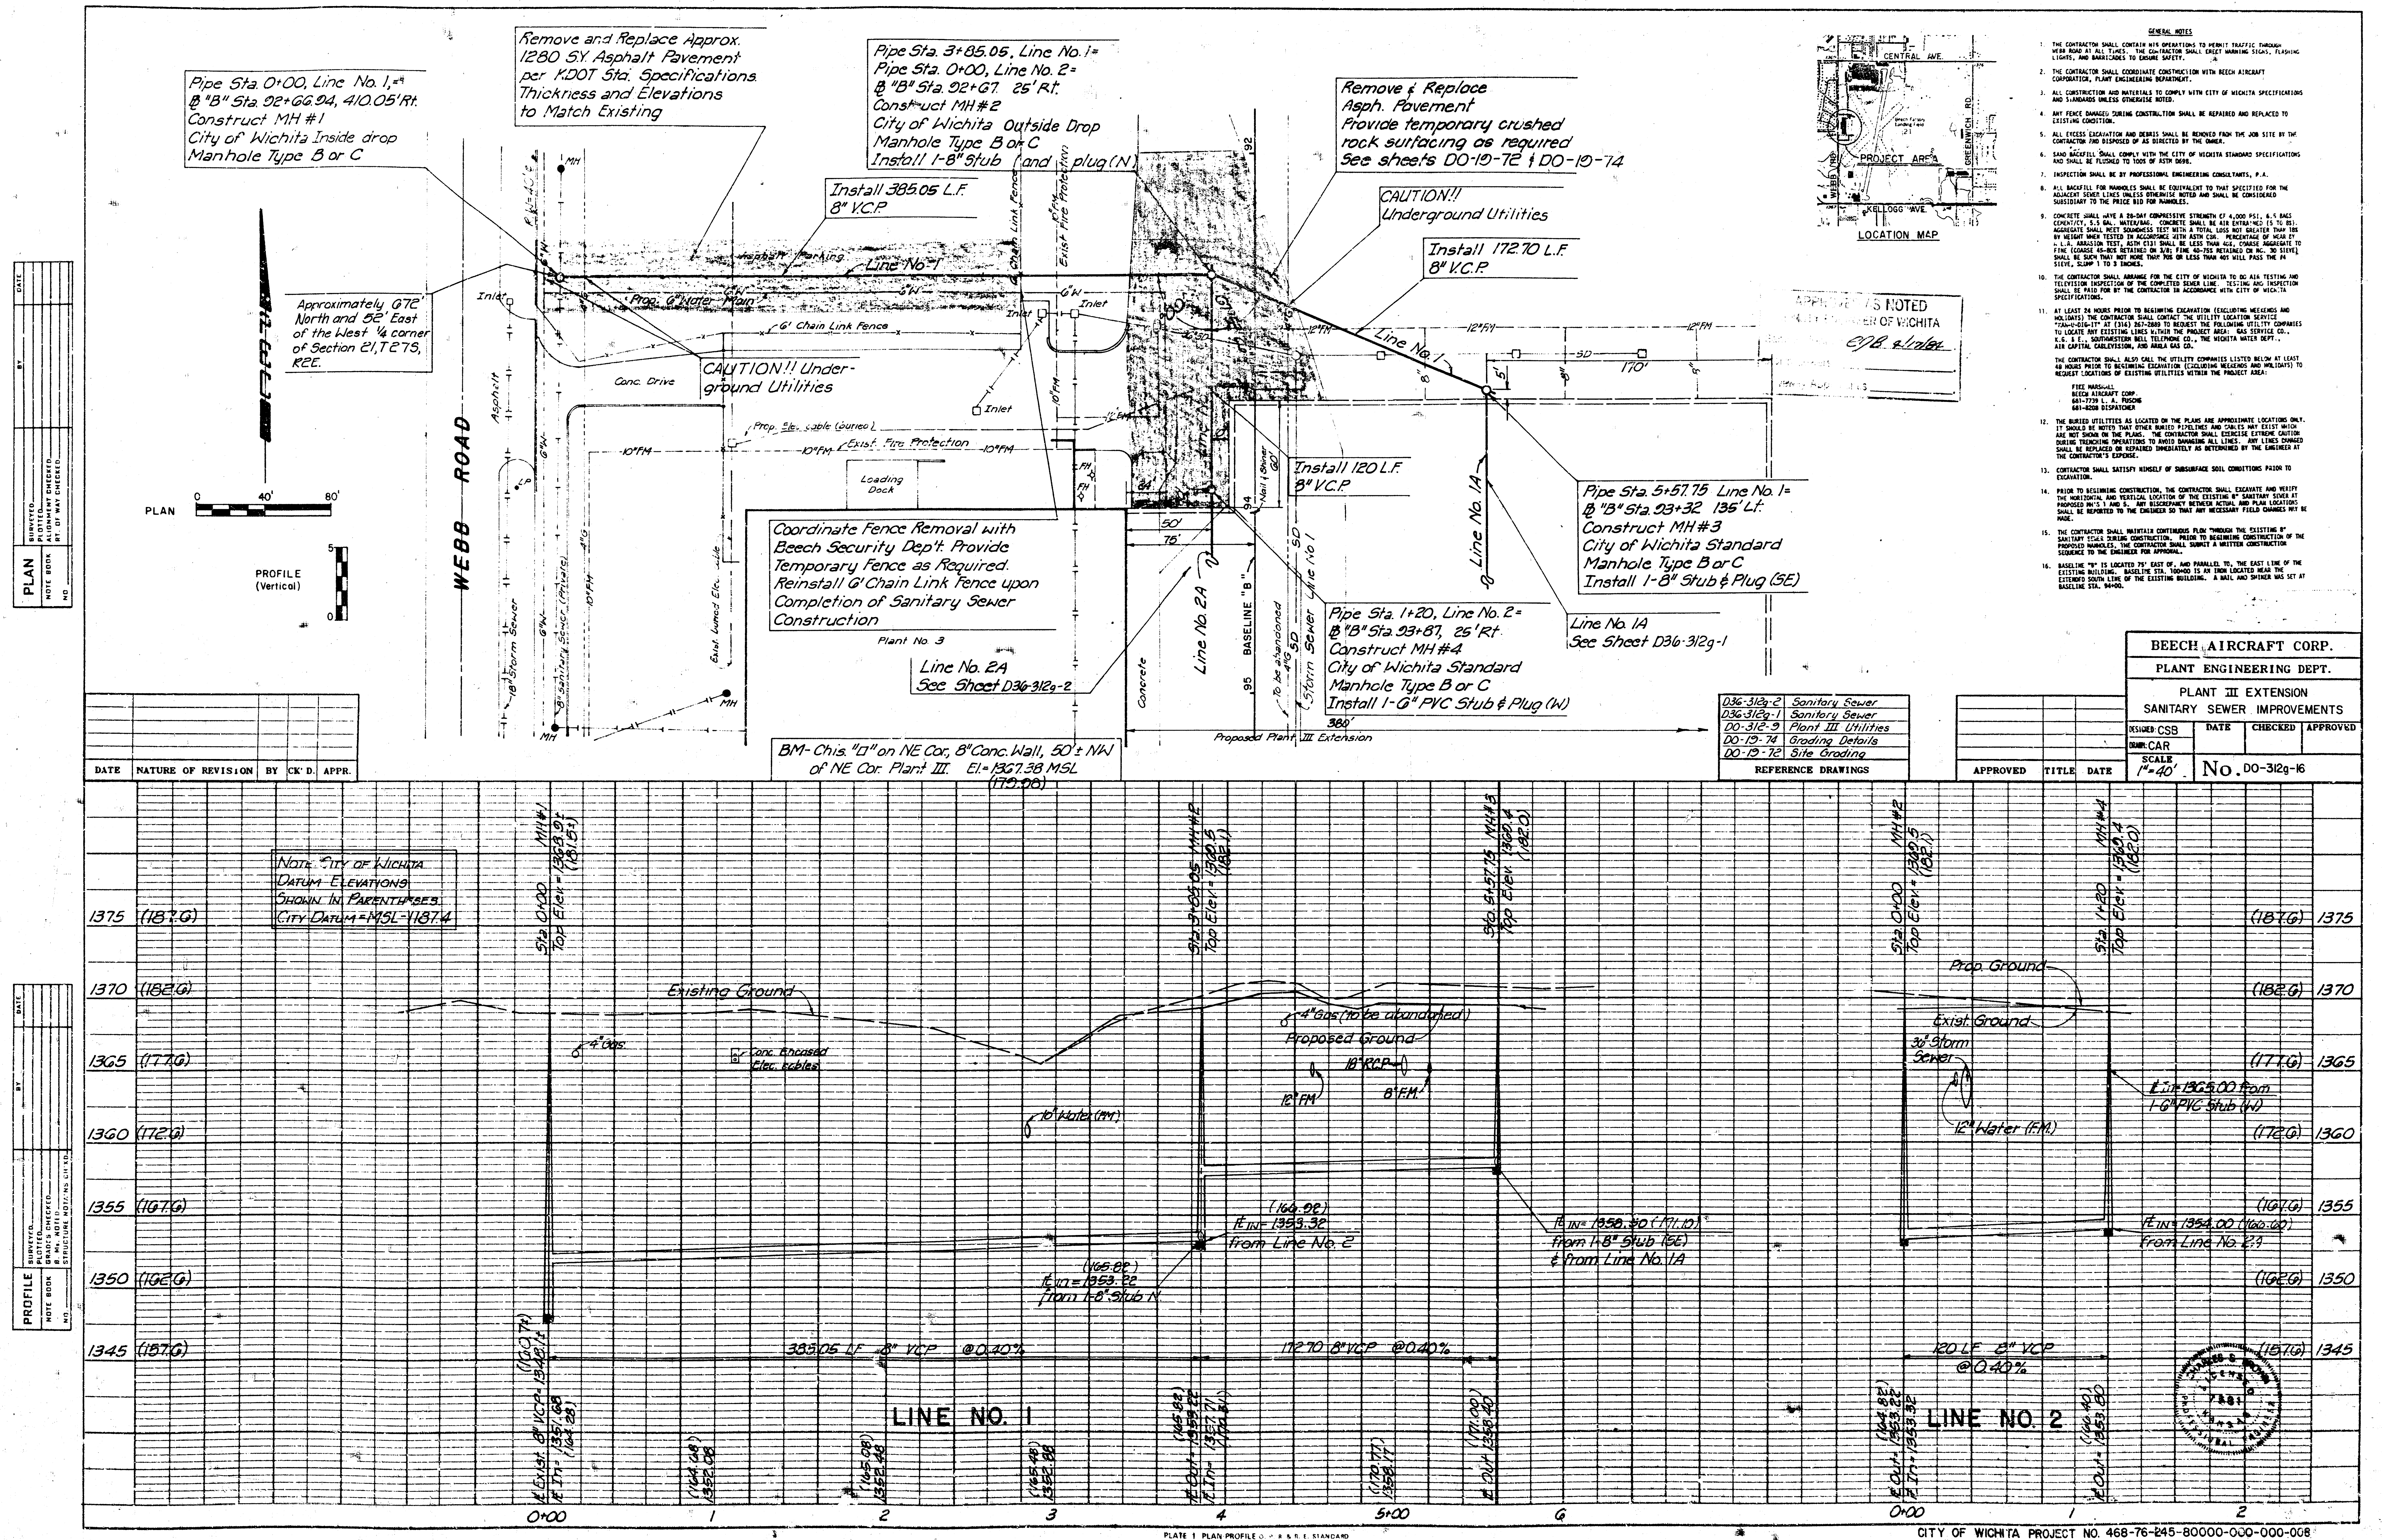


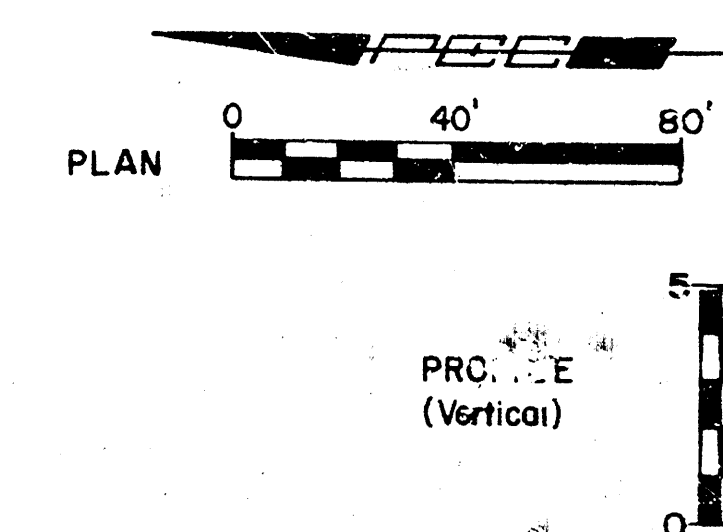

PLAN	DATE	
	BY	
	NO. OF SHEETS	
	NO. OF SHEETS	

PROFILE	DATE	
	BY	
	NO. OF SHEETS	
	NO. OF SHEETS	

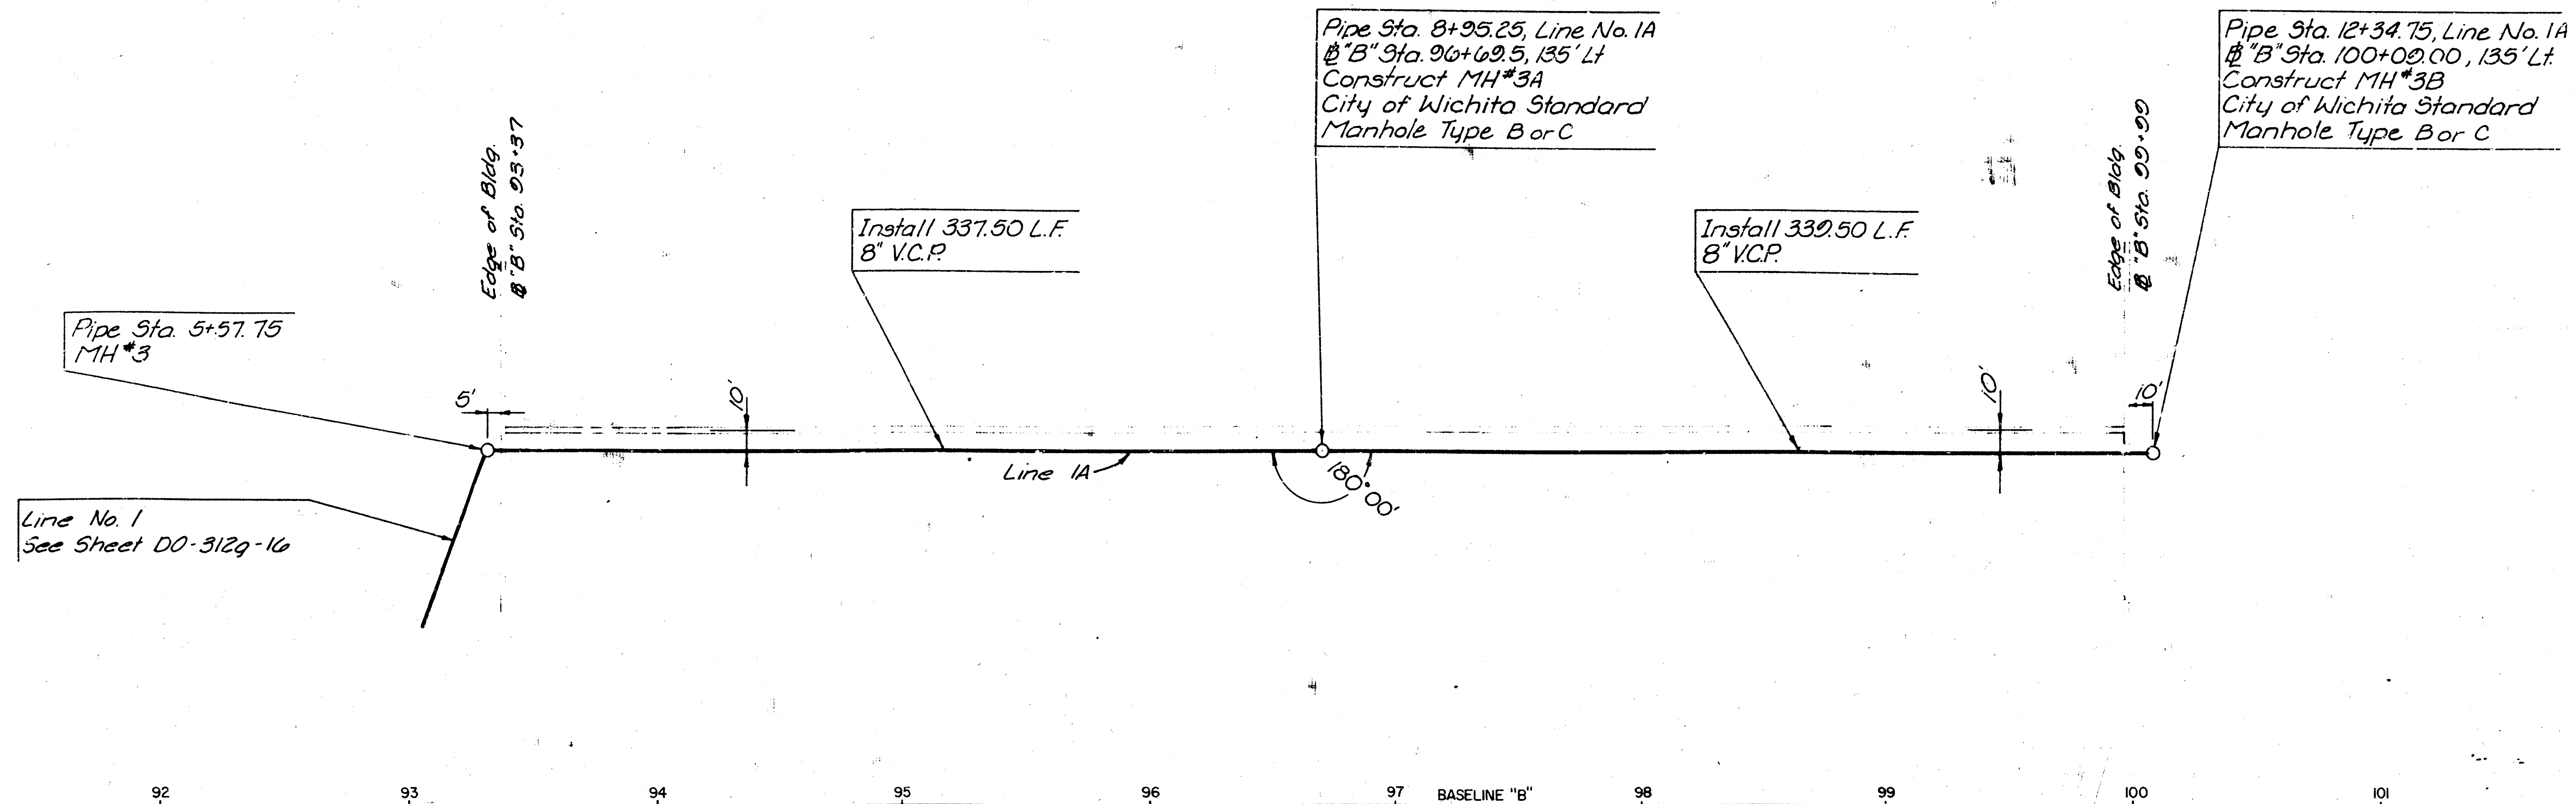




DATE	NATURE OF REVISION	BY	CHK'D	APPR.

DO-312-5	Plant III Utilities
DO-312-16	Sanitary Sewer

APPROVED	TITLE	DATE

BEECH AIRCRAFT CORP.			
PLANT ENGINEERING DEPT.			
PLANT III EXTENSION			
SANITARY SEWER IMPROVEMENTS			
DRAWN	DATE	CHECKED	APPROVED
SCALE	No. D36-312g-3		

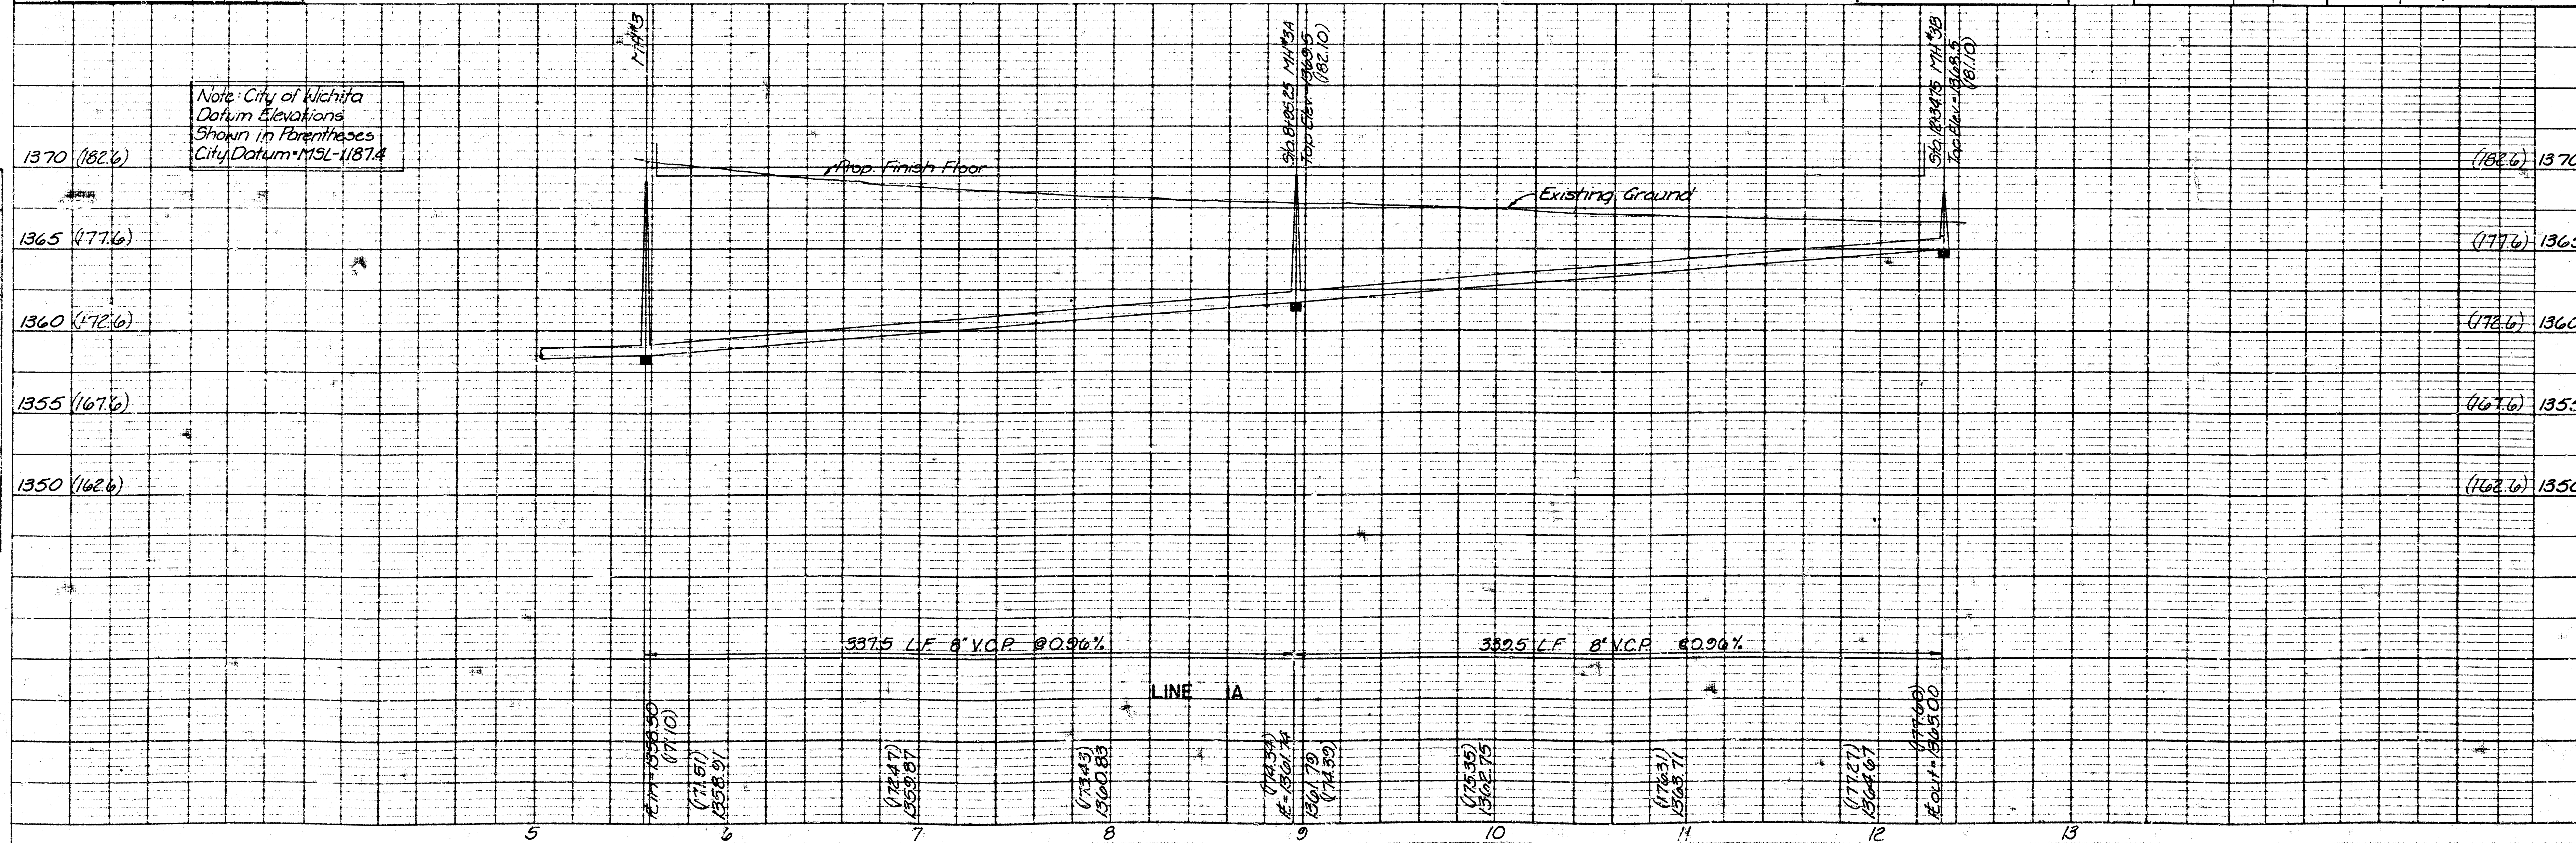

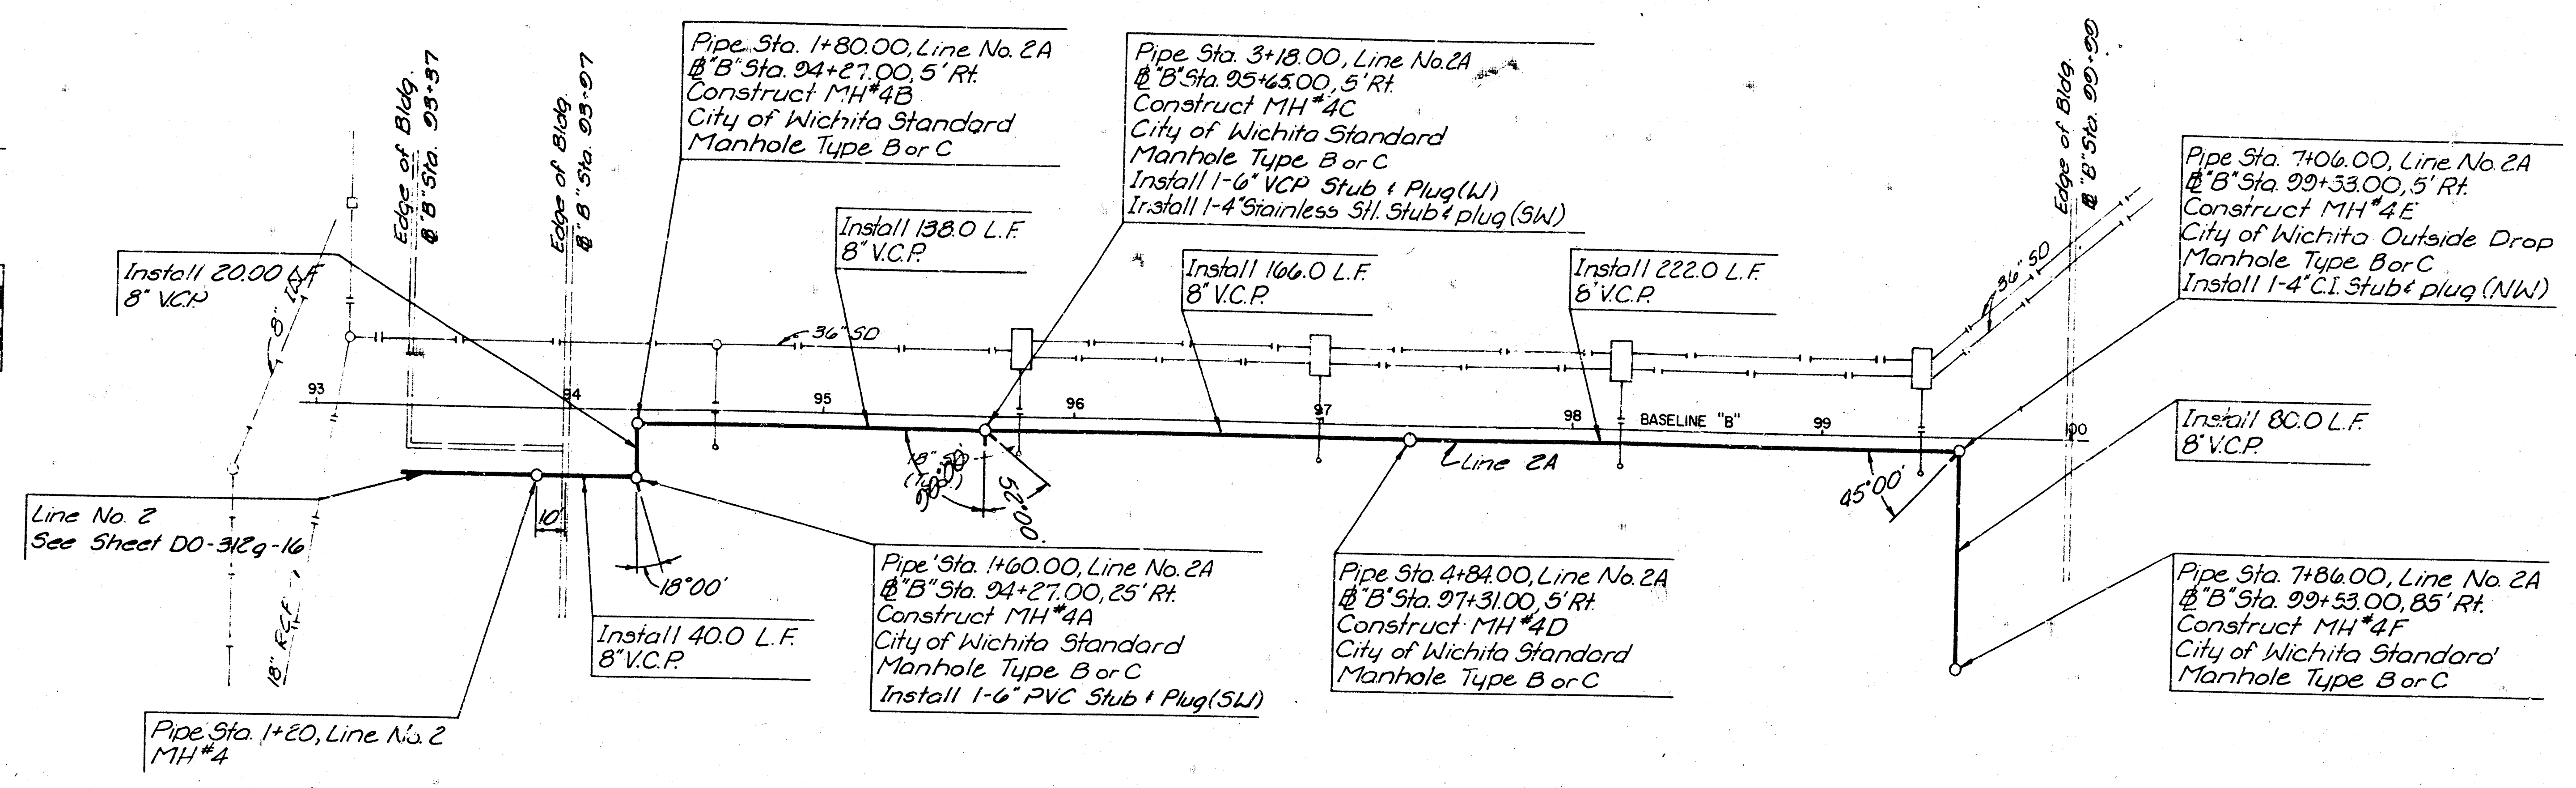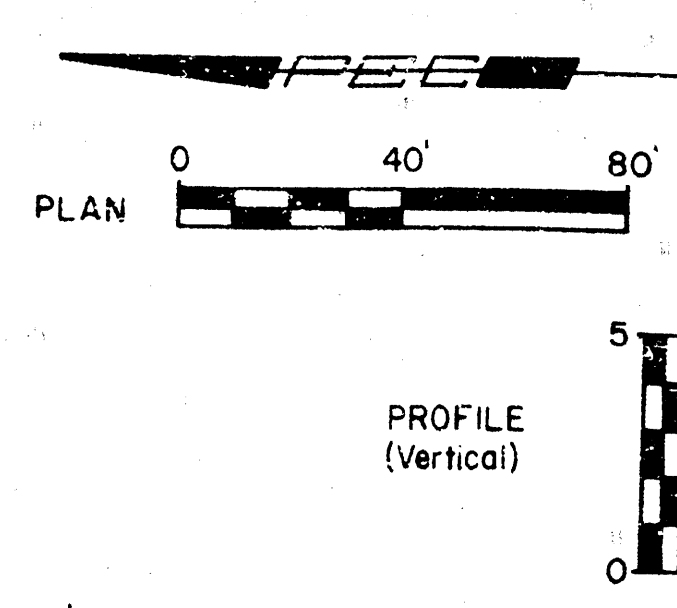

DATE	NATURE OF REVISION	BY	CK'D.	APPR.

BEECH AIRCRAFT CORP.			
PLANT ENGINEERING DEPT.			
PLANT III EXTENSION			
SANITARY SEWER IMPROVEMENTS			
DESIGNED BY	DATE	CHECKED	APPROVED
DRAWN BY			
SCALE	No. 036-3129-2		


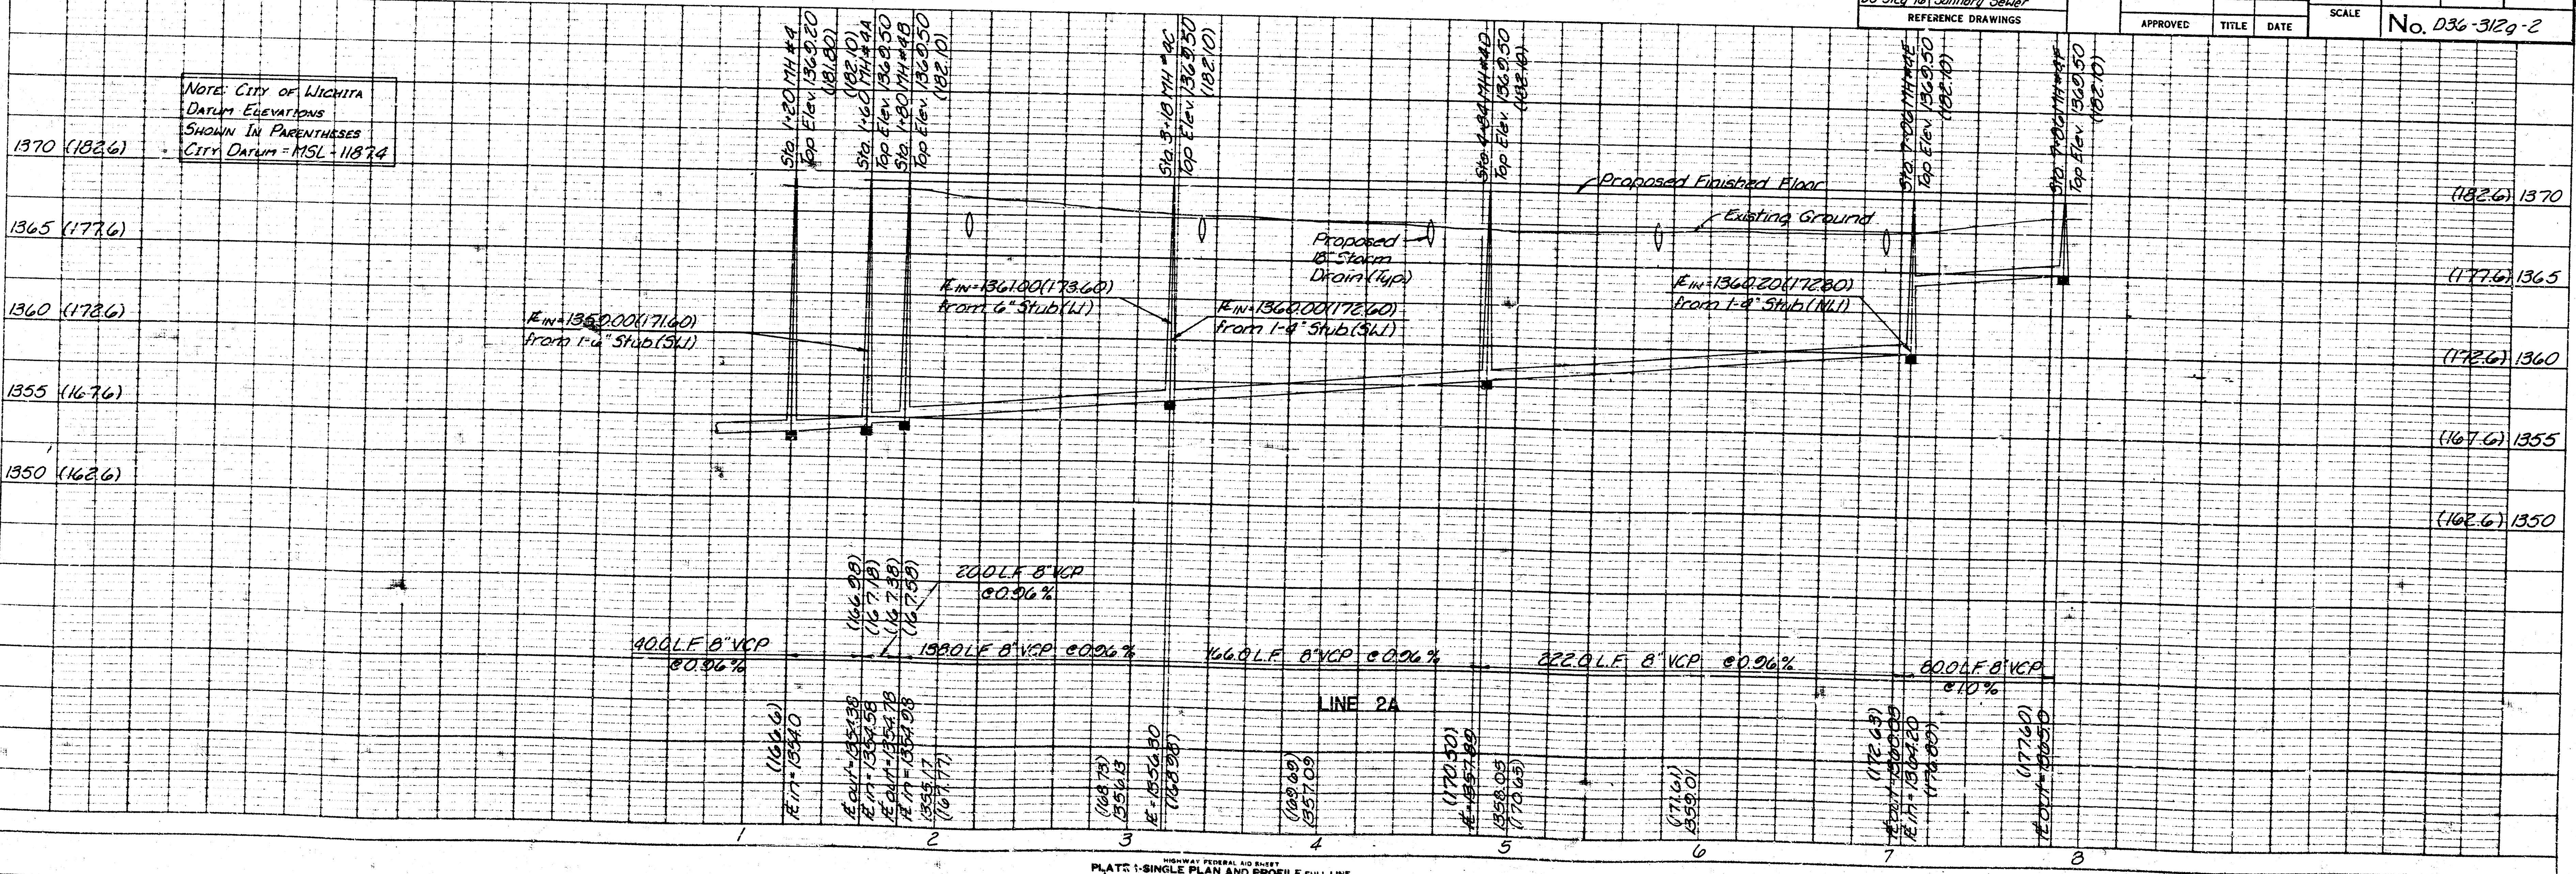


PLATE 1-SINGLE PLAN AND PROFILE-FULL LINE
PRINTED IN U.S.A.

PLAN	DATE
PROJECT NO.	
PROJECT NAME	
DATE	
BY	
CHECKED	
BY	
CHECKED	

PROFILE	DATE
PROJECT NO.	
PROJECT NAME	
DATE	
BY	
CHECKED	
BY	
CHECKED	

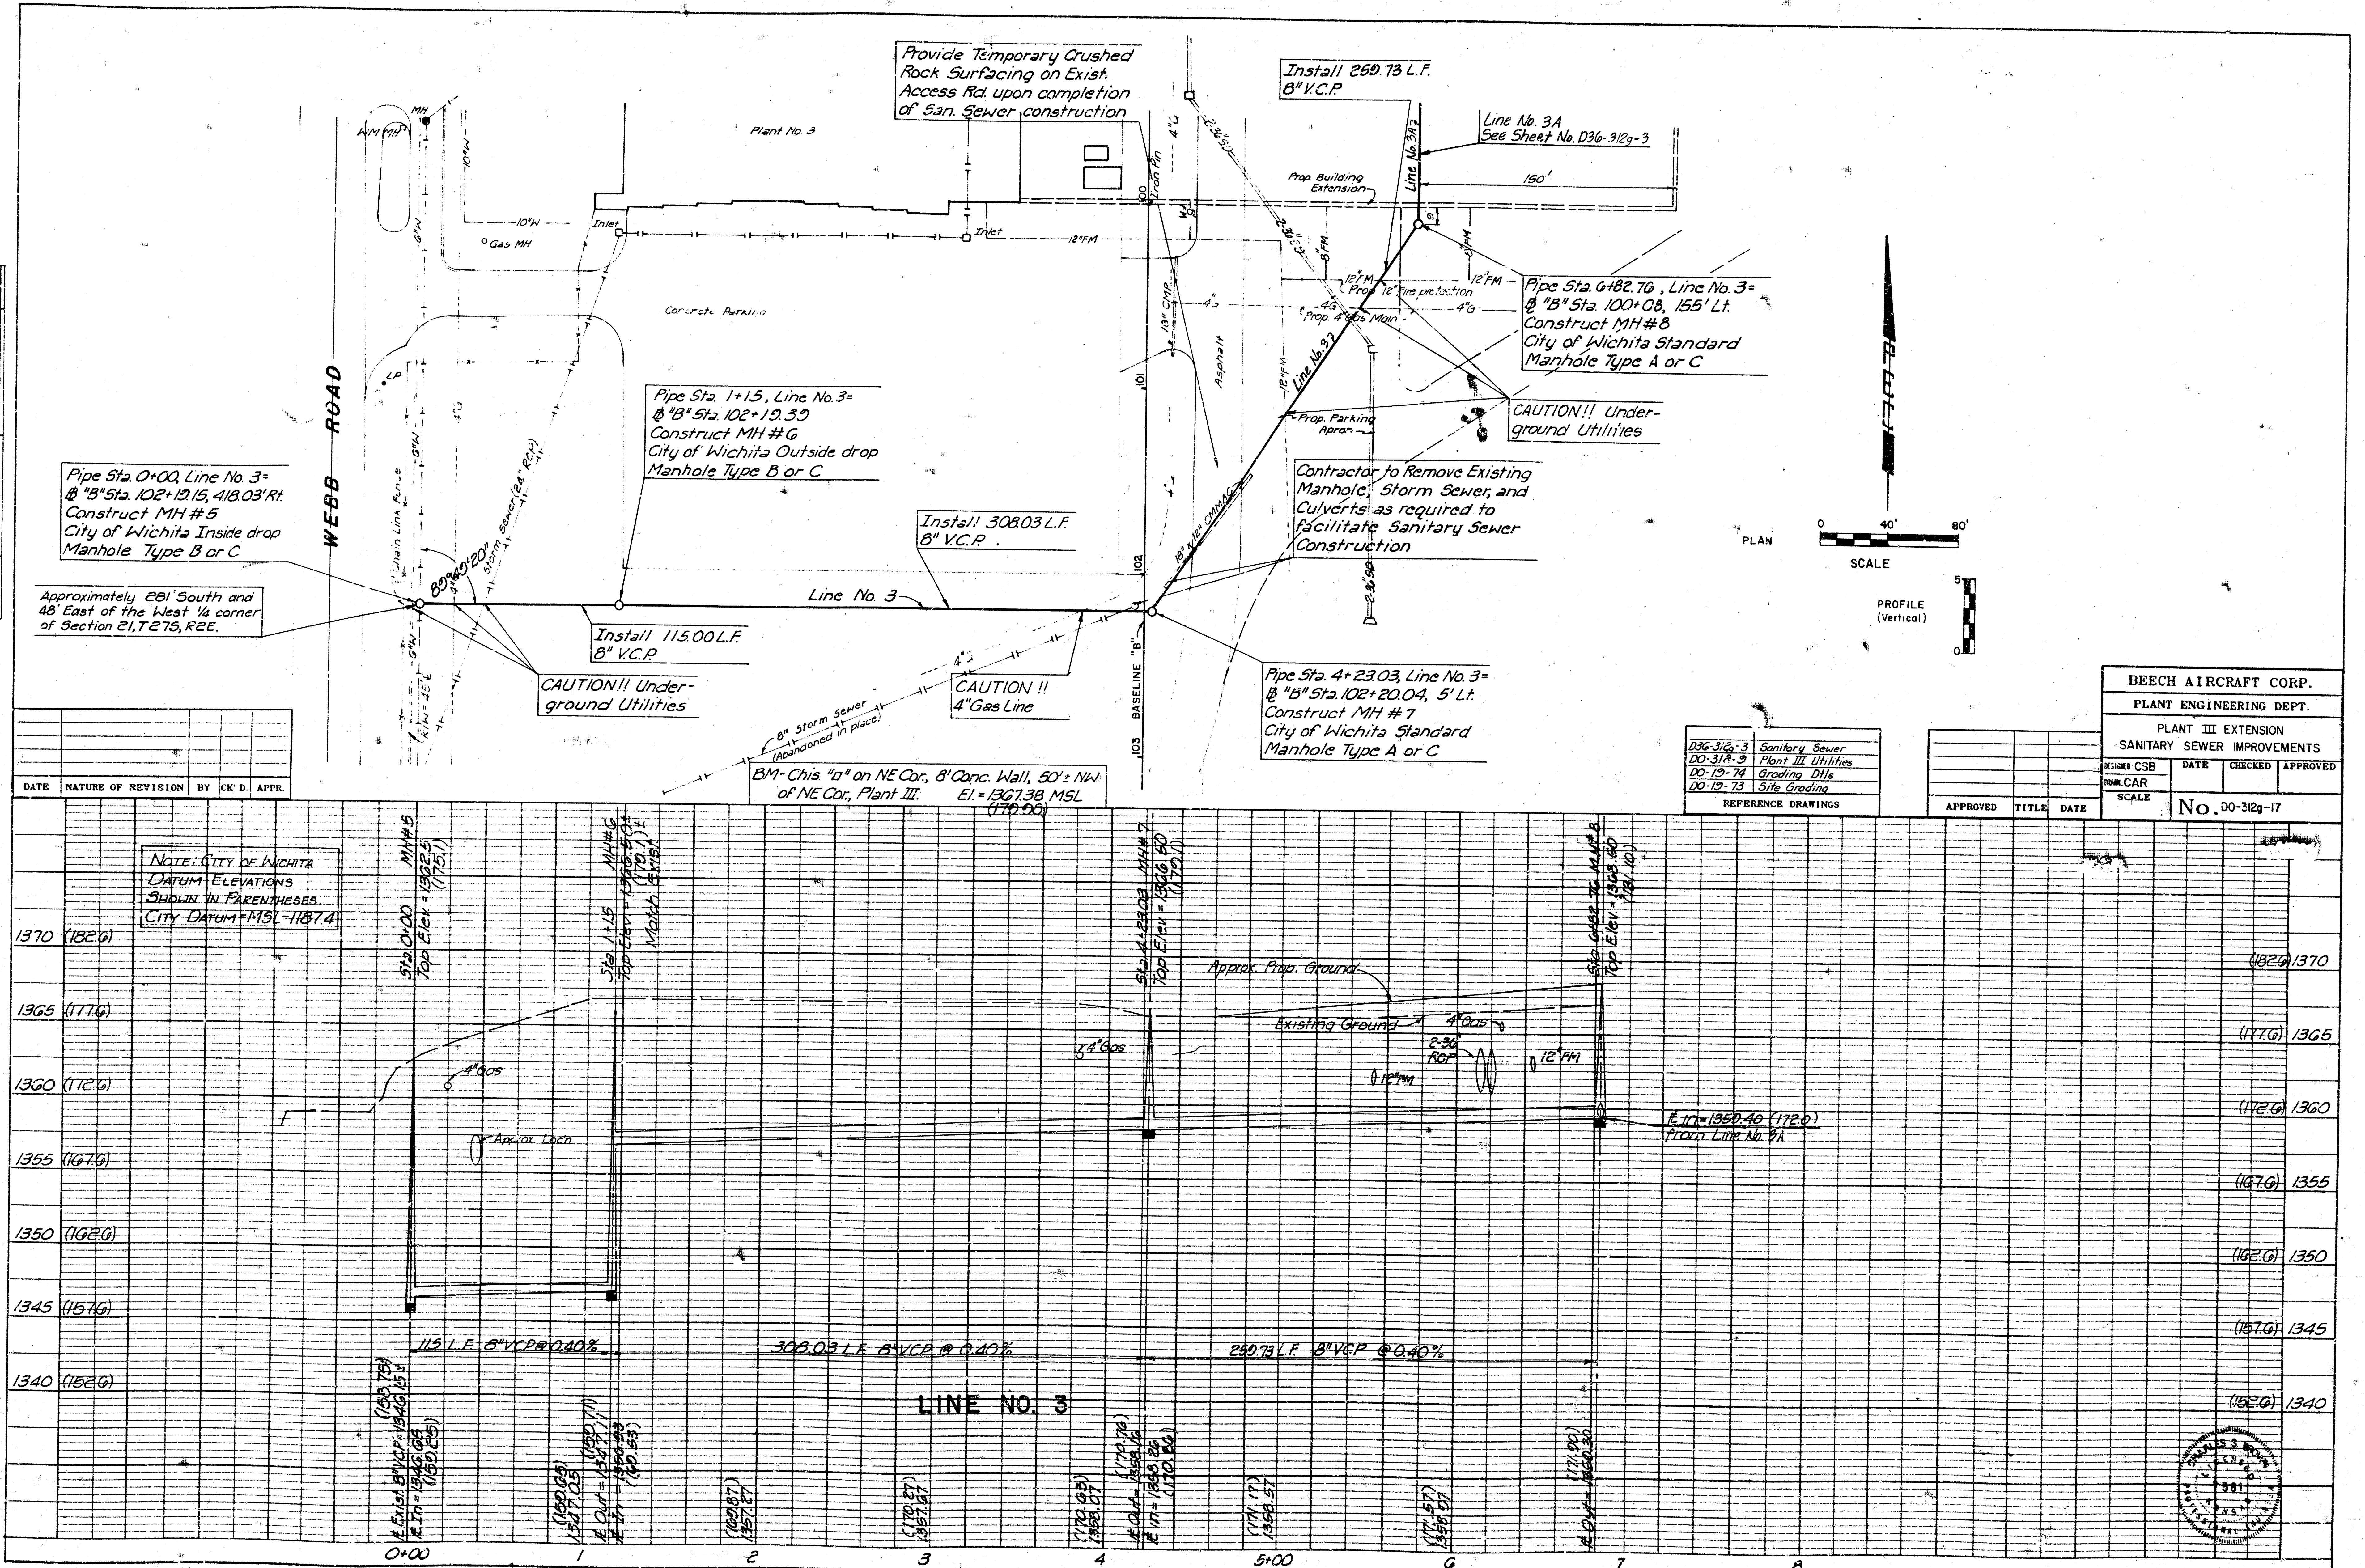



REFERENCE DRAWINGS
136-312-3 Sanitary Sewer
136-312-5 Plant III Utilities
136-312-7 Grading Data
136-312-9 Site Grading

APPROVED	TITLE	DATE

BEECH AIRCRAFT CORP.			
PLANT ENGINEERING DEPT.			
PLANT III EXTENSION			
SANITARY SEWER IMPROVEMENTS			
REVISION	DATE	CHECKED	APPROVED
1			
2			
3			
100			

PLAN
 SURVEY
 NOTE BOOK
 No. 1 of 10 CHECKS

PROFILE
 SURVEY
 NOTE BOOK
 No. 1 of 10 CHECKS

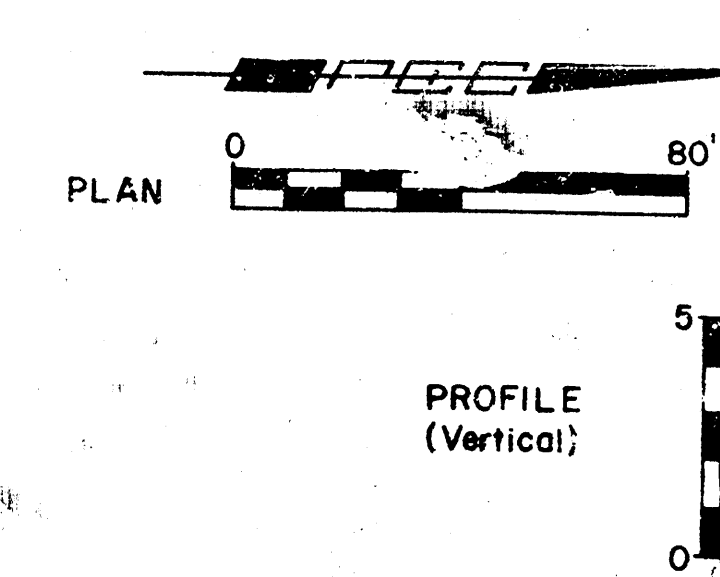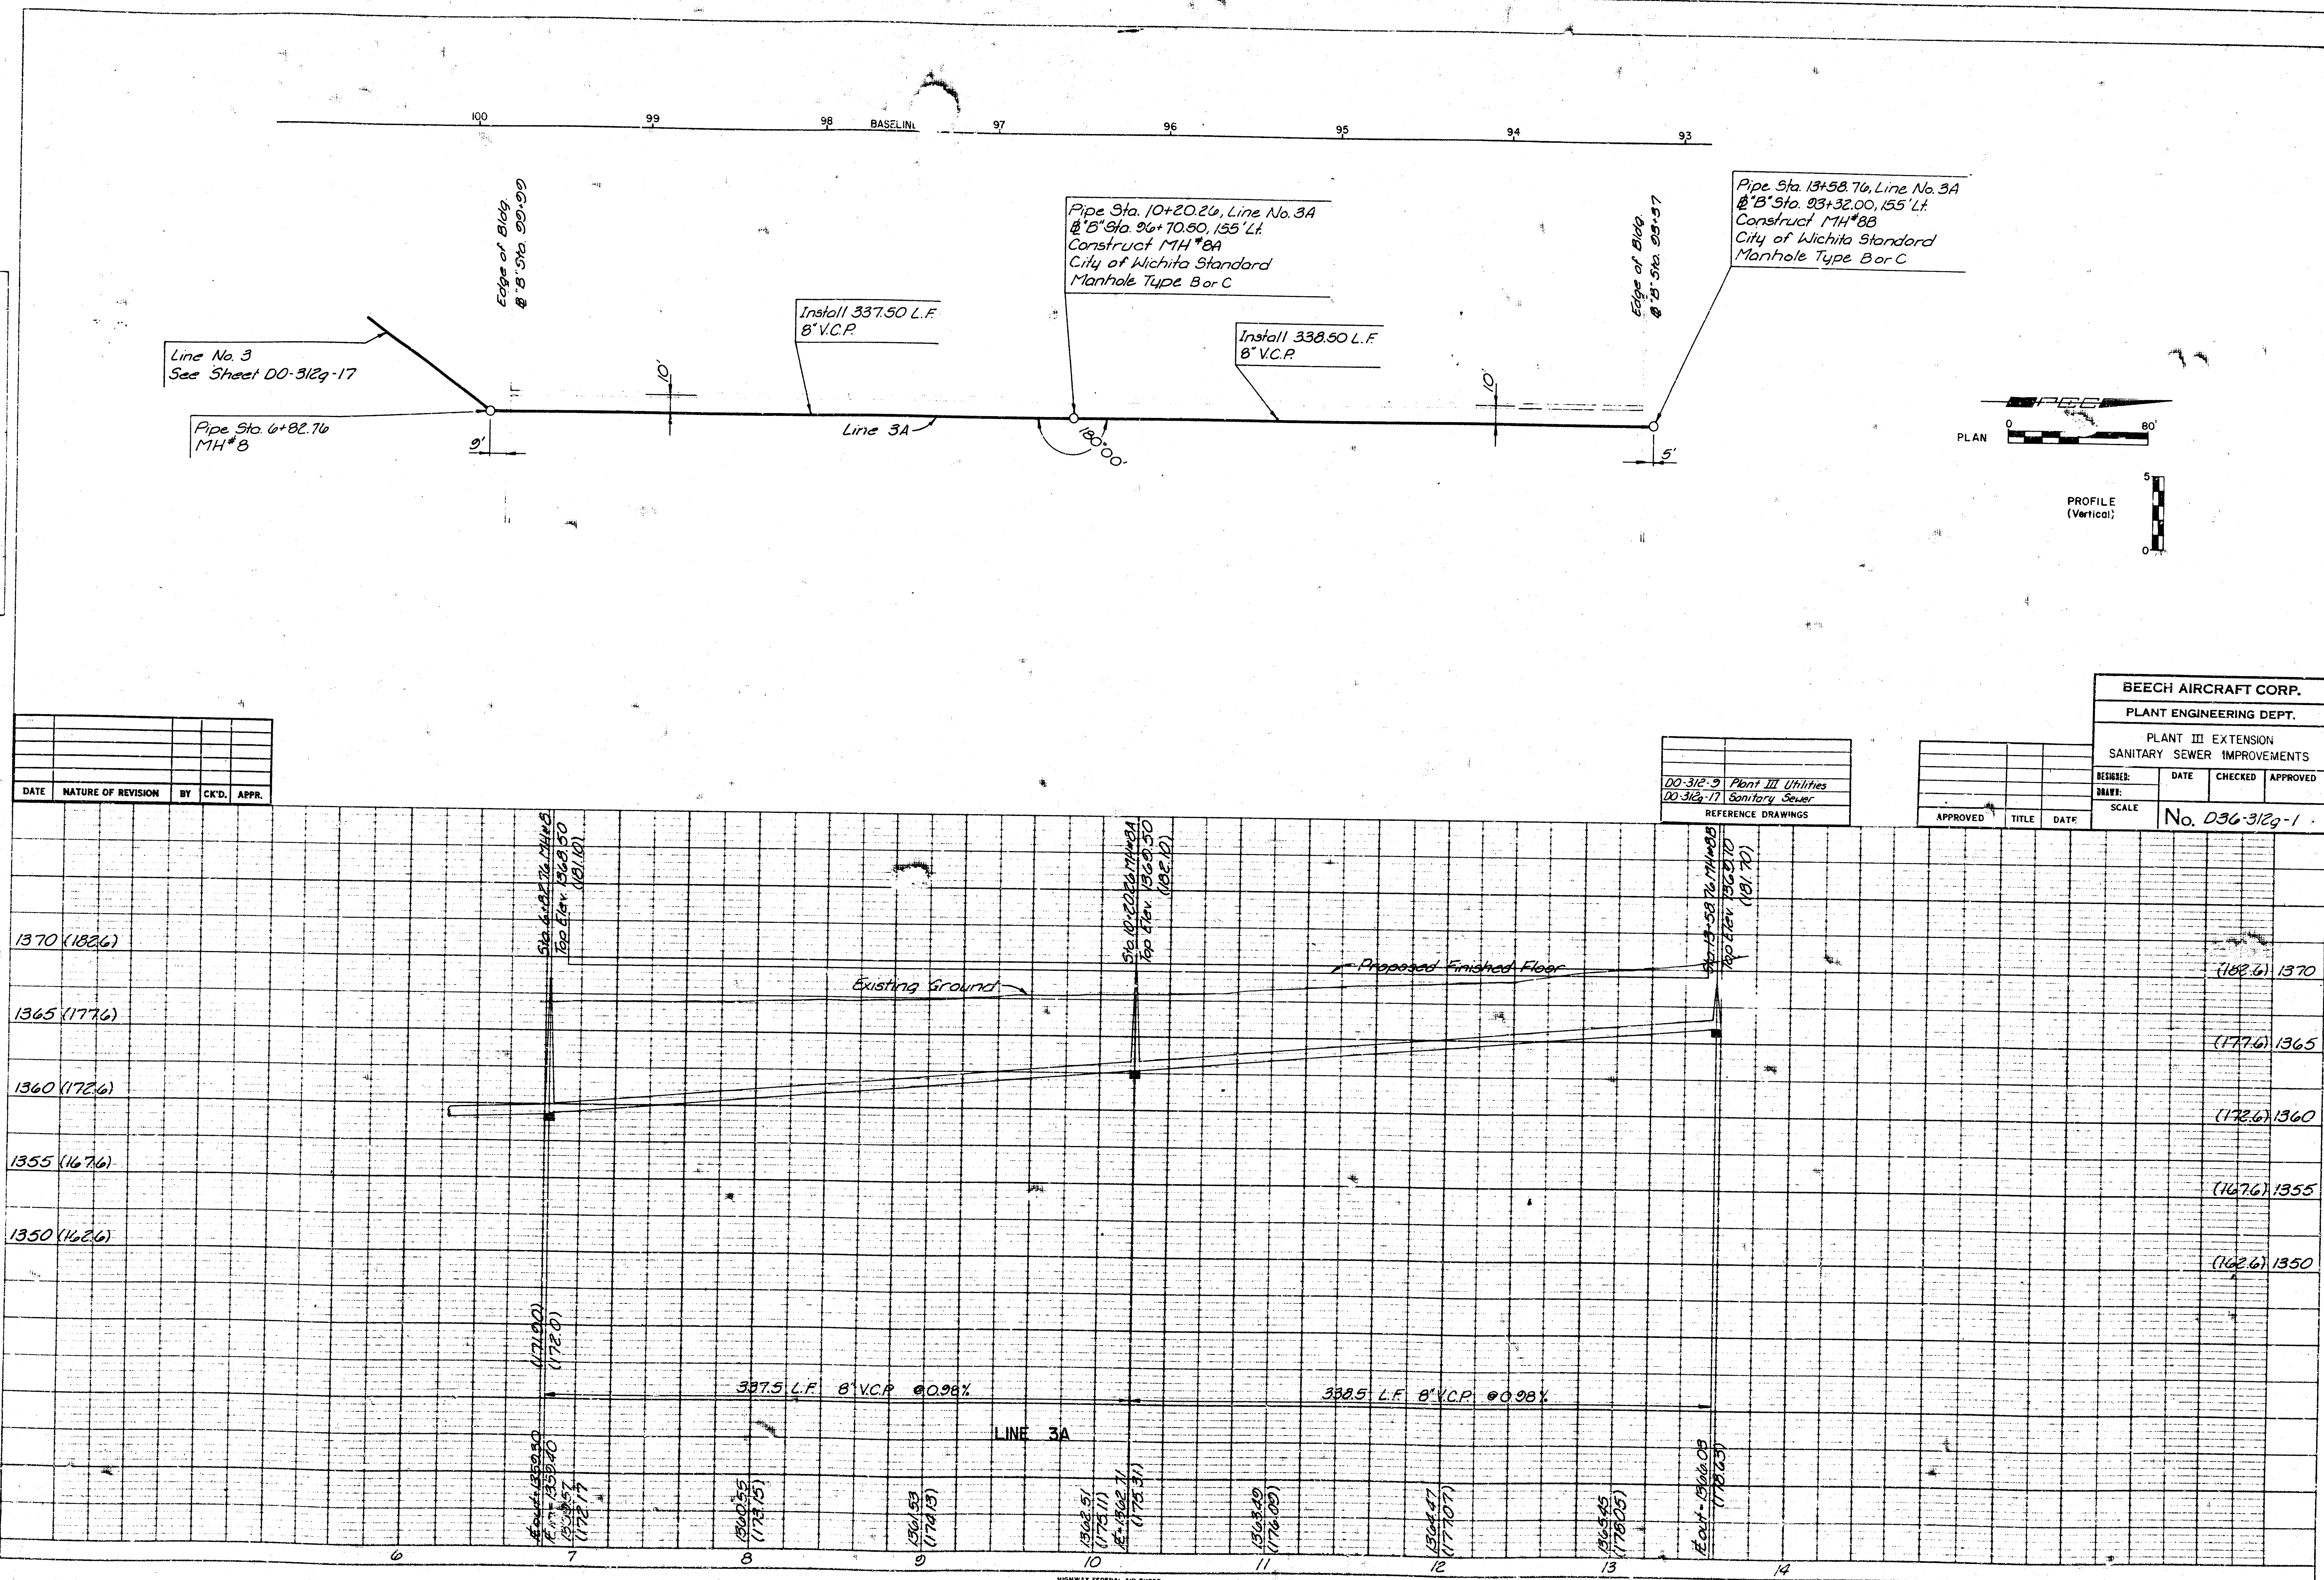

DATE	NATURE OF REVISION	BY	CHKD.	APPR.

DO-312-9	Plant III Utilities
DO-312-17	Sanitary Sewer
REFERENCE DRAWINGS	

BEECH AIRCRAFT CORP.			
PLANT ENGINEERING DEPT.			
PLANT III EXTENSION			
SANITARY SEWER IMPROVEMENTS			
DESIGNED:	DATE	CHECKED	APPROVED
DRAWN:			
SCALE	No. DO-312g-1		