


PLAN	NOTE BOOK
NO.	DATE
PROJECT: LOCATION: DRAWN BY: CHECKED BY: DATE:	

PROFILE	NOTE BOOK
NO.	DATE
PROJECT: LOCATION: DRAWN BY: CHECKED BY: DATE:	

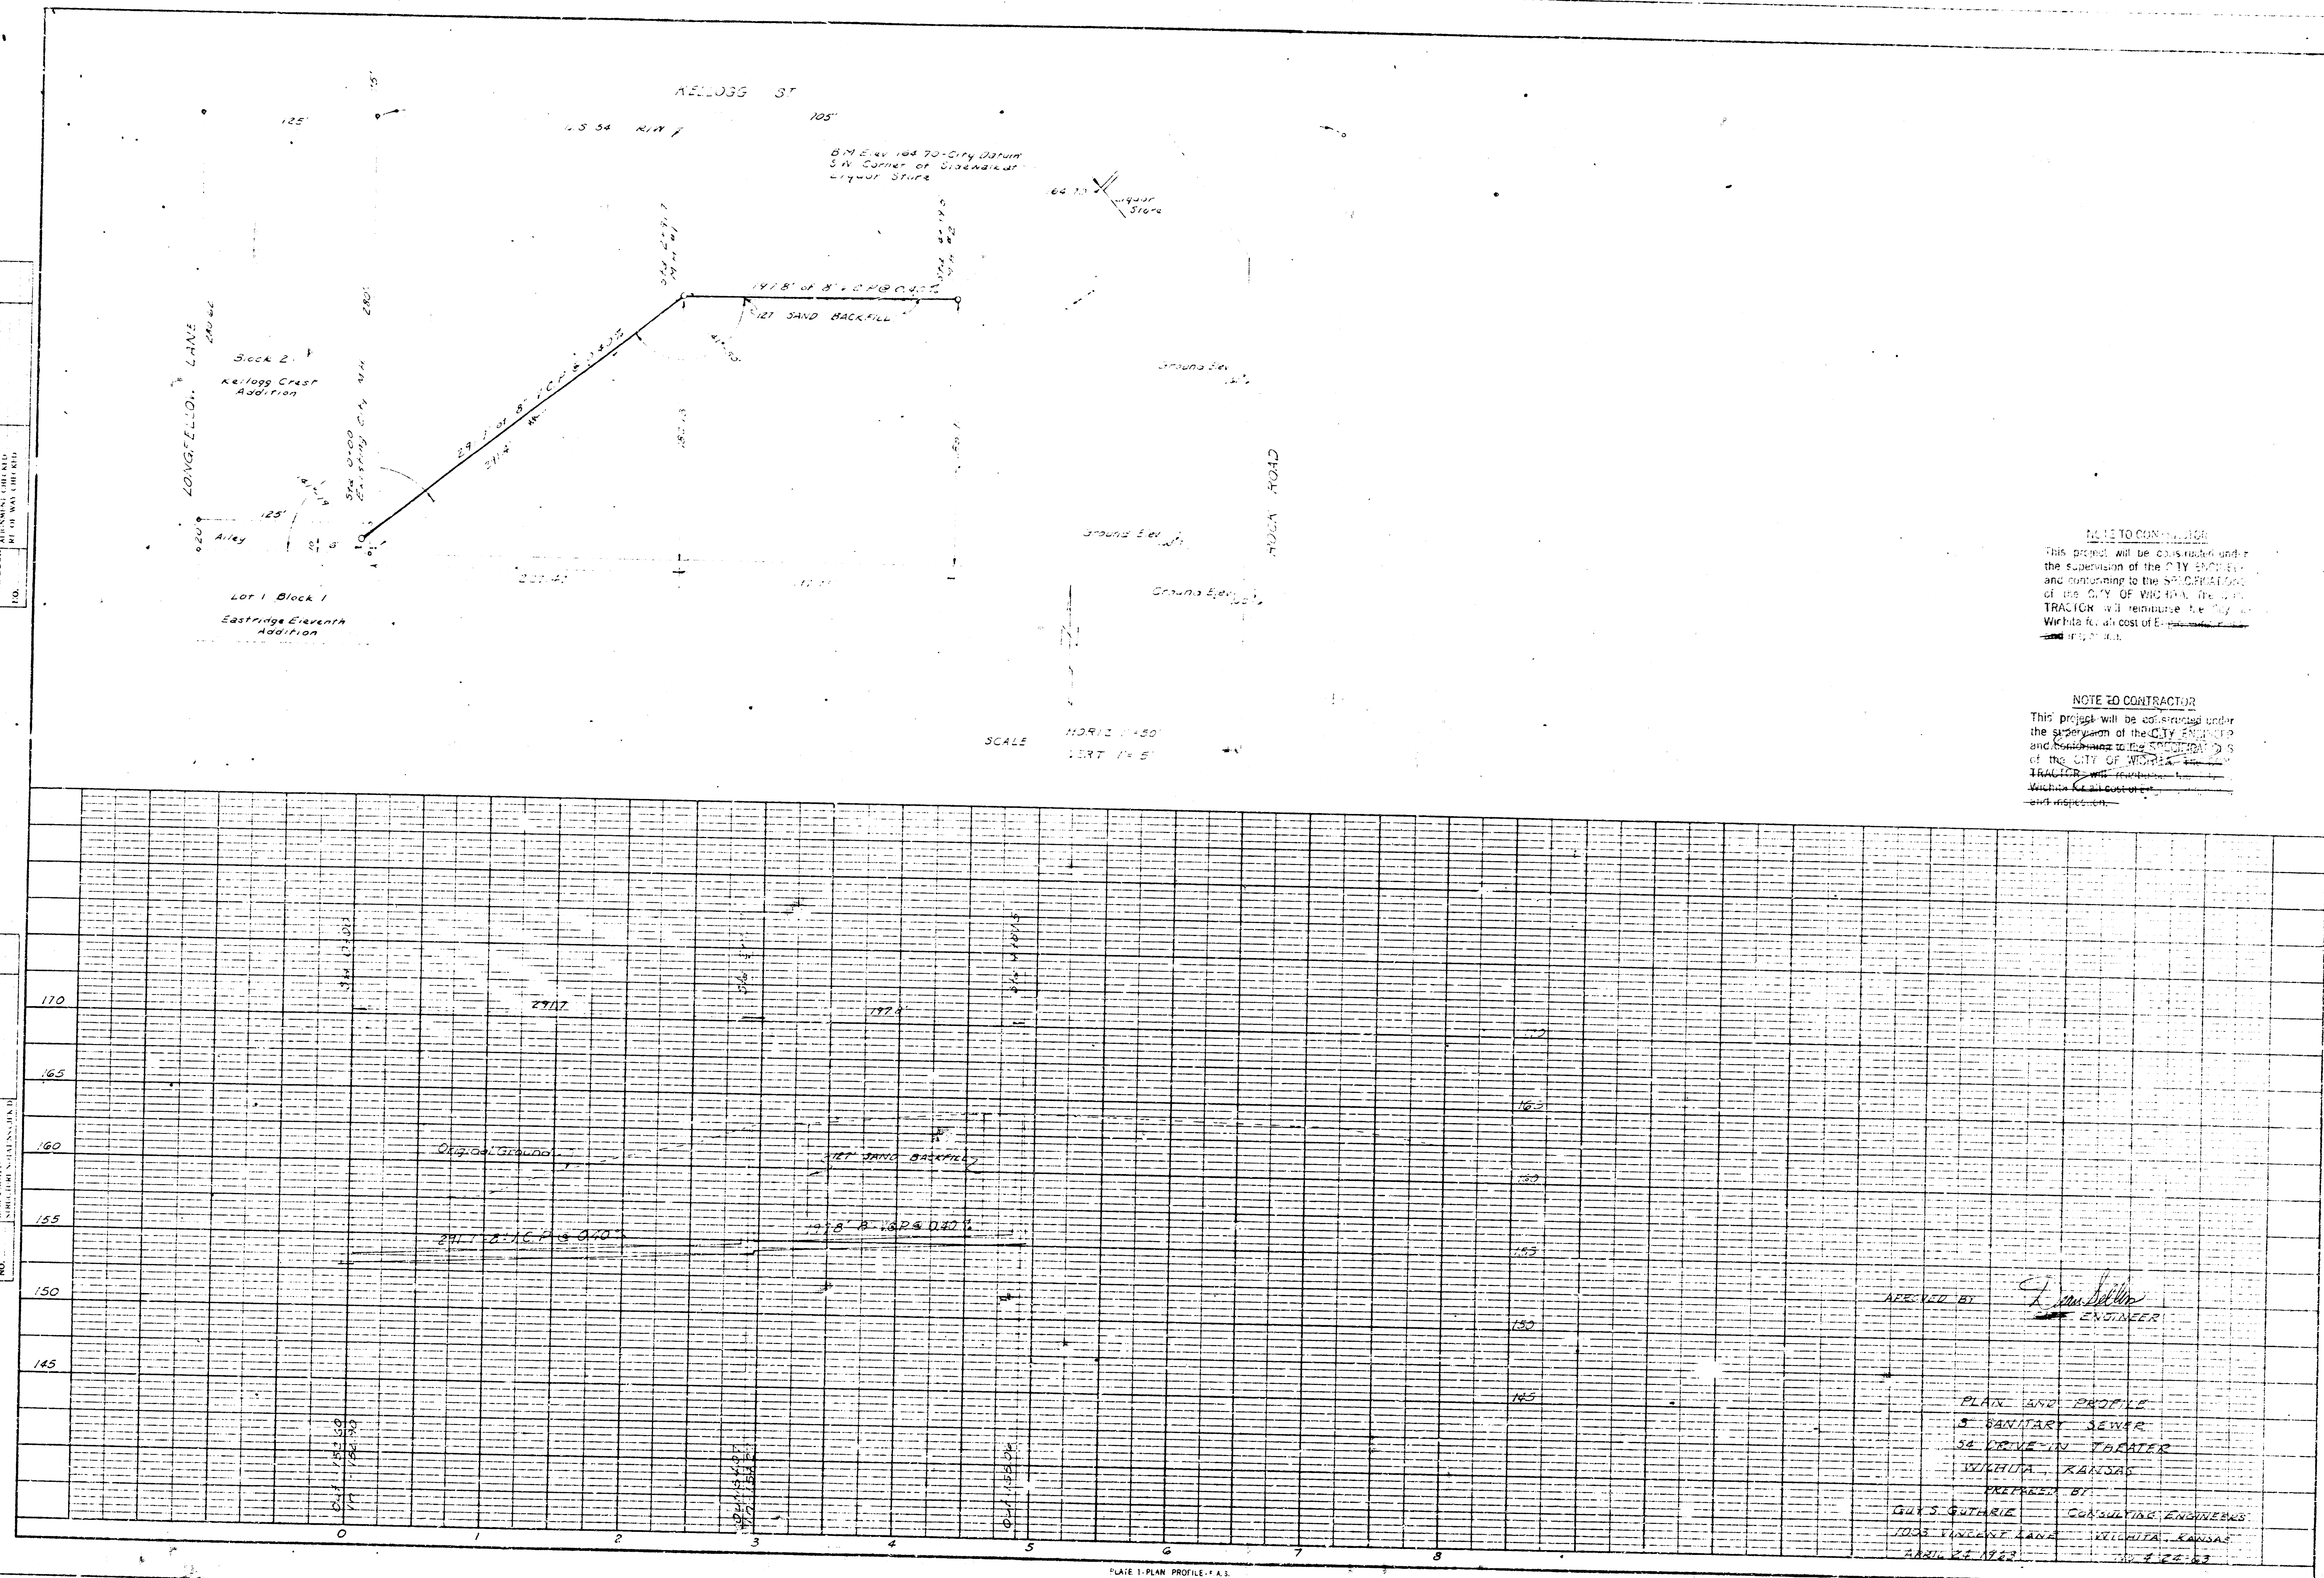

NOTE TO CONTRACTOR
 This project will be constructed under the supervision of the CITY ENGINEER and conforming to the SPECIFICATIONS of the CITY OF WICHITA. The CITY TRACER will determine the location of the sewer line and the cost of the work will be paid by the CITY OF WICHITA.

NOTE TO CONTRACTOR
 This project will be constructed under the supervision of the CITY ENGINEER and conforming to the SPECIFICATIONS of the CITY OF WICHITA. The CITY TRACER will determine the location of the sewer line and the cost of the work will be paid by the CITY OF WICHITA.

APPROVED BY: *[Signature]*
 ENGINEER

PLAN AND PROFILE
 5" SANITARY SEWER
 24" DRIVE-IN TANKER
 WICHITA, KANSAS
 PREPARED BY:
 GUY S. GUTHRIE CONSULTING ENGINEERS
 1003 LINCOLN AVENUE
 WICHITA, KANSAS