




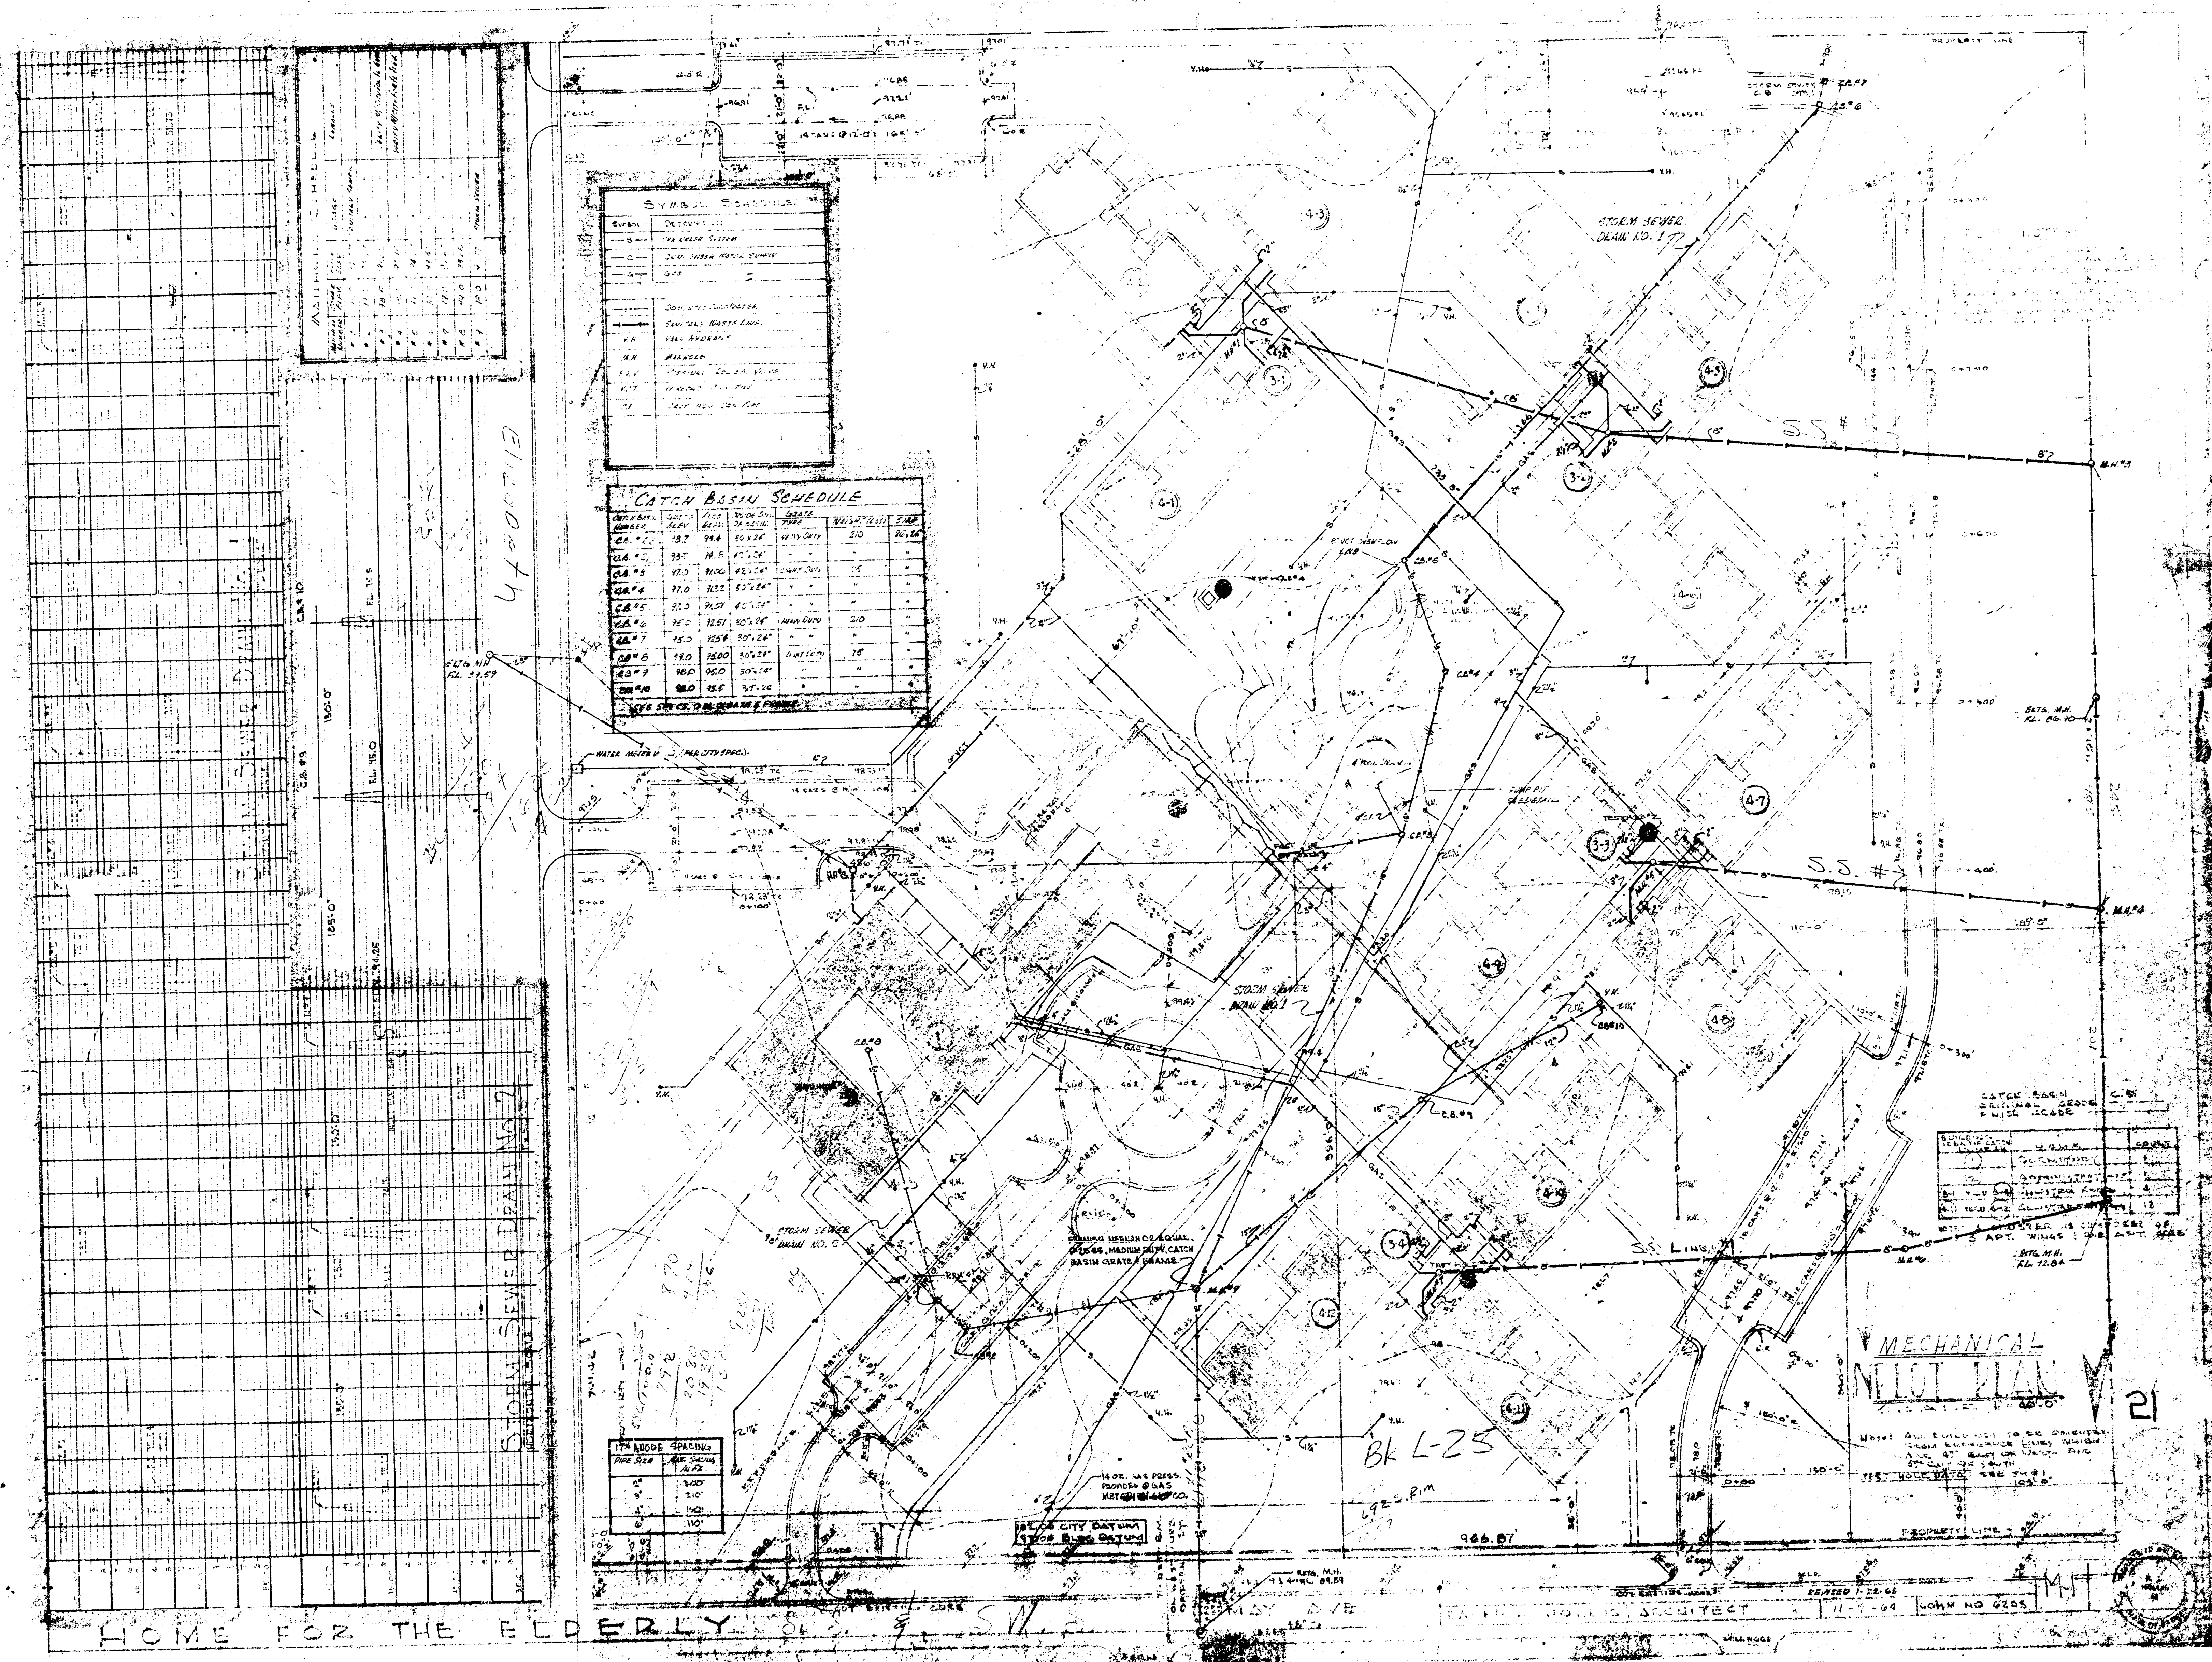


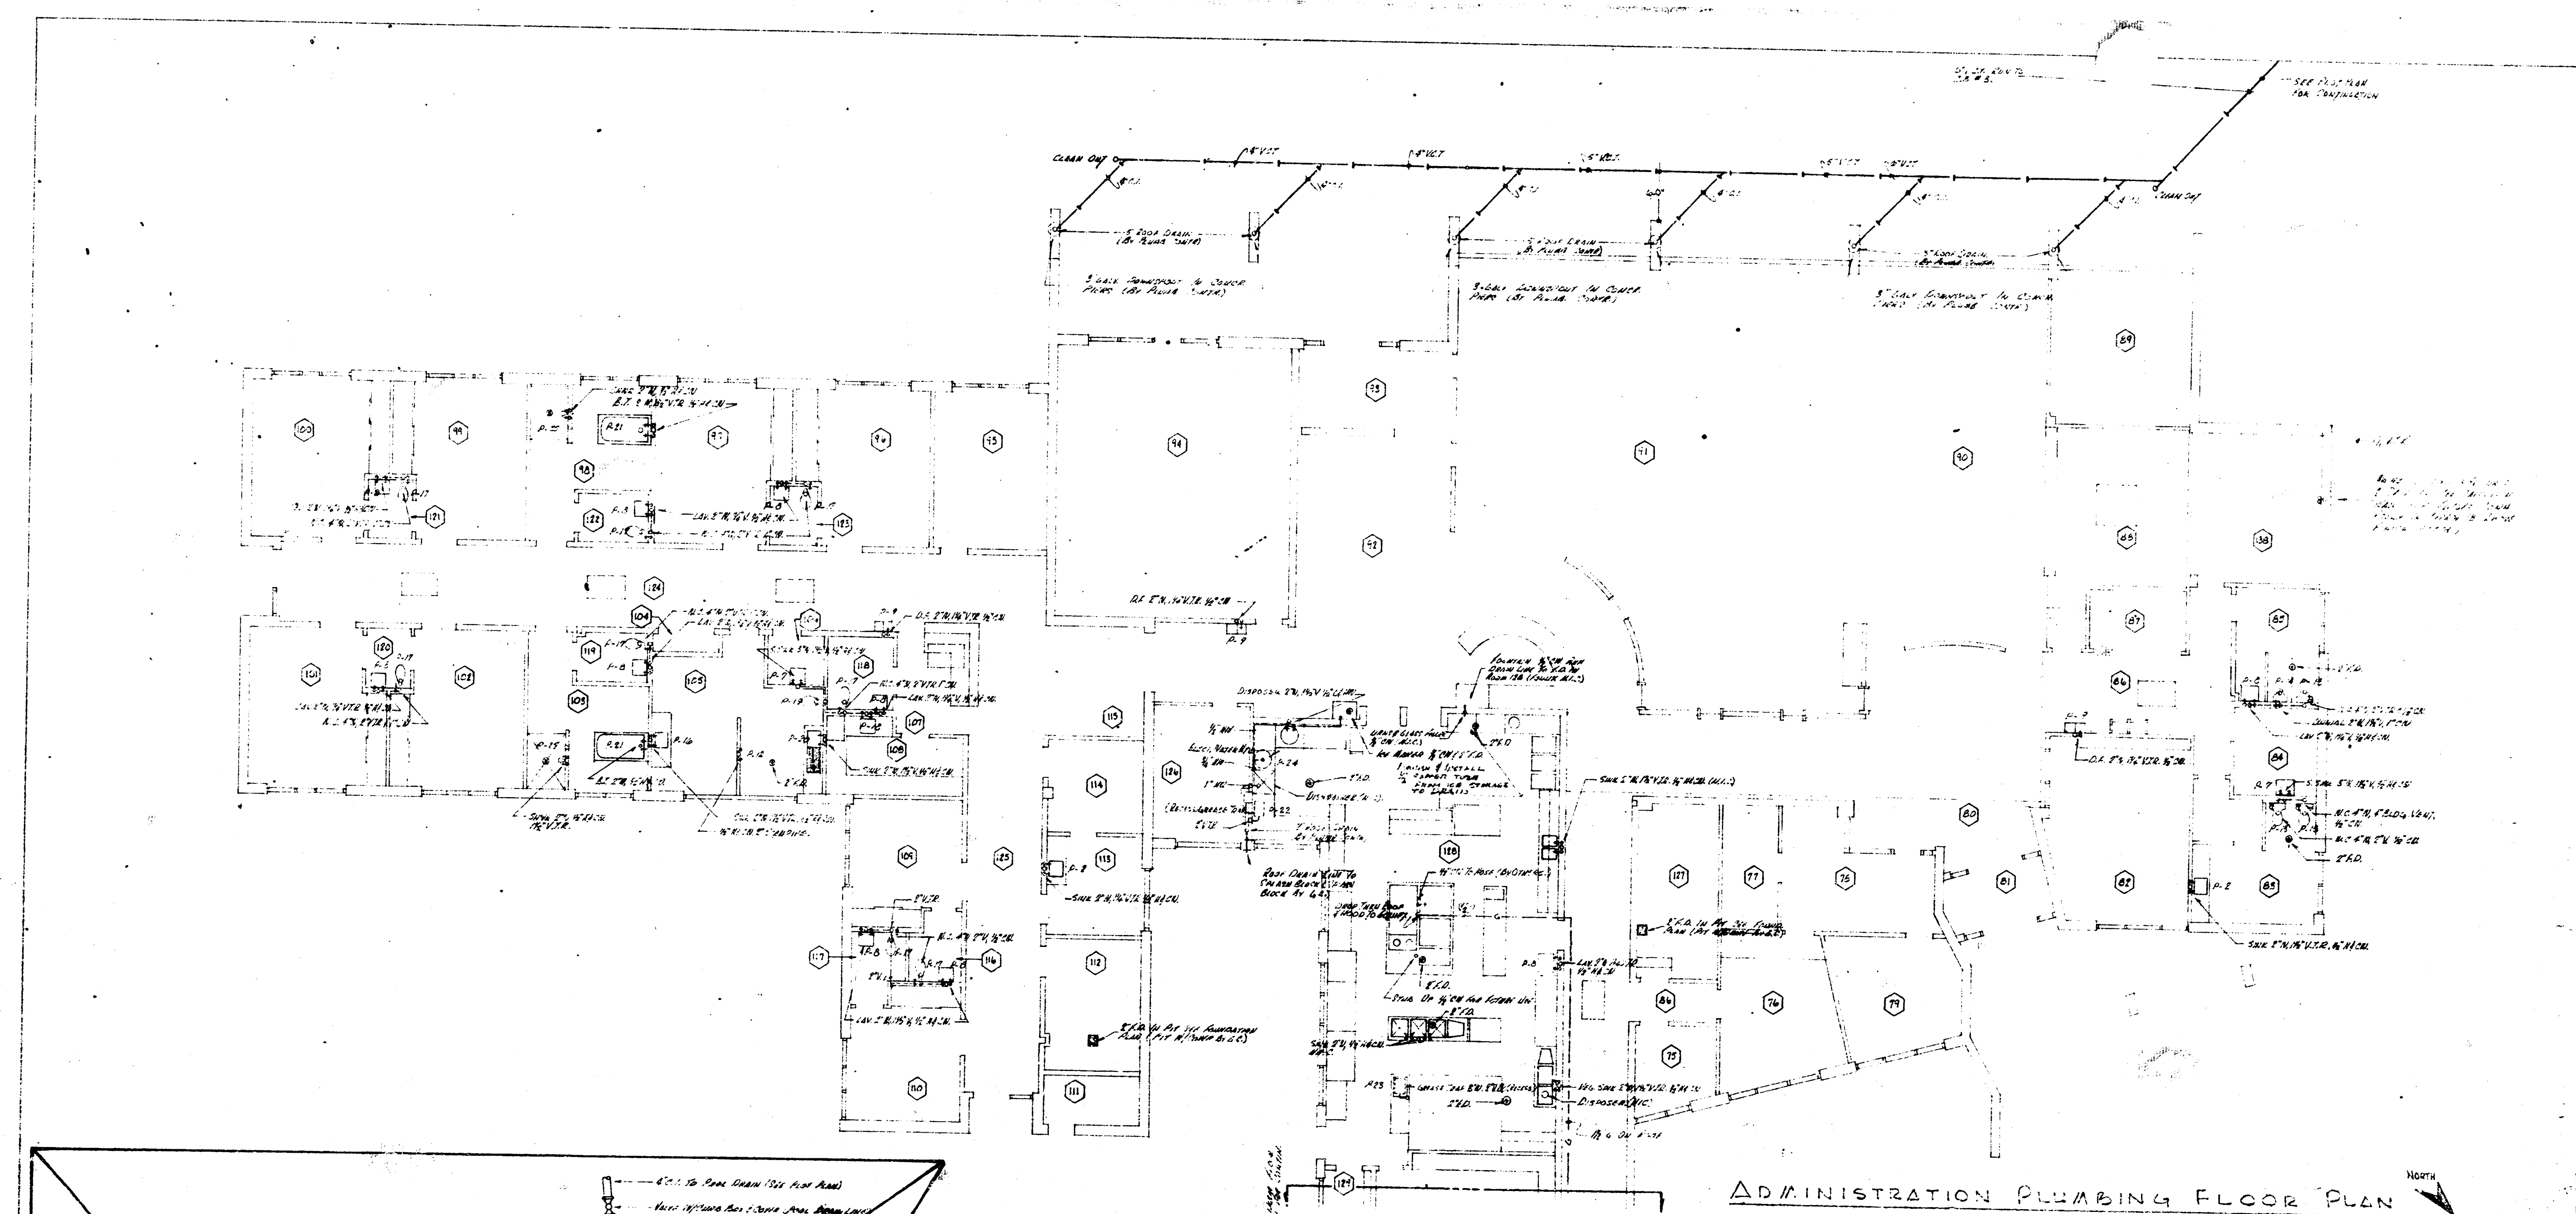


ADMINISTRATION PLUMBING FLOOR PLAN
SCALE 1/8"=1'-0"

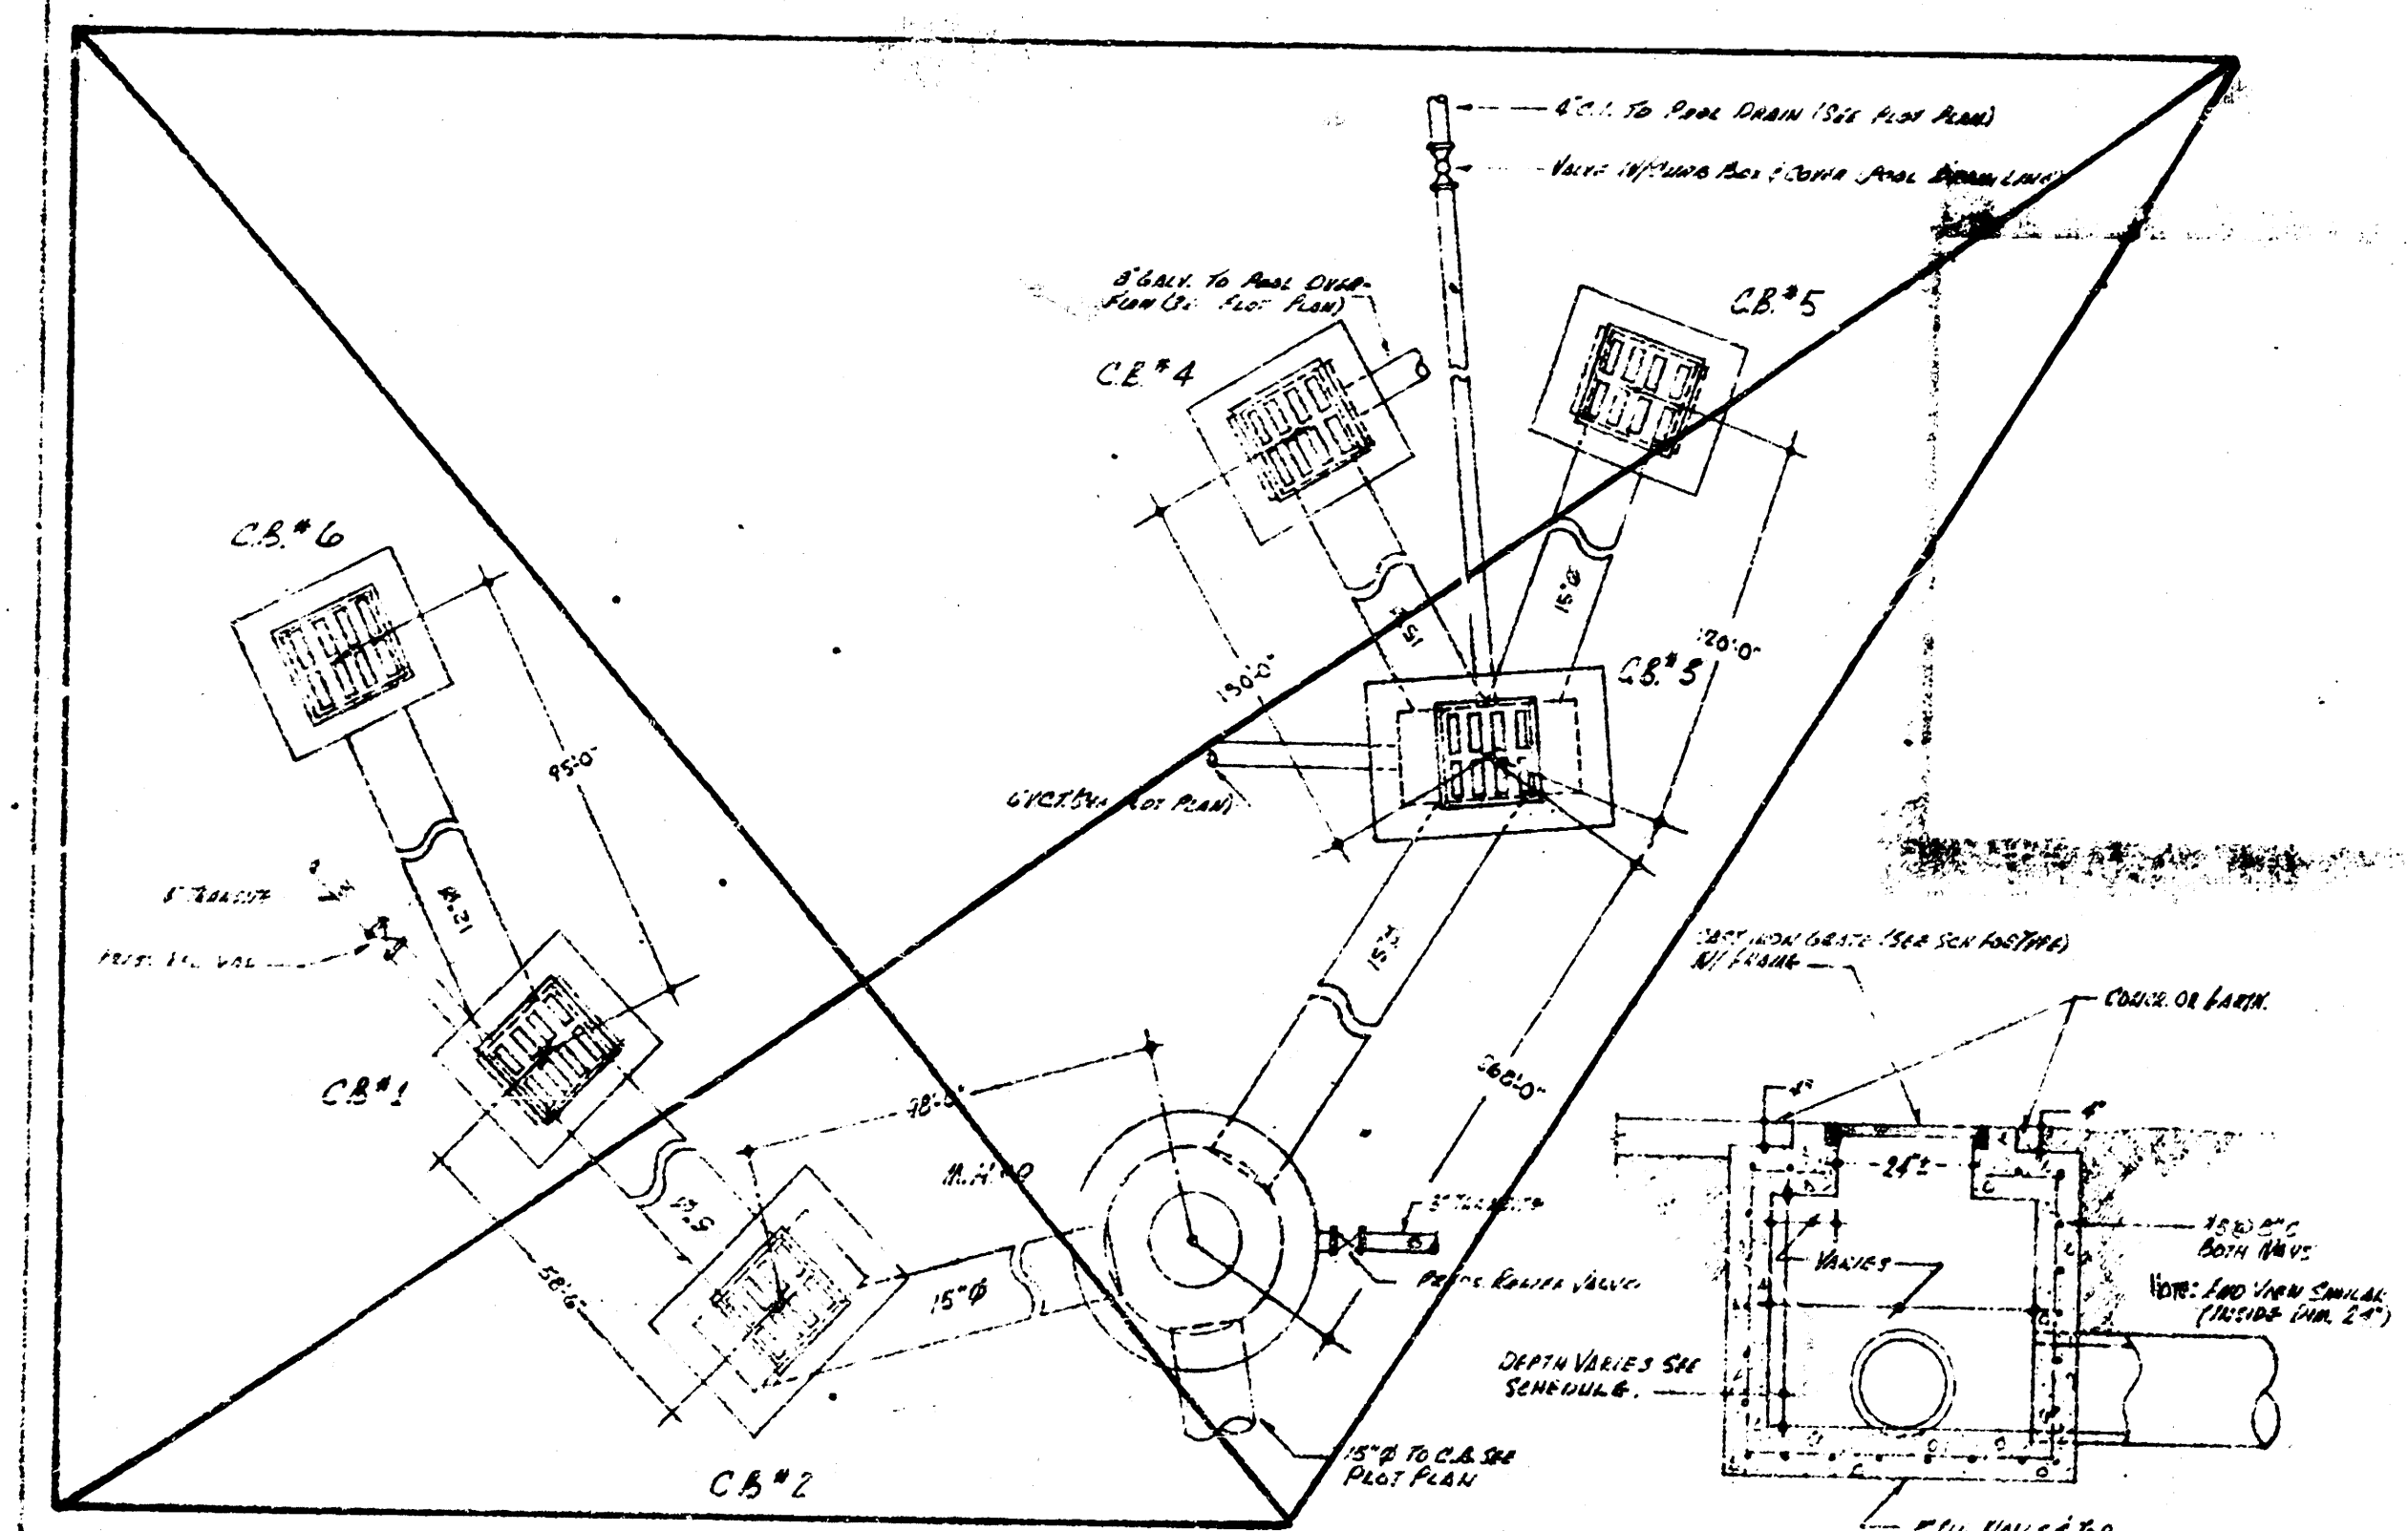


CATCH BASIN PIPING LAYOUT
SCALE 1/8"=1'-0"

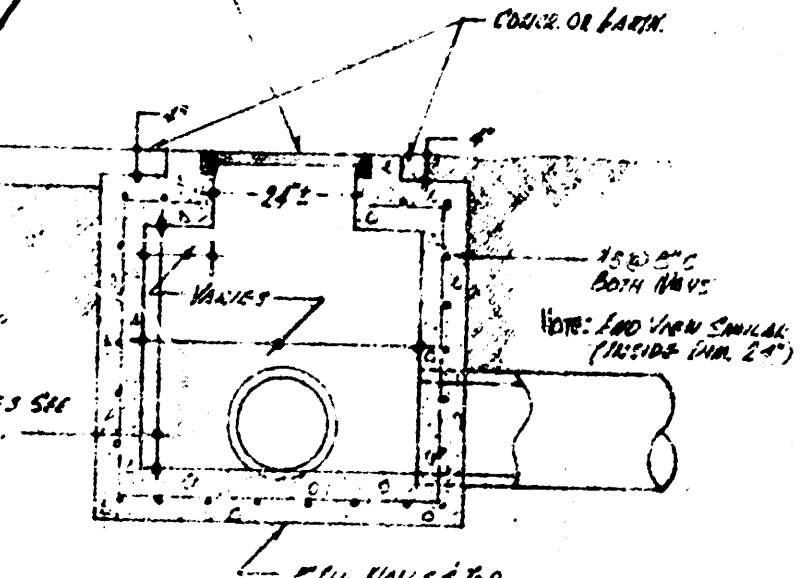


TYPICAL SECTION THRU CATCH BASIN
SCALE 1/8"=1'-0"

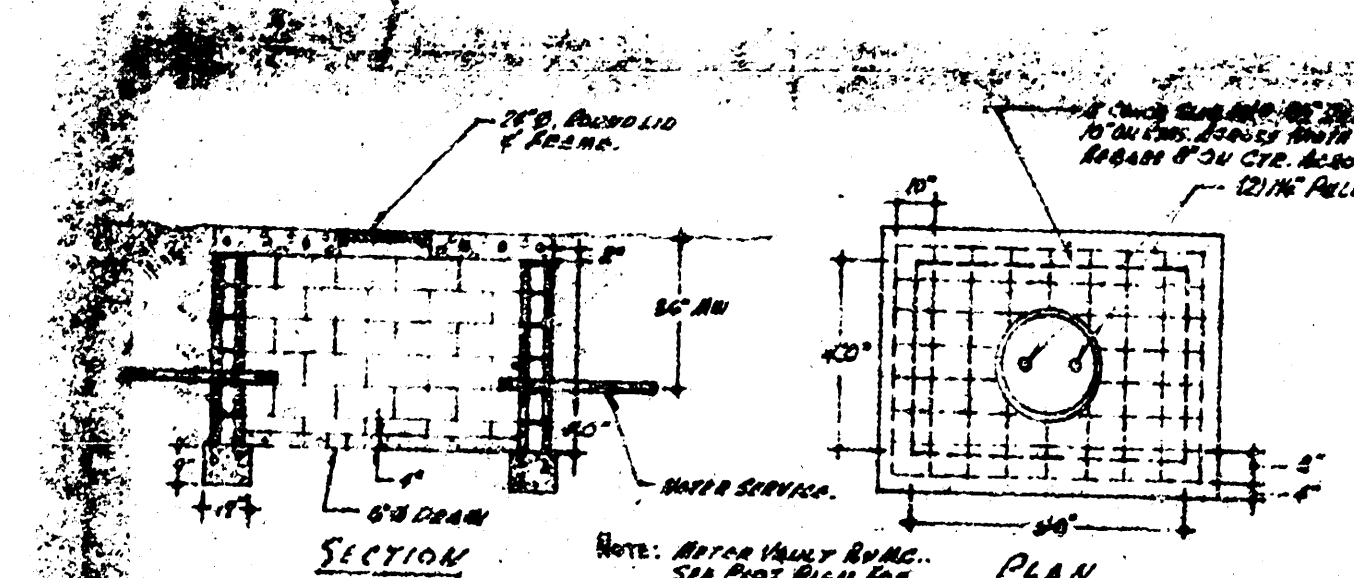

WATER METER VAULT DETAIL
SCALE 1/8"=1'-0"

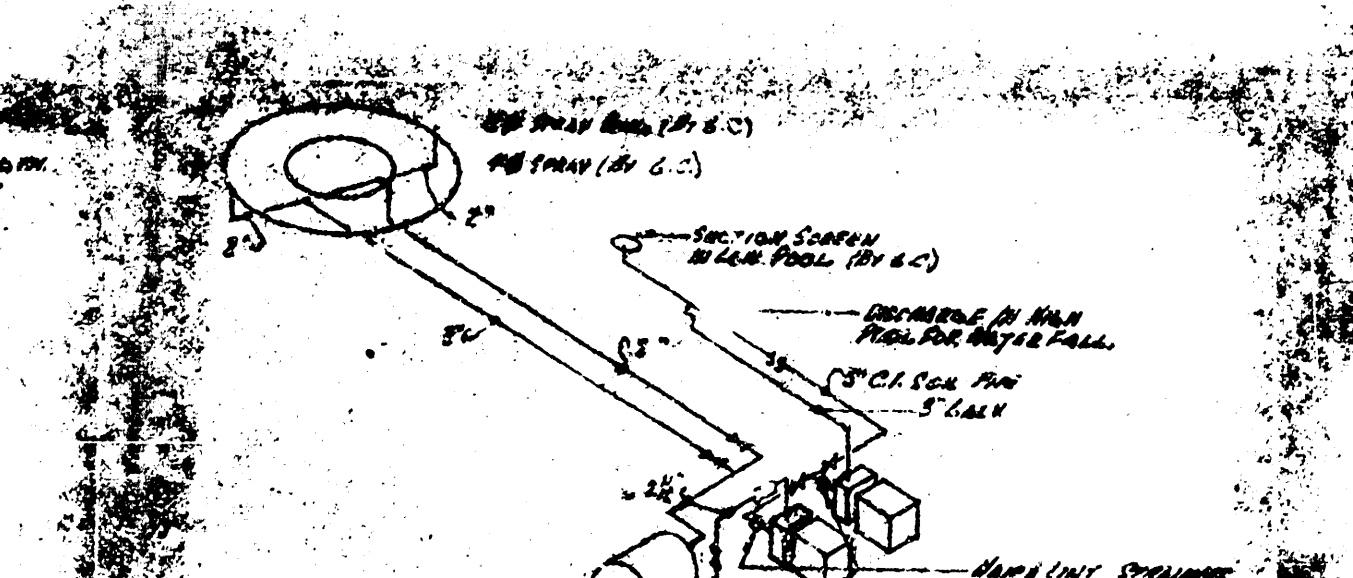

RAMP DETAIL FOR FOUNTAIN
SCALE 1/8"=1'-0"

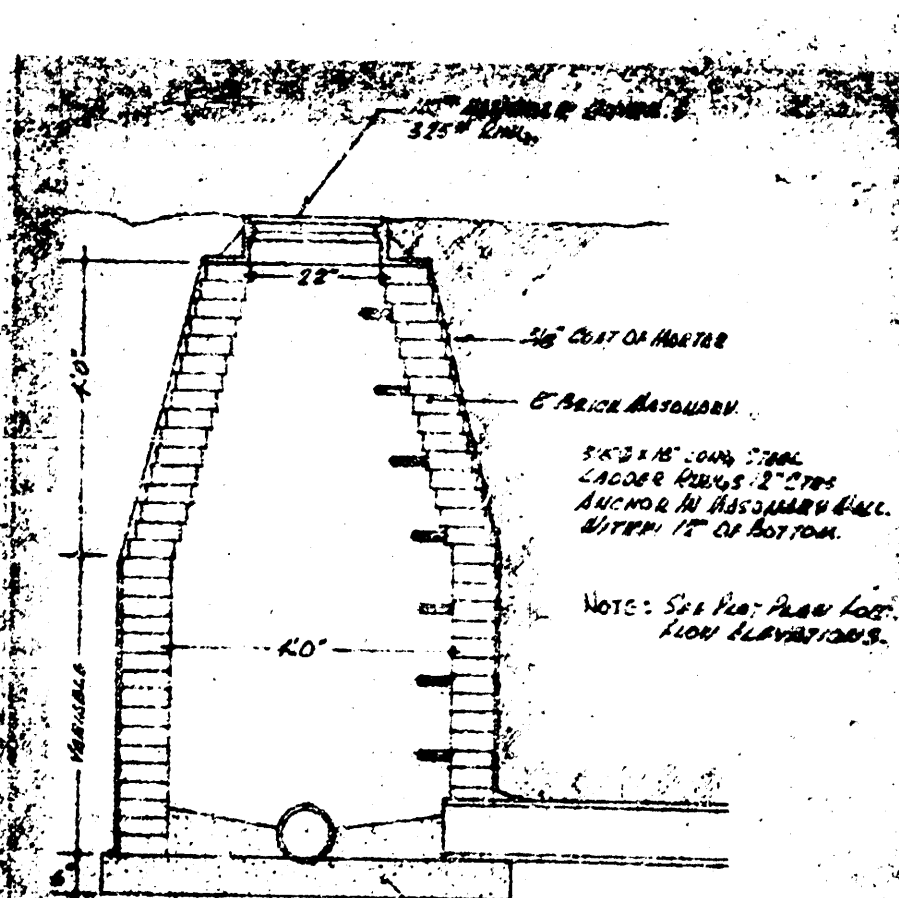

MANHOLE DETAIL
NO SCALE

HOME FOR ELDERLY — ABE. WICHITA, KANSAS

REPH L. HOLLS — A.C.A.
WICHITA, KANSAS

11-9-68 COMM NO 6208 M-4

