 



STA. 10+00.0, LINE 1, INSTALL 24" END SECTION W/ 10 S.Y. OF LIGHTSTONE RIP RAP W/ GROUTED TOE WALL N 13827.28, E 11898.80



AS-BUILT AUGUST 2008

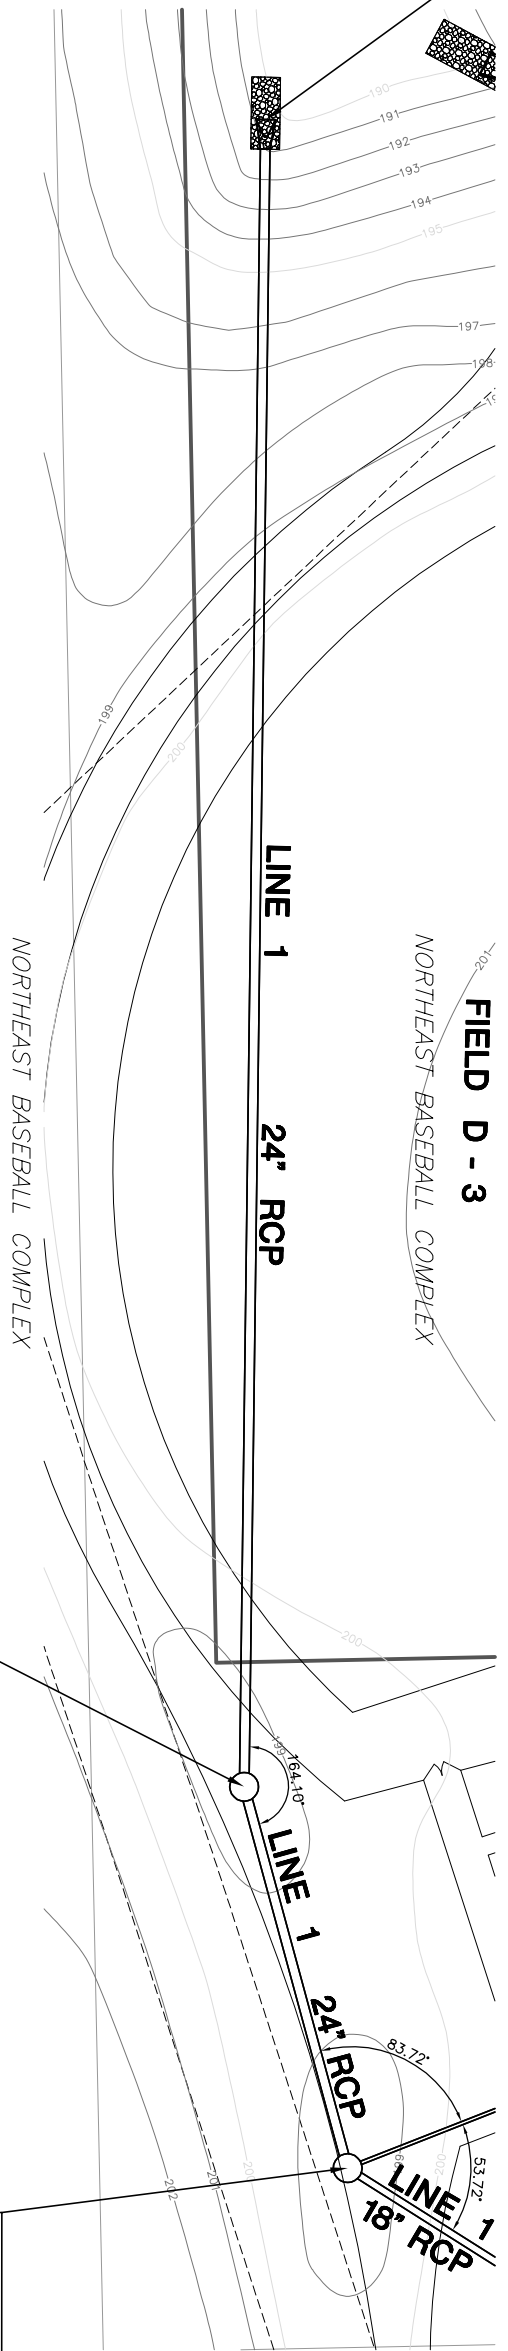


PLAN LINE 1
SCALE: 1"=20'

STA. 13+47.3, LINE 1
CONSTRUCT 5' DIA. SHALLOW
TYPE "A" MANHOLE
W/DEETER FRAME & GRATE NO.
1927 OR APPROVED EQUAL
MANHOLE TOP=197.5 AB
PROVIDE SEDIMENT BARRIER
N 13831.76 E 11551.55

STA. 14+29.6, LINE 1
CONSTRUCT 4' DIA. SHALLOW
TYPE "A" MANHOLE
W/DEETER FRAME & GRATE NO.
1927 OR APPROVED EQUAL
MANHOLE TOP=197.5 AB
PROVIDE SEDIMENT BARRIER
N 13810.23 E 11472.12

PROFILE LINE 1
SCALE: HORIZ. 1"=20'
SCALE: VERT. 1"=5'

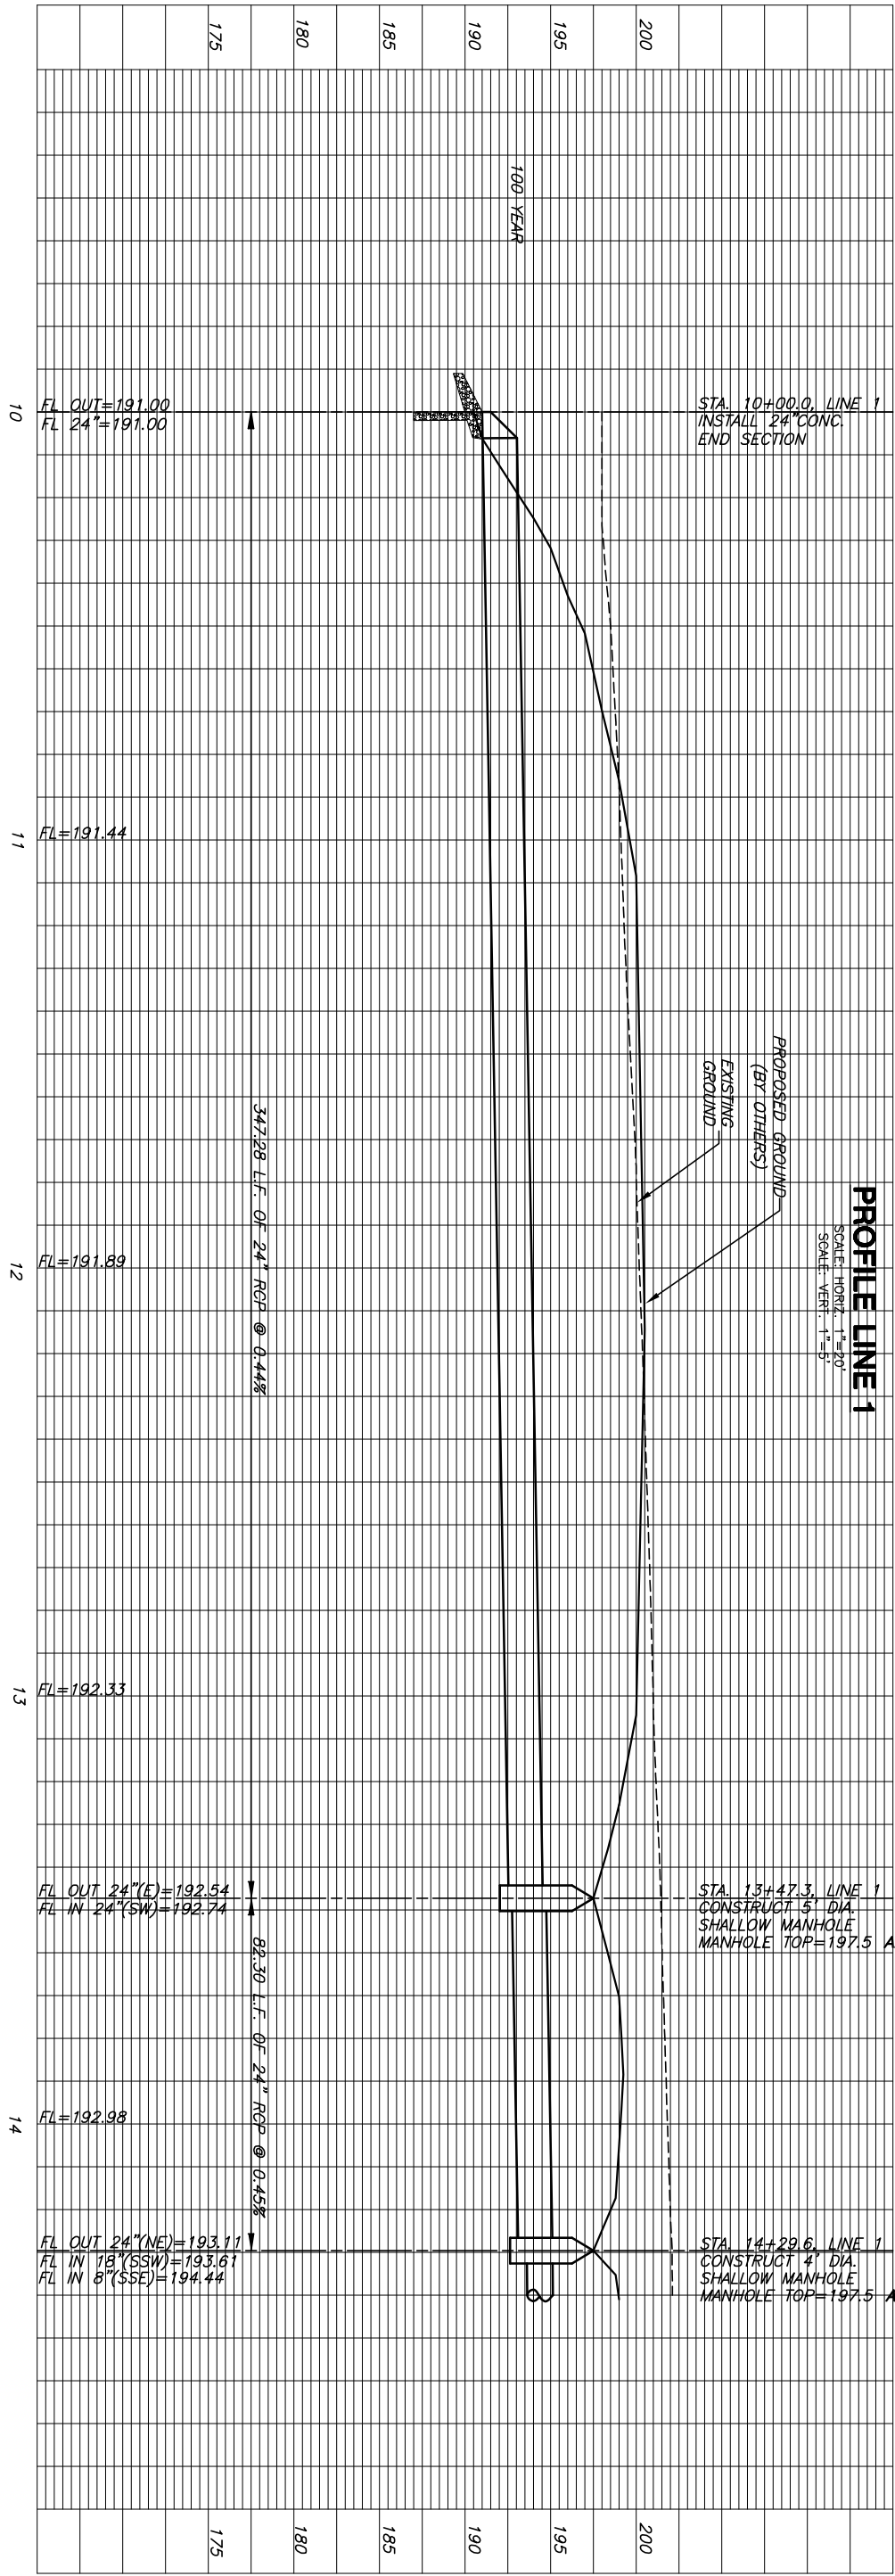

STA. 10+00.0, LINE 1
INSTALL 24" CONC.
END SECTION

STA. 13+47.3, LINE 1
CONSTRUCT 5' DIA.
SHALLOW MANHOLE
MANHOLE TOP=197.5 AB

STA. 14+29.6, LINE 1
CONSTRUCT 4' DIA.
SHALLOW MANHOLE
MANHOLE TOP=197.5 AB

FL OUT=191.00
FL 24"=191.00

FL=191.44

FL=191.89

FL=192.33

FL=192.98

FL OUT 24"(NE)=193.11
FL IN 18"(SSW)=193.67
FL IN 8"(SSE)=194.44

347.28 L.F. OF 24" RCP @ 0.44%

83.30 L.F. OF 24" RCP @ 0.45%

J:\CIVIL\064103_LINE BASEBALL\DWG\SWSS\LINE1\AS-BUILT\064103-001-001-001.dwg

STORM WATER SEWER
NORTHEAST BASEBALL COMPLEX
PHASE 1

MKREC
ENGINEERING
CONSULTANTS, INC.
411 N. WEBB ROAD
WICHITA, KS 67208
316-684-9600

LINE 1
SHEET TITLE
1853PPS
PROJECT NUMBER

DESIGN BY: JTC
DRAWN BY: DDC
CHECKED BY: GJA

ISSUED
August 2008
REVISED

SHEET NO.
4 of 17