


STA. 18+78.9, LINE 1
 4' DIA. SHALLOW TYPE "A" MH
 W/DEETER FRAME & GRATE NO. 1927 OR
 APPROVED EQUAL. MANHOLE TOP=199.5 AB
 PROVIDE SEDIMENT BARRIER
 N 13417.54 E 11312.68

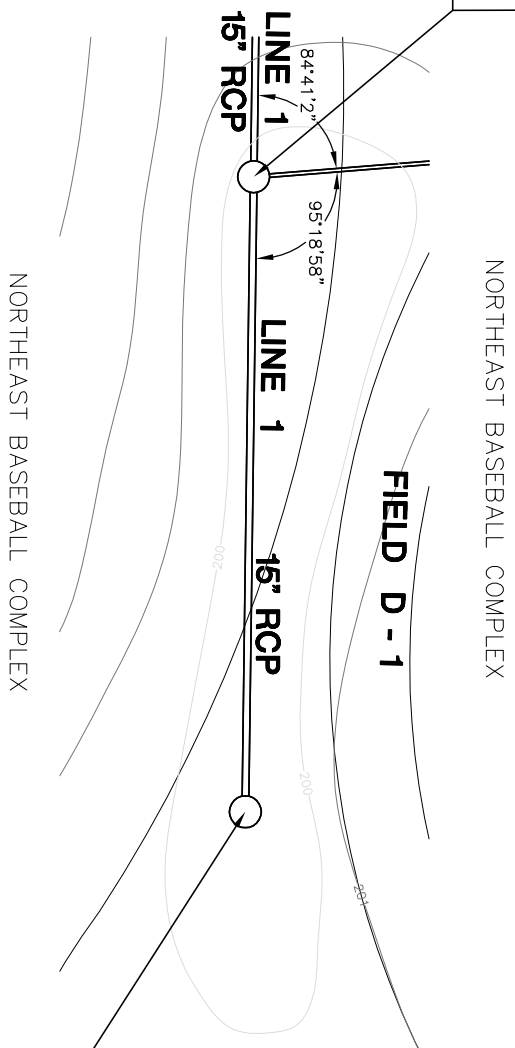


STA. 19+98.5, LINE 1, 4' DIA. SHALLOW
 TYPE "A" MH W/DEETER FRAME & GRATE
 NO. 1927 OR APPROVED EQUAL
 MANHOLE TOP=199.1 AB
 PROVIDE SEDIMENT BARRIER
 N 13301.66 E 11342.11

PLAN LINE 1
 SCALE: 1"=20'

AS-BUILT AUGUST 2008

PROFILE LINE 1
 SCALE: HORIZ. 1"=20'
 SCALE: VERT. 1"=5'

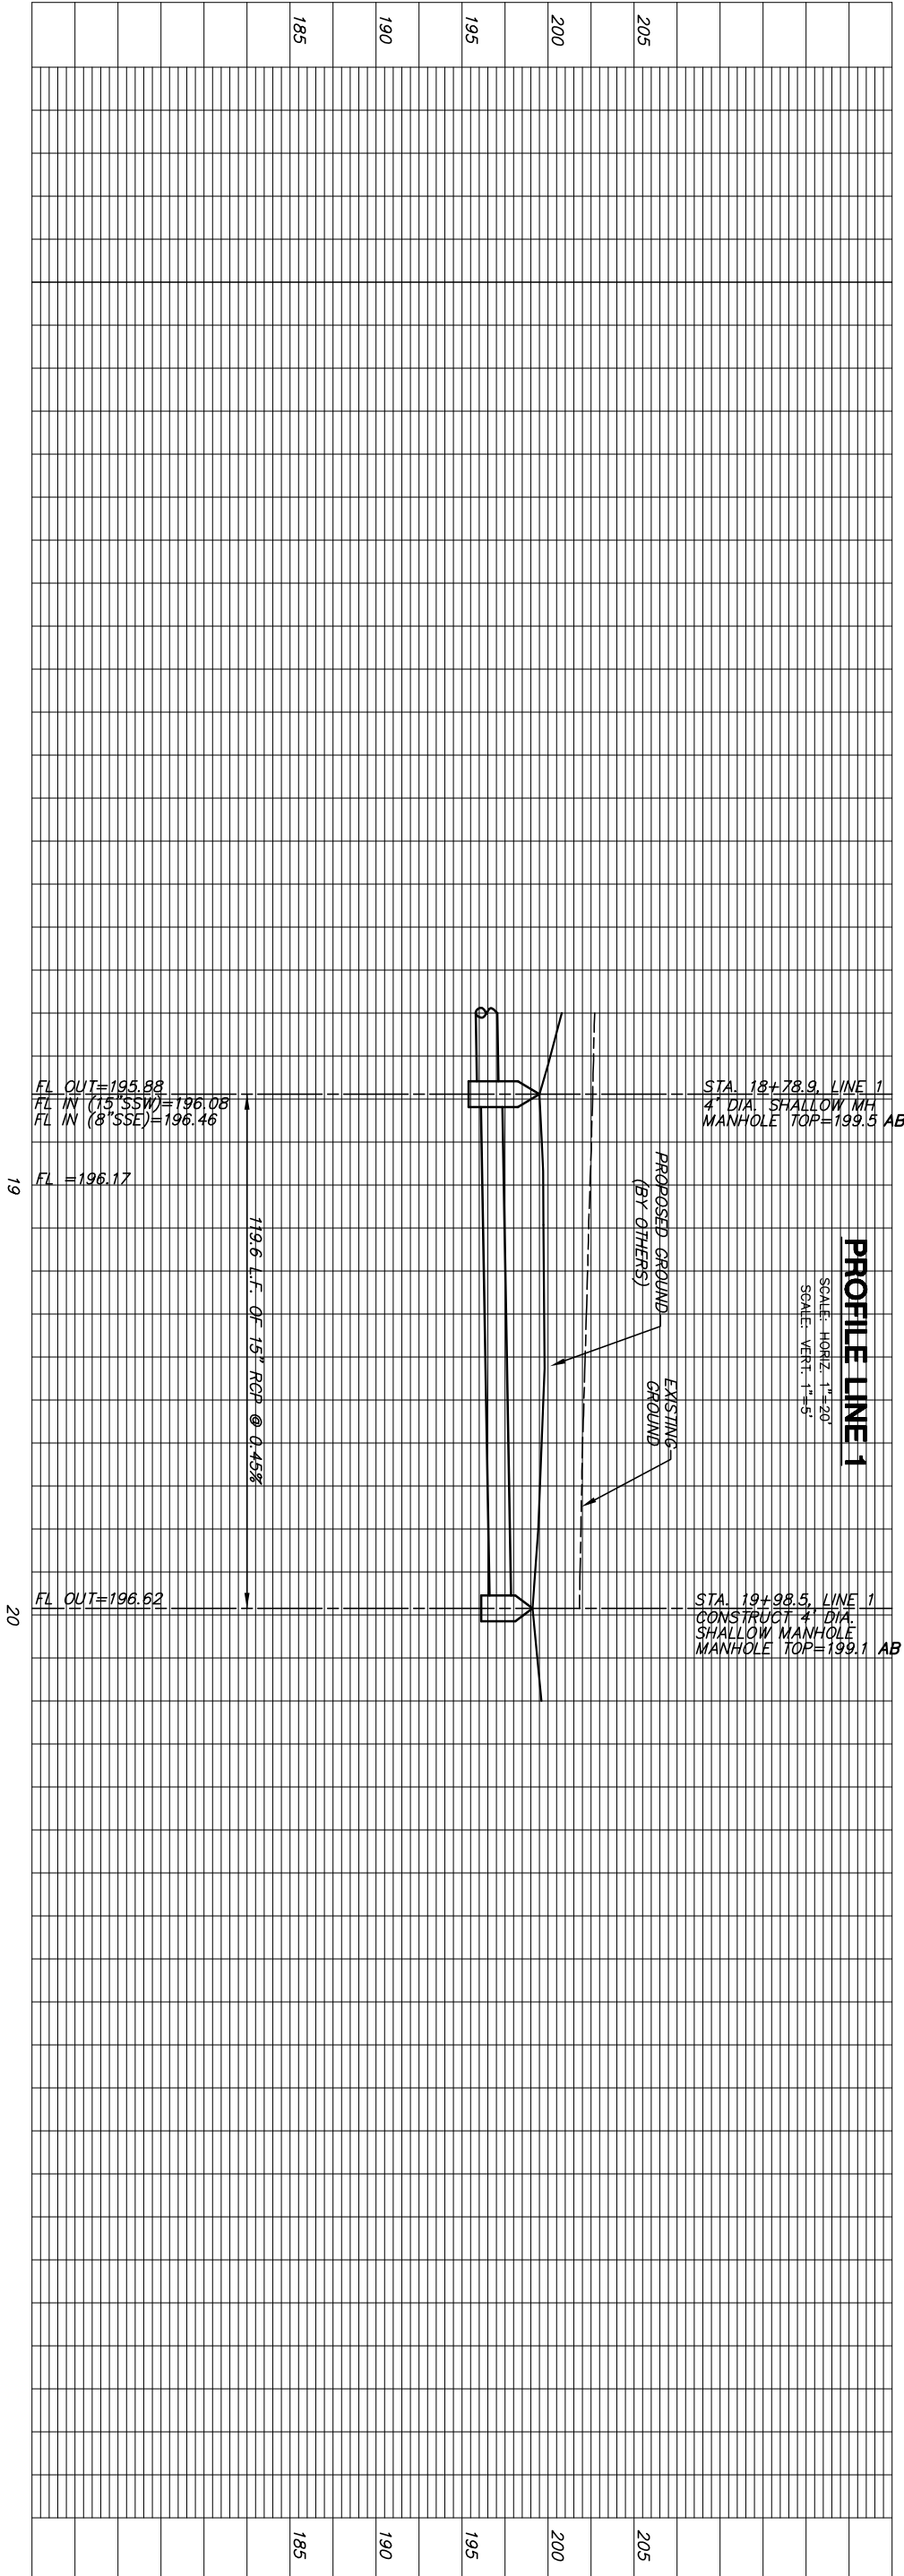

J:\CIVIL\064003_NE BASEBALL\DWG\SW\SW\AS-BUILT\064003\AS-BUILT.DWG

MKEEC
 ENGINEERING
 CONSULTANTS, INC.
 411 N. WEBB ROAD
 WICHITA, KS 67208
 316-684-9600

STORM WATER SEWER
NORTHEAST BASEBALL COMPLEX
PHASE 1

SHEET TITLE
LINE 1
 PROJECT NUMBER
 1853PPS

DESIGN BY
 JTC
 DRAWN BY
 DDC
 CHECKED BY
 GJA

ISSUED
 August 2008
 REVISED

SHEET NO.
6 of 17