


PHOTOMETRICS PLAN

SCALE: 1"=20'

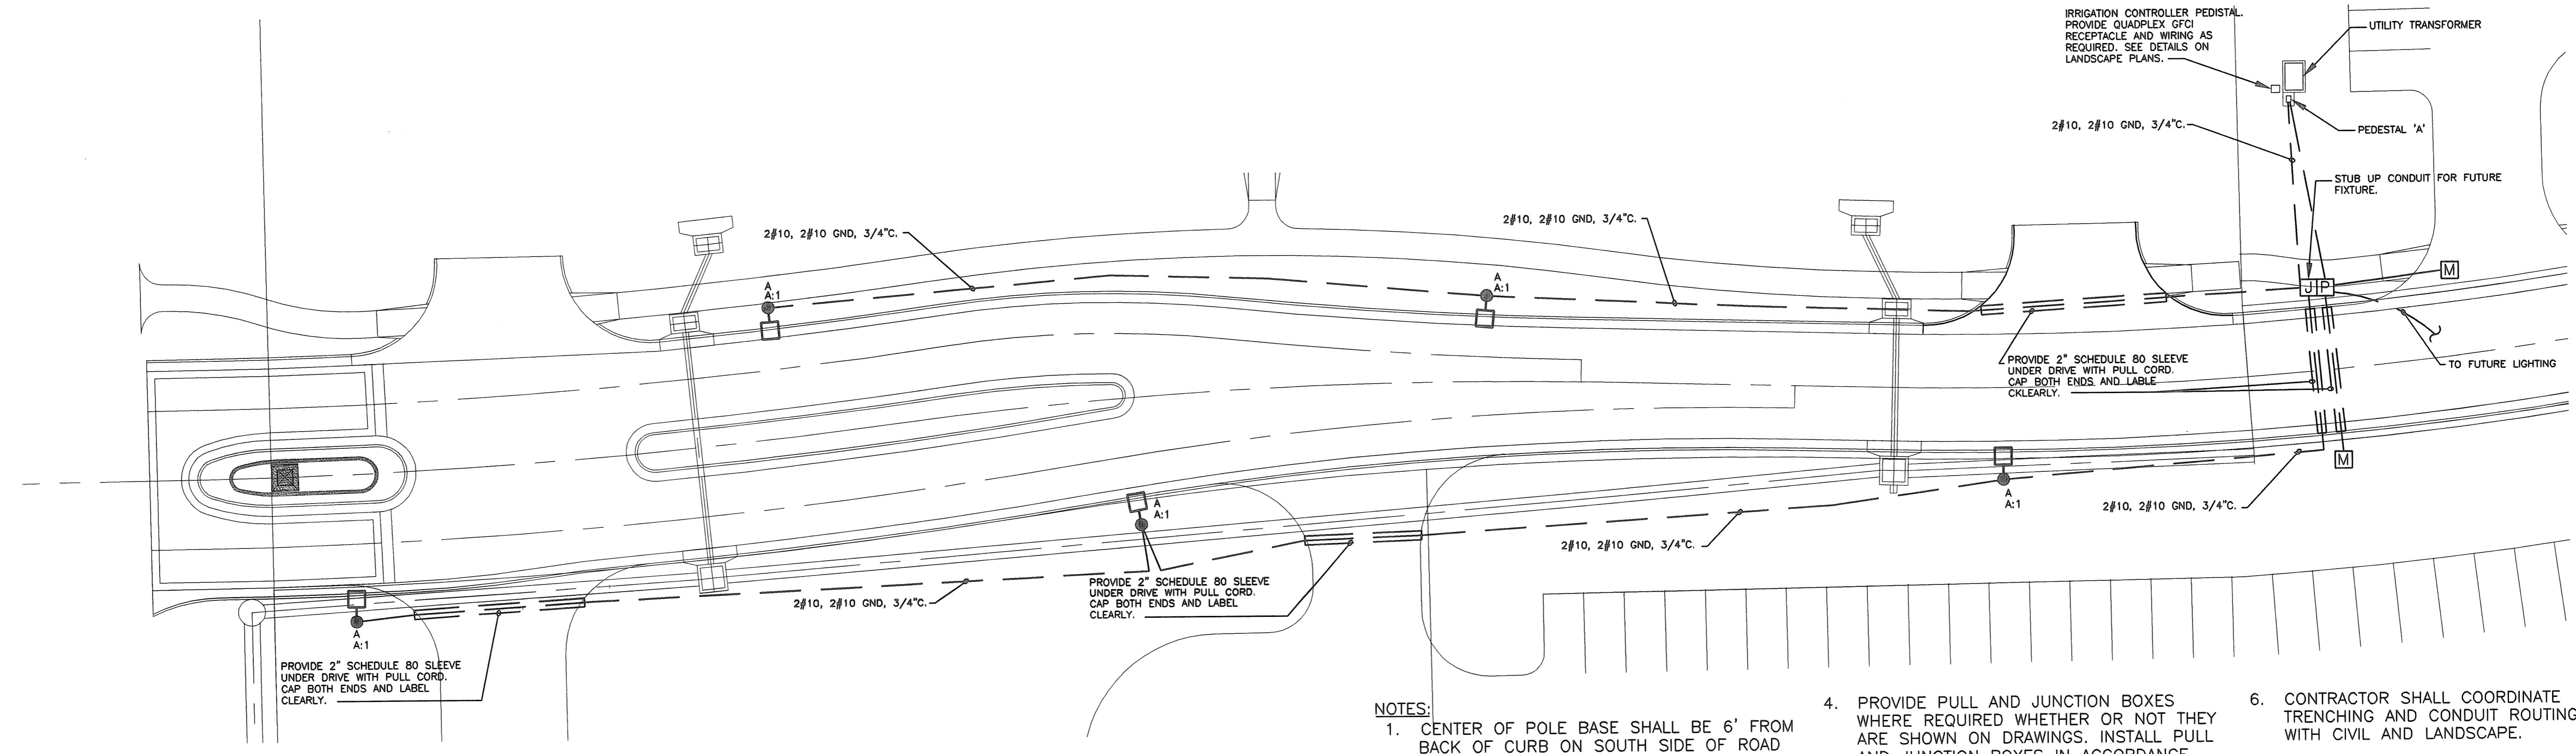


SITE LIGHTING PLAN

SCALE: 1"=20'

LEGEND:
 LIGHT FIXTURE
 UNDERGROUND ELECTRICAL

- NOTES:**
- CENTER OF POLE BASE SHALL BE 6' FROM BACK OF CURB ON SOUTH SIDE OF ROAD AND 4' FROM BACK ON CURB ON NORTH SIDE OF ROAD.
 - LIGHT POLES TO BE PRIVATELY MAINTAINED.
 - EXISTING UNDERGROUND UTILITIES SHOWN FOR REFERENCE. ELECTRICAL INSTALLATION SHALL BE CAREFULLY COORDINATED TO NOT DISTURB EXISTING UTILITIES.
 - POWER AND SYSTEM CONDUITS CROSSING UTILITY EASEMENTS SHALL CROSS AT RIGHT ANGLES THROUGH EASEMENTS. COORDINATE CROSSING LOCATIONS AND DEPTHS WITH UTILITY COMPANIES.
 - PROVIDE PULL AND JUNCTION BOXES WHERE REQUIRED WHETHER OR NOT THEY ARE SHOWN ON DRAWINGS. INSTALL PULL AND JUNCTION BOXES IN ACCORDANCE WITH MANUFACTURER'S INSTRUCTIONS. LABEL ALL BOXES. SPLICES ARE NOT ALLOWED IN BOX.
 - CONTRACTOR SHALL COORDINATE TRENCHING AND CONDUIT ROUTING WITH CIVIL AND LANDSCAPE.

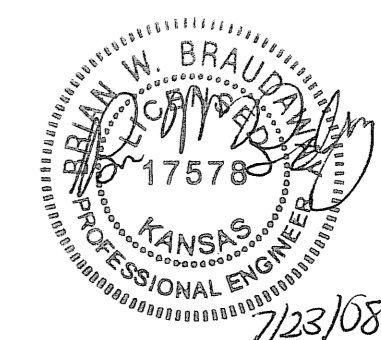

PHOTOMETRICS AND SITE LIGHTING PLAN
SHEET TITLE
472-84644
PROJECT NUMBER

DESIGN BY: AJR
DRAWN BY: JJW
CHECKED BY: BWB

ISSUED: July 2008
REVISED:

SHEET NO. 4 of 8

PLOTTED: Wednesday, July 23, 2008 @ 10:12AM