



STORM WATER DRAIN #344
THE MOORINGS TENTH
ADDITION

GRADING PLANS
SHEET TITLE
468-84468
PROJECT NUMBER


MKEC
DESIGN BY
RKO
DRAWN BY
GJA
CHECKED BY

ISSUED
August 2008
REVISED

SHEET NO.
5 of 17

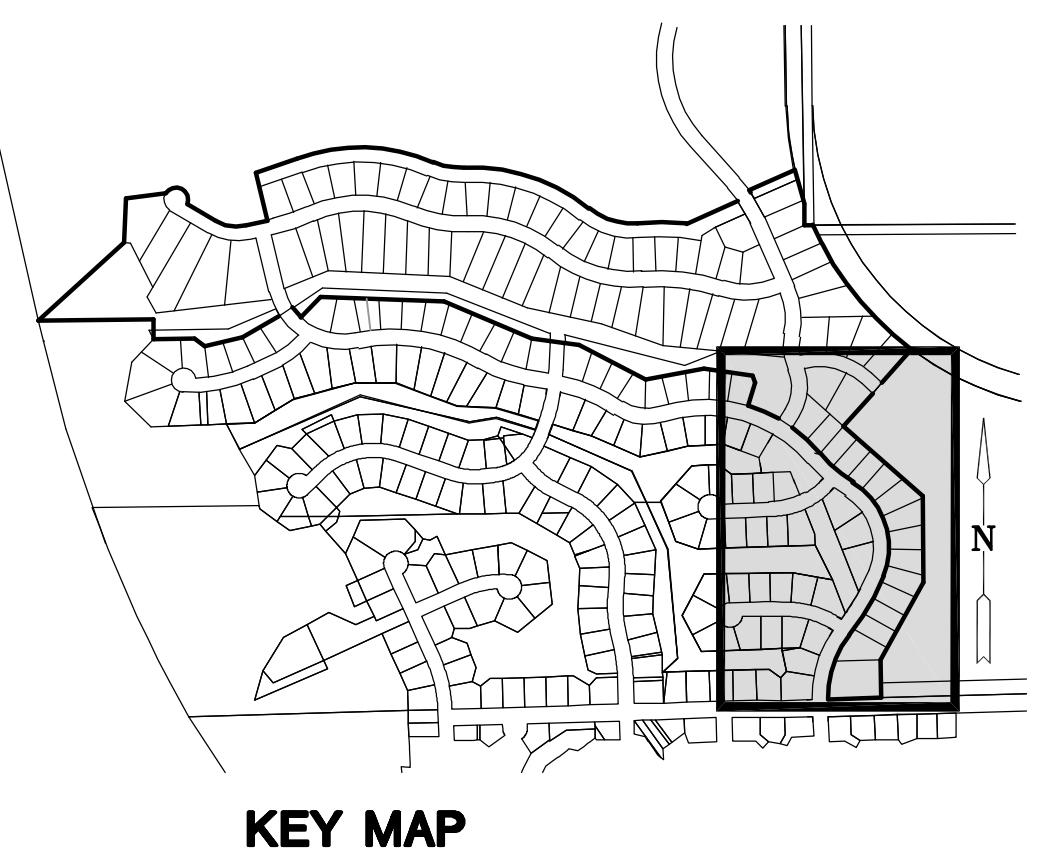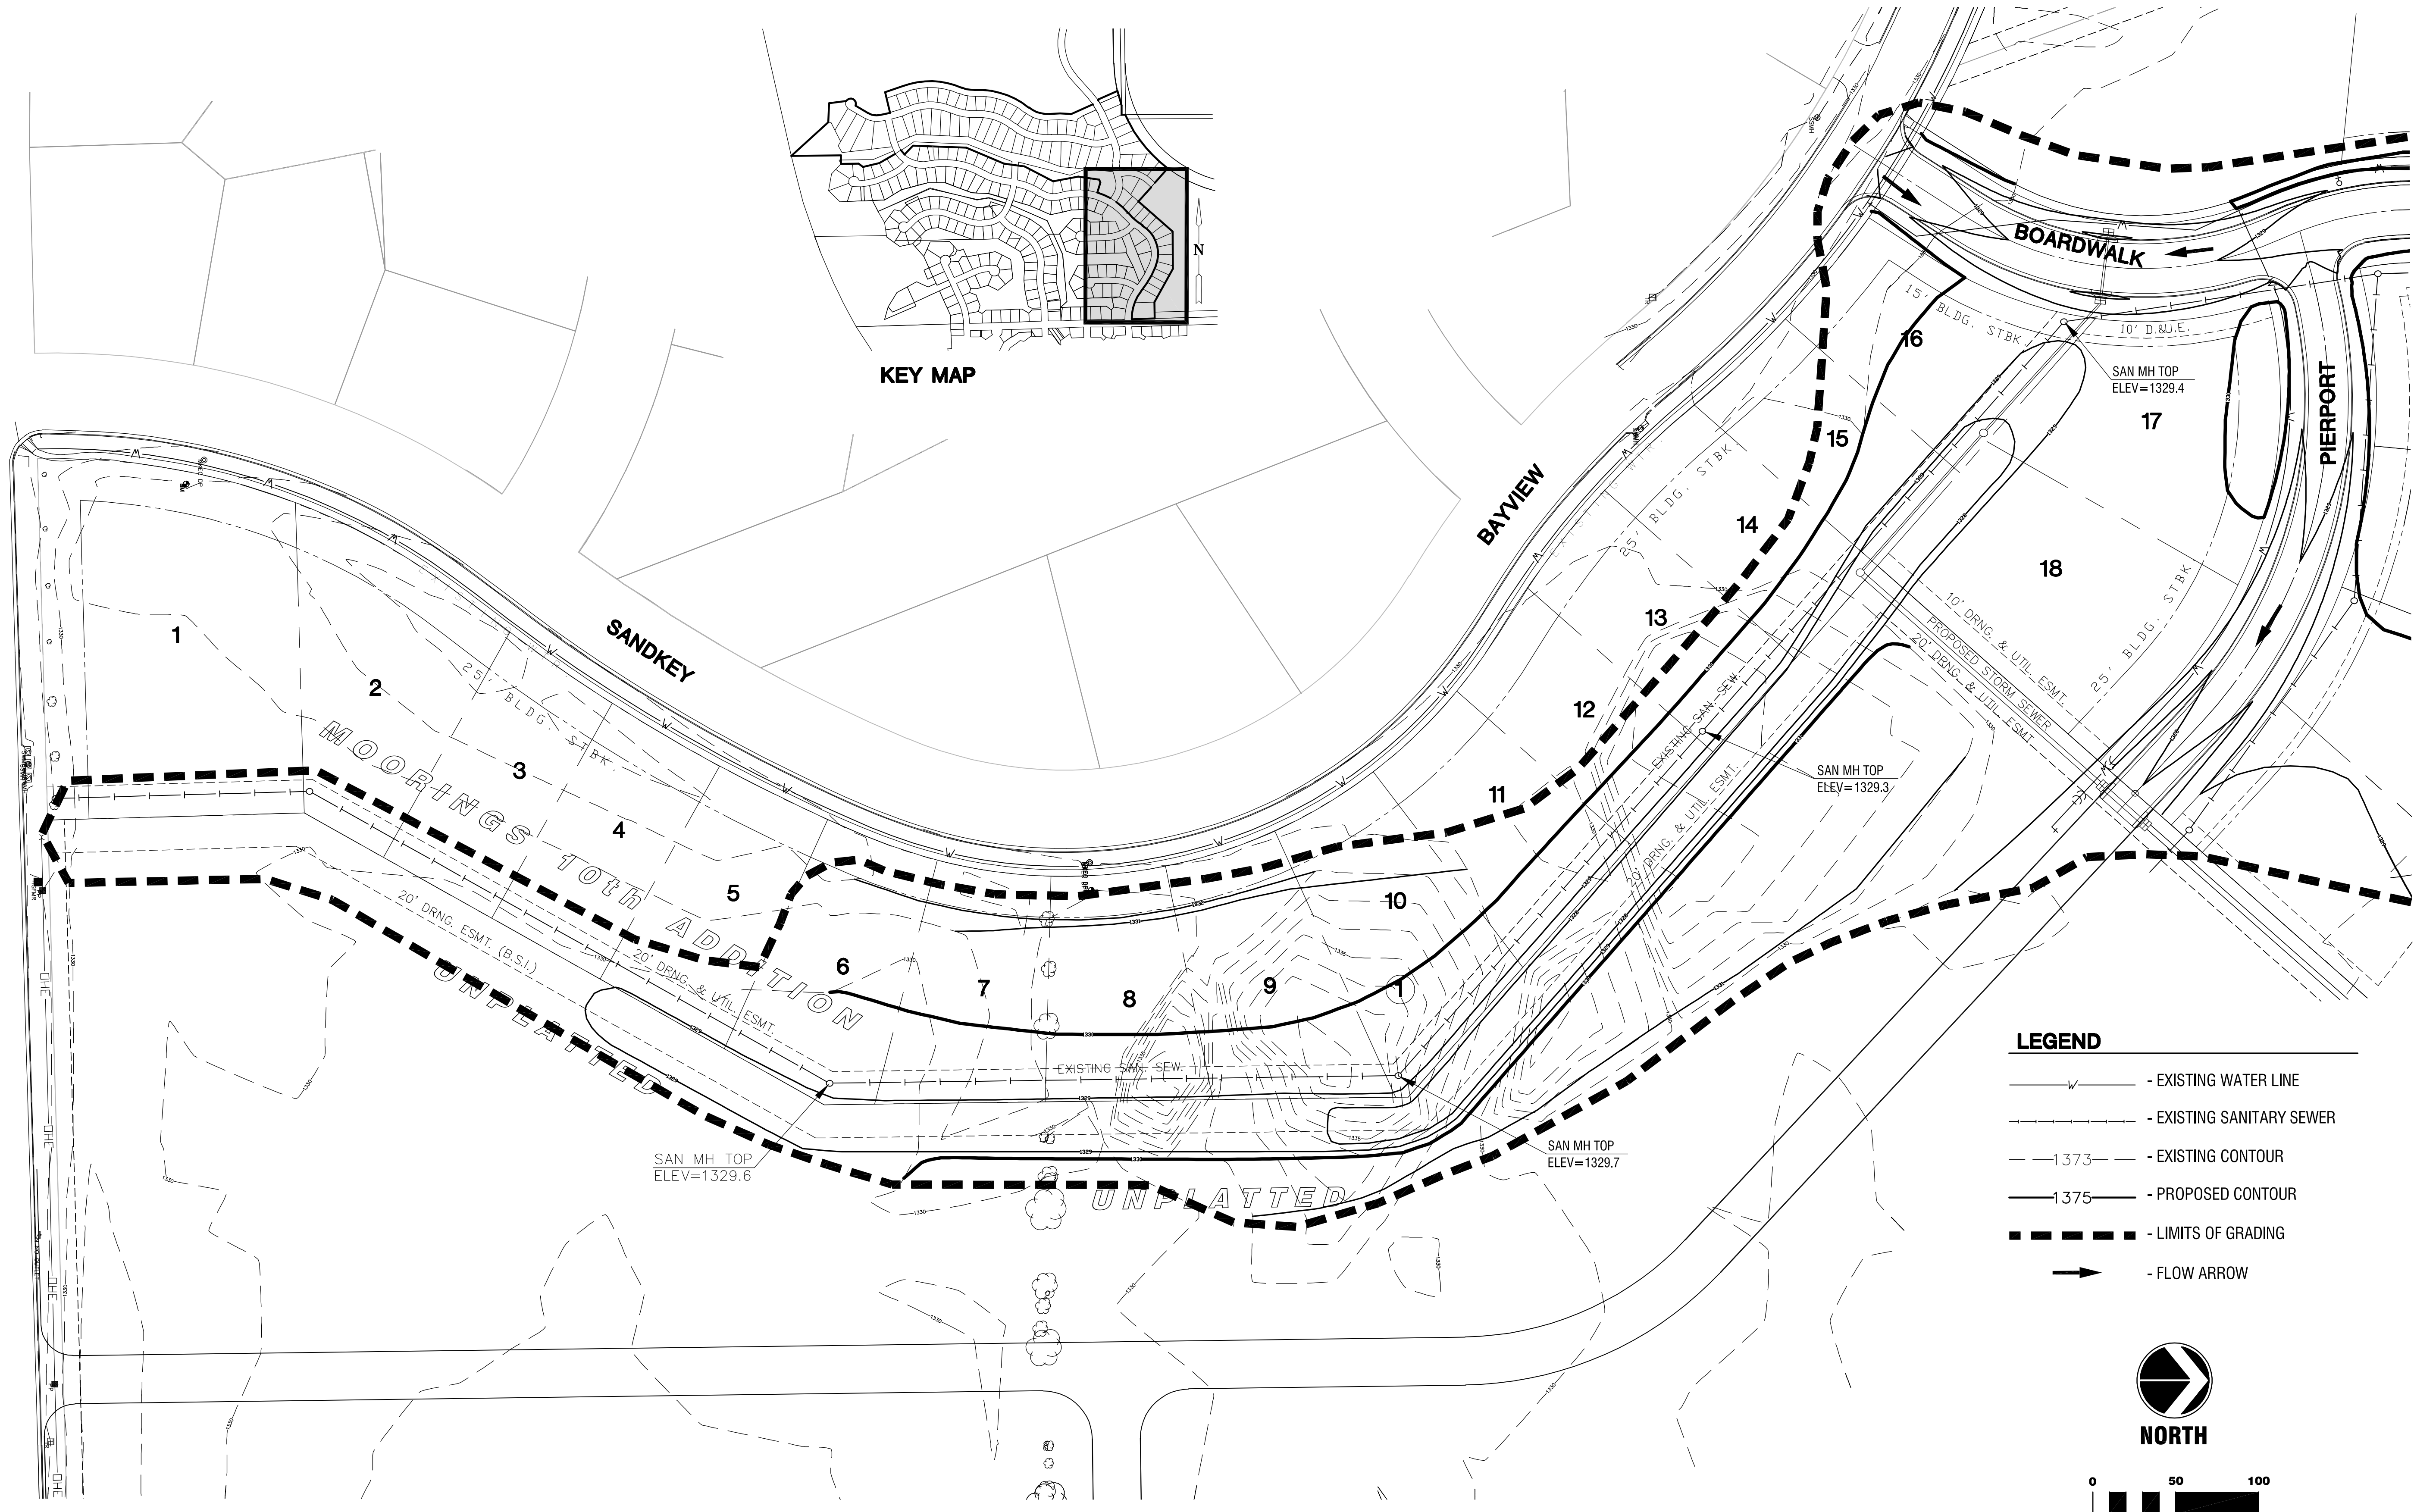

- LEGEND**
- - - - - EXISTING WATER LINE
 - - - - - EXISTING SANITARY SEWER
 - - - - - 1373 - EXISTING CONTOUR
 - - - - - 1375 - PROPOSED CONTOUR
 - - - - - LIMITS OF GRADING
 - - FLOW ARROW

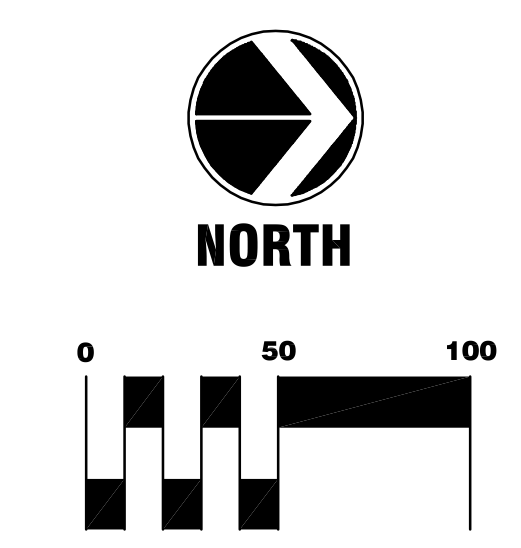

PLOTTED: Tuesday, September 16, 2008 @ 08:54AM

J:\CIVIL\06608\DWG\GRADE\10THADDITION\06608_G4.DWG