


**STORM WATER DRAIN #344  
THE MOORINGS TENTH  
ADDITION**

**LOT GRADING PLANS**  
SHEET TITLE  
468-84468  
PROJECT NUMBER

MKEC  
DESIGN BY  
RKO  
DRAWN BY  
GJA  
CHECKED BY

ISSUED  
August 2008  
REVISED

SHEET NO.  
9 of 17

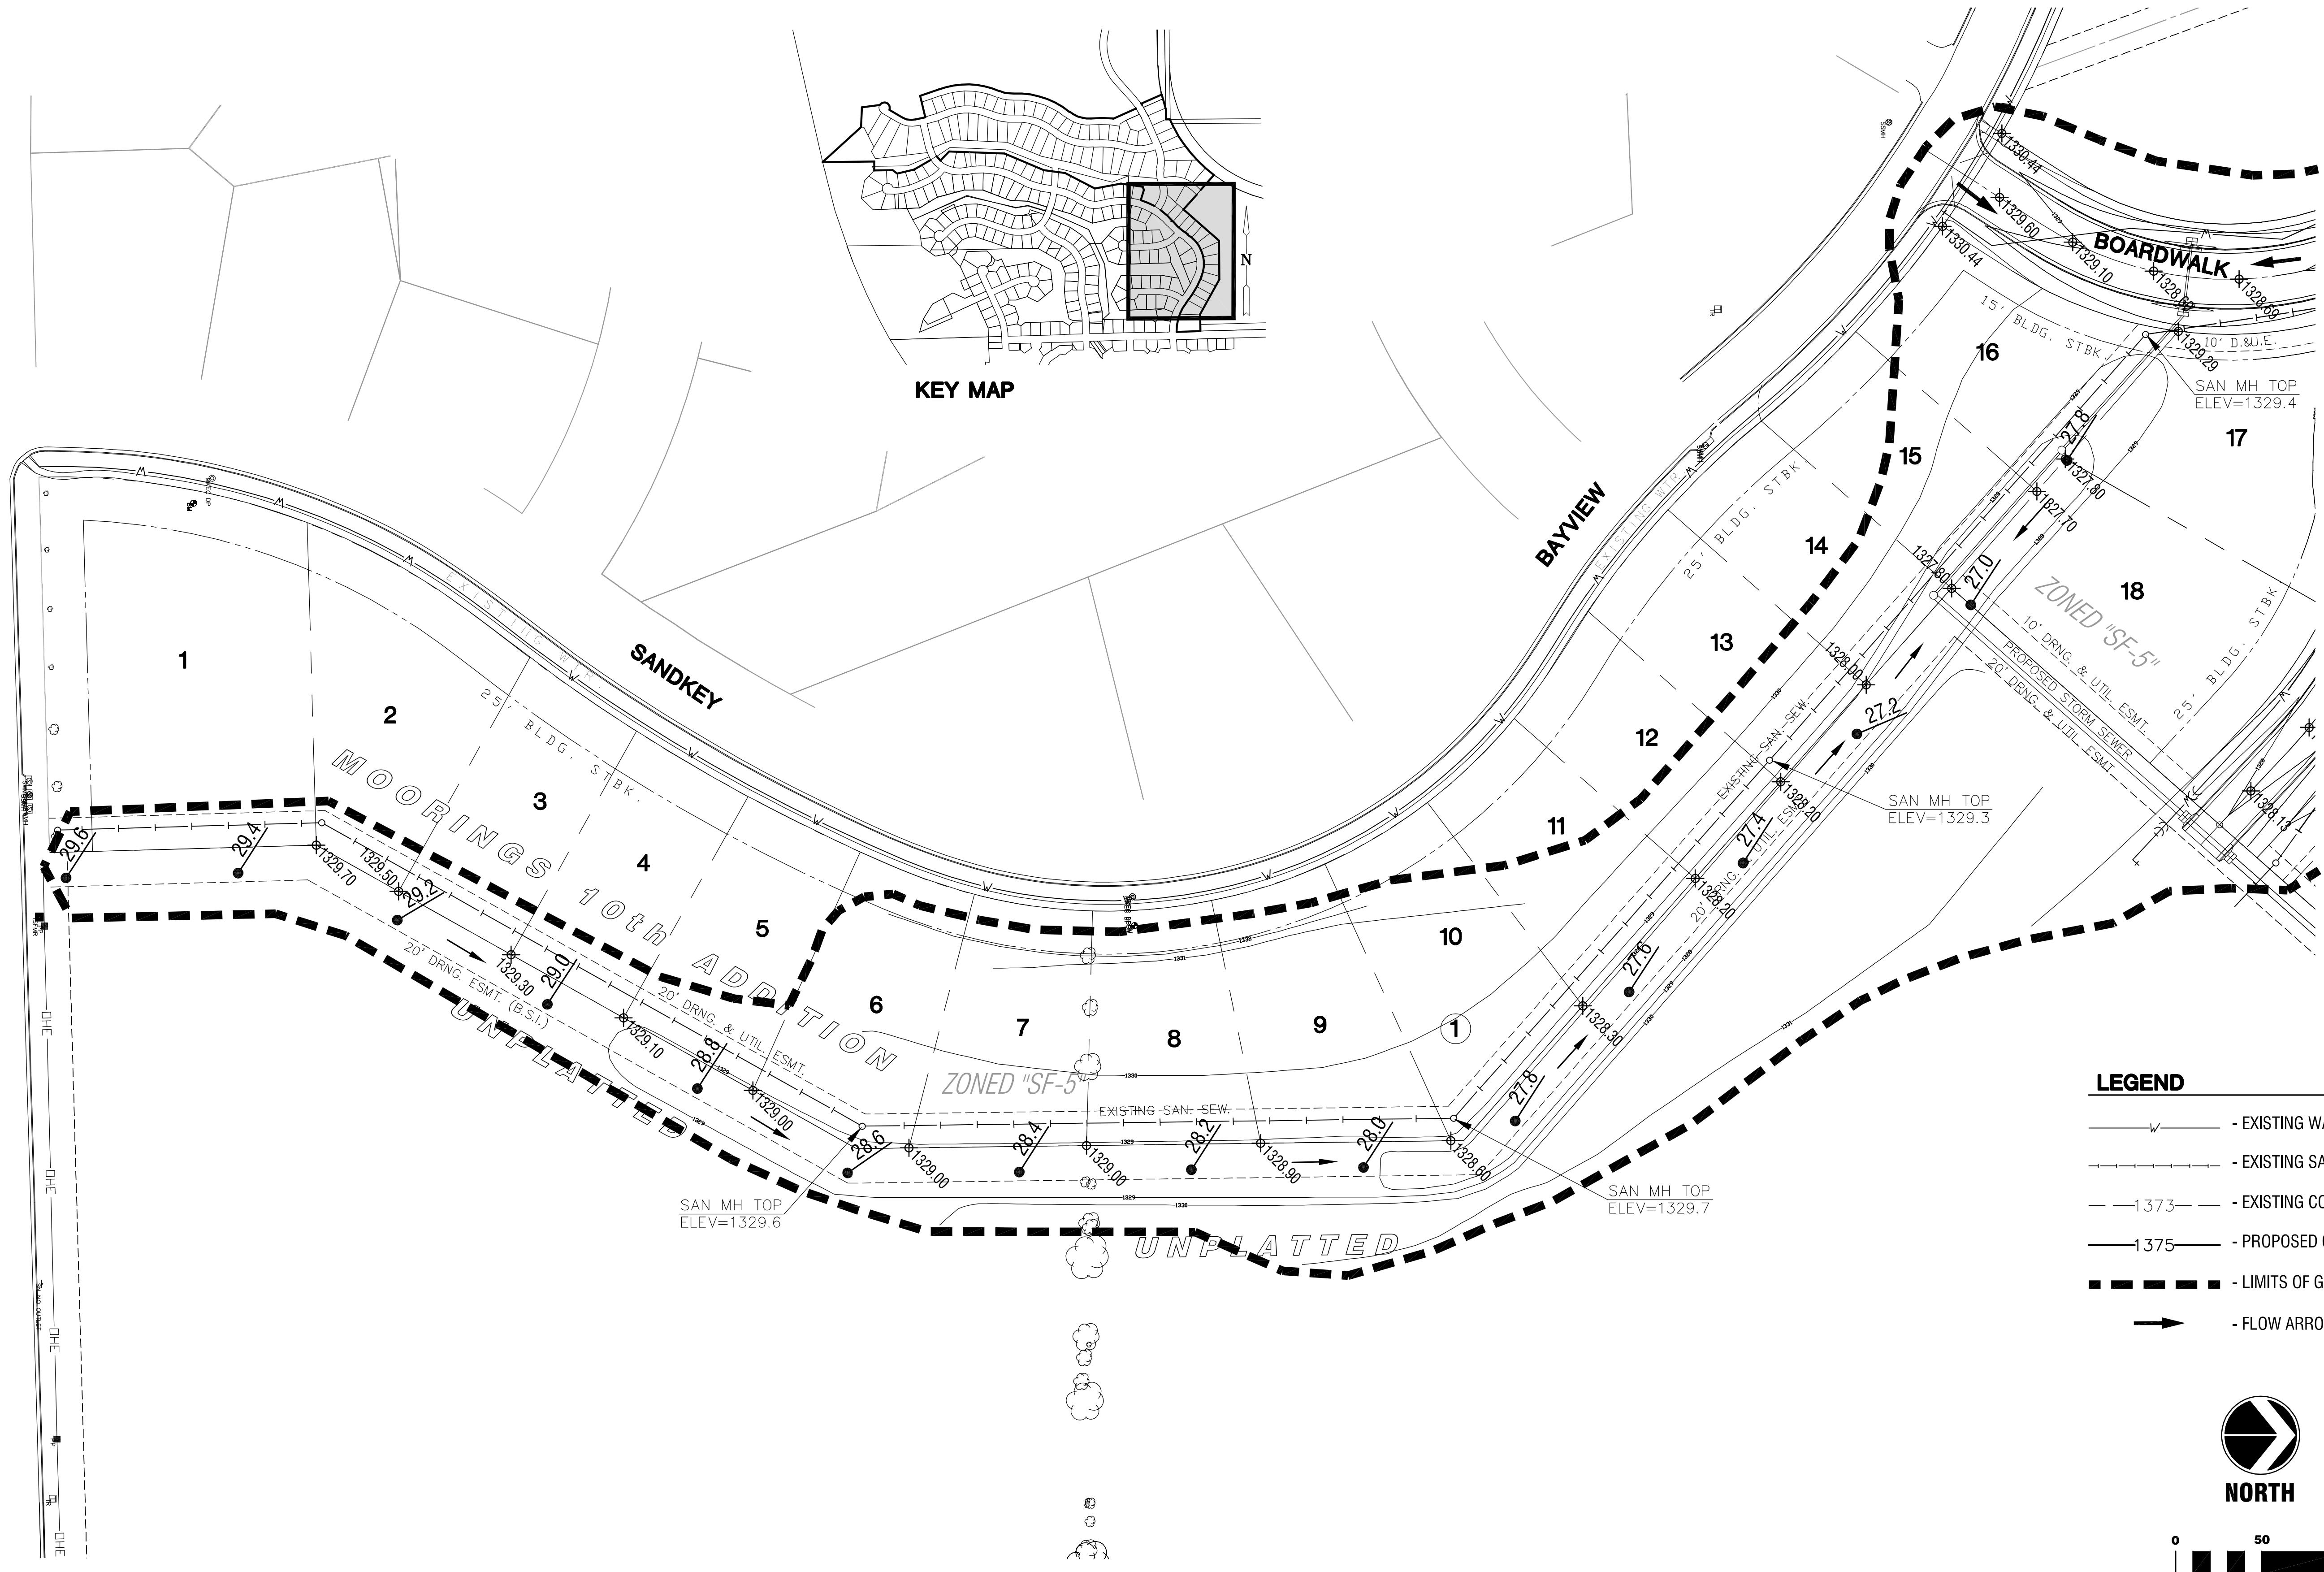

- LEGEND**
- EXISTING WATER LINE
  - EXISTING SANITARY SEWER
  - EXISTING CONTOUR
  - PROPOSED CONTOUR
  - LIMITS OF GRADING
  - FLOW ARROW

