

STATE	PROJECT NO.	YEAR	SHEET NO.	TOTAL SHEETS
KANSAS	448-90308	2008	1	13

# 20" WATER LINE ON HOOVER

## 23rd STREET NORTH to 25th STREET NORTH

### WATER LINE PROJECT NO. 448-90308

### O.C.A. No. 735378

#### INDEX OF SHEETS


TITLE SHEET	1
GENERAL NOTES	2
CITY OF WICHITA STANDARDS	3 - 4
PROPOSED WATER LINE PLAN & PROFILE	5 - 6
EROSION CONTROL DETAILS	7 - 9
TRAFFIC CONTROL STANDARDS	10 - 13

#### LEGEND


- W --- Existing Water Line
- E --- Existing Electric Line
- NG --- Existing Gas Line
- T --- Existing Telephone Line
- TV --- Existing Cable TV Line
- Existing Right-of-Way
- Power Pole
- E.M. Electric Meter
- ◀-◀ Luminaire
- ☼ Yard Light
- ☐ Pull Box
- ☒ Signal Control Box
- M.A. Mast Arm
- P.M.S. Pedestal Mounted Signal
- T.M.H. Telephone Manhole
- ☐ Telephone Pedestal
- ☐ PHONE Telephone
- ☐ Cable Television Box
- ▶ W.V. Water Valve
- W.M. Water Meter
- ☉ Fire Hydrant
- S.H. Sprinkler Head
- ▶ I.C.V. Irrigation Control Valve
- A.R. Air Release
- G.M.S. Gas Monitoring Station
- G.M. Gas Meter
- G.T.S. Gas Testing Station
- G.F.C. Gas Filler Cap
- S.S.M.H. Sanitary Sewer Manhole

BY	DATE

\$(getvar, "dwgprefix")\$(getvar, "dwgname"), Plotted\$(edtime, "O, MON DD, ", YYYY - H:M:Am/pm)  
 Plotted By : danavarr  
 File : g:\W107\0024\Road\G-COV-001.dgn

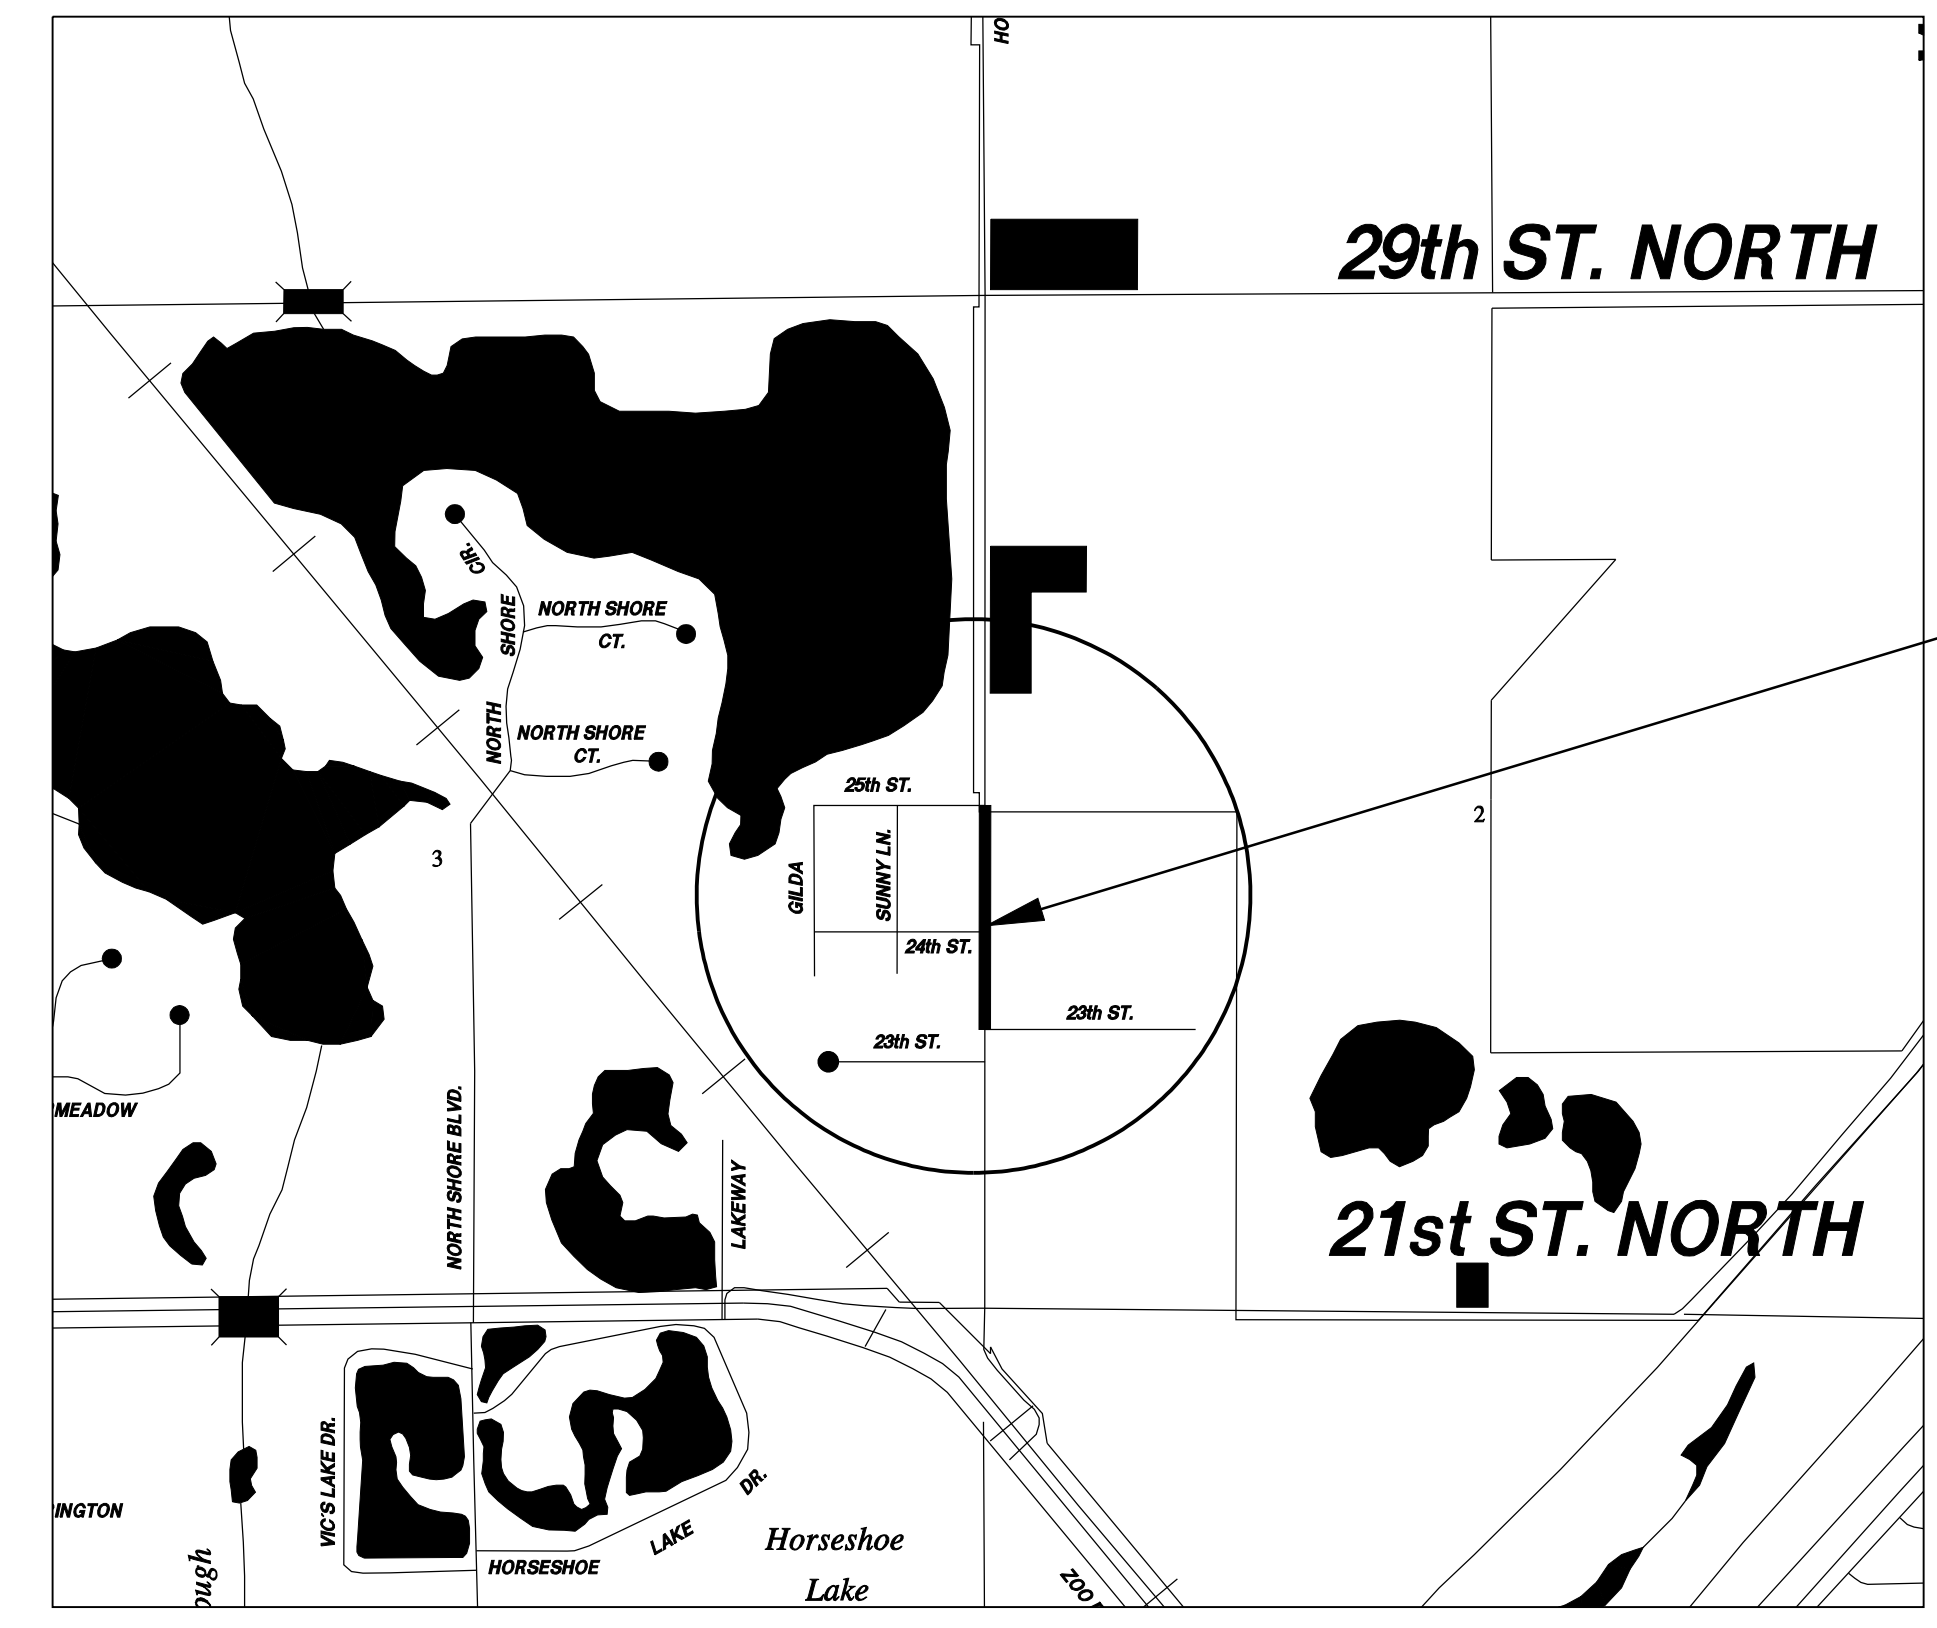

**Project Map**  
Not to Scale

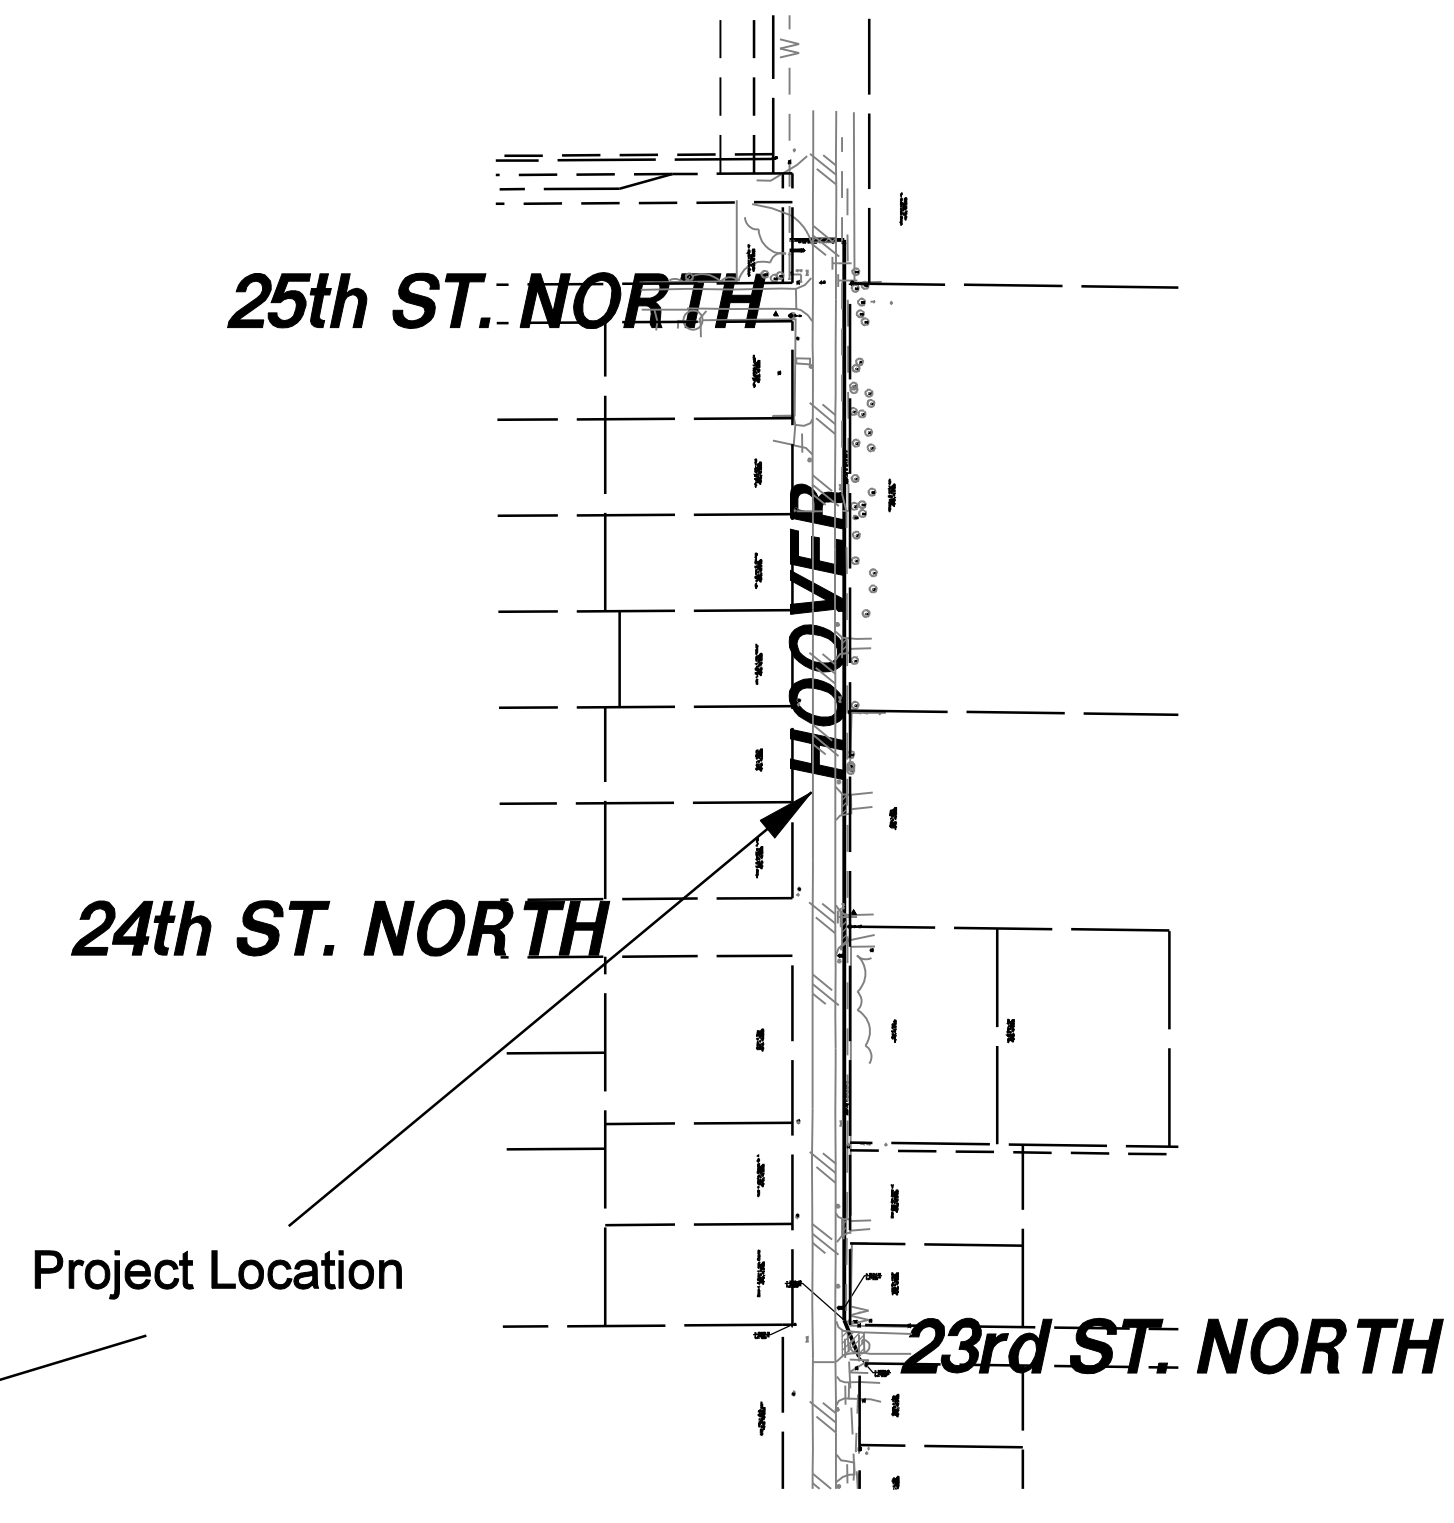

**Vicinity Map**

NOT TO SCALE

**CITY OF WICHITA, KANSAS**  
 James L. Armour, P.E. City Engineer  
**AUGUST, 2008**

APPROVED - DATE
PUBLIC WORKS DIRECTOR CITY OF WICHITA

245 N. Waco, Suite 222  
 Wichita, KS 67202  
 Main: 316-303-3000  
 Fax: 316-303-0156