




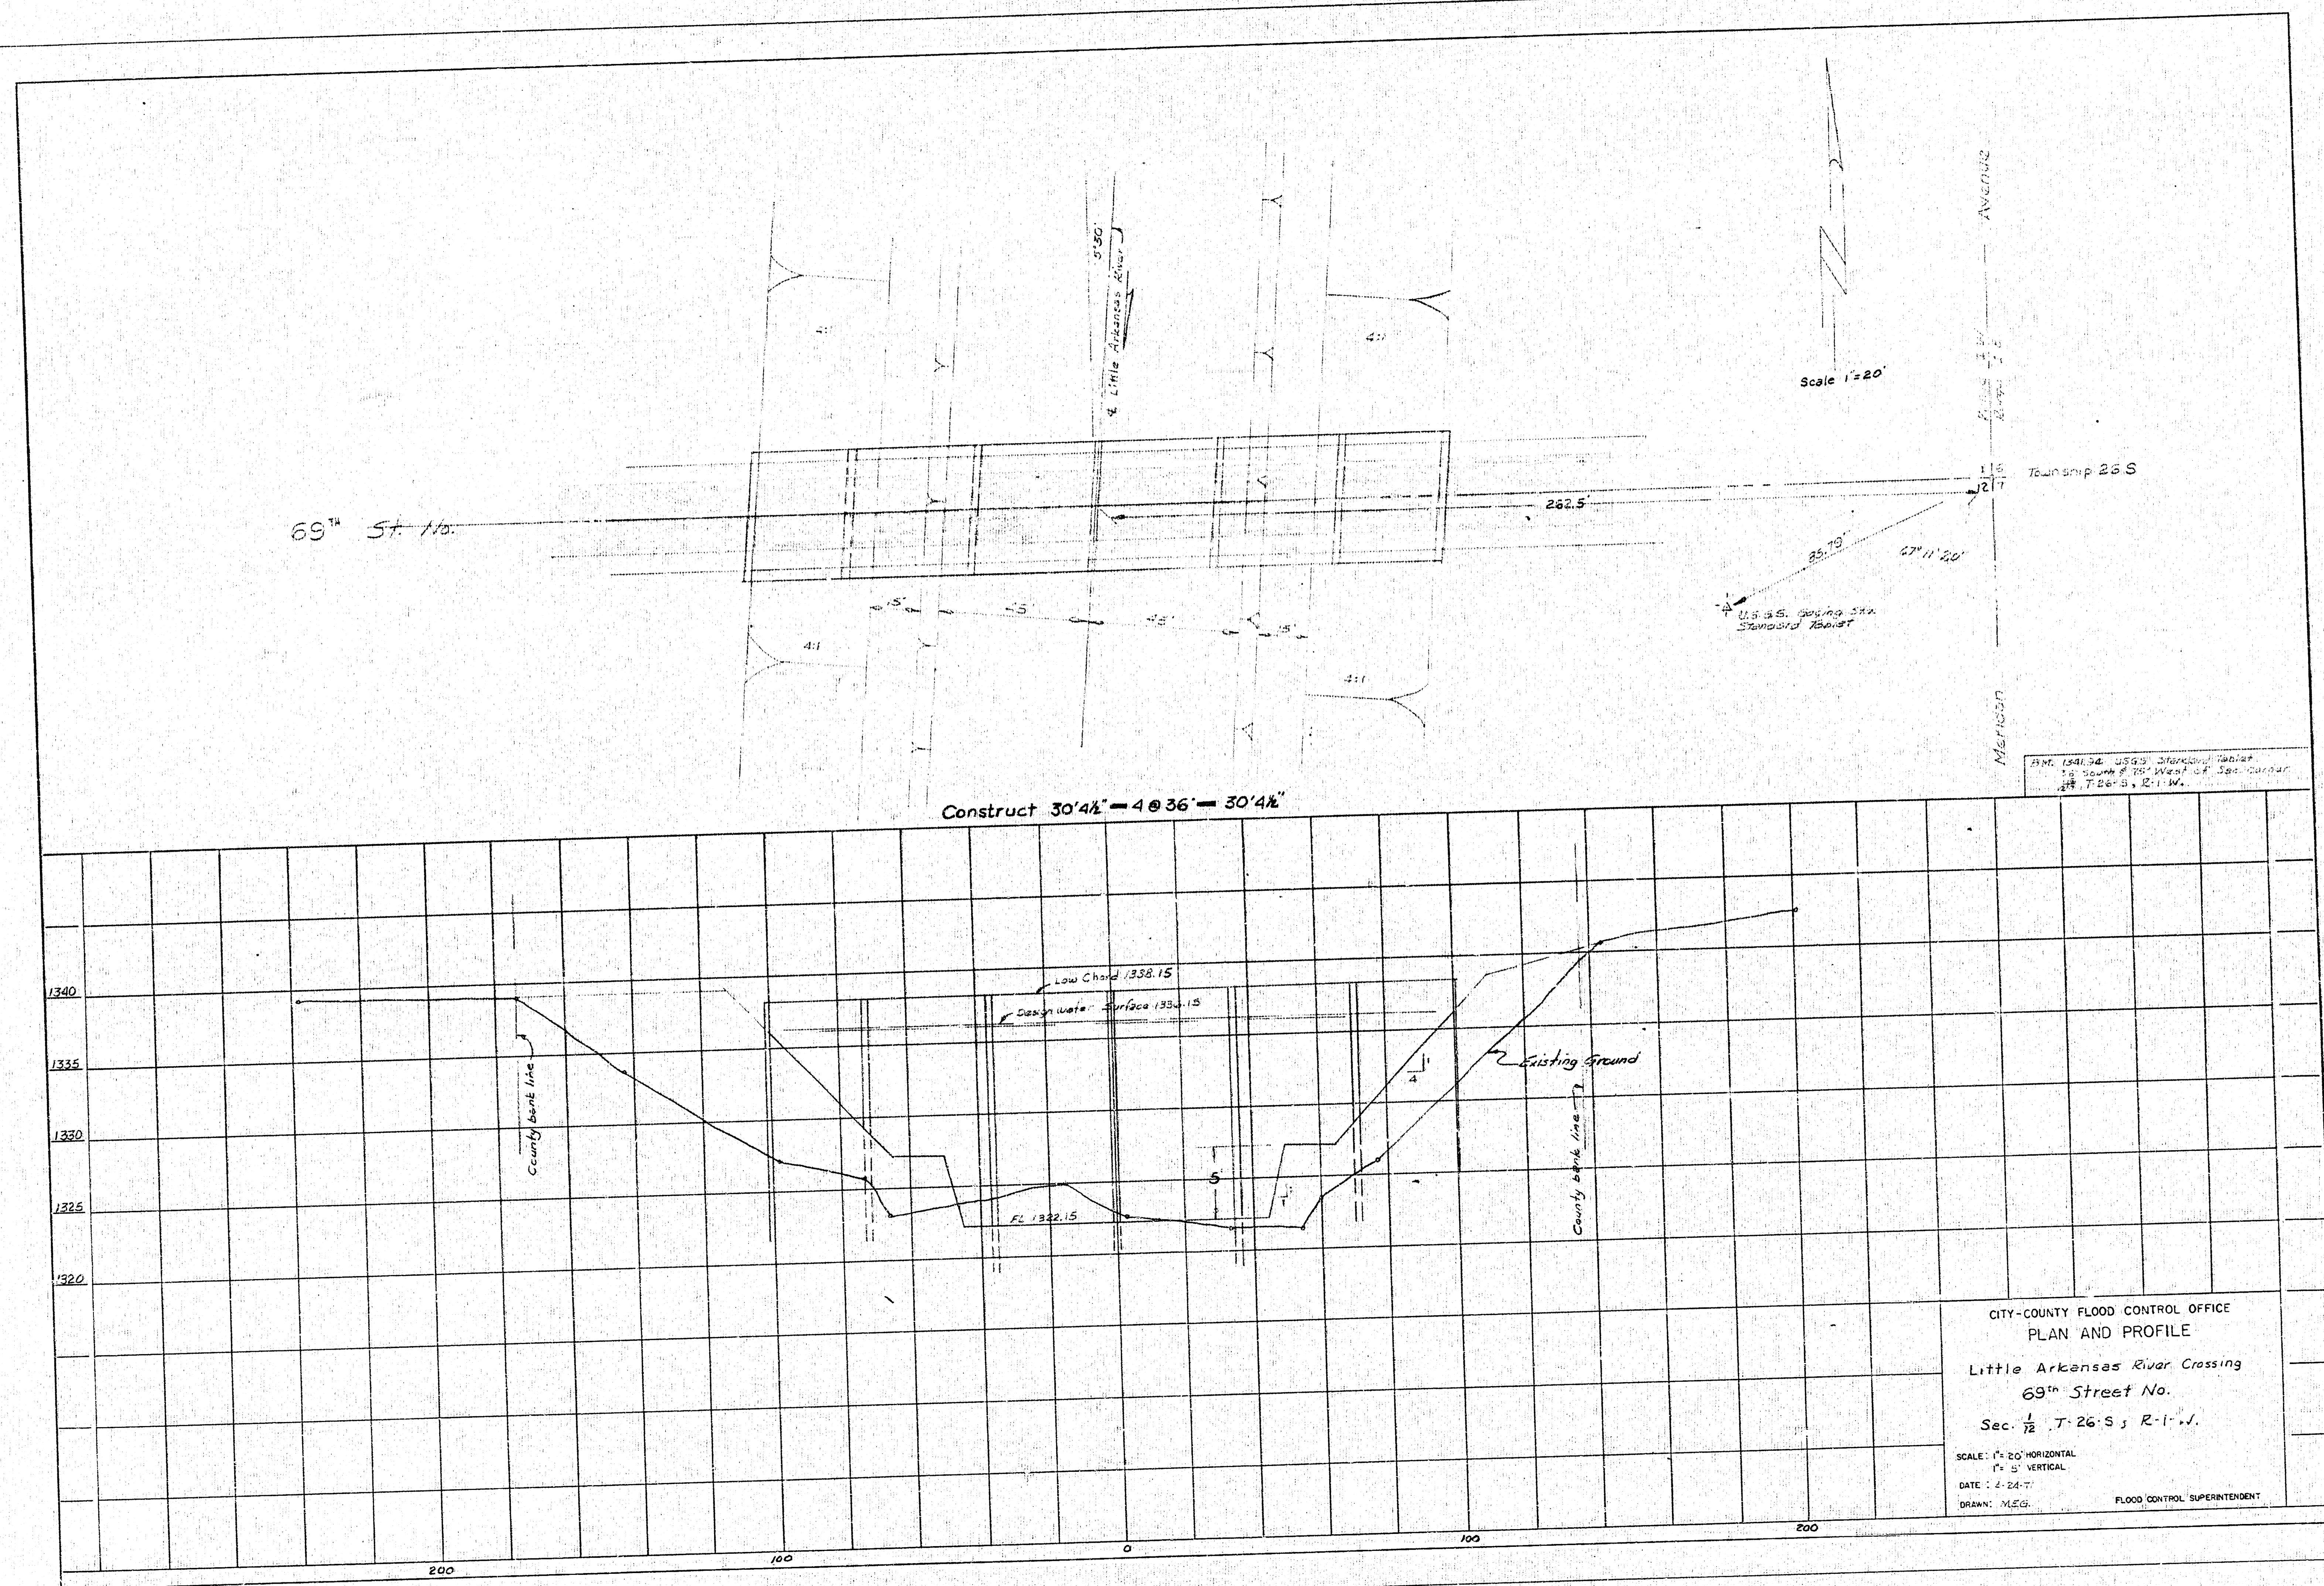

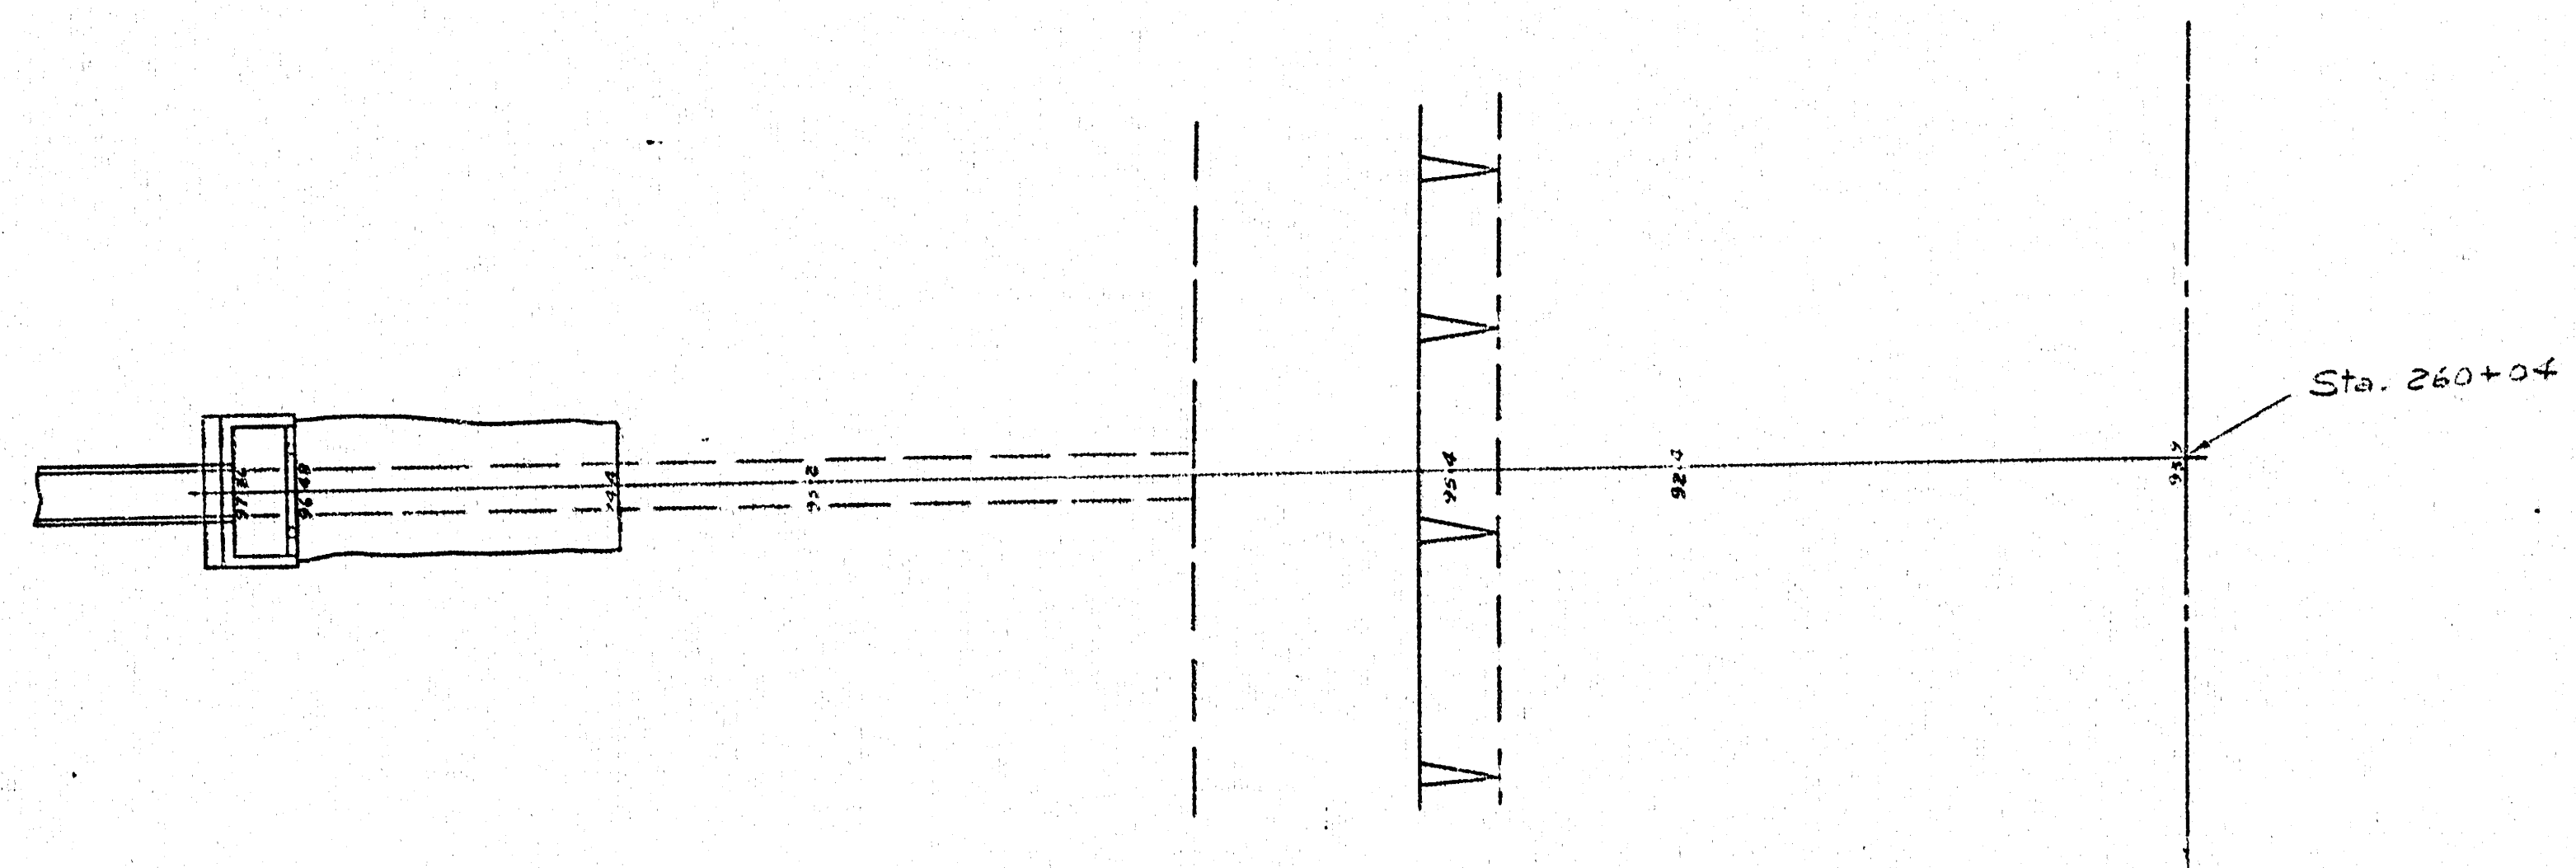

FCBM
 □ On curb NE Cor
 23rd St & Porter
 Elev 1311.45

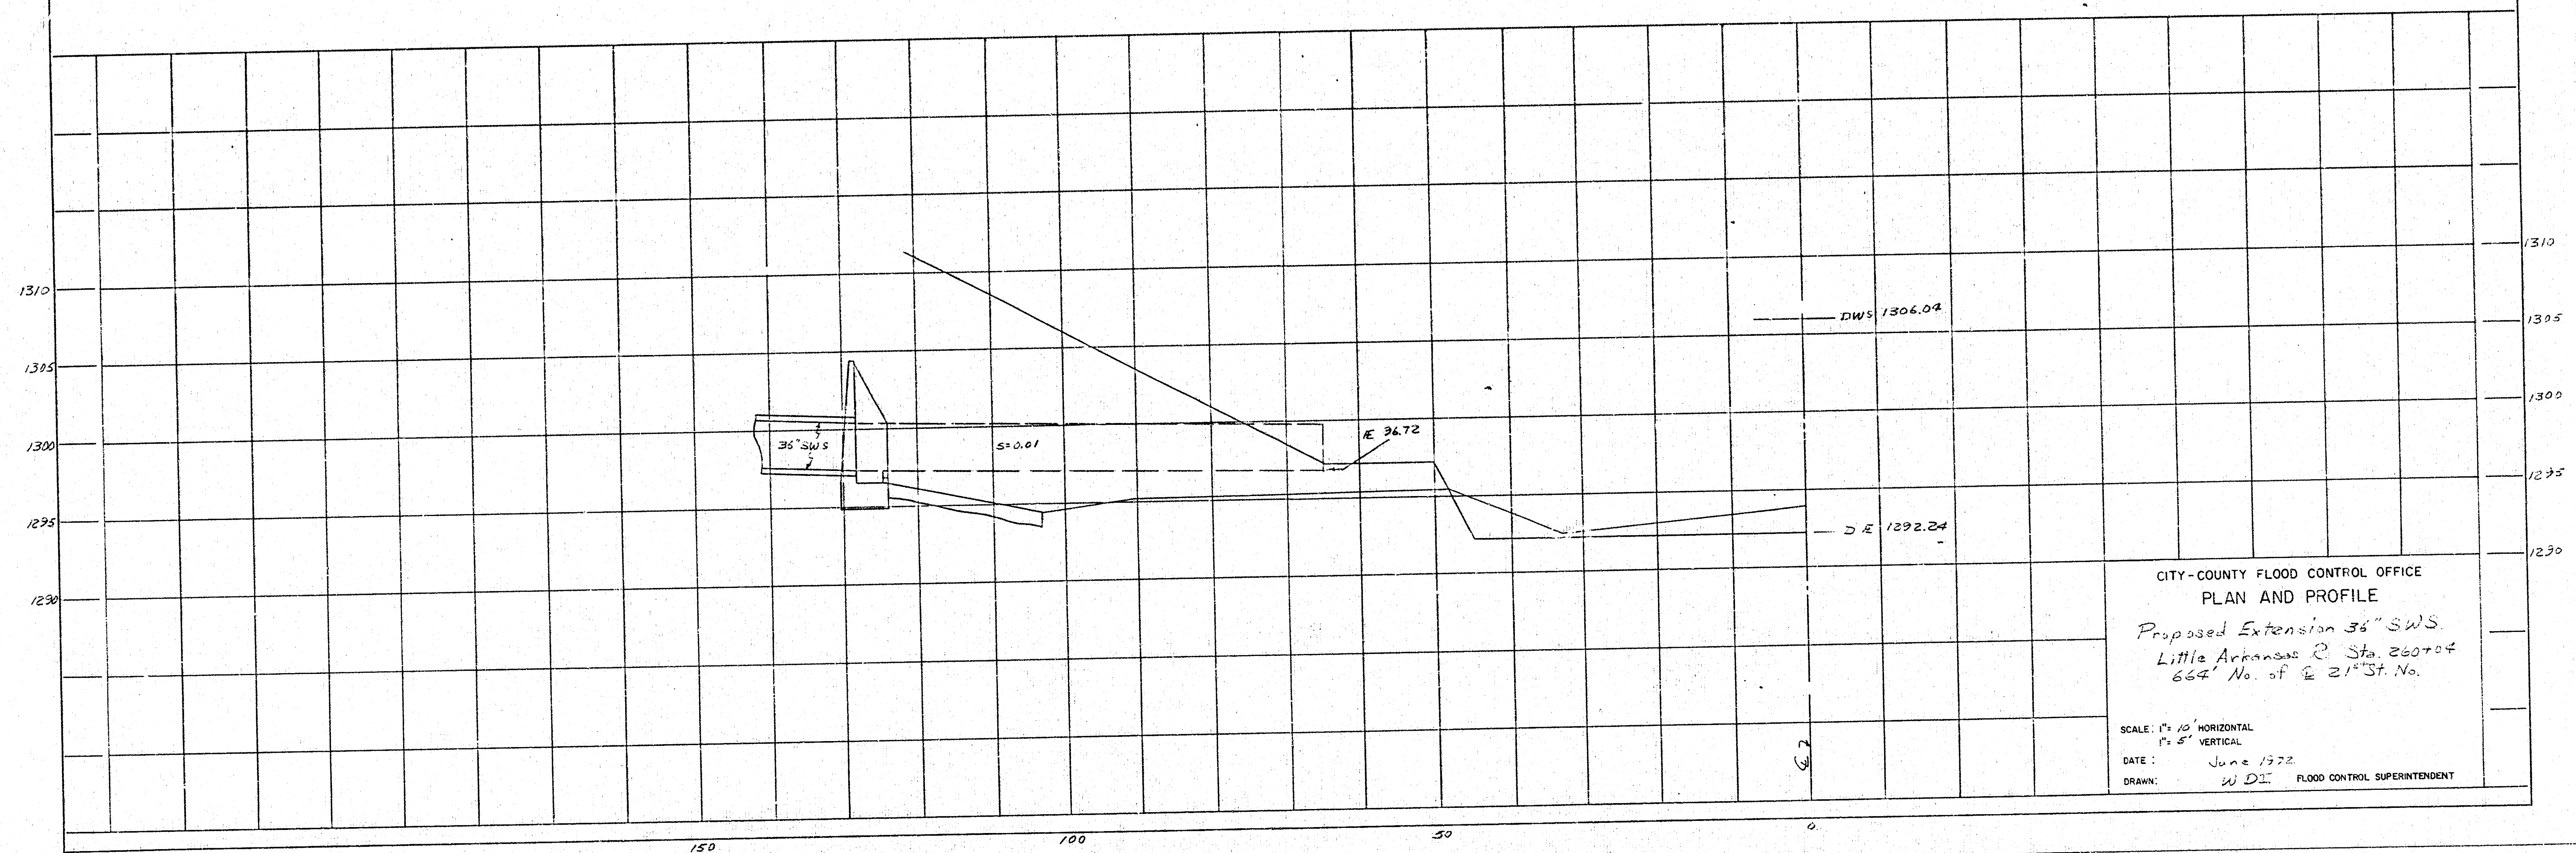

CITY-COUNTY FLOOD CONTROL OFFICE
 PLAN AND PROFILE
 Proposed Extension 36" SWS
 Little Arkansas R Sta. 260+04
 664' No. of E 21st St No.

SCALE: 1" = 10' HORIZONTAL
 1" = 5' VERTICAL
 DATE: June 1972
 DRAWN: W.D.I. FLOOD CONTROL SUPERINTENDENT



