


Saved 03-03-2009 11:50:50 AM by DK
 Plot Scale 1/20 03-05-2009 2:46:14 PM by JJK
 C:\2008\08258\Landscapes\08258-L-02-Landscape Plan605 Emporia

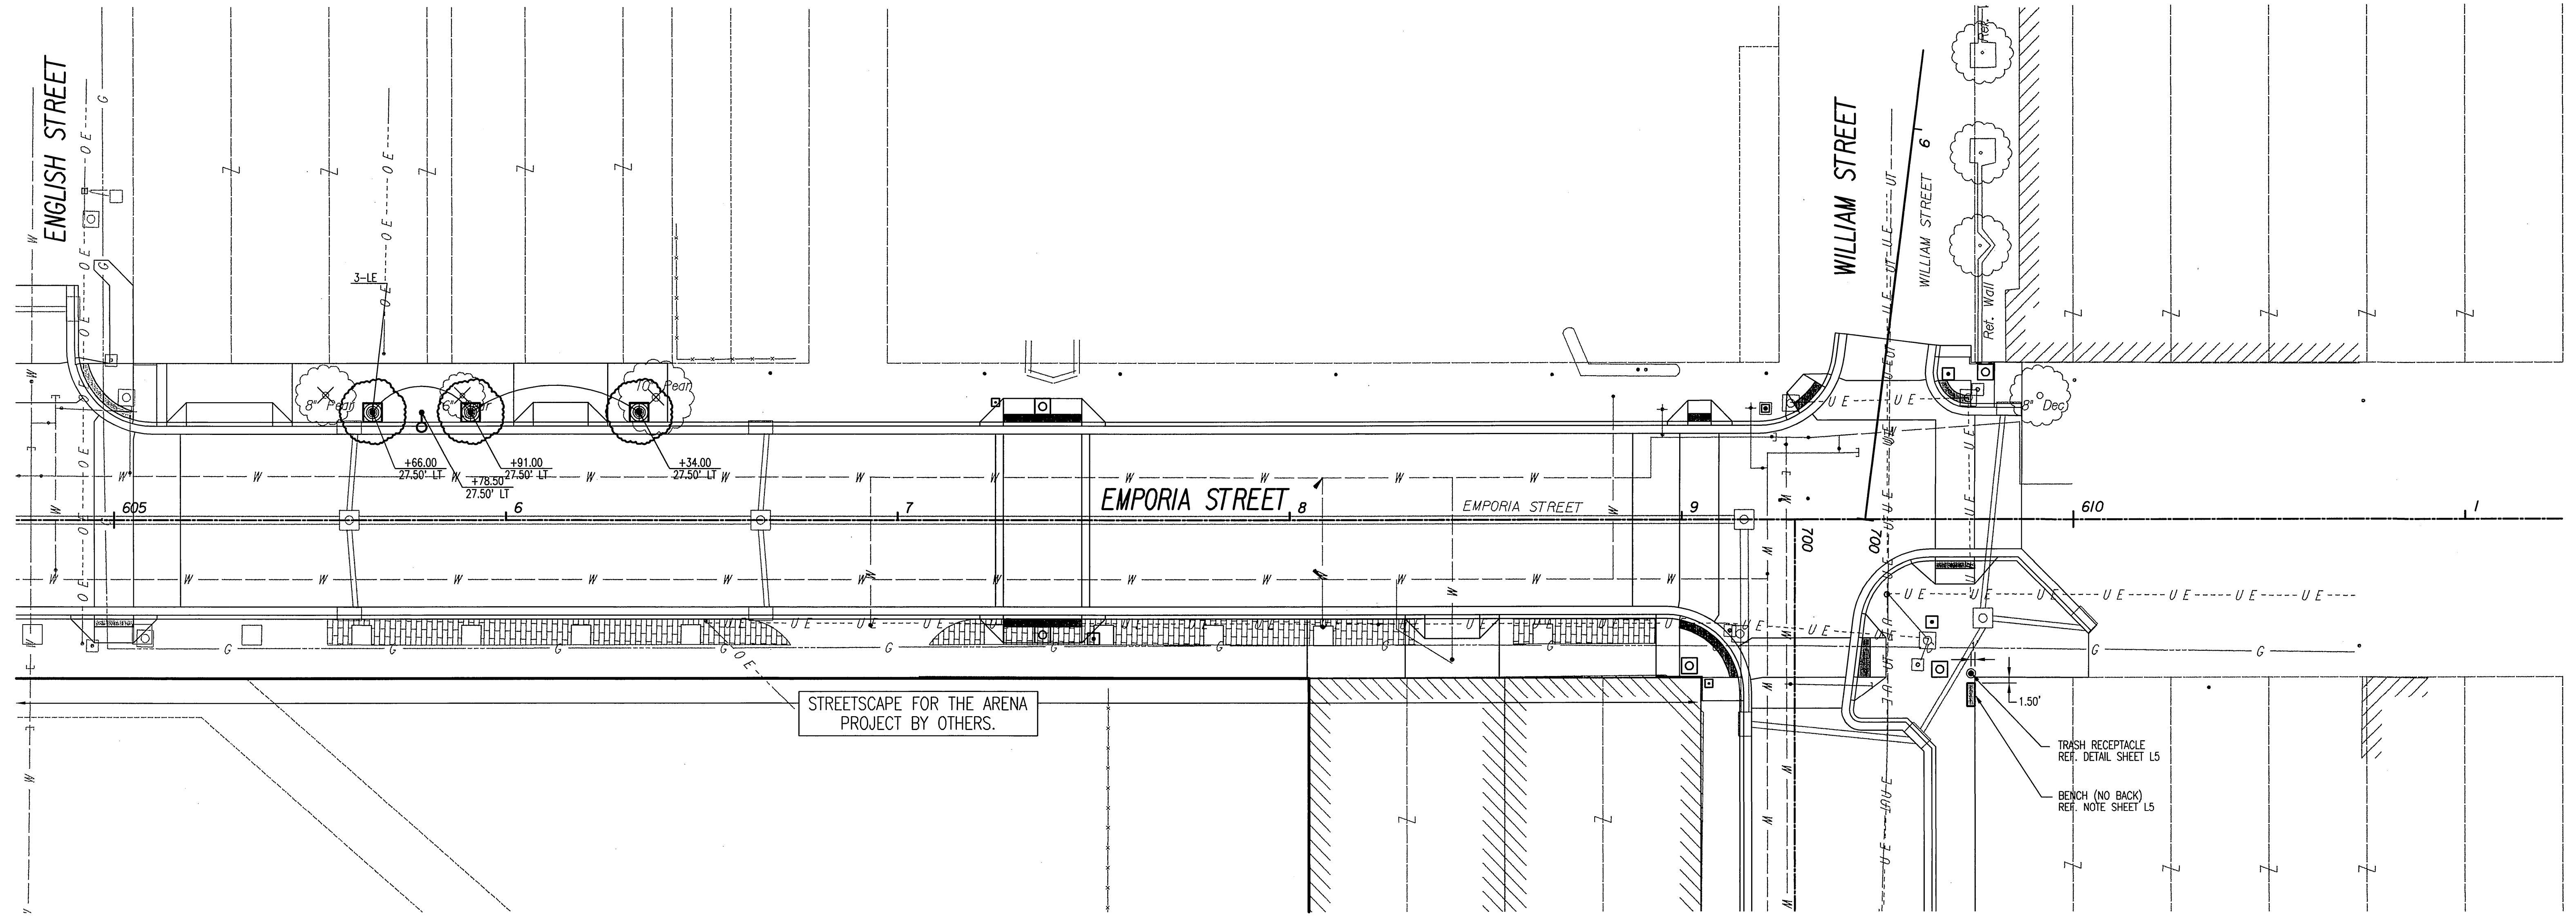




STREETSCAPE FOR THE ARENA
PROJECT BY OTHERS.

TRASH RECEPTACLE
REF. DETAIL SHEET L5

BENCH (NO BACK)
REF. NOTE SHEET L5

LEGEND

- LIGHT POLES WITH STATION AND OFFSET TO CENTER OF BASE.
(REFERENCE ELECTRICAL PLANS FOR TYPE AND DETAILS)
- TREE GRATE (STYLE: METROPOLITAN)
REF. DETAIL SHEET L5
(STATION AND OFFSET TO CENTER OF GRATE)
- TRASH RECEPTACLE. REF. DETAIL SHEET L5
- BENCH REF. NOTE SHEET L5

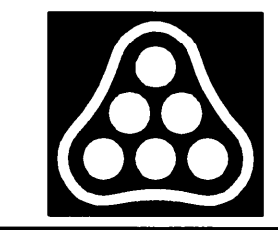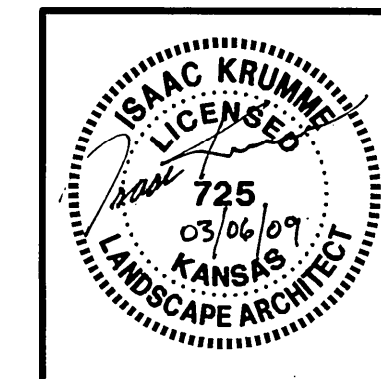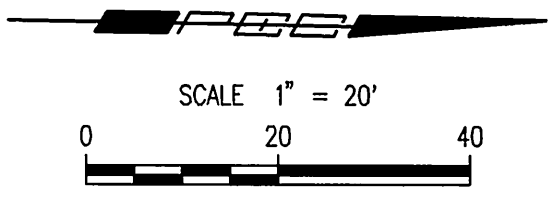

EMPORIA STREET		By	Date
LANDSCAPE PLAN			
STA. 605+00 TO STA. 611+00			
JAMES L. ARMOUR, P.E.-CITY ENGINEER CITY OF WICHITA PROJECT NO. 472-84744			
Professional Engineering Consultants, P.A. 303 S. TOPEKA • WICHITA, KANSAS 67202 316-262-2691 • FAX 316-262-3003			
Designed by	Job No. 08456	Sht. L2 of 5	
Drawn by	Date Feb., 2009		