

 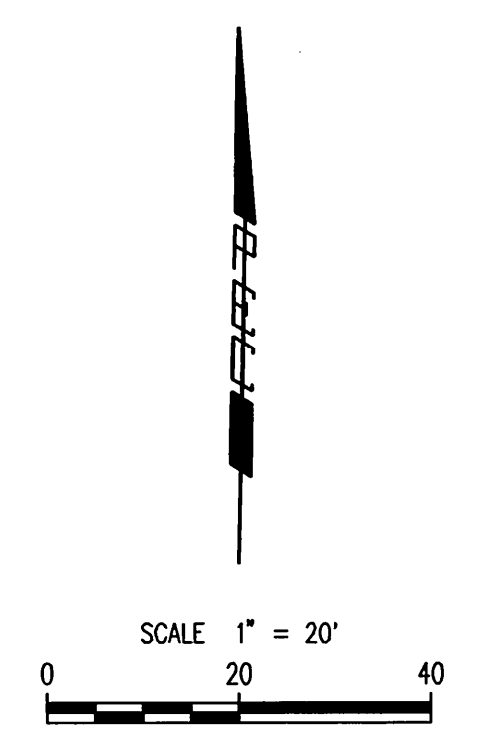
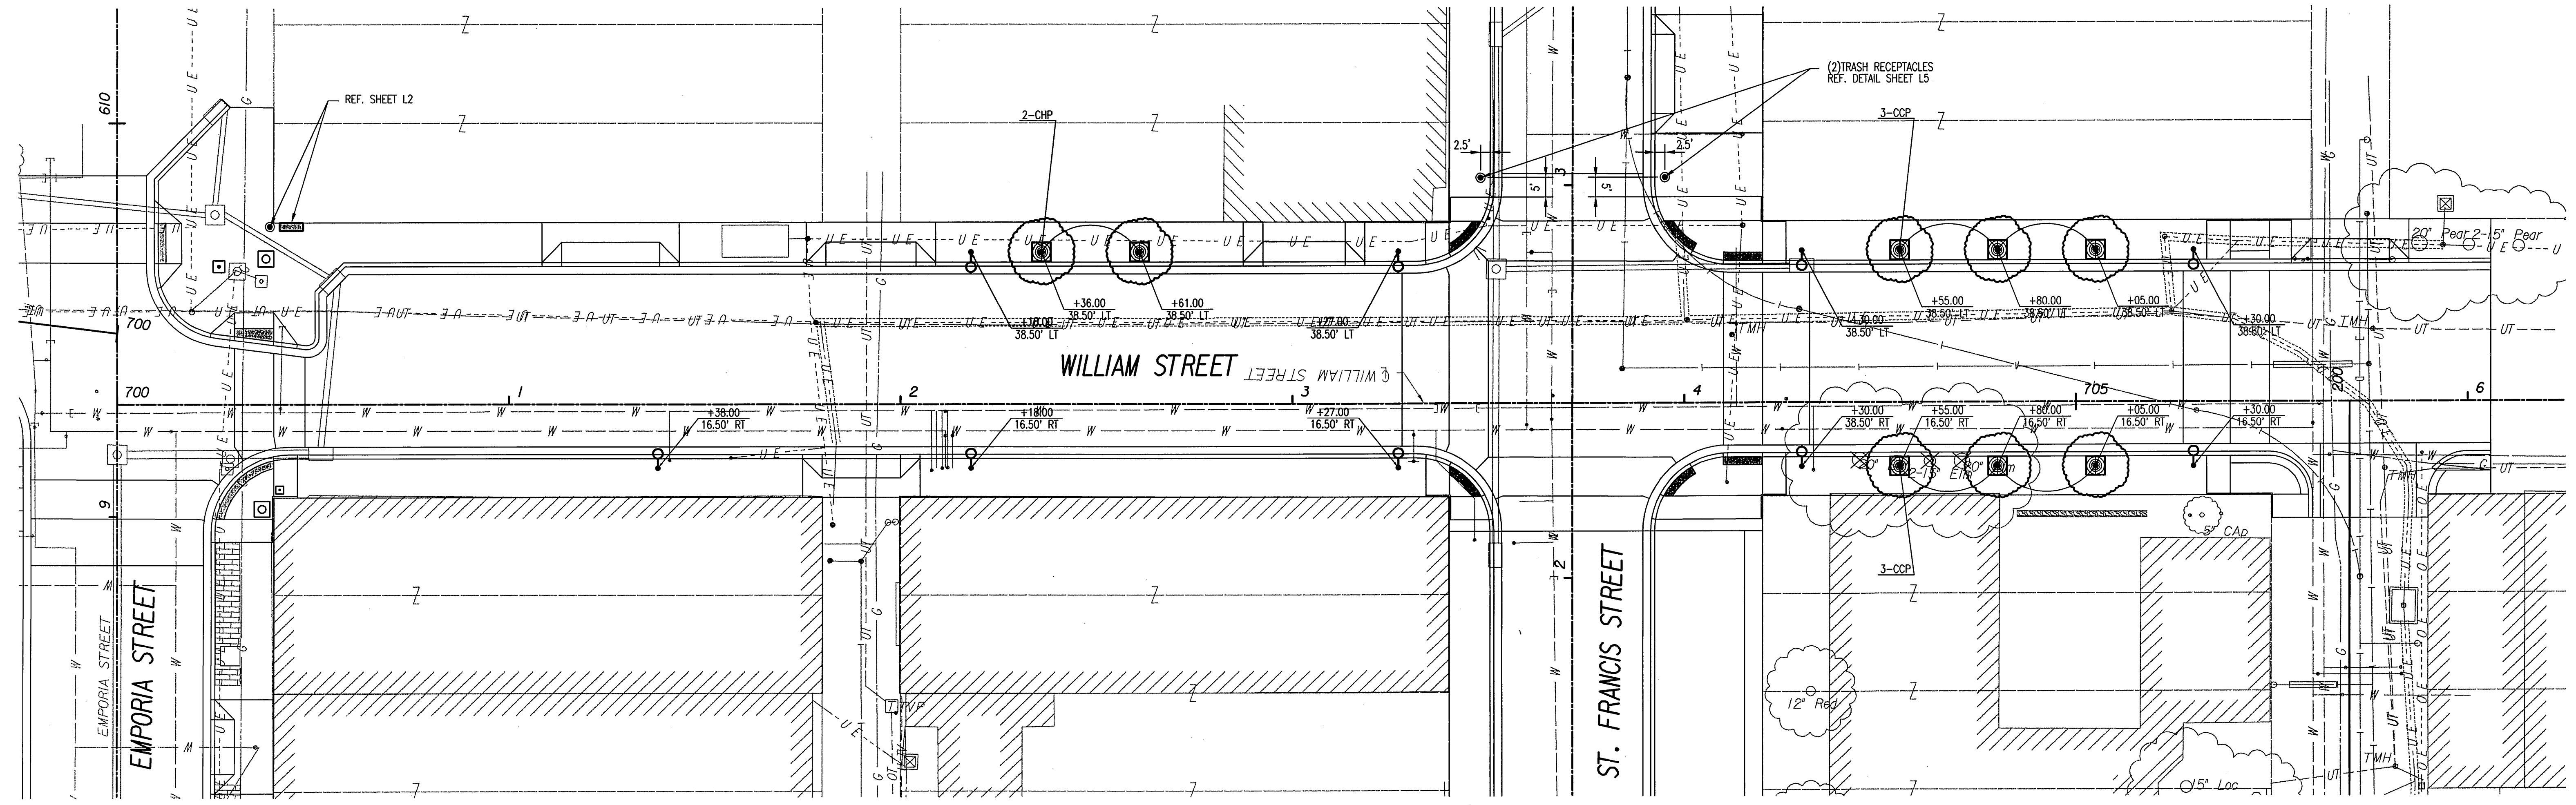






Saved: 03-03-2009 11:50:36 AM by DK  
 Plot Scale: 1:20 03-05-2009 2:47:35 PM  
 C:\2008\08456\08456-L-03-Landscape Plan700 William

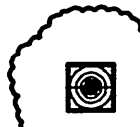

**LEGEND**

-  LIGHT POLES WITH STATION AND OFFSET TO CENTER OF BASE. (REFERENCE ELECTRICAL PLANS FOR TYPE AND DETAILS)
-  TREE GRATE (STYLE: METROPOLITAN) REF. DETAIL SHEET L5 (STATION AND OFFSET TO CENTER OF GRATE)
-  TRASH RECEPTACLE. REF. DETAIL SHEET L5
-  BENCH REF. NOTE SHEET L5

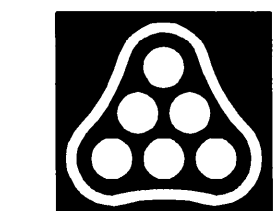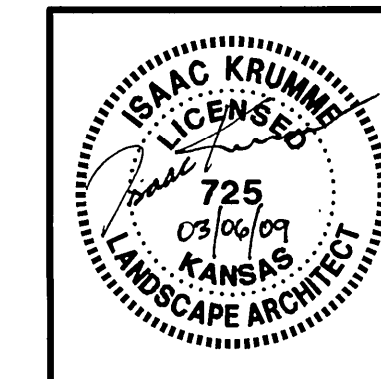

Region <b>WILLIAM STREET</b>		By	Date
<b>LANDSCAPE PLAN</b> STA. 700+00 TO STA. 706+00			
JAMES L. ARMOUR, P.E.-CITY ENGINEER CITY OF WICHITA PROJECT NO. 472-84744			
<b>Professional Engineering Consultants, P.A.</b> 303 S. TOPEKA • WICHITA, KANSAS 67202 316-262-2691 • FAX 316-262-3003			
Designed by	Job No.	Date	
Drawn by	08456	Feb., 2009	
			Sht. L3 of 5