


FHWA REGION NO.	STATE	PROJECT NUMBER	FISCAL YEAR	SHEET NUMBER	TOTAL SHEETS
7	KANSAS				

REFERENCES NOTED	DATE
REFERENCES CHECKED	

LITTLE ARKANSAS RIVER

Edge of Water

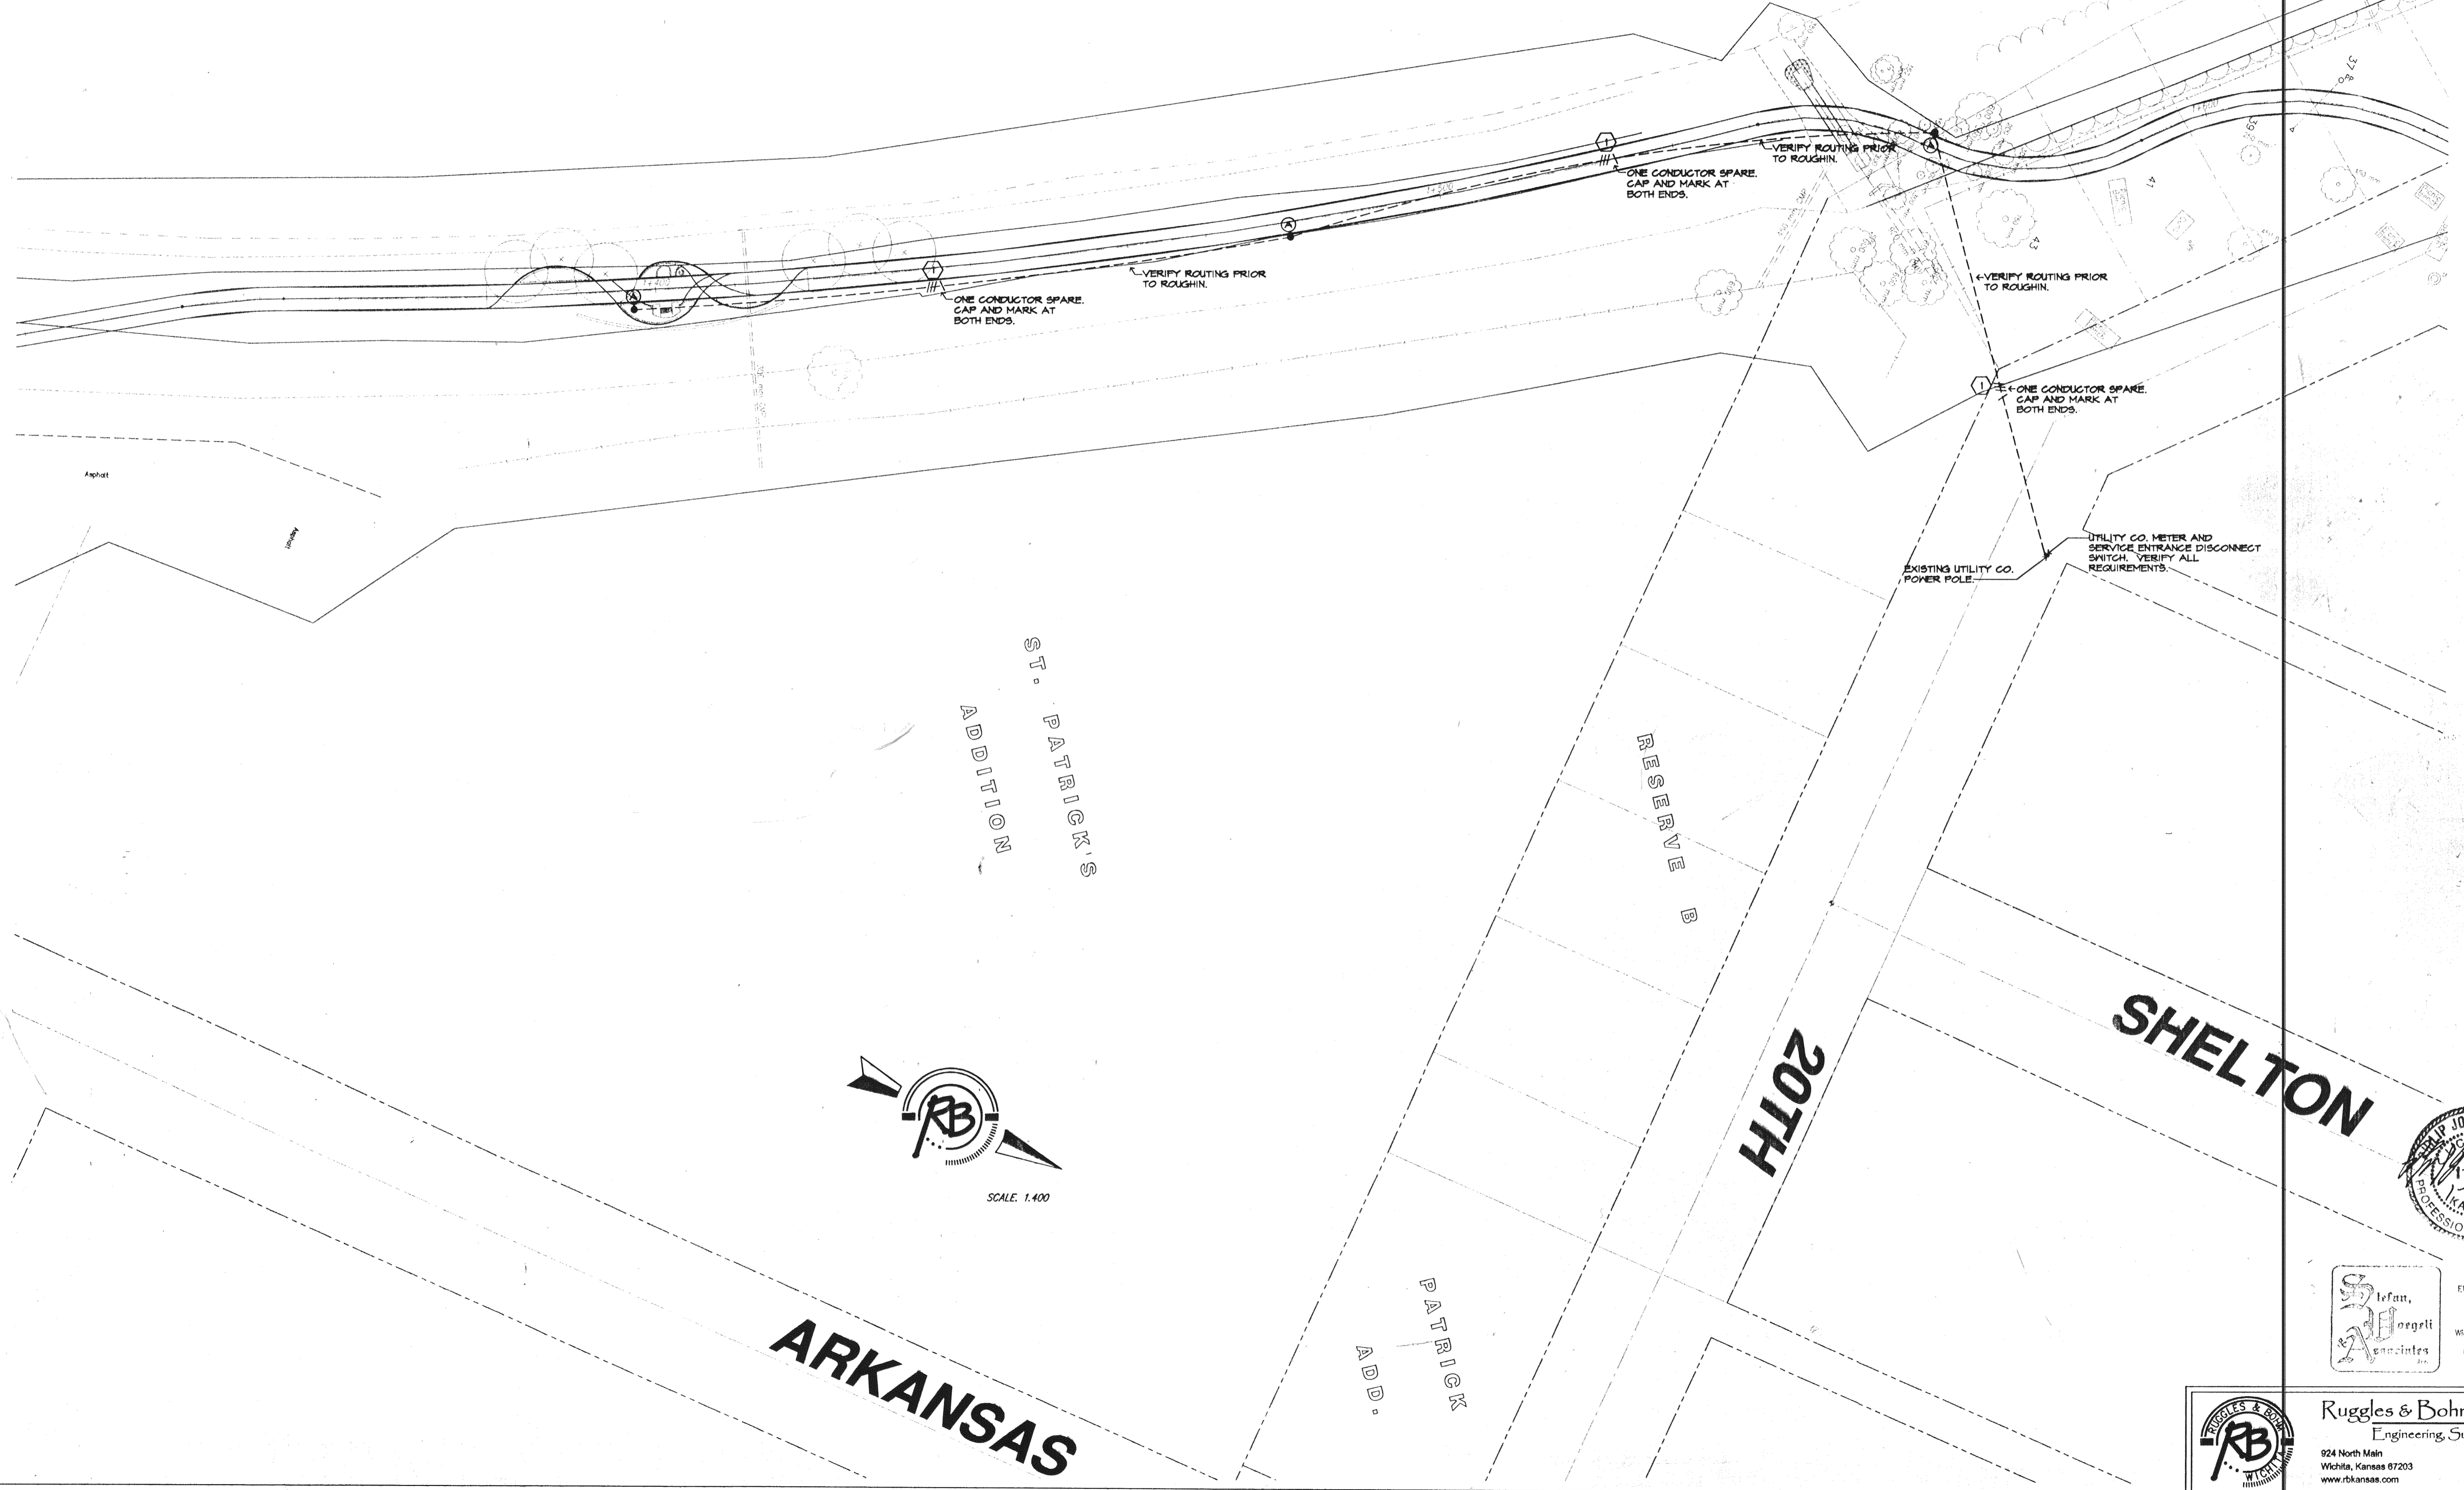


DESIGN	DRAWN	REVIEW
SVA	SVA	SVA
UTILITY	DATE	REVISED
	JAN. 20, 2003	


PROJECT NUMBER  
472-83438 (706531)

DRAWING FILE  
2140CCLD10

ELECTRICAL PLAN  
LITTLE ARKANSAS RIVER  
BICYCLE / PEDESTRIAN PATH

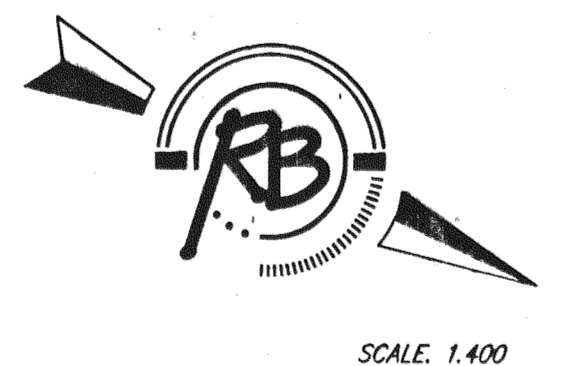

**S. J. Virek**  
Associates, Inc.  
Electrical Engineering and Design  
349 S. Hydraulic  
Wichita, KS, 67211-1904  
(316) 264-2081  
FAX: (316) 264-2542

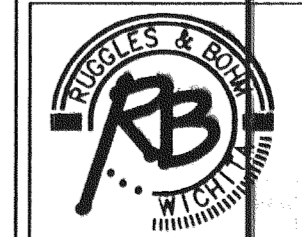

**Ruggles & Bohm, P.A.**  
Engineering, Surveying, Land Planning  
924 North Main  
Wichita, Kansas 67203  
www.rbkansas.com  
(316) 264-8008  
(316) 264-4621 fax  
E-mail: info@rbkansas.com

RB JOB  
2088T  
SHEET  
33  
02140-04