


# MASS GRADING PLAN AND PRIVATE STORM WATER SEWER

1882 PPS

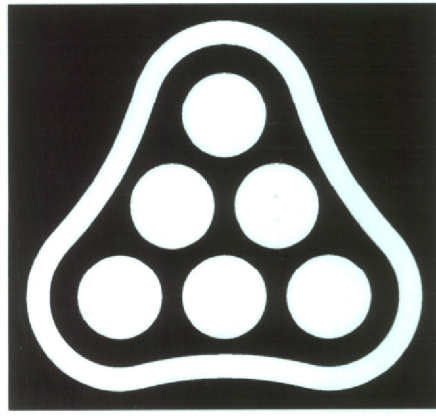

**P**rofessional  
**E**ngineering  
**C**onsultants

303 S. TOPEKA • WICHITA, KANSAS 67202  
316-262-2691 • FAX 316-262-3003  
www.pec1.com • designers@pec1.com

TO SERVE  
LUBRICANT RECYCLING FACILITY  
UNIVERSAL LUBRICANT, LLC


PRIVATE PROJECT NO. 1882 PPS (607861)

## CITY OF WICHITA, KANSAS

JAMES L. ARMOUR, P.E. - CITY ENGINEER

**INDEX OF SHEETS**

SHEET NO. C1.1	TITLE SHEET
SHEET NO. C1.2	KEY MAP AND GENERAL NOTES
SHEET NO. C1.3	SITE SURVEY
SHEET NO. C1.4	SITE/GRADING PLAN
SHEET NO. C1.5	GEOMETRY PLAN
SHEET NO. C1.6	SWPP PLAN
SHEET NO. C2.1-C2.3	PLAN/PROFILE
SHEET NO. C2.4	STANDARD TYPE 'P' MANHOLE DETAILS
SHEET NO. C2.5	MANHOLE FRAME & COVER DETAILS
SHEET NO. C3.1-C3.3	SOIL EROSION BMP DETAILS

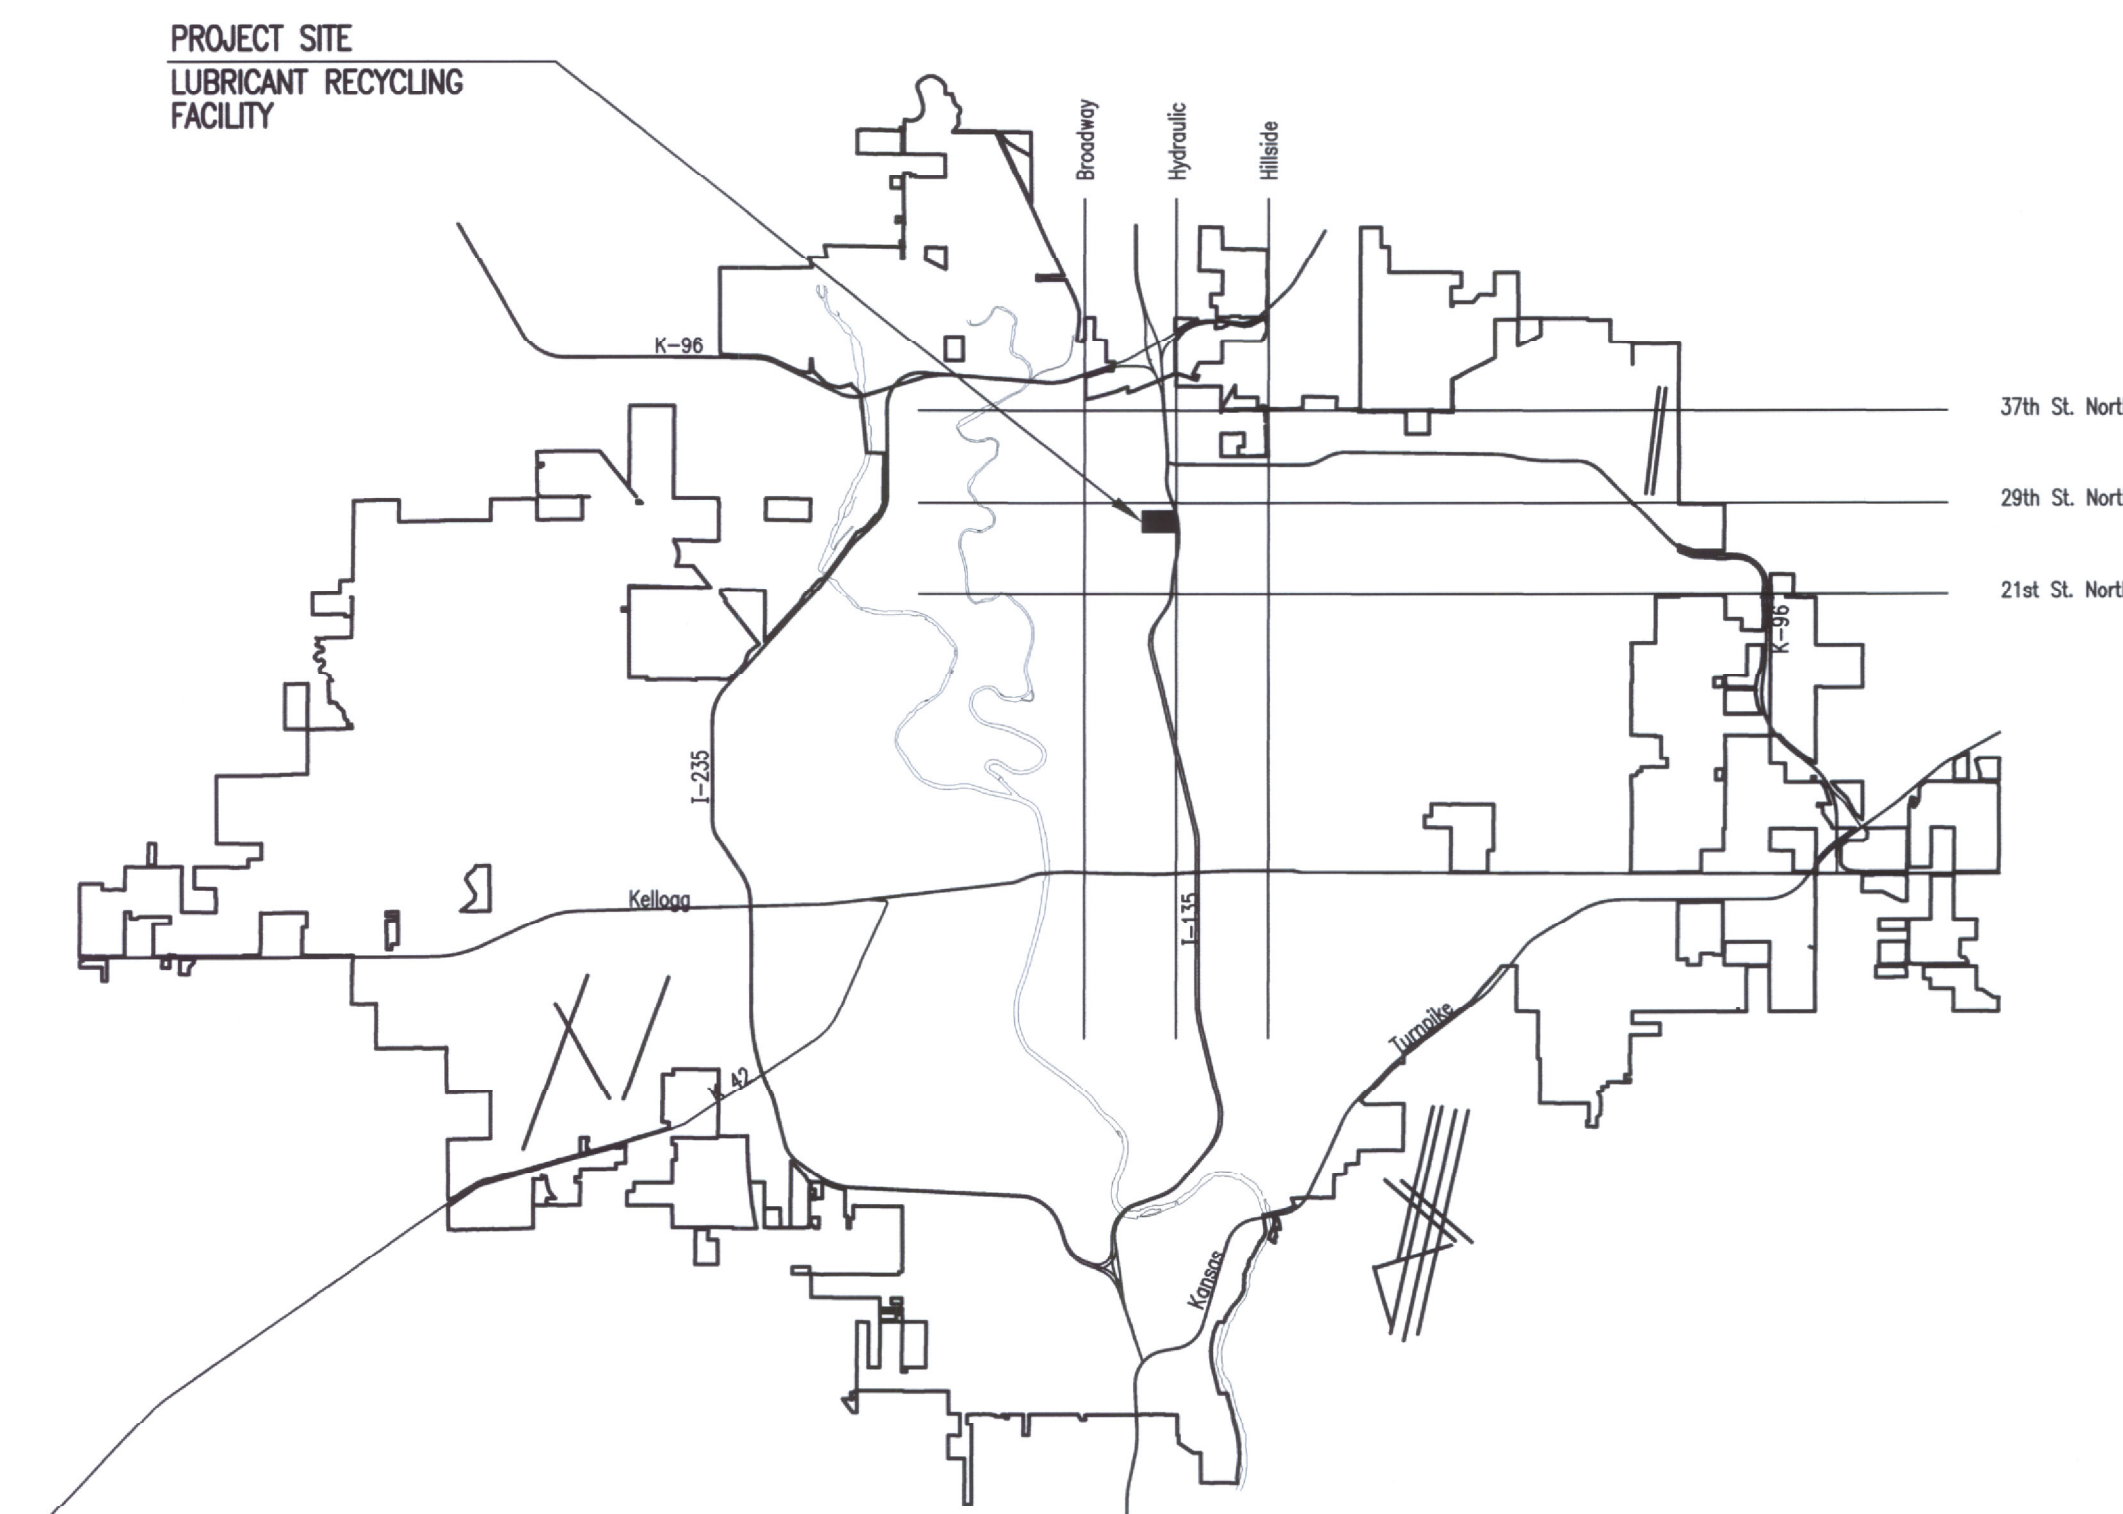

LOCATION MAP

APPROVED AS NOTED  
By CITY ENGINEER OF WICHITA

Sanitary Sewers \_\_\_\_\_

Storm Sewers Julianne Kallman 6-18-08

Driveway Approaches \_\_\_\_\_

Paving \_\_\_\_\_

**NOTE TO CONTRACTOR**

INSPECTION AND TESTING FOR THIS PROJECT IS TO BE PROVIDED BY A LICENSED CONSULTING ENGINEERING FIRM CONTRACTED BY THE OWNER/DEVELOPER. SAID INSPECTION TO BE IN ACCORDANCE WITH THE CITY OF WICHITA STANDARD CONSTRUCTION ENGINEERING PRACTICES AND CERTIFIED BY A LICENSED PROFESSIONAL ENGINEER. NO WORK SHALL BE PERFORMED IN DEDICATED EASEMENTS OR PUBLIC RIGHT-OF-WAY BY THE CONTRACTOR UNTIL SUCH INSPECTION IS ARRANGED FOR AND REQUIRED BONDS HAVE BEEN SUBMITTED TO AND APPROVED BY THE CITY. NOR SHALL ANY WORK BE COMMENCED IN DEDICATED EASEMENTS OR PUBLIC RIGHT-OF-WAY WITHOUT WRITTEN AUTHORIZATION BY THE CITY ENGINEER. IMPROVEMENTS PERFORMED UNDER THIS PROJECT SHALL NOT BE ACCEPTED BY THE CITY UNTIL ALL APPLICABLE DOCUMENTATION HAS BEEN SUBMITTED TO THE CITY ENGINEER. THIS MAY INCLUDE: RECORD DRAWINGS, INSPECTION LOGS, TEST DOCUMENTATION, TV TAPES, AND A CERTIFICATE OF COMPLETION. THE ABOVE SHALL BE PERFORMED BY THE CONSULTING FIRM CONTRACTED TO INSPECT THIS PROJECT.

LUBRICANT RECYCLING FACILITY  
UNIVERSAL LUBRICANTS, LLC  
WICHITA, KS

### JUNE 2008

PLANS PREPARED BY

PROFESSIONAL ENGINEERING CONSULTANTS, P.A.

ENGINEERS

WICHITA, KANSAS

RECORD DRAWINGS  
CONTRACTOR: WILDCAT CONSTRUCTION  
INSPECTOR: STEPHEN LORSON  
.pdf by: \_\_\_\_\_ 9/11/2009  
Inspectors Initials Date

Engineering Firm Inspecting: P.E.C.

TITLE SHEET

JOB NO. 07172-003  
DATE JUNE 2008  
DRAWN NCL  
CHECKED RRY  
**C1.1**  
-  
**14**