



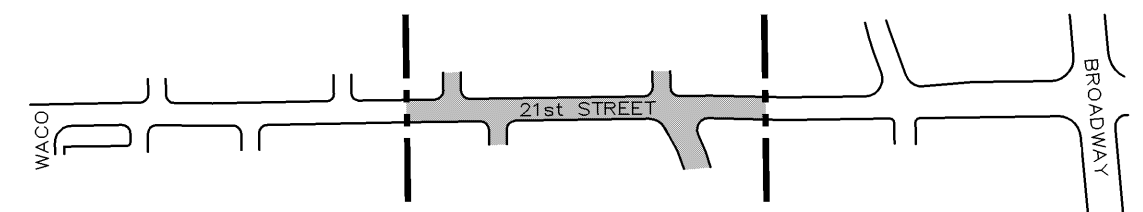
STATE	PROJECT NO.	YEAR	SHEET NO.	TOTAL SHEETS
KANSAS	472-84295	2010	131	194

BY	DATE


REFERENCES NOTED	REFERENCES CHECKED

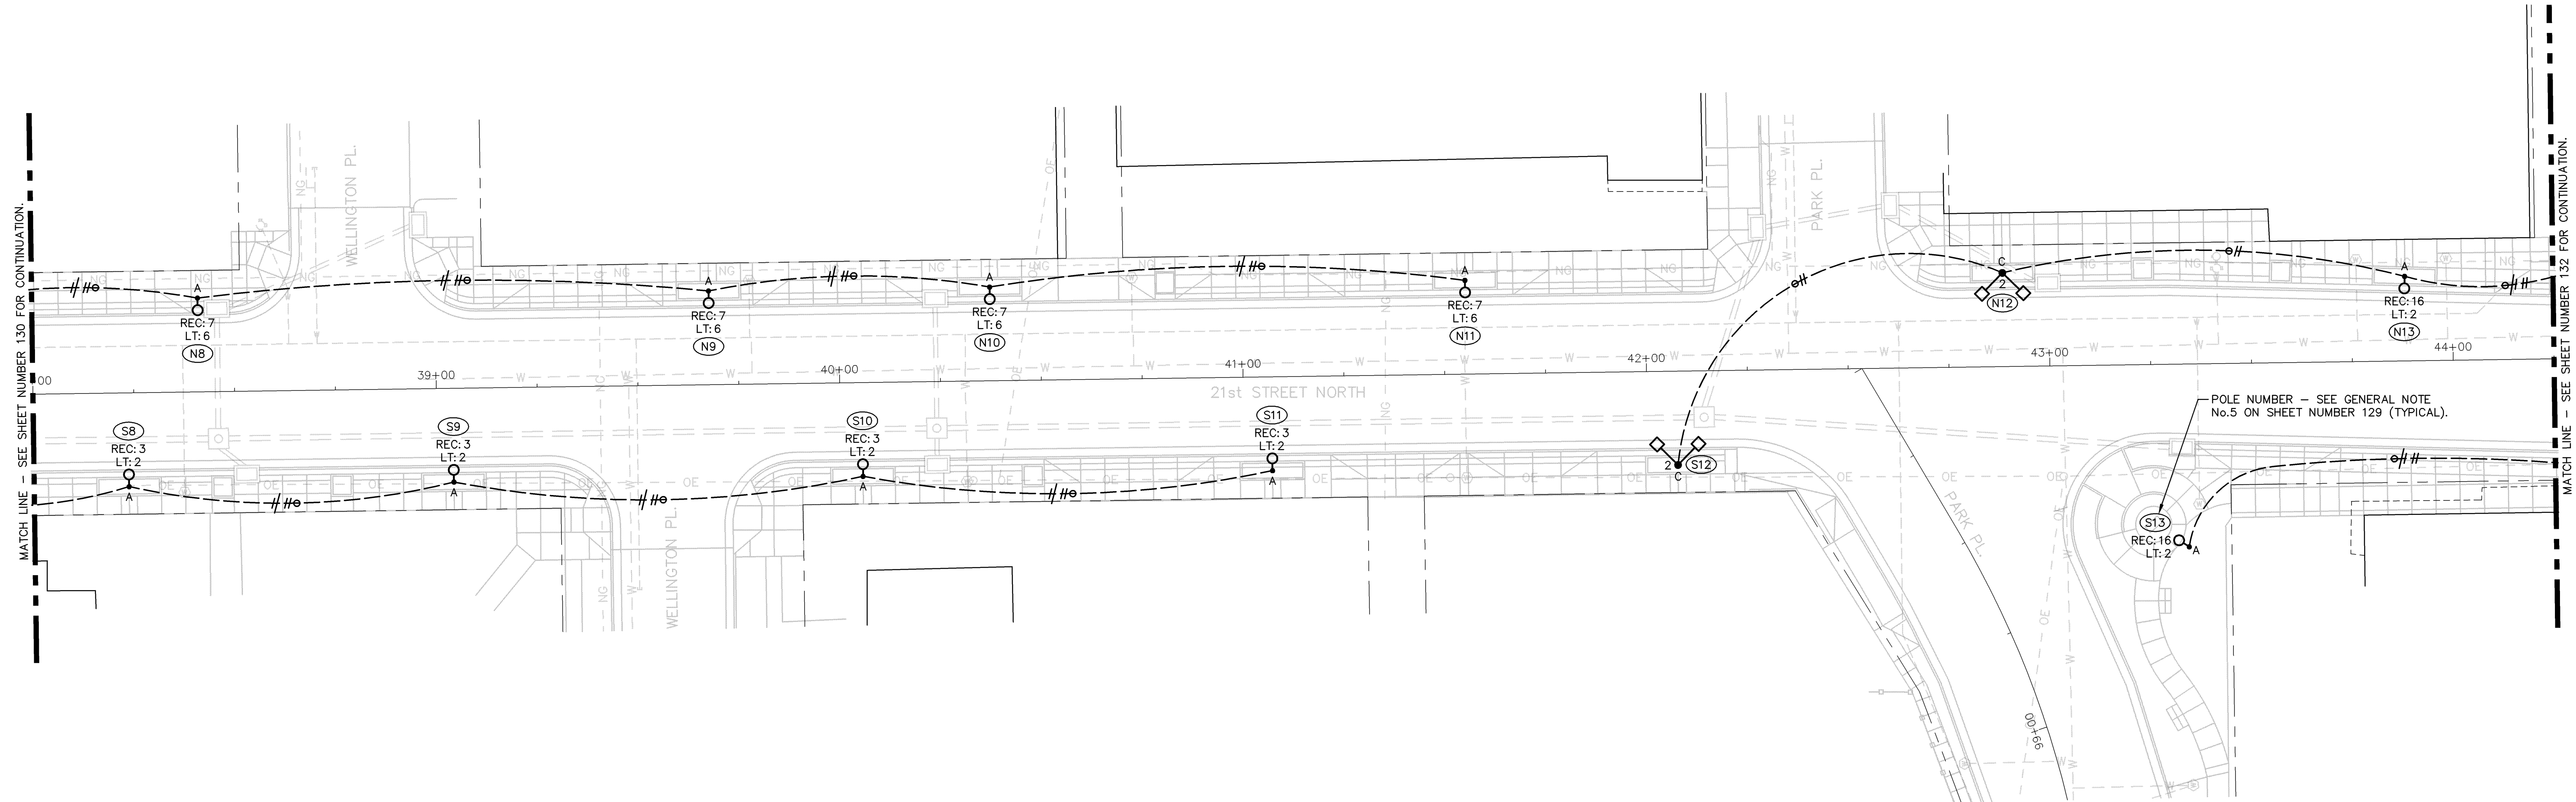

A ELECTRICAL PLAN - CENTER SECTION
 1" = 20'-0" 




KEY PLAN 



LAW/KINGDON, INC.
 ARCHITECTS, ENGINEERS, PLANNERS
 & LANDSCAPE ARCHITECTS

CITY OF WICHITA
 21ST STREET NORTH &
 BROADWAY AVENUE INTERSECTION
 ELECTRICAL PLAN
 CENTER SECTION
 WICHITA, KANSAS



DESIGNED: ST	DRAWN: ST
CHECKED: JC	DATE: 01-11-2010

L/K DWG. NAME: 07290-131.dwg; Jan 8 2010 - 11:22am; LAST EDITED BY: stucker