

PROJECT NO.	YEAR	SHEET NO.	TOTAL SHEETS
KA-1006-04	2010	1	71

STREET IMPROVEMENTS 47TH STREET FROM LULU TO HYDRAULIC


KDOT PROJ. NO. KA-1006-04
PROJ. NO. 472-84872
OCA NO. 991306
ARRA PROJ. NO. ARRA-KA 100(604)
WATER PROJ. NO. 448-90460

TRAFFIC TO BE CARRIED THROUGH
CONSTRUCTION FOR ALL MOVEMENTS.
SEE SHEETS 47-55 FOR CONSTRUCTION
SEQUENCE.

KDOT PROJECT NO. KA-1006-04
FEDERAL PROJECT NO. ARRA-KA 100(604)

CONCRETE PAVEMENT
GRADING
SEEDING
SIGNING AND PAVEMENT MARKING
WATER SYSTEM

LOCATION MAP

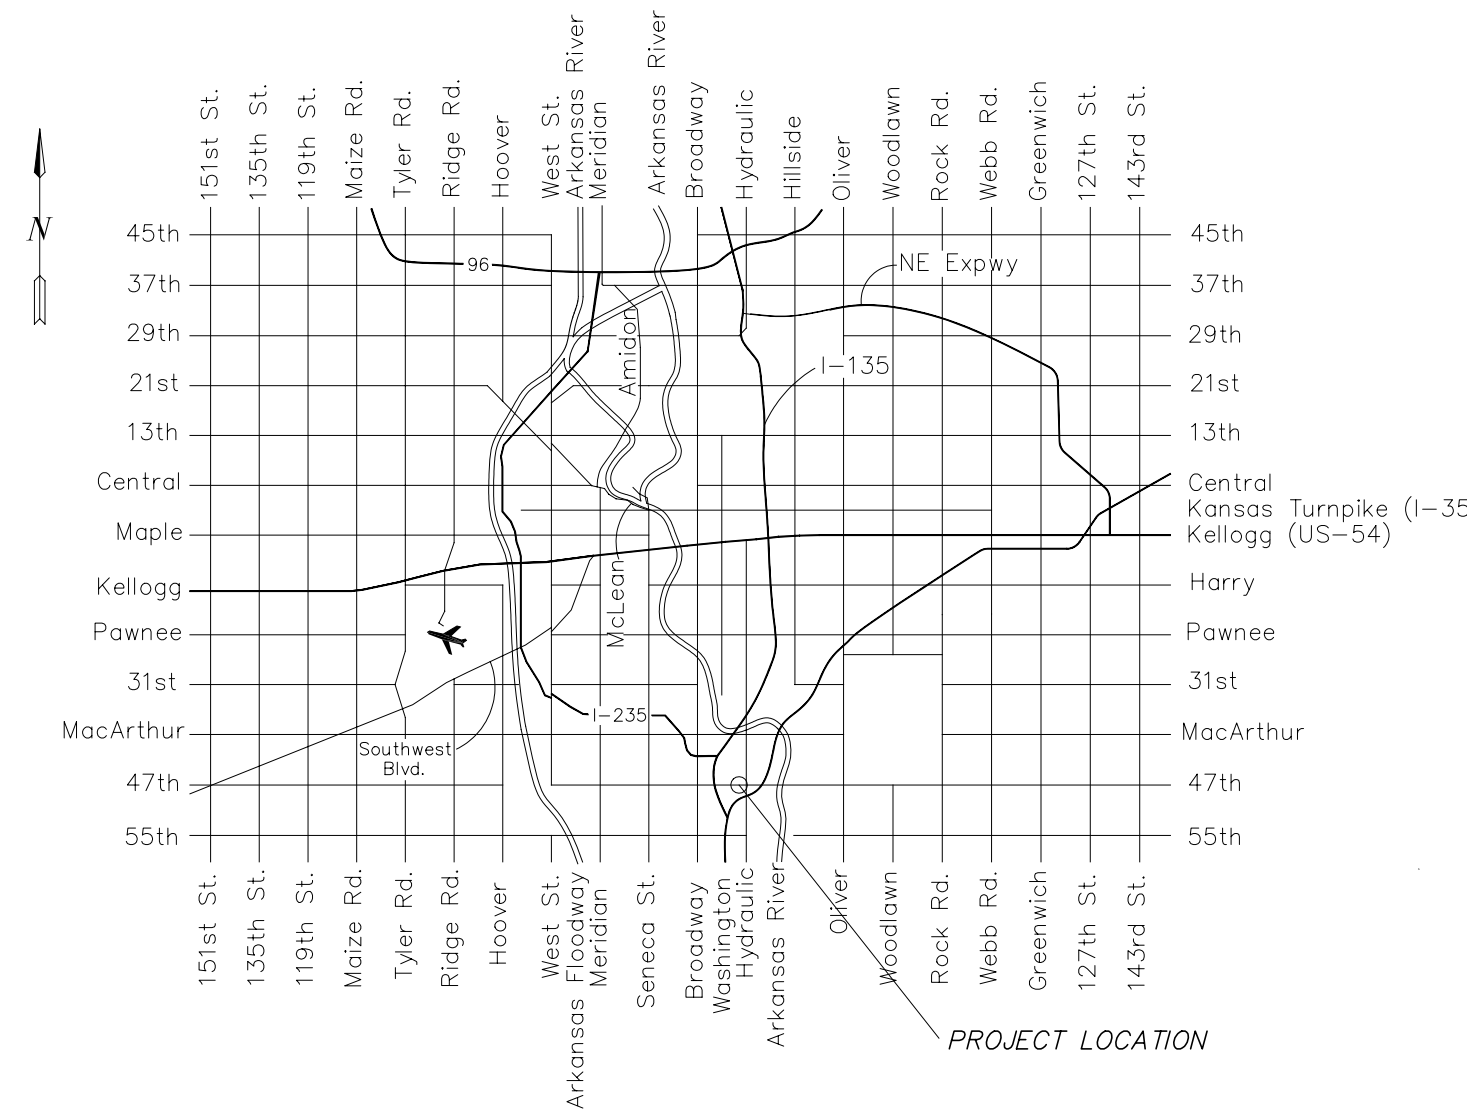

CITY OF WICHITA, KANSAS JAMES L. ARMOUR, P.E., L.S. - CITY ENGINEER

INDEX OF SHEETS


- 1 TITLE SHEET
- 2 GENERAL NOTES & UTILITY CONTACTS
- 3 ALIGNMENT DETAIL SHEET
- 4 TYPICAL SECTIONS
- 5-12 PLAN & PROFILE SHEETS
- 13-15 INTERSECTION DETAILS
- 16-18 JOINT DETAILS
- 19-24 PAVEMENT DETAILS
- 25-27 INLET AND MANHOLE DETAILS
- 28-29 PIPE PROFILES
- 30 WATER RELOCATION PLAN
- 31-32 SUMMARY OF QUANTITIES
- 33-35 SODDING & EROSION CONTROL
- 36-46 SIGNING AND PAVEMENT MARKING
- 47-55 CONSTRUCTION SEQUENCE & TRAFFIC CONTROL
- 56-63 TRAFFIC CONTROL DETAILS
- 64 DRAINAGE AREA SHEET
- 65-71 CROSS SECTIONS

DESIGN DESIGNATION - 47TH

AADT (2008)	23,091
AADT (2030)	30,557
DHV	10%
D	60/40
T	4%
V	40 mph
C of A	NONE

CONVENTIONAL SIGNS

COUNTY LINE	CENTER LINE OF PROJECT 50
CITY LIMITS	TERRACE
STATE OR NATIONAL LINE	CULVERTS
TOWNSHIP, SECTION or GRANT LINE	DROP INLET & STORM SEWER
PROPERTY LINE	ACCESS CONTROL
HIGHWAY FENCE	POWER POLE
EXISTING FENCE	TELEPHONE POLE
GUARD FENCE	MARSH
CONSTRUCTION LIMITS	HEDGE
RIGHT OF WAY LINE	TREES
TRAVELED WAY	PROFILE ELEVATION
RAILROADS	STREAM or CREEK

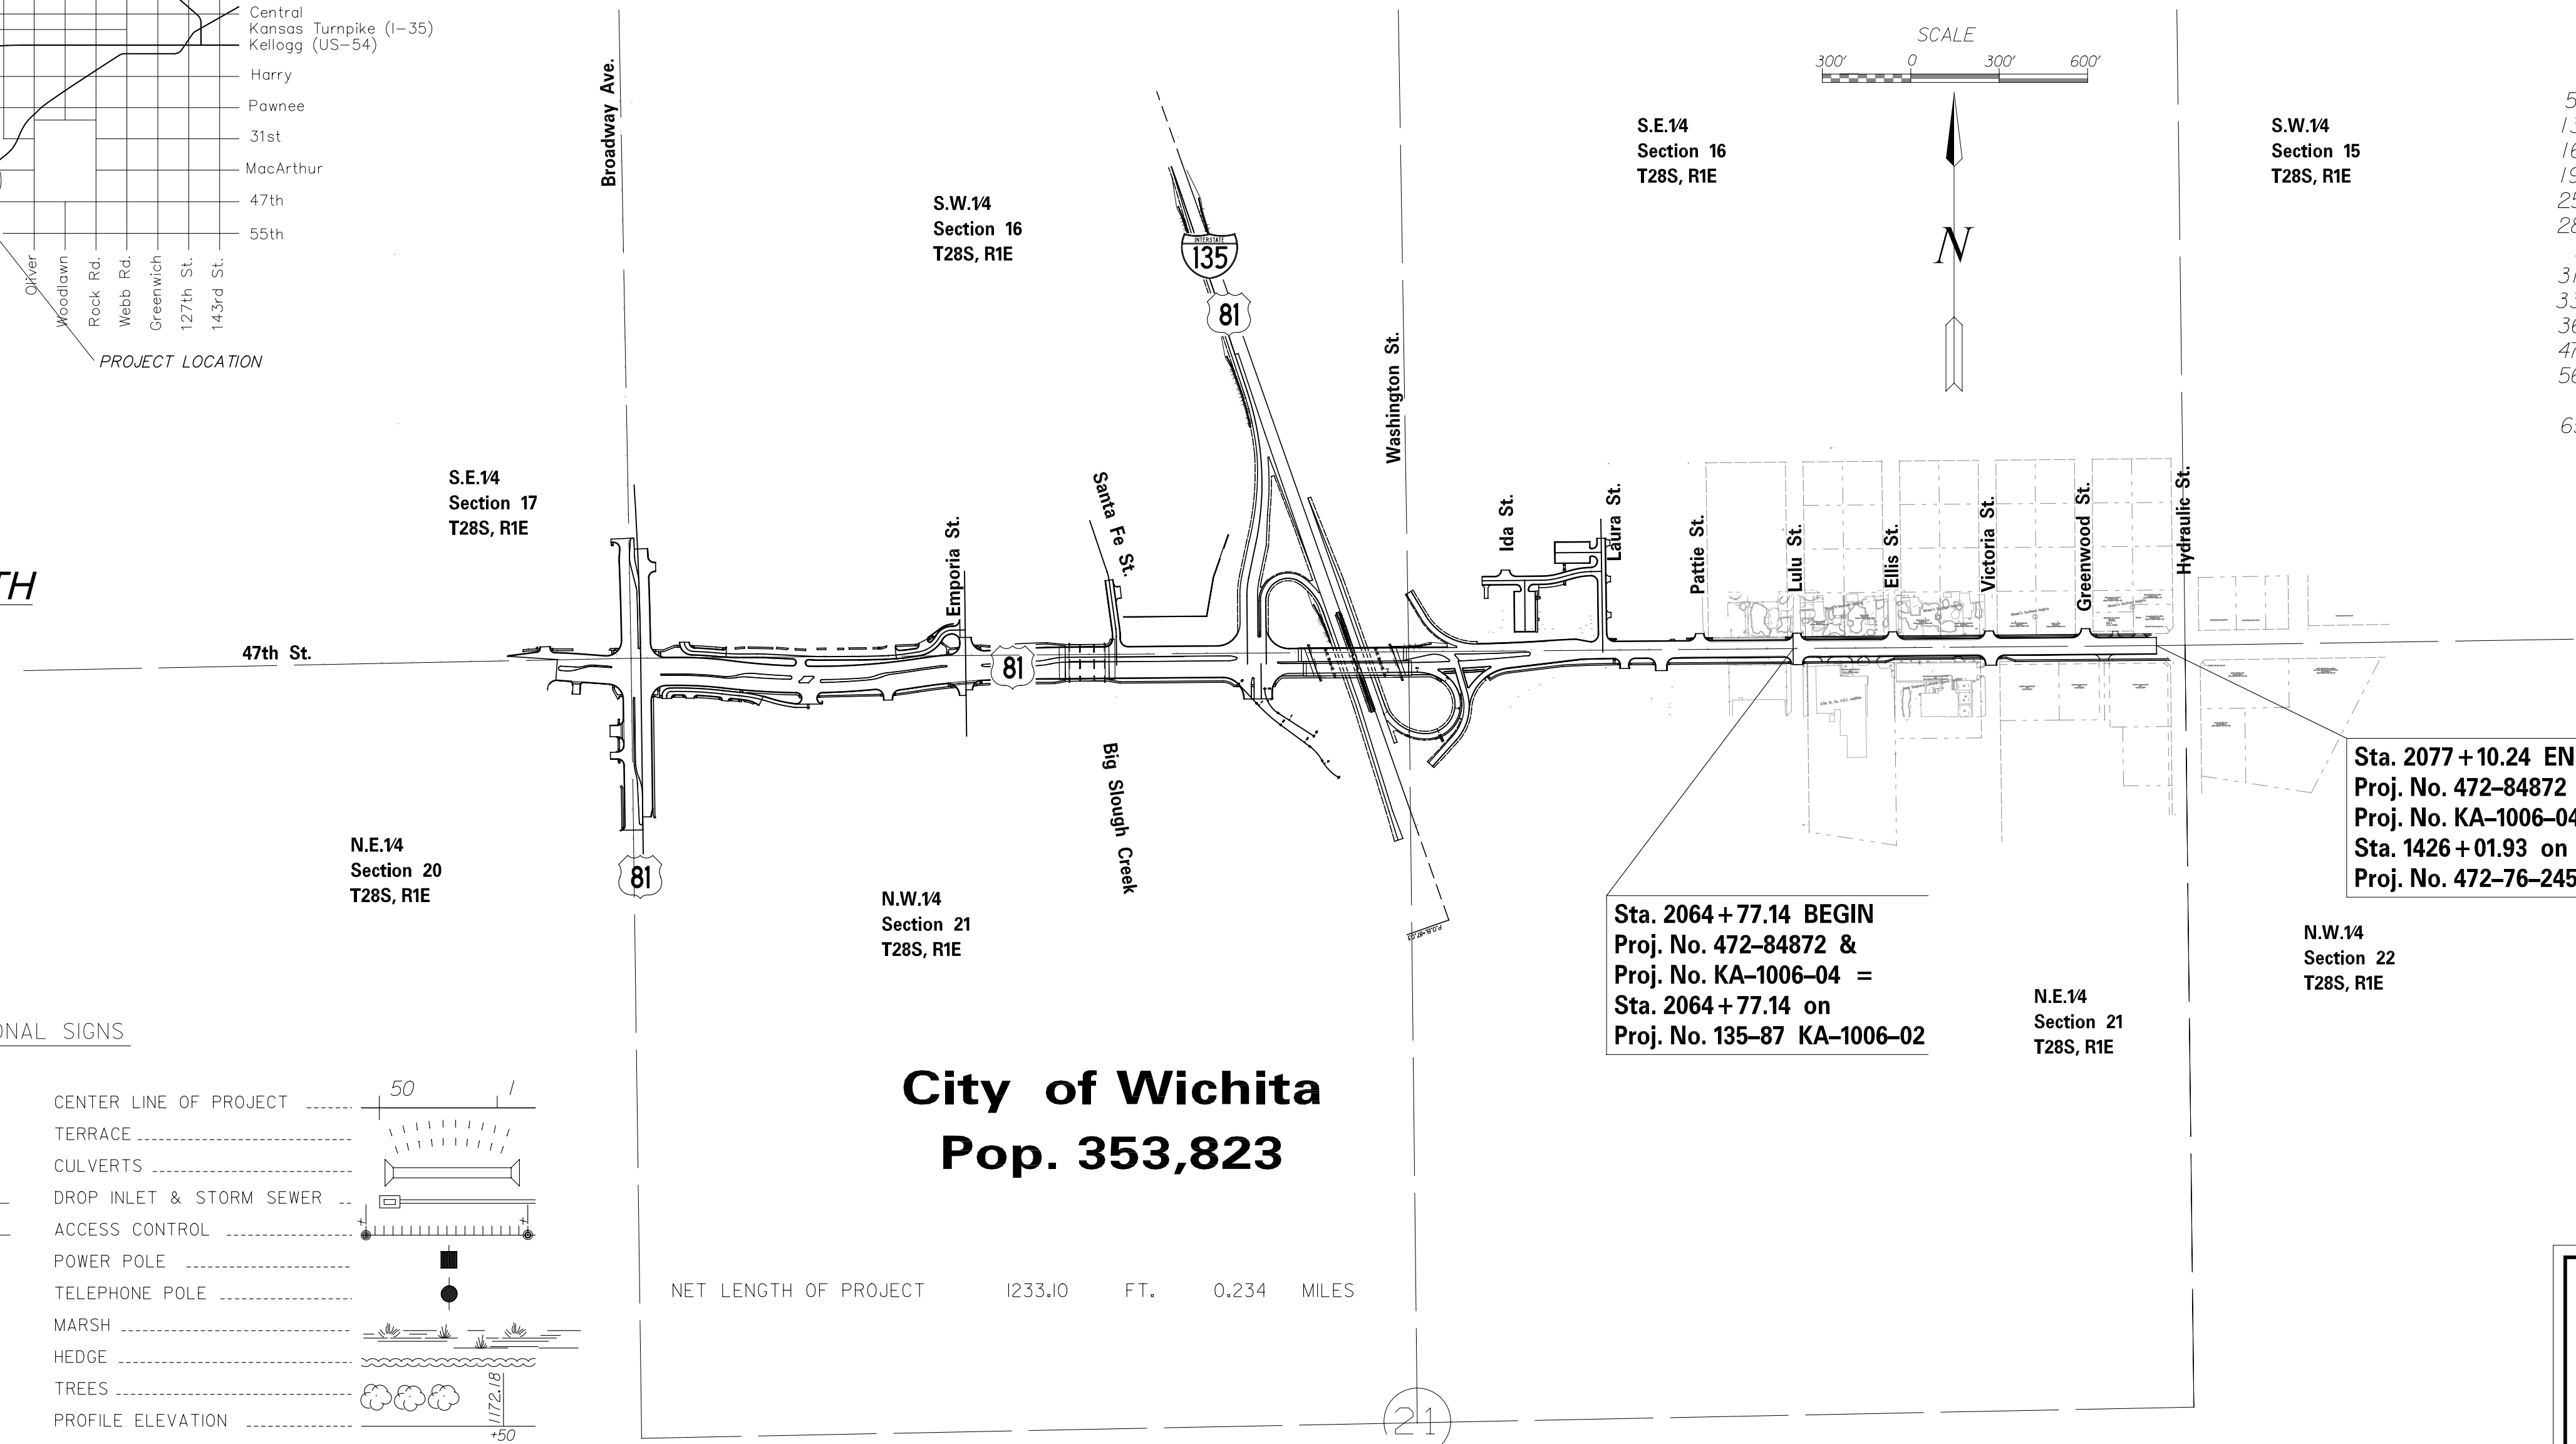

Sta. 2064 + 77.14 BEGIN
Proj. No. 472-84872 &
Proj. No. KA-1006-04 =
Sta. 2064 + 77.14 on
Proj. No. 135-87 KA-1006-02

Sta. 2077 + 10.24 END
Proj. No. 472-84872 &
Proj. No. KA-1006-04 =
Sta. 1426 + 01.93 on
Proj. No. 472-76-245



PREPARED & SUBMITTED BY:

HNTB
ENGINEERS ARCHITECTS PLANNERS
James L. Armour 2/24/10
Engineer Date

City of Wichita
Pop. 353,823

NET LENGTH OF PROJECT 1233.10 FT. 0.234 MILES

21



CITY ENGINEER		
JAMES L. ARMOUR, P.E., L.S.		
PROJECT NUMBER	OCA NUMBER	DATE
472-84872	991306	03/10
CITY ENGINEER'S OFFICE		DESIGN DRAWN
CITY HALL - SEVENTH FLOOR		EGS RAM
455 NORTH MAIN STREET		SHEET
WICHITA, KANSAS 67202-1620		1 OF 71
(316) 268-4501		
(316) 268-4114 FAX		