

# WATER DISTRIBUTION SYSTEM IMPROVEMENTS

TO SERVE

## FIRE TRAINING ACADEMY


PRIVATE PROJECT NO. 1499 PPW (607853)

## CITY OF WICHITA, KANSAS

JAMES L. ARMOUR, P.E. - CITY ENGINEER

### INDEX OF SHEETS

SHEET NO. C301	TITLE SHEET
SHEET NO. C302	KEY MAP AND GENERAL NOTES
SHEET NO. C303	UTILITY PLAN
SHEET NO. C304	STANDARD DETAILS
SHEET NO. C305	PLAN/PROFILE
SHEET NO. C402-C404	SOIL EROSION BMP DETAILS

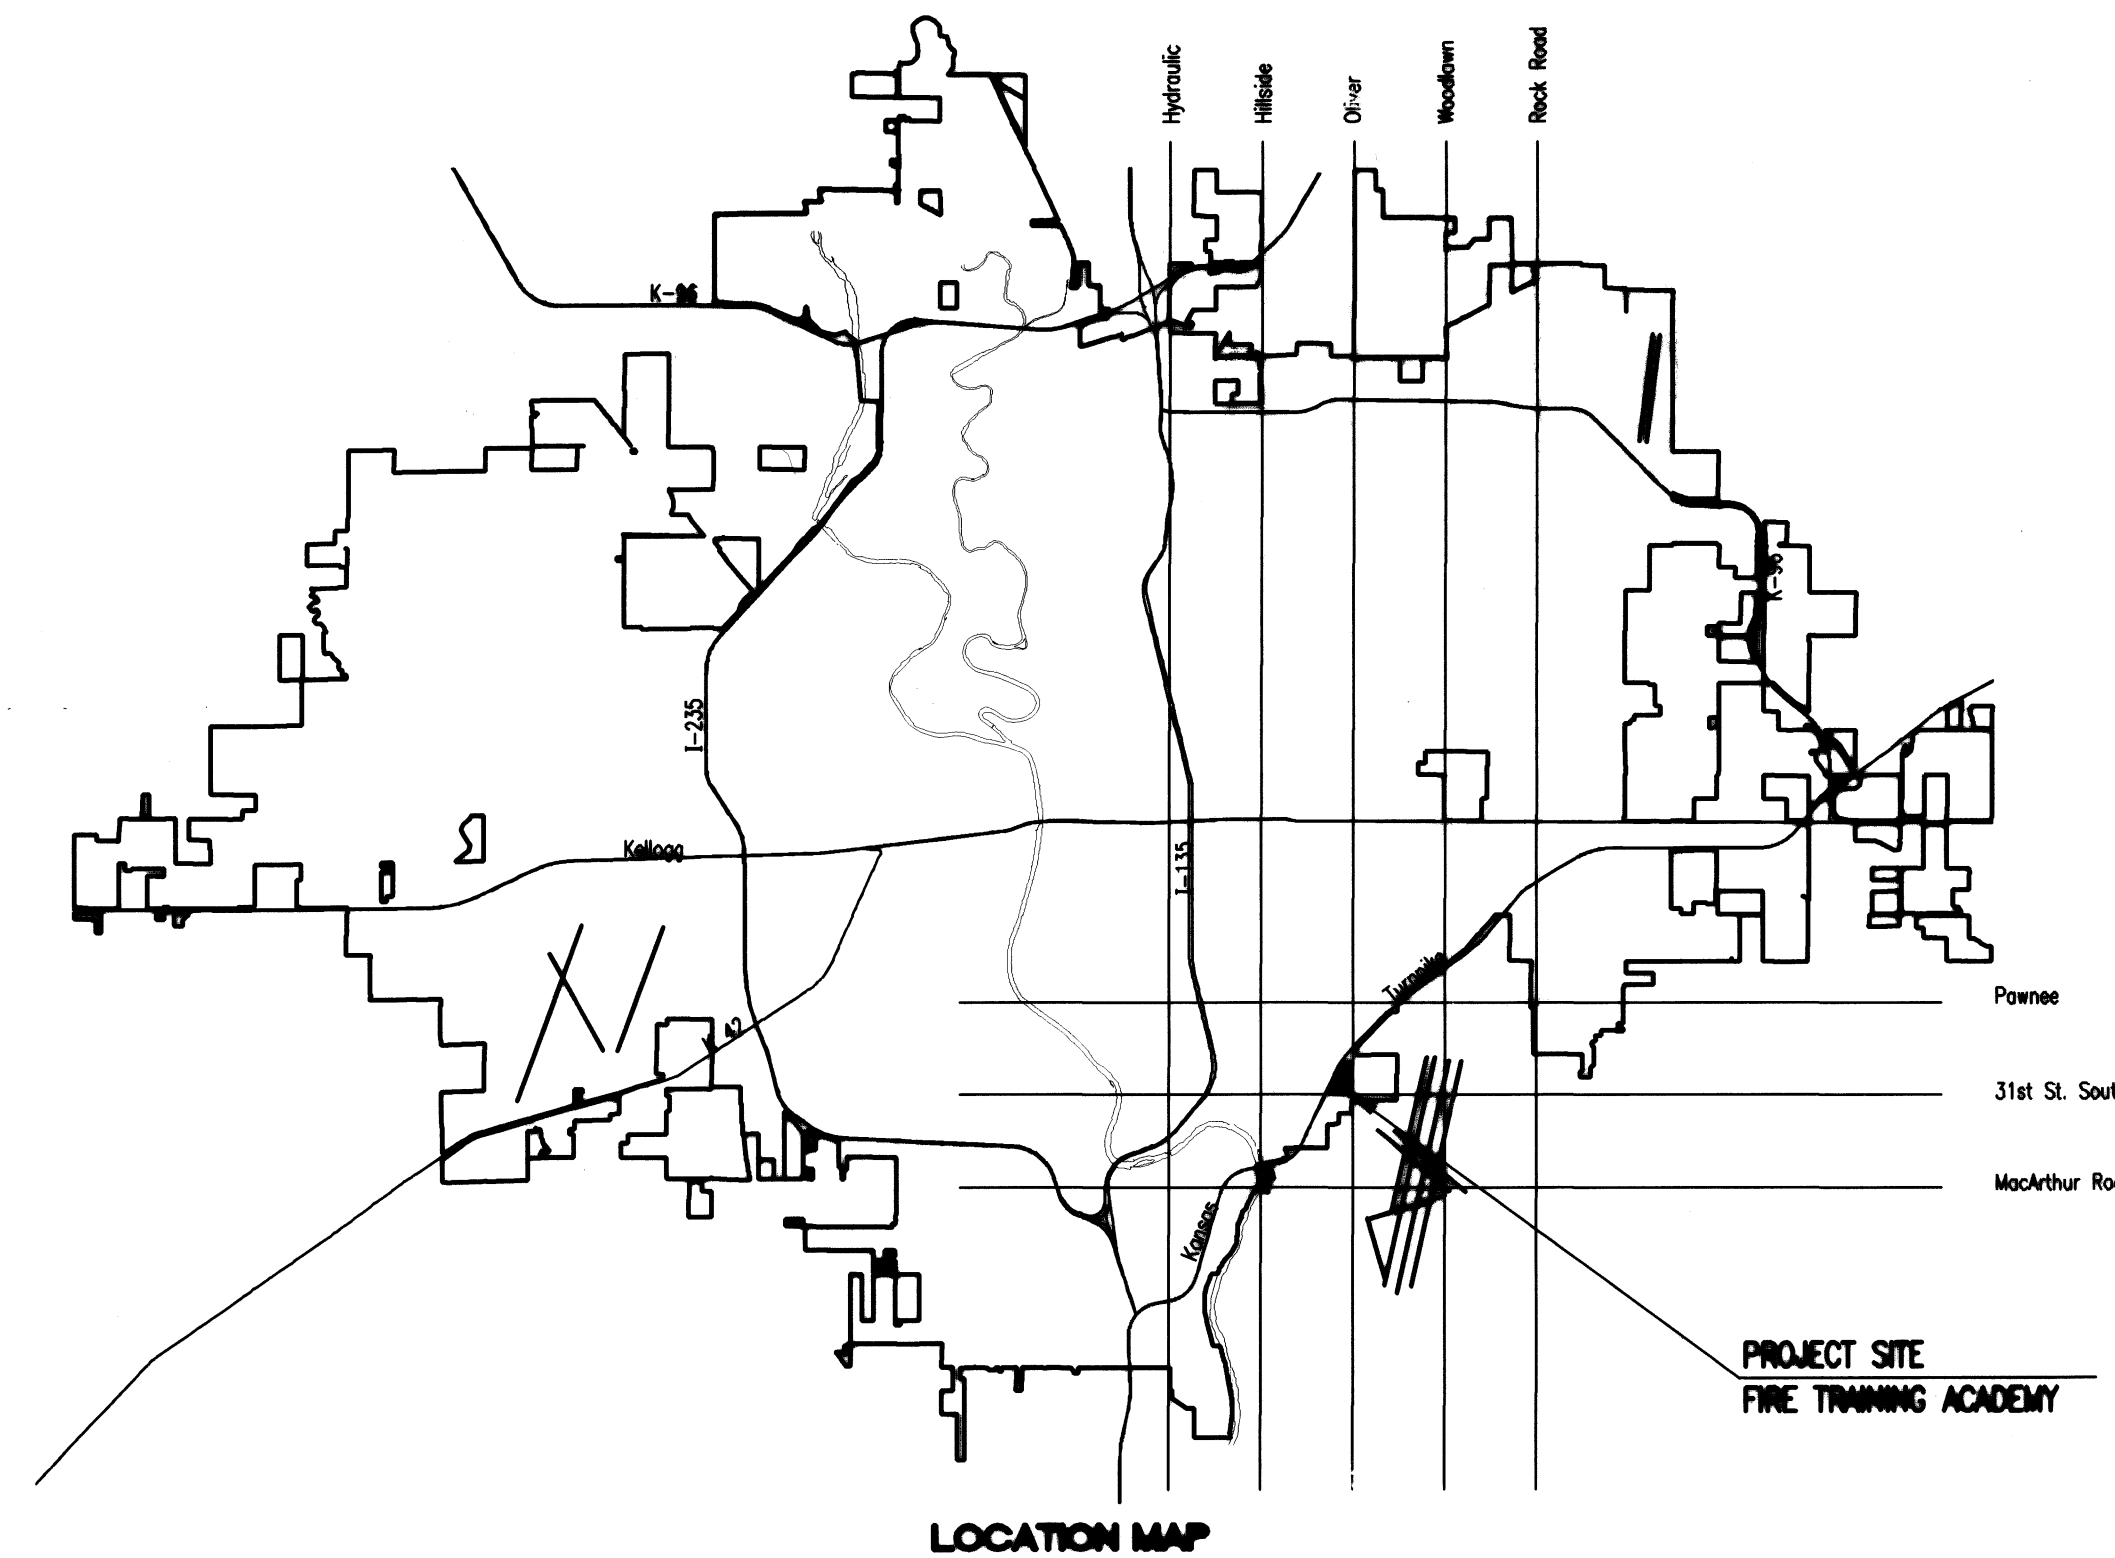

APPROVED AS NOTED  
 BY CITY ENGINEER OF WICHITA,  
 BY WICHITA WATER UTILITIES,  
 & BY WICHITA FIRE DEPARTMENT

Water Mains (Public Works) *[Signature]* 1/13/10  
 Water Mains (Water Utilities) *[Signature]* 1-14-10  
 Fire Prot. Line WED/RET 1-15-2010

NOTE TO CONTRACTORS

**PUBLIC PROPERTY:**  
 Inspection and testing for the waterline is to be provided by a Licensed Consulting Engineering Firm under contract with the Owner/Developer. Said inspection to be in accordance with the City of Wichita standard construction engineering practices and certified by a Licensed Professional Engineer licensed in the State of Kansas. No work shall be performed in dedicated easements or public right-of-way by the Contractor without such inspection nor shall any work be commenced without written authorization by the City Engineer. All Construction and Materials shall comply with the City of Wichita Specifications and Standards (on file and available in the City Engineer's Office).

**PRIVATE PROPERTY:**  
 Installation and testing for the fire protection line is to be performed by a City of Wichita licensed fire protection contractor in accordance with the fire codes as adopted by the City of Wichita. All materials and construction practices for the fire protection line shall comply with the fire codes as adopted by the City of Wichita (available from the City of Wichita Fire Department). The Contractor shall not commence work without notification and approval of the Wichita Fire Department.  
 Inspection of the fire protection line is to be provided by the City of Wichita Fire Department and by a licensed Consulting Engineering Firm under contract with the Owner/Developer.  
 The contractor shall not start work until the project inspector is assigned to the project and present on the site. Any work done without inspection will be required to be uncovered for inspection.

## JANUARY 2010

PLANS PREPARED BY  
**PROFESSIONAL ENGINEERING CONSULTANTS, P.A.**  
 ENGINEERS  
 WICHITA, KANSAS

**As Built Plans:**

CONTRACTOR: Ewertz Exc.

INSPECTOR: Larry Gann, K E Miller Engineering

.PDF by: NWS, 4-27-2010



Architecture  
 420 South Emporia  
 Wichita, KS 67202  
 Tel: (316) 265-9367  
 Fax: (316) 265-5646  
 Email: arch@gsosslivingston.com



Professional Engineering Consultants, P.A.  
 303 SOUTH TOPEKA  
 WICHITA, KANSAS 67202  
 316-262-2691  
 FAX 316-262-3003  
 www.pec1.com

2009 GossenLivingston Associates, Inc.

All work herein is the exclusive property of Gossen Livingston Associates, Inc. and is not to be copied or used in any way without the express written consent of Gossen Livingston Associates, Inc. All drawings, specifications, plans, designs and arrangements appearing thereon constitute the original and unaltered work of Gossen Livingston Associates, Inc.

Gossen Livingston Associates, Inc.

**FIRE TRAINING ACADEMY**  
**CITY OF WICHITA FIRE DEPARTMENT**  
**WICHITA, KS**

REV 5/01/05/10	ADDENDUM 4
REV 3/12/15/09	ADDENDUM 2
REV 2/11/20/09	PLAN REVIEW COMMENTS
REV 1/10/22/09	PLAN REVIEW COMMENTS / ISSUE TO BID

PPW TITLE SHEET

Job No. 1036.300  
 Date 09/24/09  
 Drawn SAW  
 Checked JEH

**C301**