



MATCH LINE
See Sheet S2

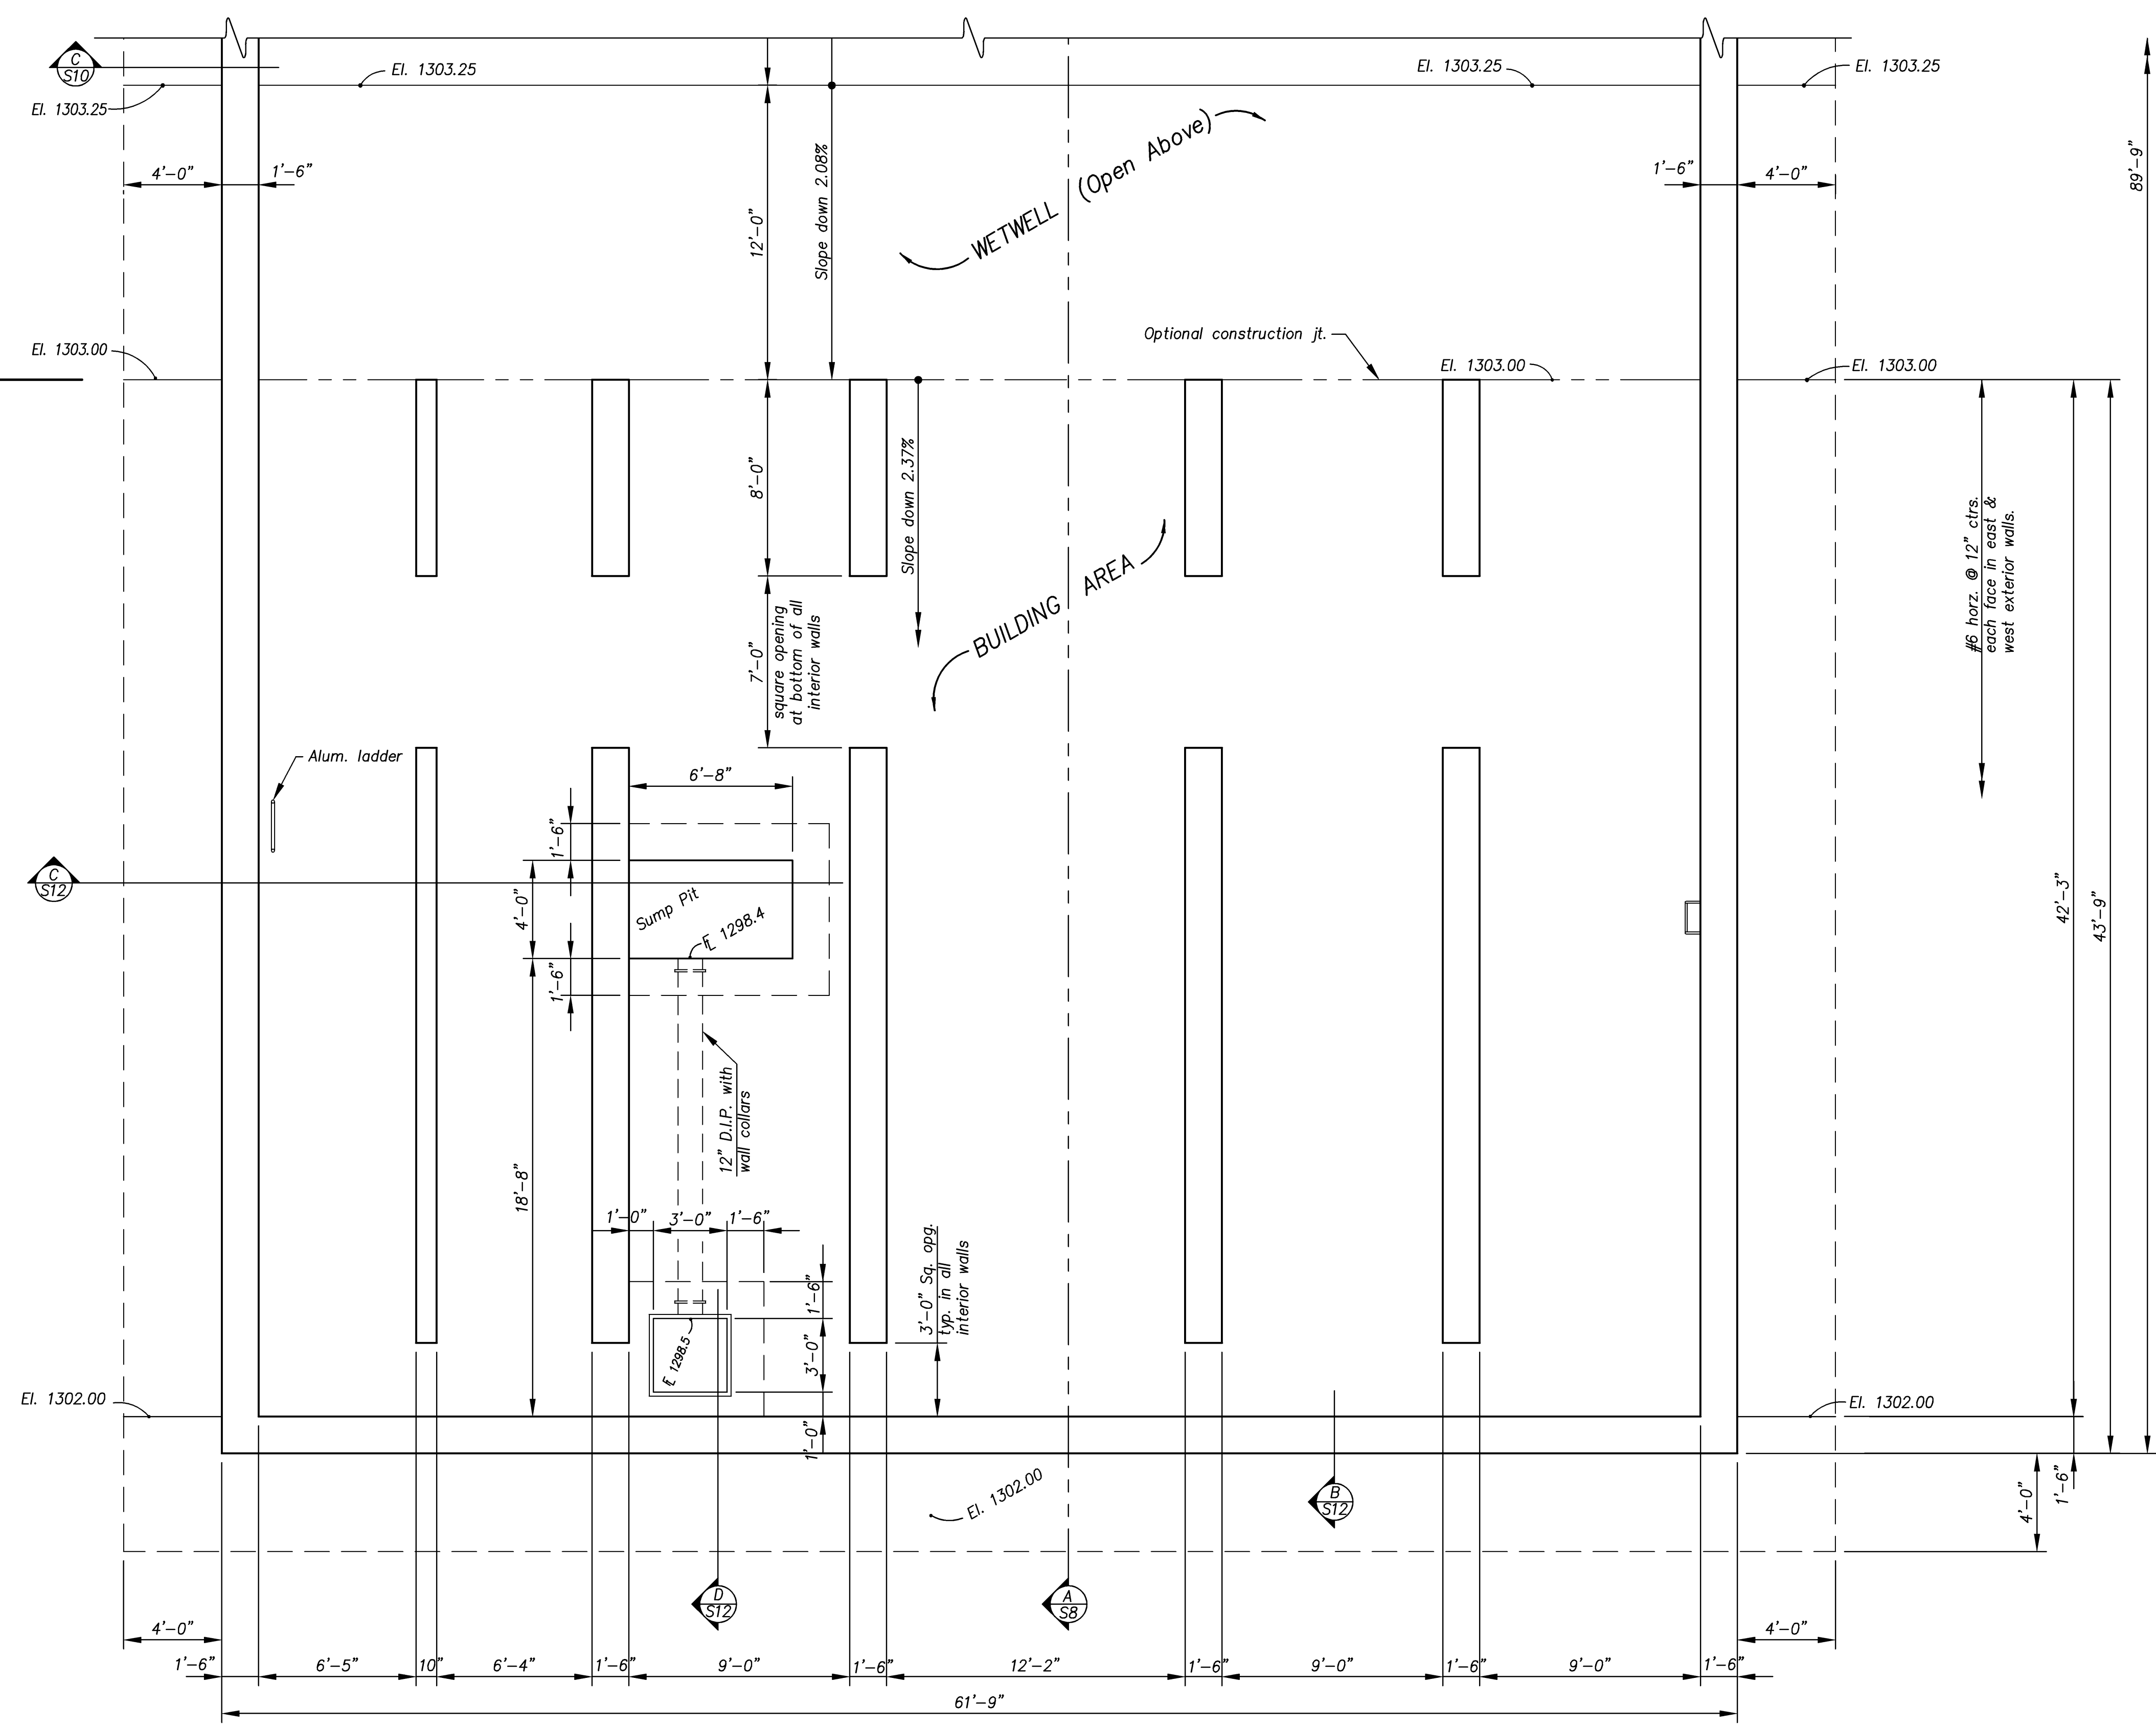

FOUNDATION PLAN - BUILDING AREA
Scale: 1/4" = 1'-0"



CITY OF WICHITA, KANSAS	
PUMP STATION NO. 11	
STRUCTURAL	
PUMP STATION FOUNDATION PLAN BUILDING AREA	
DESIGNED KMB	SCALE As Shown
DETAILED HAP	DATE 10-30-09
CHECKED	SHEET S3 OF S17

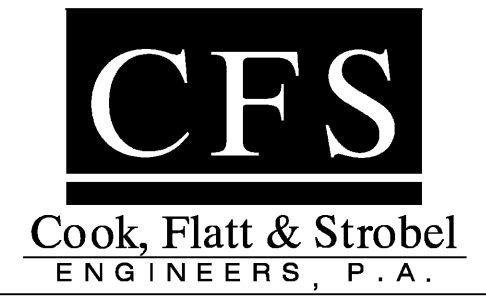

J:\2008Proj\08527\DWG\Structural\DWG\Structural_2.dwg SZ-3 FD Plan 11/10/2009 - 1:47pm lpham