


STATE	PROJECT NO.	YEAR	SHEET NO.	TOTAL SHEETS
KANSAS	87 N-0305-03	2005	1	117

STATE OF KANSAS

DEPARTMENT OF TRANSPORTATION

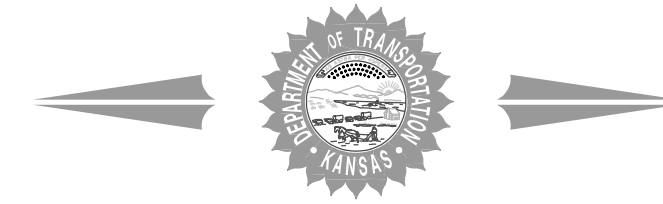

PLAN AND PROFILE OF PROPOSED

PROJECT NO. 87 N-0305-03

STREET AND STORM WATER SEWER IMPROVEMENTS

WICHITA, SEDGWICK COUNTY, KANSAS

MERIDIAN AVENUE

FROM

31ST STREET SOUTH TO PAWNEE STREET

C.O.W. PROJECT NO. 472-84175 (706918)

GRADING
SURFACING
PAVEMENT MARKING
SEEDING




End Project
87N-0305-03
Sta. 65+14.48

Begin Project
87N-0305-03
Sta. 11+52.66

DESIGN DESIGNATION

AADT (2004) = 13,536
AADT (2030) = 15,000
DHV = 10%
T = 3%
V = 40 mph

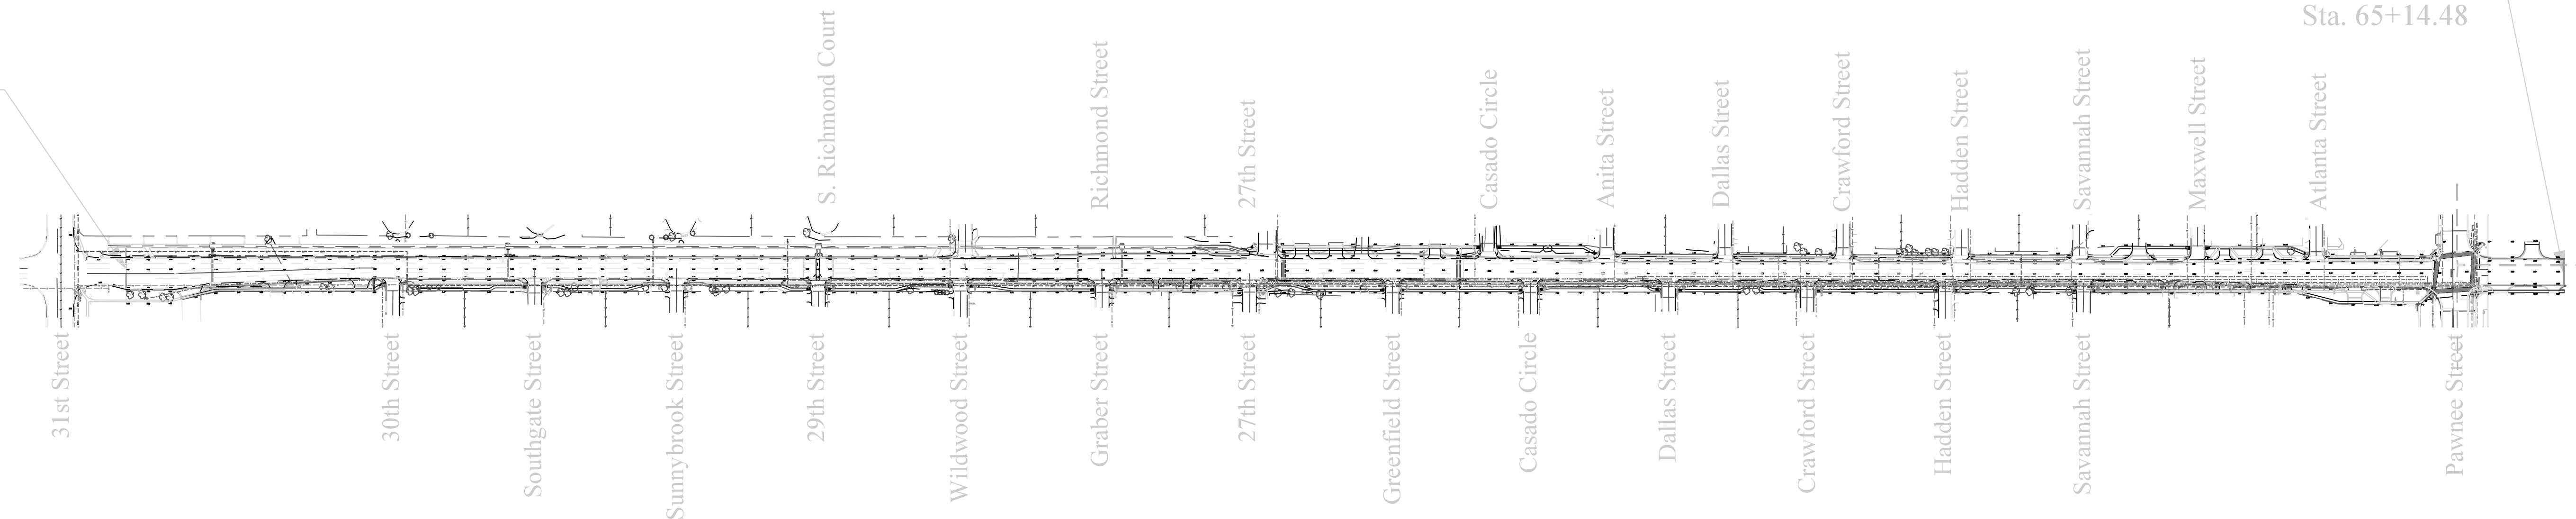

PROJECT AREA

GROSS LENGTH OF PROJECT 5,361.8 ft.


EXCEPTIONS 0 ft.

Legend

- Existing Water Line
- Electric Line
- Gas Line
- Telephone Line
- Cable TV Line
- Center Line
- Existing Right-of-Way
- Power Pole
- Electric Meter
- Luminaire
- Yard Light
- Pull Box
- Signal Control Box
- Mast Arm
- Pedestal Mounted Signal

- Telephone Manhole
- Telephone Pedestal
- Telephone
- Cable Television Box
- Water Valve
- Water Meter
- Fire Hydrant
- Sprinkler Head
- Irrigation Control Valve
- Air Release
- Gas Monitoring Station
- Gas Meter
- Gas Testing Station
- Gas Filler Cap
- Sanitary Sewer Manhole

- T.M.H.
- PHONE
- W.V.
- W.M.
- S.H.
- I.C.V.
- A.R.
- G.M.S.
- G.M.
- G.T.S.
- G.F.C.
- S.S.M.H.

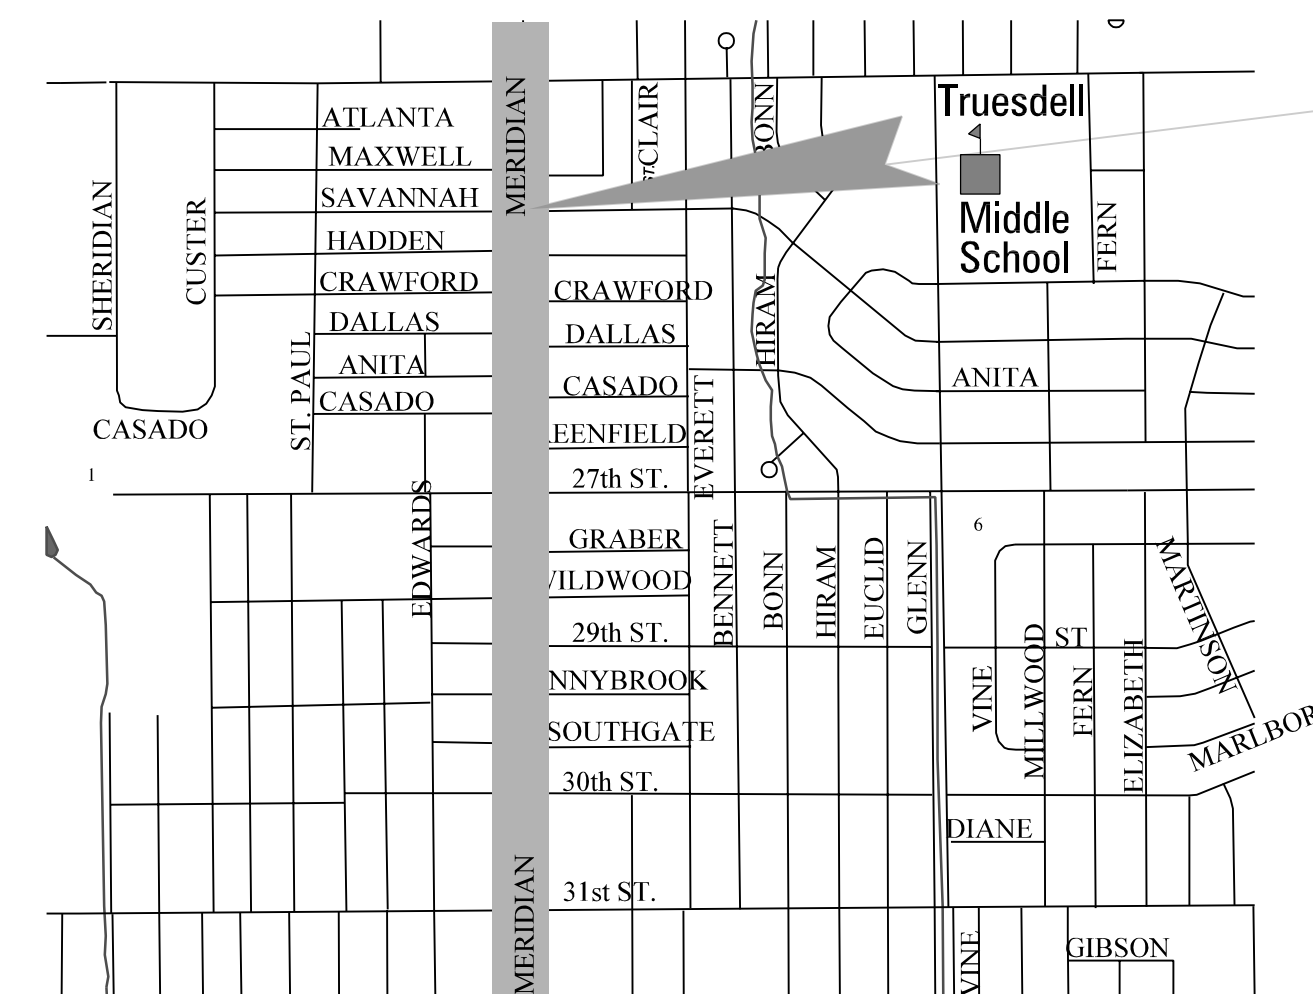

Vicinity Map

Project Location

ENGINEER

DATE

PREPARED BY
TRANSYSTEMS CORPORATION

245 North Waco Suite 420
Wichita, Kansas

APPROVED - DATE

CITY OF WICHITA, KANSAS

RECOM. FOR APPROVAL-DATE

CHIEF, BUREAU OF LOCAL PROJECTS
KANSAS DEPARTMENT OF TRANSPORTATION

APPROVED - DATE

STATE TRANSPORTATION ENGINEER
KANSAS DEPARTMENT OF TRANSPORTATION



245 North Waco, Suite 420 - Wichita, Kansas 67202

BY	DATE

REFERENCES NOTED	REFERENCES CHECKED

Drawn By: \$USER\$ Plotted: \$SYTIME\$
File: \$DGN\$