


Saved: 02-27-2007 3:31:10 PM by WAN
 P:\006\06237\06237-SHEET.E07
 E:\2006\06237\06237-SHEET.E07

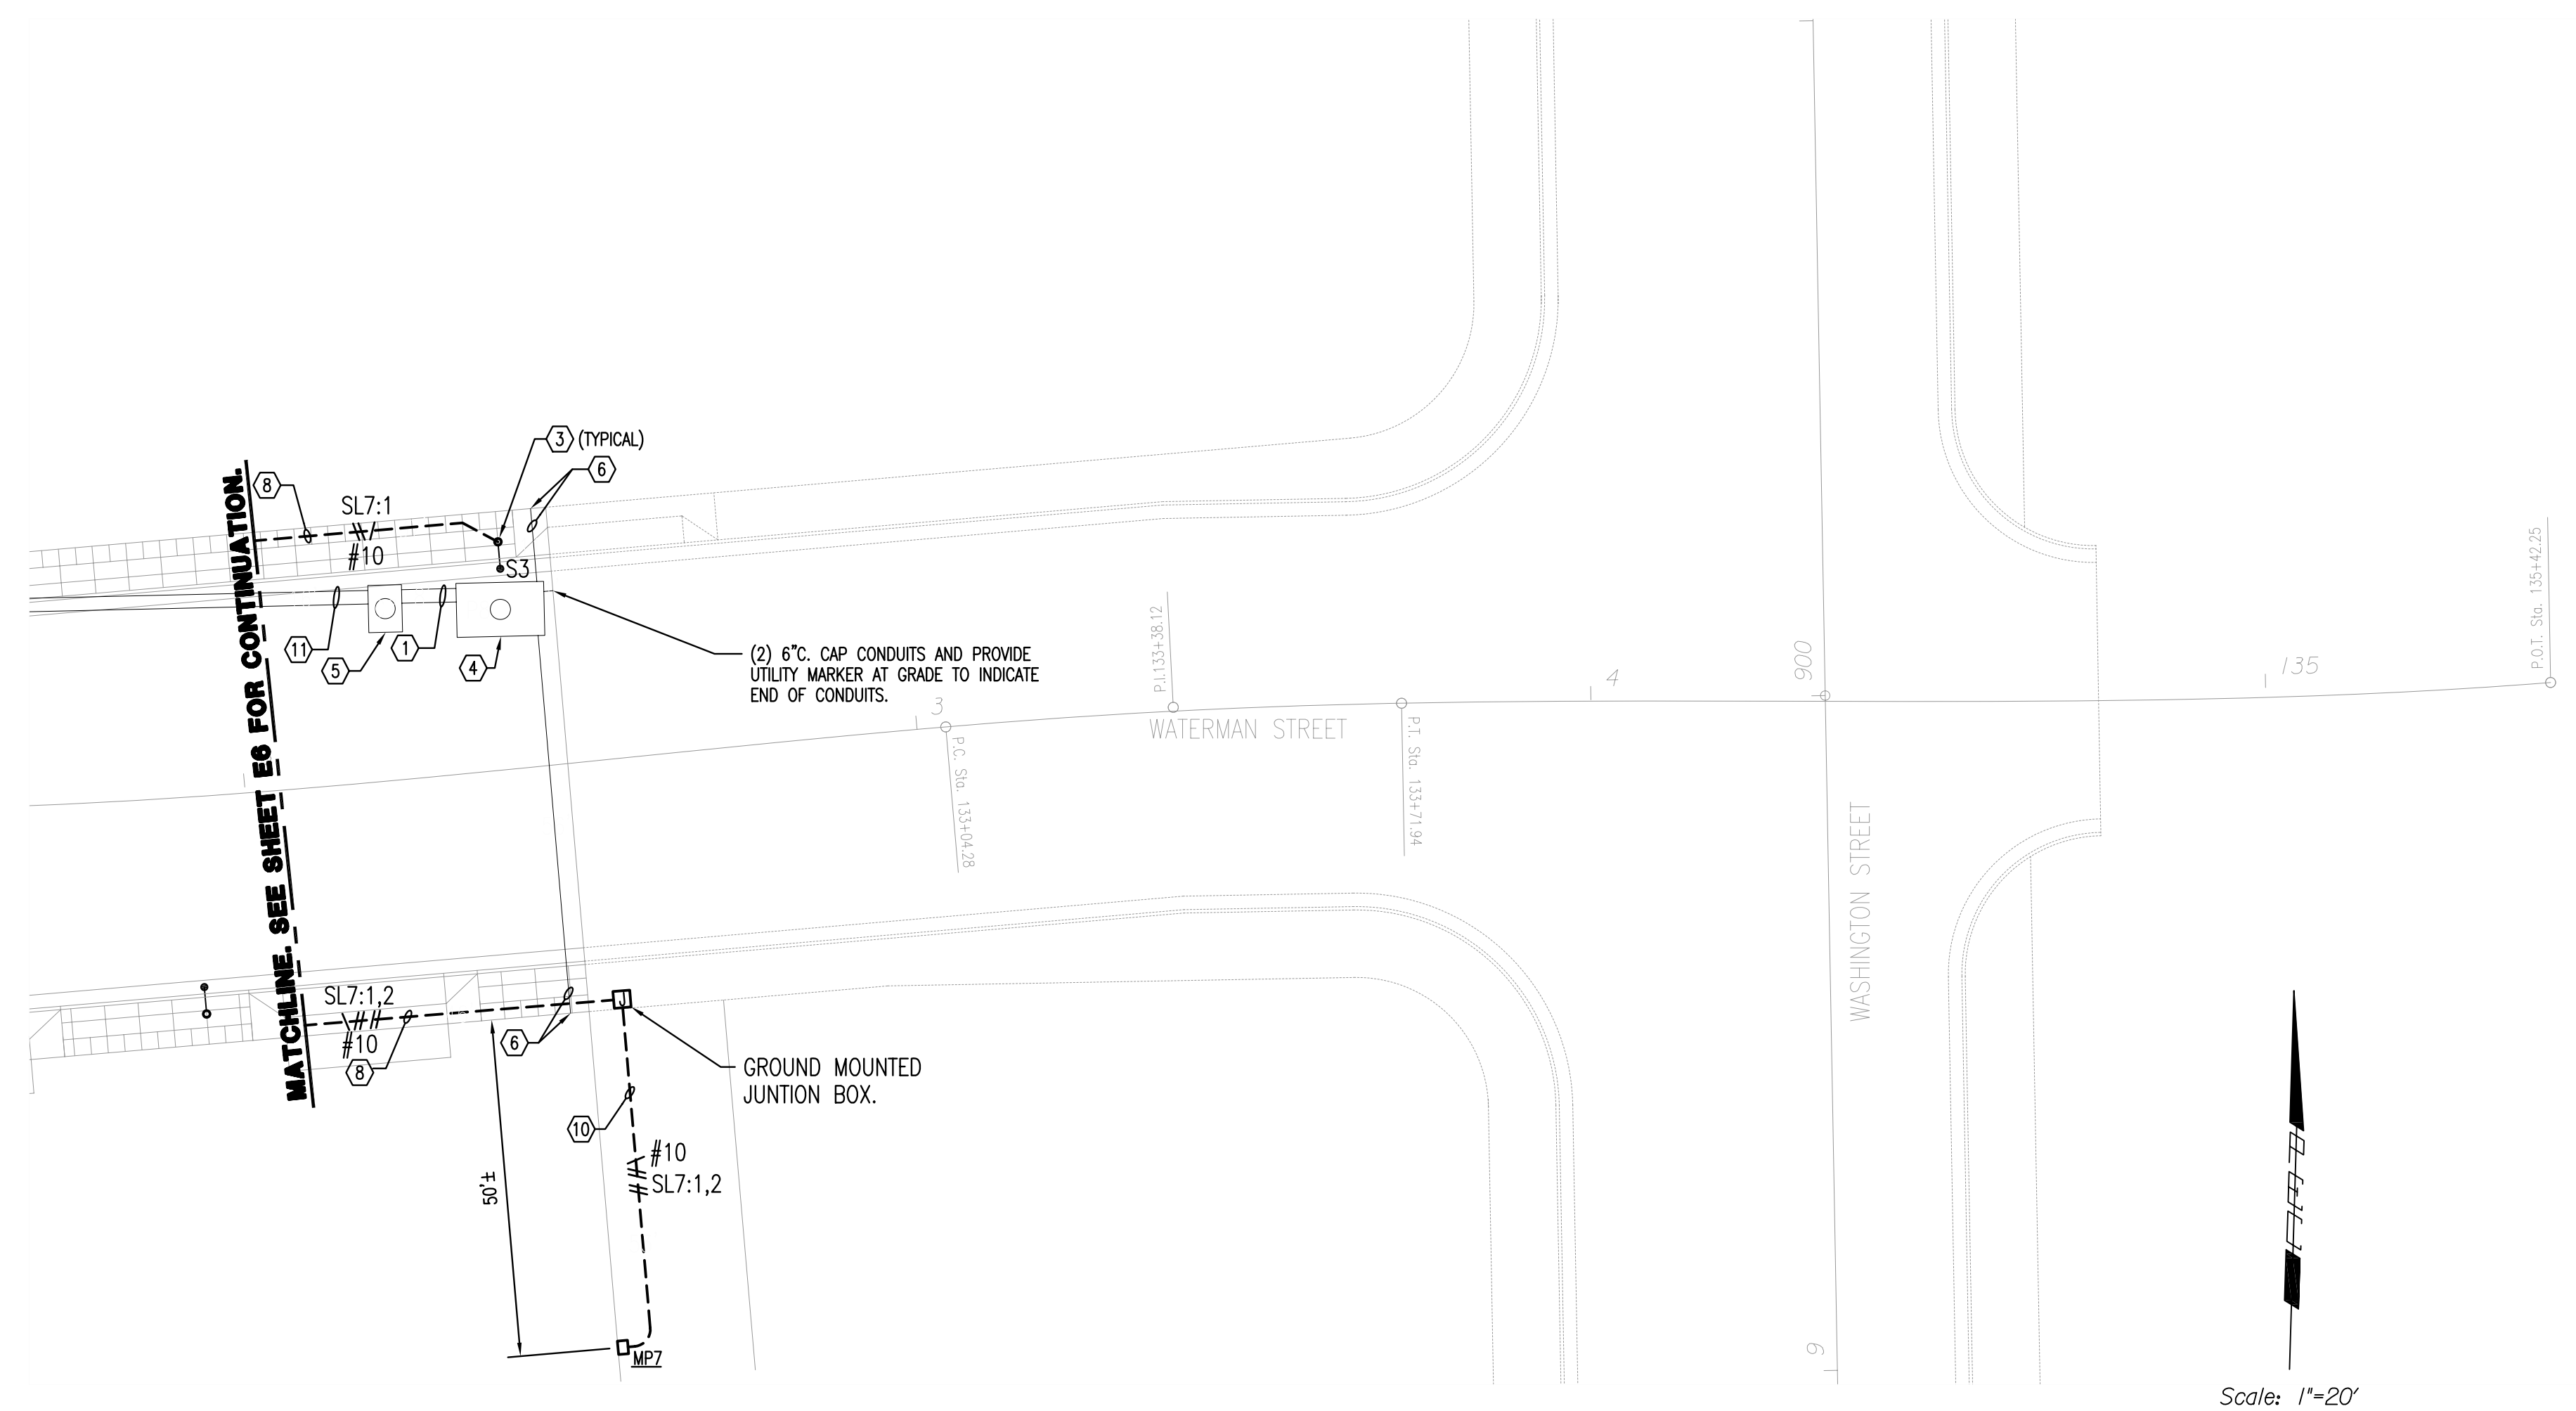

KEYED NOTES:

- ① (6) 6" POWER DUCTBANK. SEE ELECTRICAL DUCTBANK PLAN DETAILS.
- ② NOTE NOT USED.
- ③ STREET LIGHTING POLE. LETTER DESIGNATES POLE/FIXTURE TYPE. SEE POLE DETAIL SHEET AND LIGHTING FIXTURE SCHEDULE FOR ADDITIONAL INFORMATION.
- ④ ELECTRICAL POWER MANHOLE. SEE ELECTRICAL DUCTBANK PLANS FOR EXACT LOCATION AND ADDITIONAL INFORMATION. COMMUNICATION CONDUITS SHALL PASS THROUGH MANHOLE UNBROKEN.
- ⑤ ELECTRICAL COMMUNICATIONS MANHOLE. SEE ELECTRICAL DUCTBANK PLANS FOR EXACT LOCATION AND ADDITIONAL INFORMATION. POWER CONDUITS SHALL PASS THROUGH MANHOLE UNBROKEN.
- ⑥ (1) 6" CONDUIT WITH PULL ROPE ROUTED TO ALLEY FOR FUTURE WESTAR USE. CAP CONDUIT AND PROVIDE UTILITY MARKER AT GRADE TO INDICATE END OF CONDUIT.
- ⑦ NOTE NOT USED.
- ⑧ (1) 2" RGS CONDUIT WITH PULL ROPE FOR STREET LIGHTING CIRCUITING.
- ⑨ NOTE NOT USED.
- ⑩ CONTINUE (1) 2" RGS CONDUIT THROUGH ALLEY AND TO ENCLOSURE FOR STREET LIGHTING CIRCUITS TERMINATION. SEE SHEET R43 FOR ALLEY PAVEMENT CUT & PATCH DETAIL.
- ⑪ (6) 6" (POWER) AND (6) 4" (COMM.) DUCTBANK SEE ELECTRICAL DUCTBANK PLAN DETAILS.

	Revision	By	Date
	WATERMAN STREET		
ELEC. STREETScape PLAN			
STA. 132+00 TO STA. 135+00			
JAMES L. ARMOUR, P.E.—CITY ENGINEER CITY OF WICHITA PROJECT NO. 468-84167			
Professional Engineering Consultants, P.A. 303 S. TOPEKA • WICHITA, KANSAS 67202 316-262-2691 • FAX 316-262-3003			
Designed by	SMS	Job No.	06237
Drawn by	WAN	Date	February, 2007
			Sht. E7 of 8

