

ARKANSAS RIVE

18500E
4500N

Kc 11093
Down town
1990
Drainage

MENTOR

MCLEAN

TAFT

#380
Sta. 277+00.00 Const.
Median Inlet, Type 4, 7.09' Lt.
Install 18" x 298' Stm. Sew.
See Sht. 103, 118

#381
Sta. 274+00.00 Const.
Median Inlet, Type 4, 4.86' Lt.
Install 18" x 64' Stm. Sew.
See Sht. 103, 118


#383
Sta. 272+00.00 Const.
Median Inlet, Type 4 Modified, 4.86' Lt.
Install 15" x 64' Stm. Sew.
See Sht. 103, 118

#379
Sta. 277+00.00 Const.
Median Inlet, Type 4, 64.27' Rt.
Install 15" x 89' Stm. Sew.
See Sht. 103, 118

#382
Sta. 274+00.00 Const.
Median Inlet, Type 4, 61.86' Rt.
Install 24" x 198' Stm. Sew.
See Sht. 103, 118

#384
Sta. 272+00.00 Const.
Median Inlet, Type 4 Modified, 61.86' Rt.
Install 24" x 98' Stm. Sew.
See Sht. 103, 118
Remove temporary plug and connect
to existing 24" storm sewer.


NO	DATE	REVISIONS	BY	APP'D
3				
2				
1				

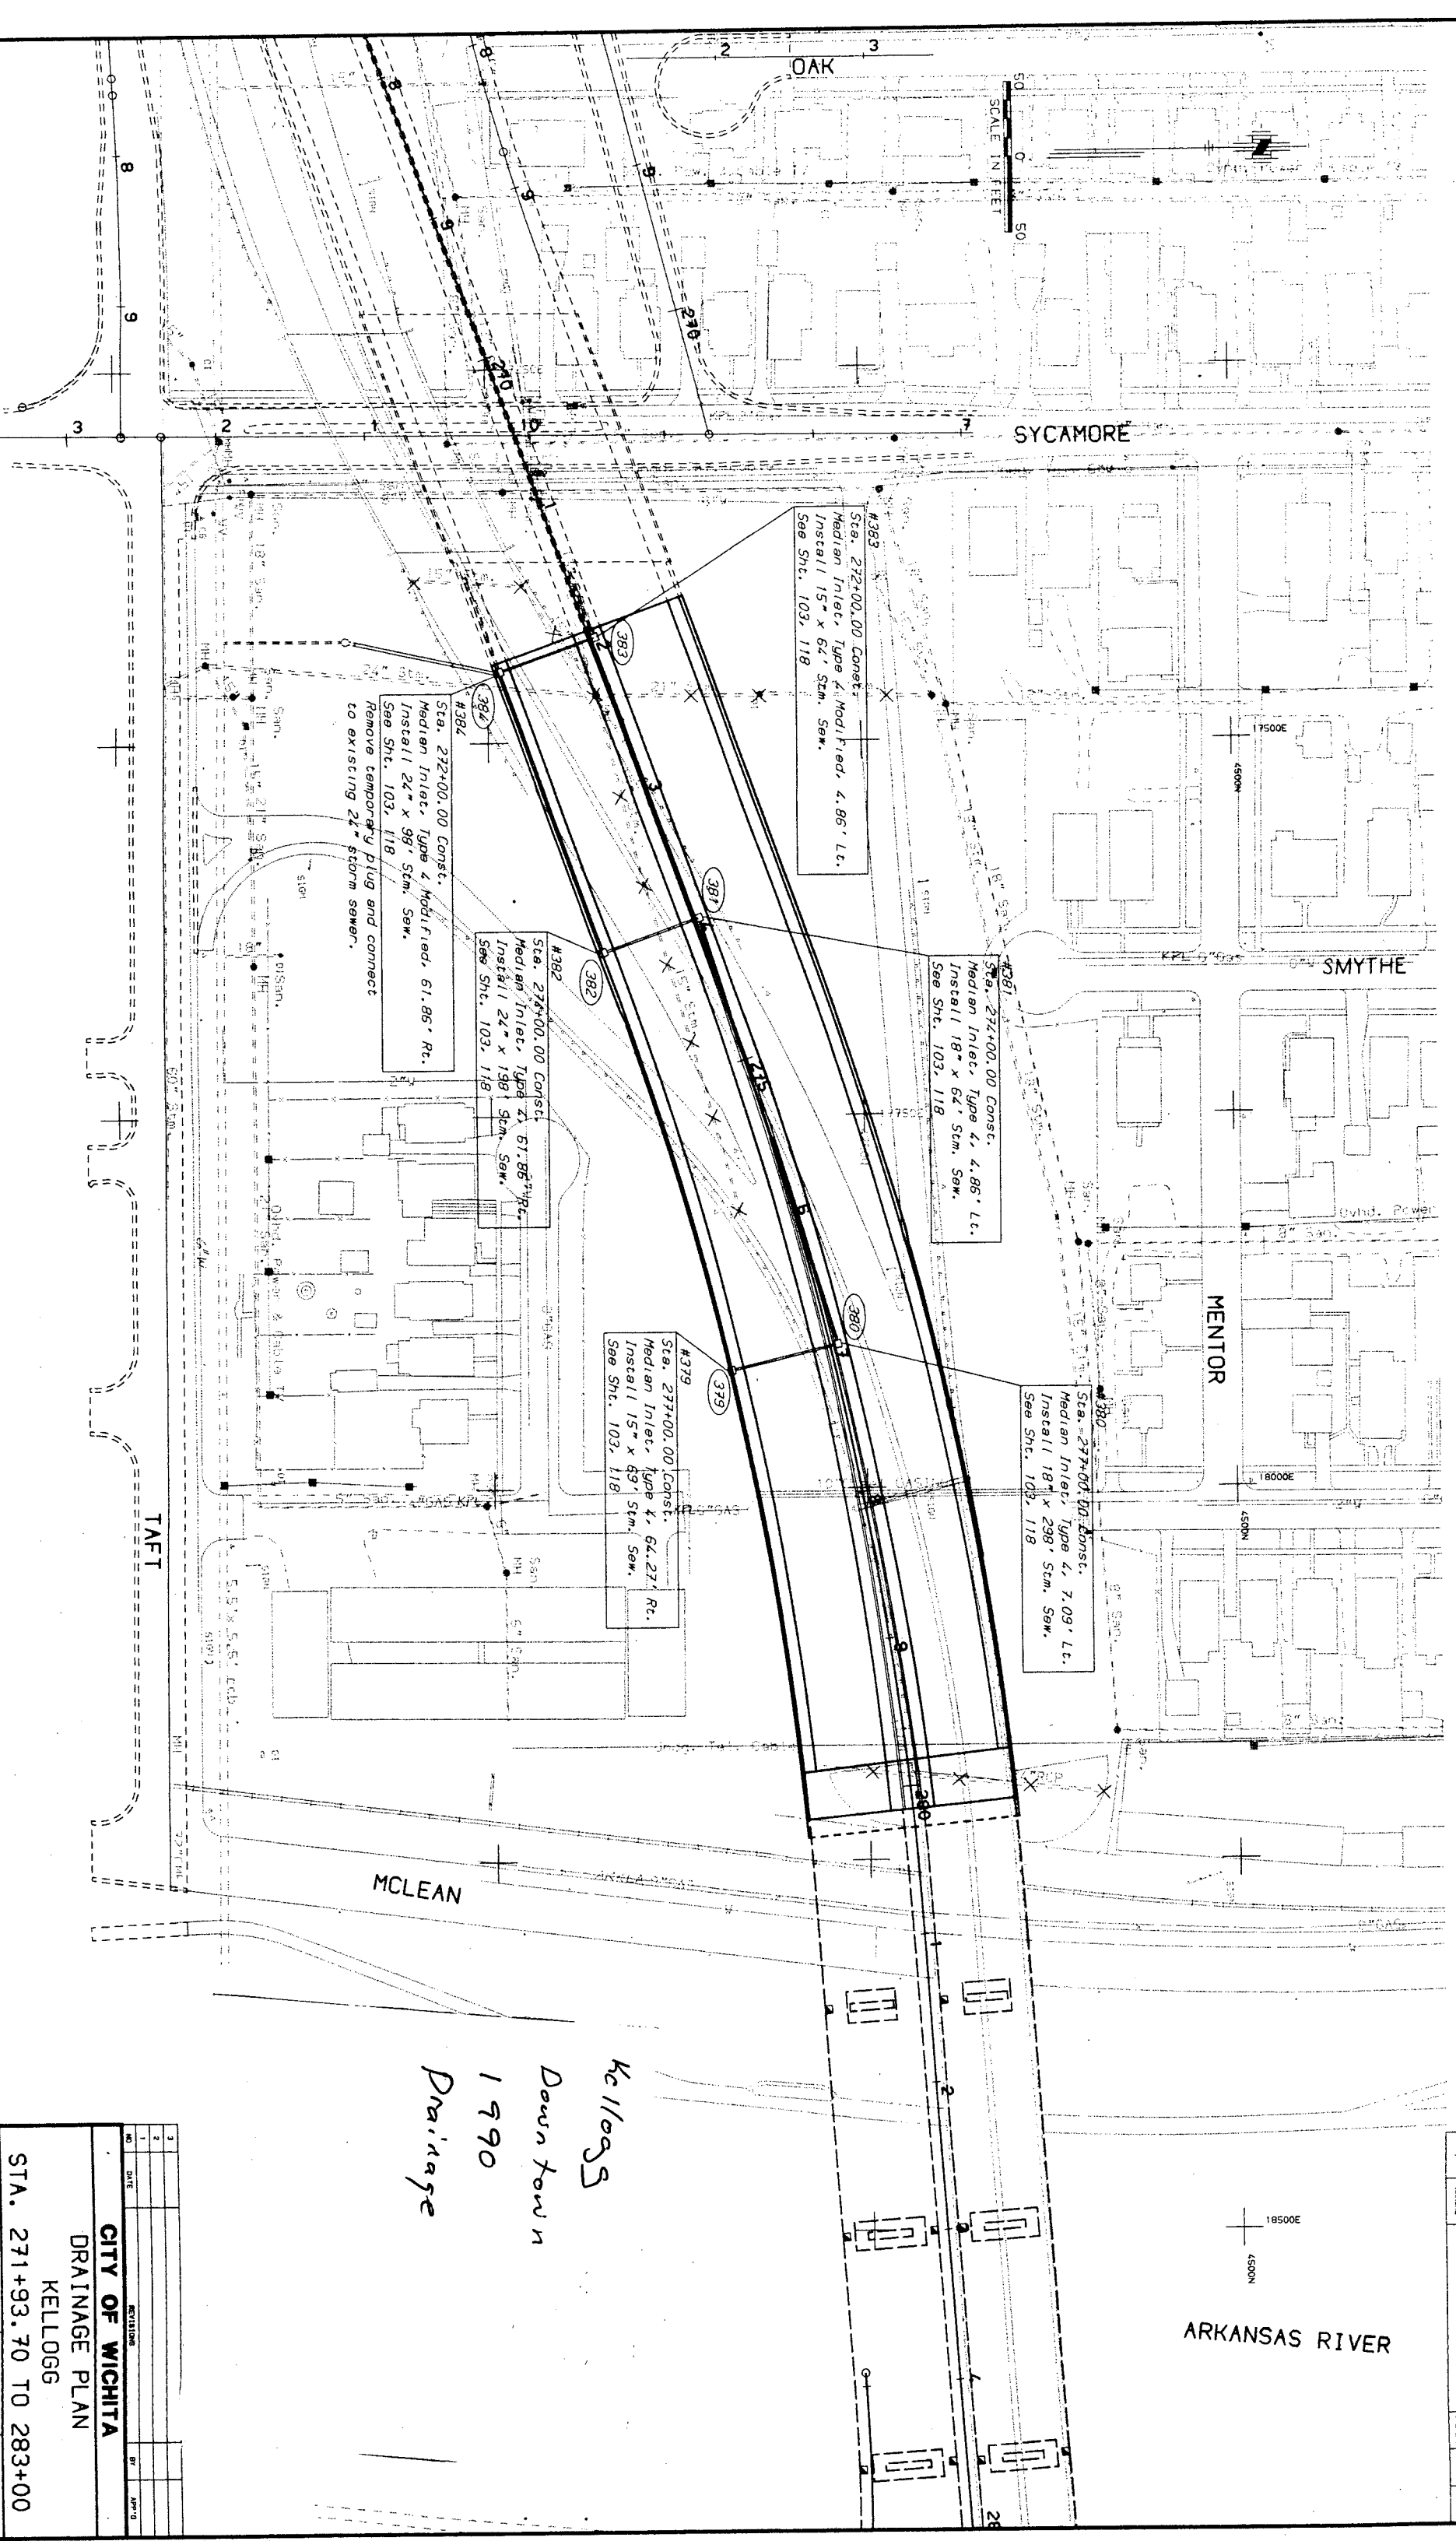

*Ke 11095
Down town
1990
Drainage*

PROJECT NO.	193082
DATE	7/60

PROJECT NO.	193082
DATE	7/60
CITY OF WICHITA	
DRAINAGE PLAN	
KELLOGG	
STA. 271+93.70 TO 283+00	
DESIGNED BY	HLO
CHECKED BY	AG
DATE	7/60

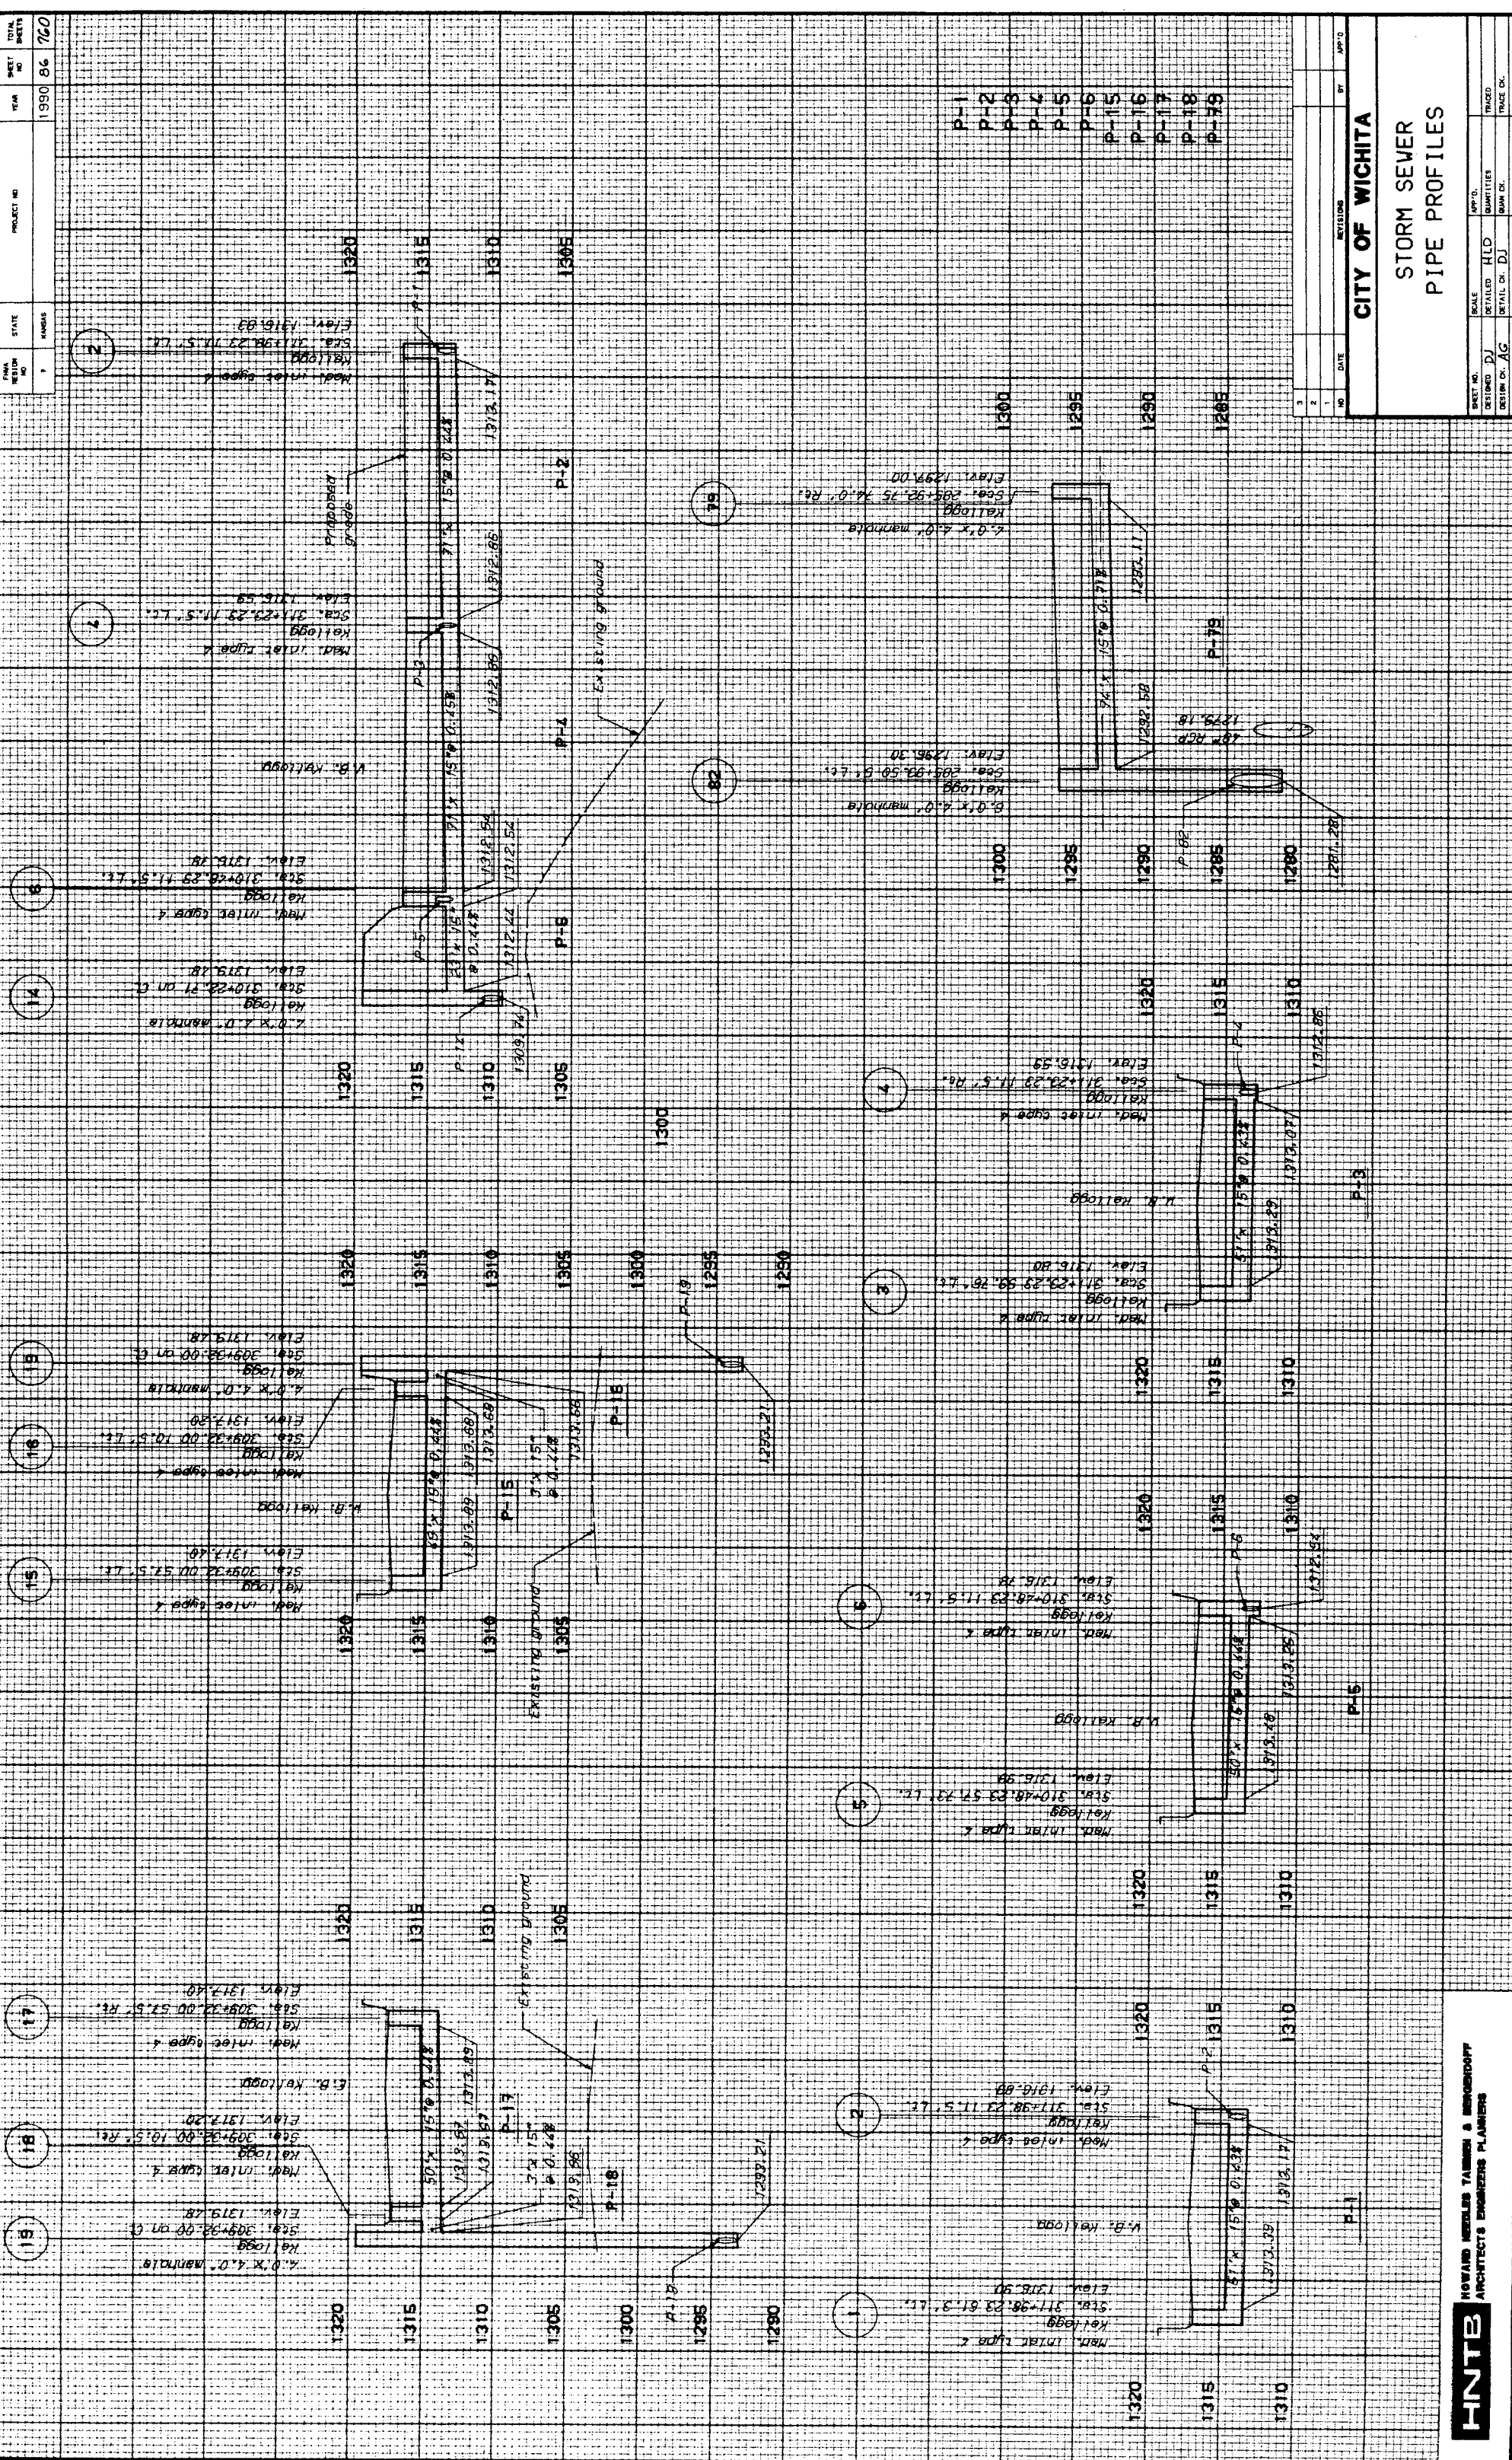

DATE	BY	REVISION
1980	84	7620


CITY OF WICHITA

STORM SEWER

PIPE PROFILES

DRAWN BY	CHECKED BY	DATE	SCALE	PROJECT NO.
EXTENDING	DJ		1" = 10'	
DESIGNED BY	DJ			
DATE	AG			


HNTB HOWARD NEEDLES TAMMEN & BERENDSON
ARCHITECTS ENGINEERS PLANNERS

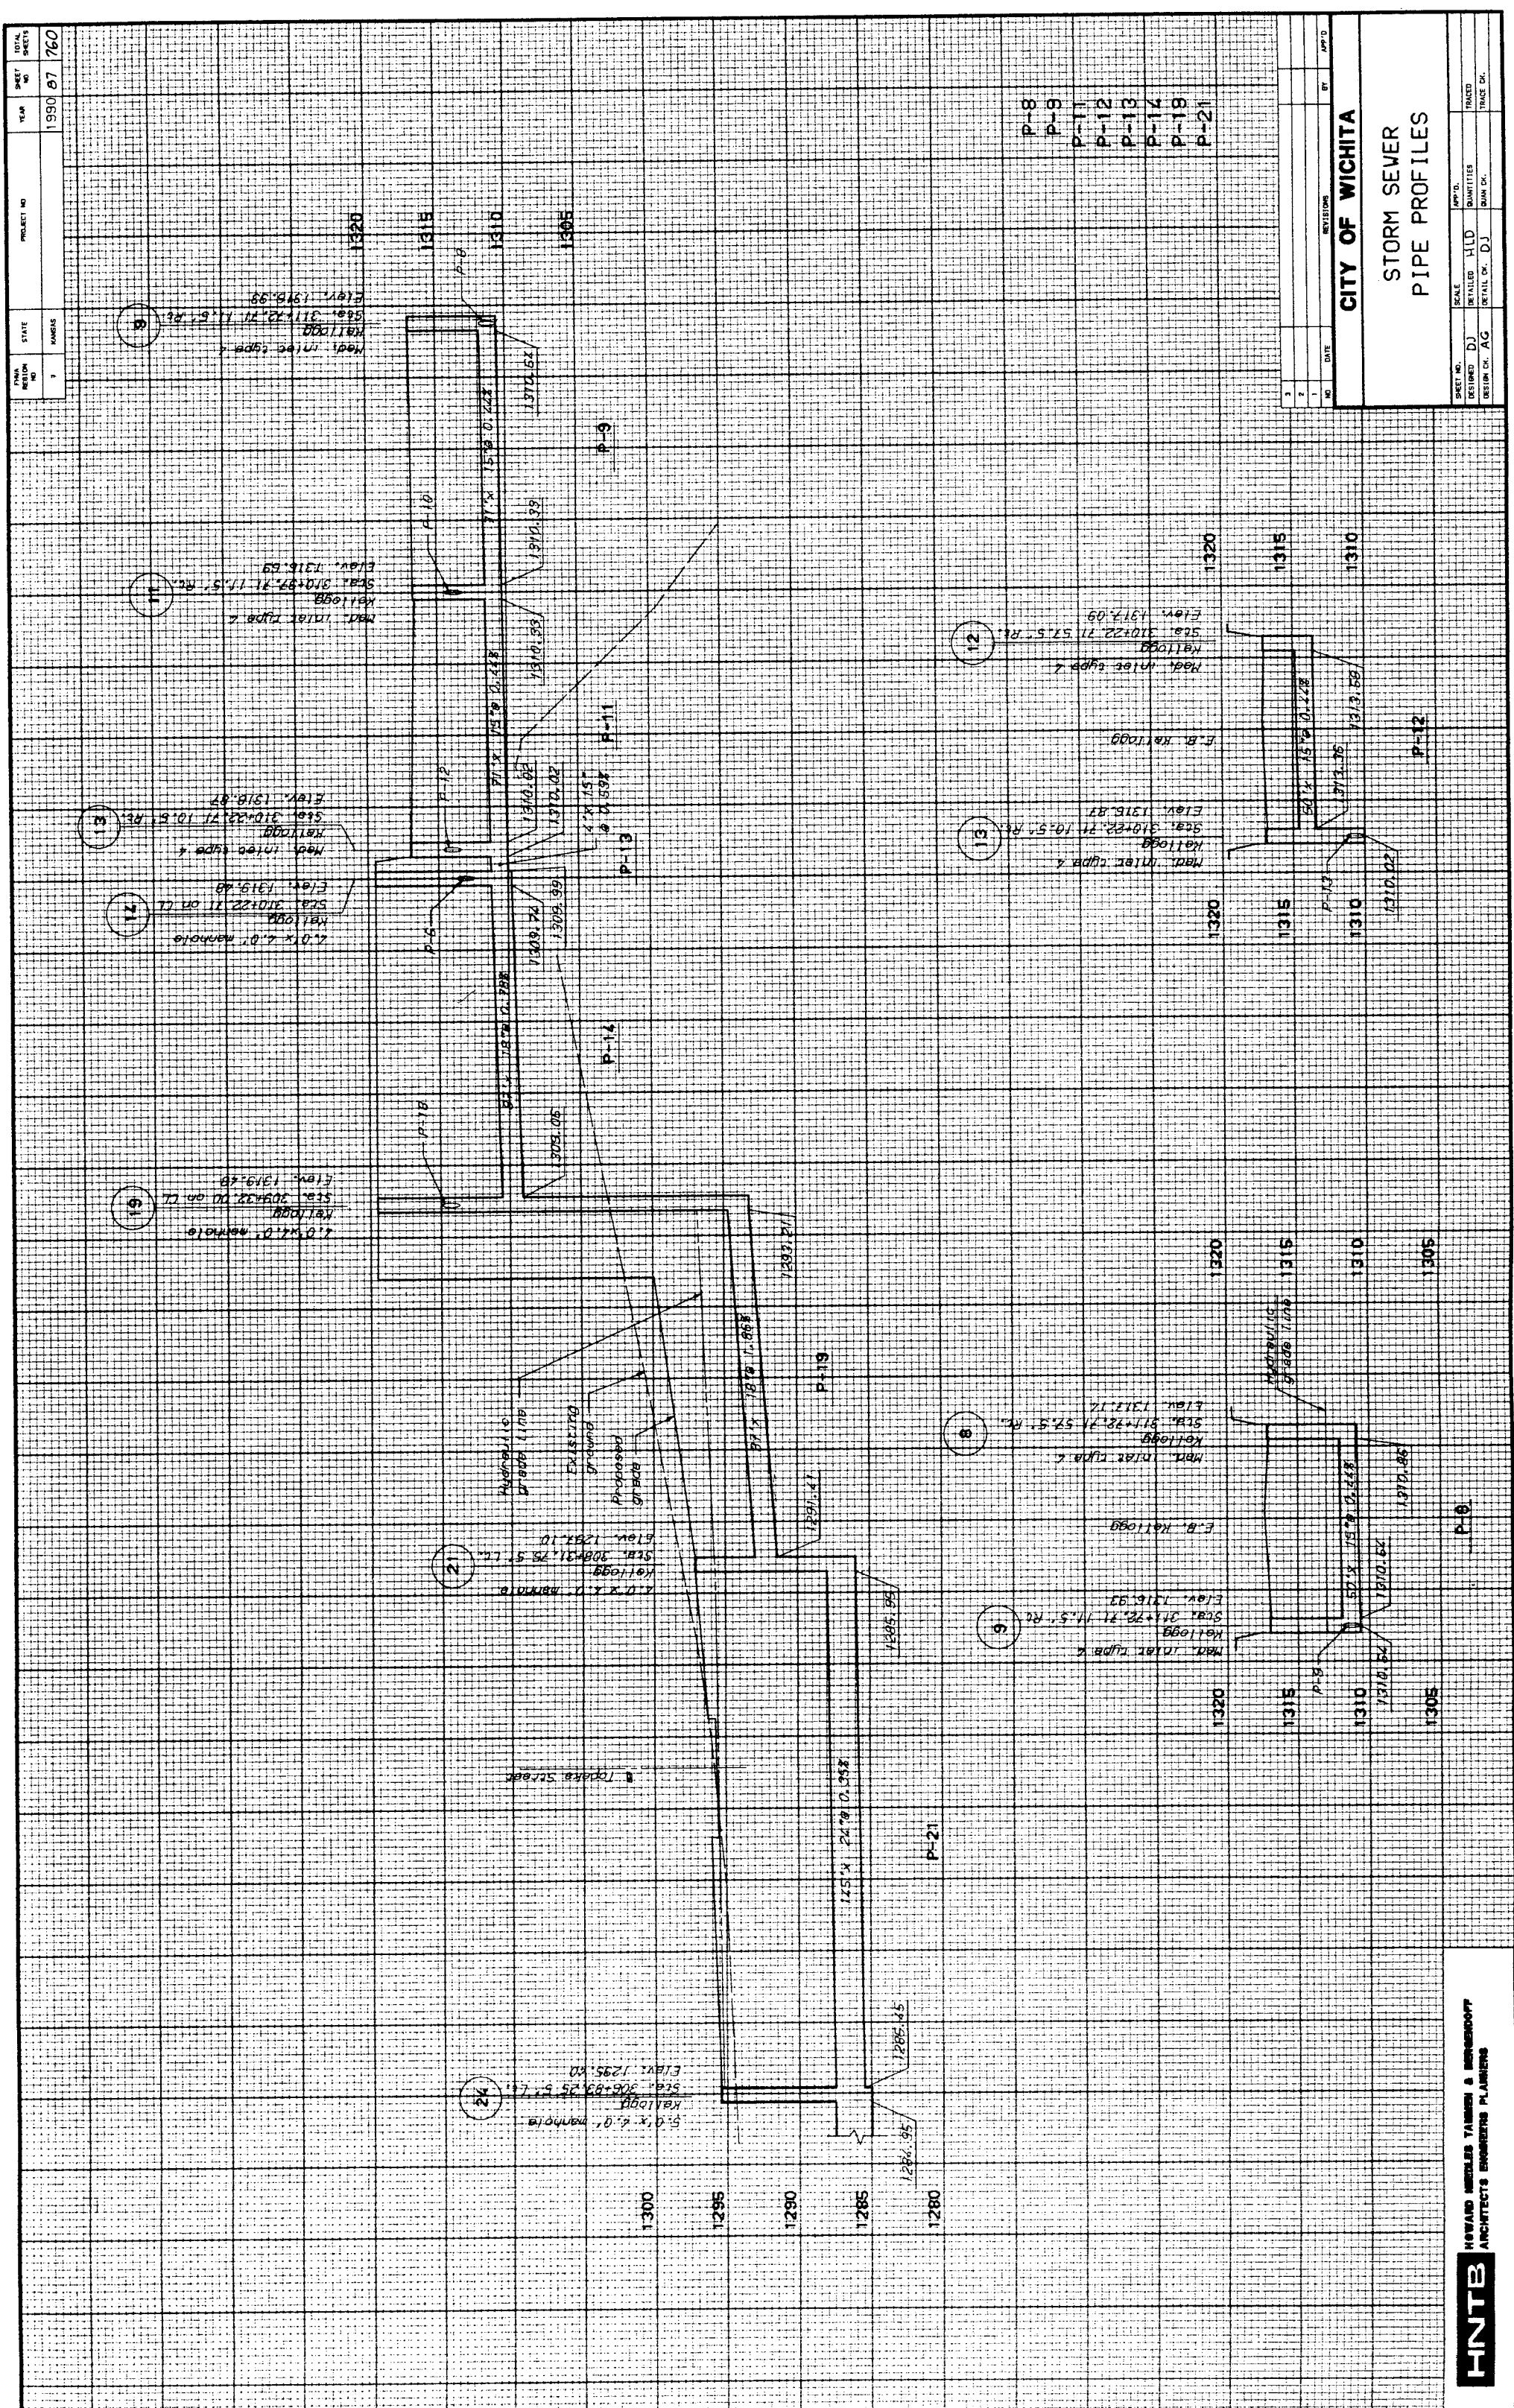

SHEET NO. 1
 PROJECT NO. 1994 07 160
 DATE 1994 07 160

CITY OF WICHITA
STORM SEWER
PIPE PROFILES

HNTB
 HNTB ARCHITECTS ENGINEERS PLANNERS

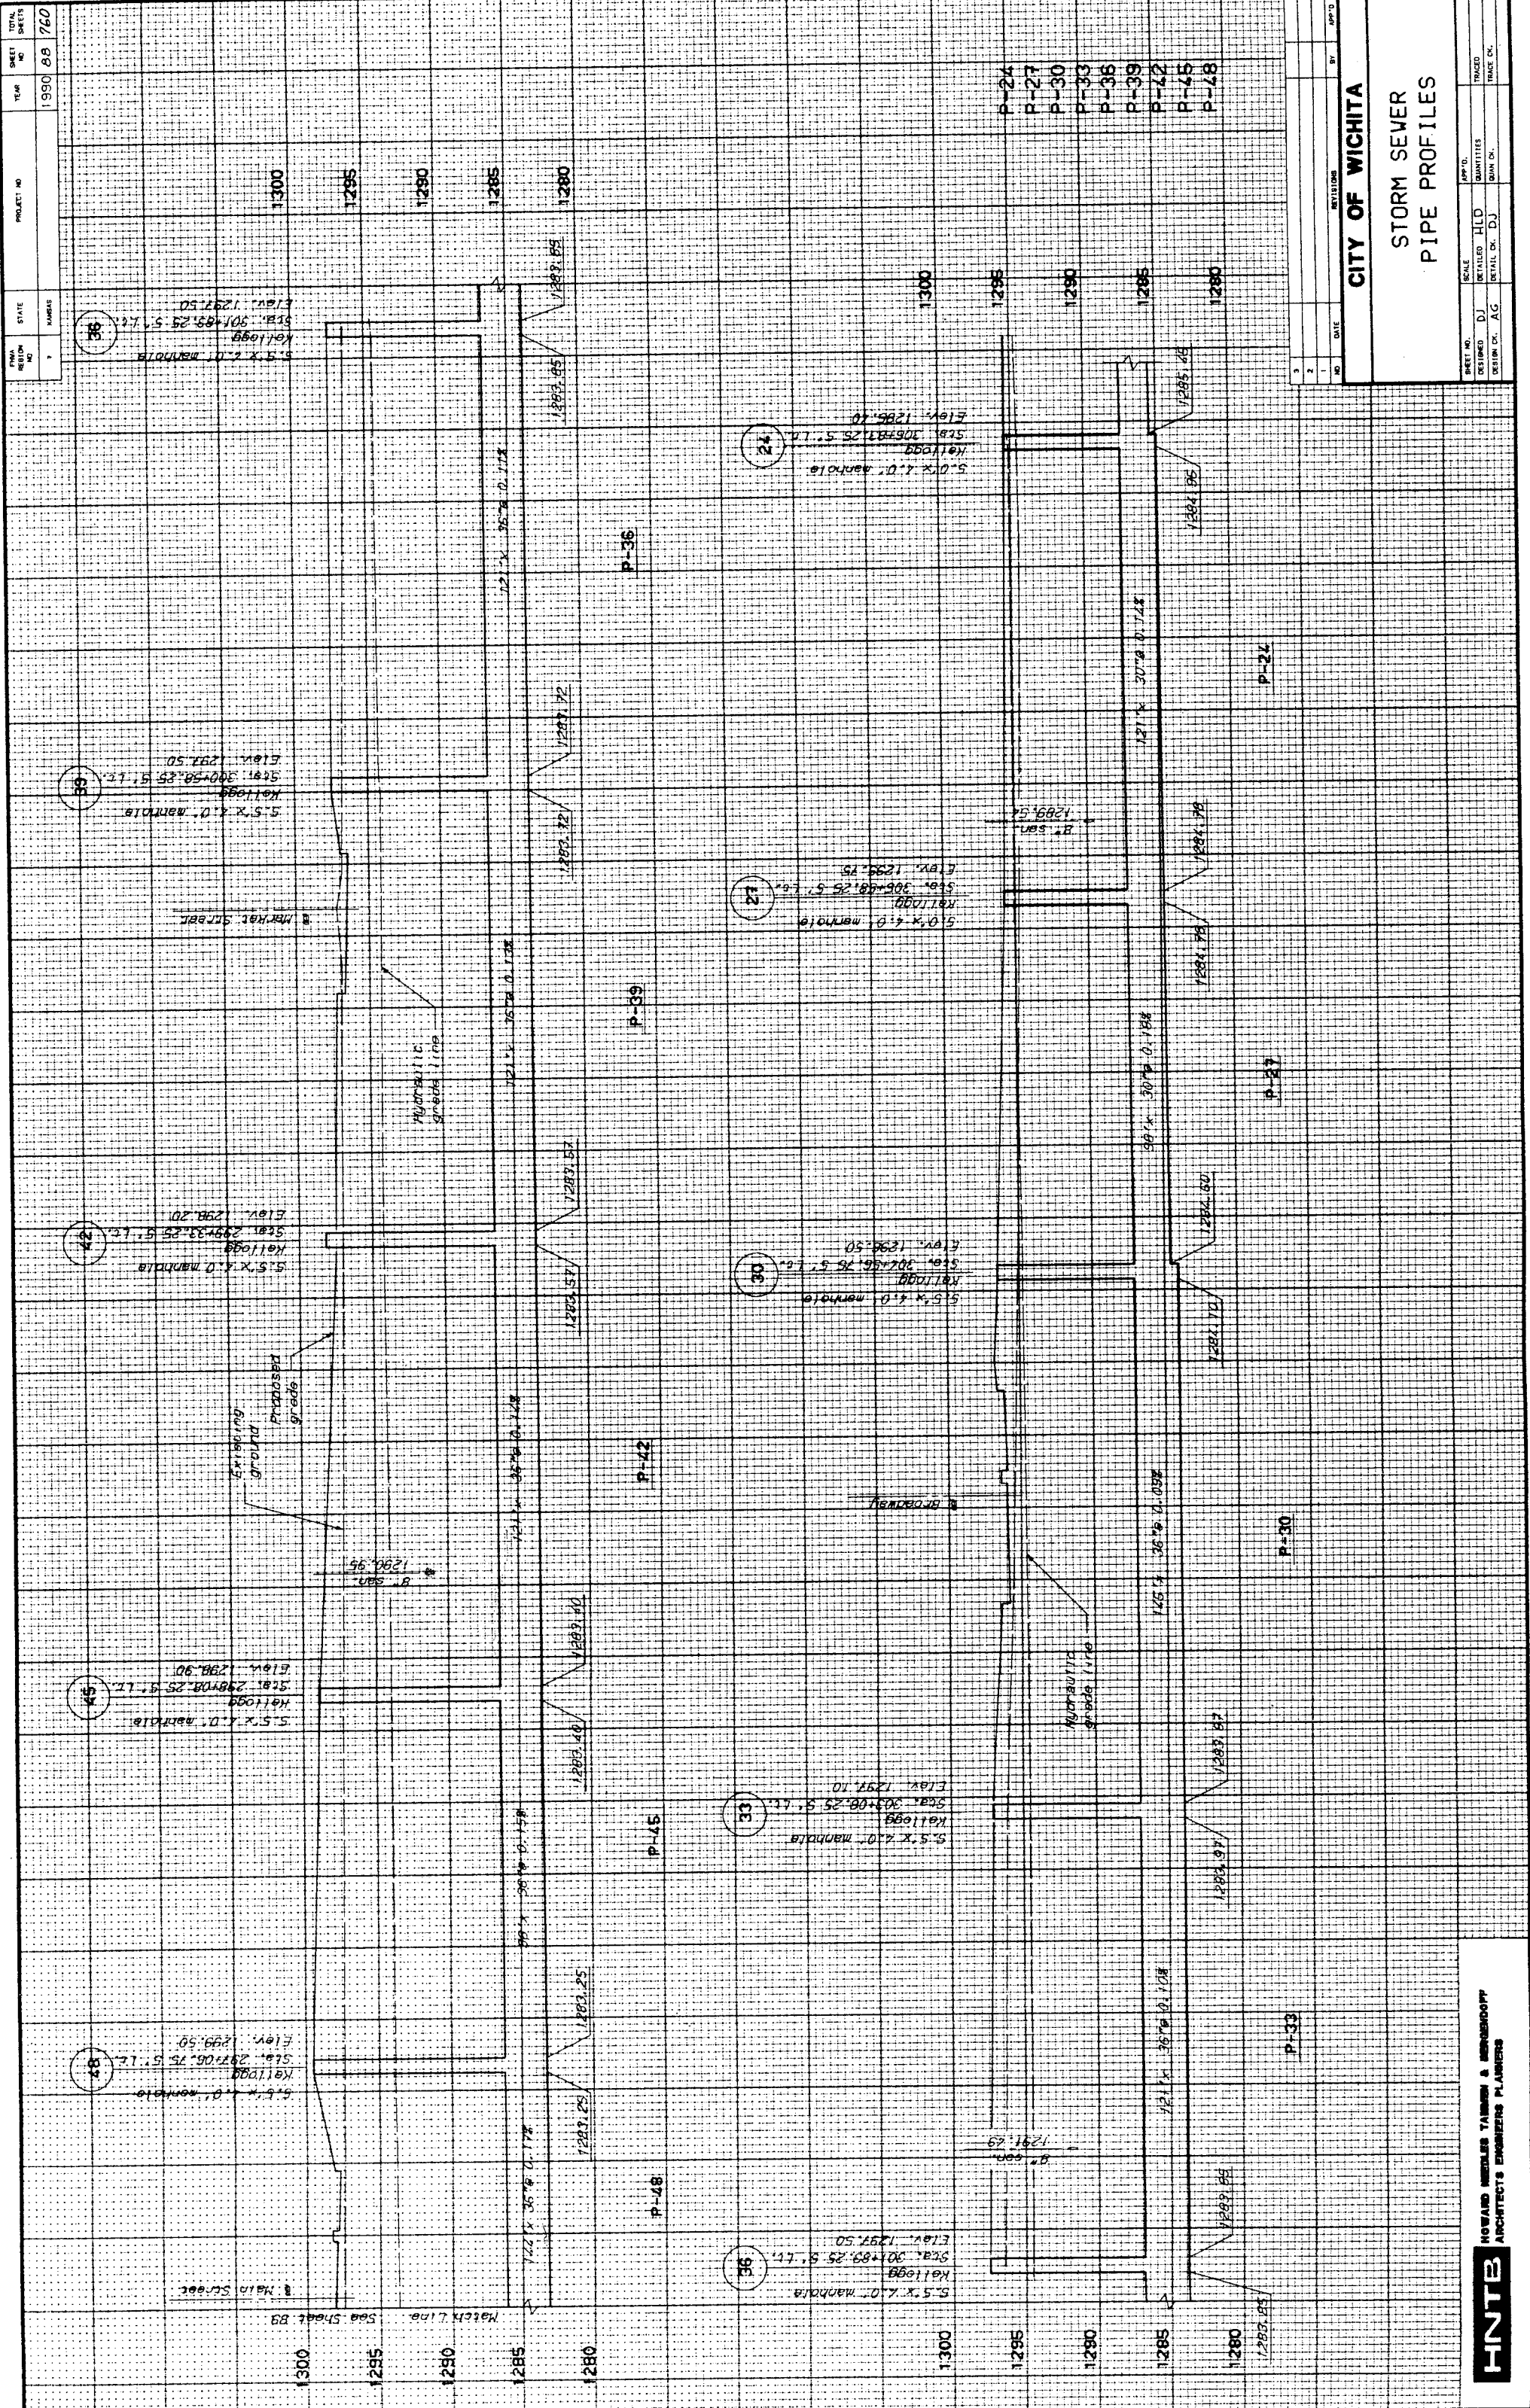

NO.	DATE	DESCRIPTION	BY	CHK.
1				
2				
3				




PROJECT NO.		1900 89 160
SHEET NO.		160
DATE		1900 89 160
DRAWN BY		
CHECKED BY		
APPROVED BY		

CITY OF WICHITA	
STORM SEWER	
PIPE PROFILES	

SCALE	DATE	BY	CHK.
AS SHOWN			
EXTEND TO	DATE	BY	CHK.

HNTB		HOWARD MEELES TANKER & ASSOCIATES
ARCHITECTS ENGINEERS PLANNERS		


PROJECT NO.	1990 90 762
DATE	1990 90 762
STATE	KANSAS
CITY	WICHITA
SCALE	AS SHOWN
DATE	
BY	
CHECKED	
APPROVED	

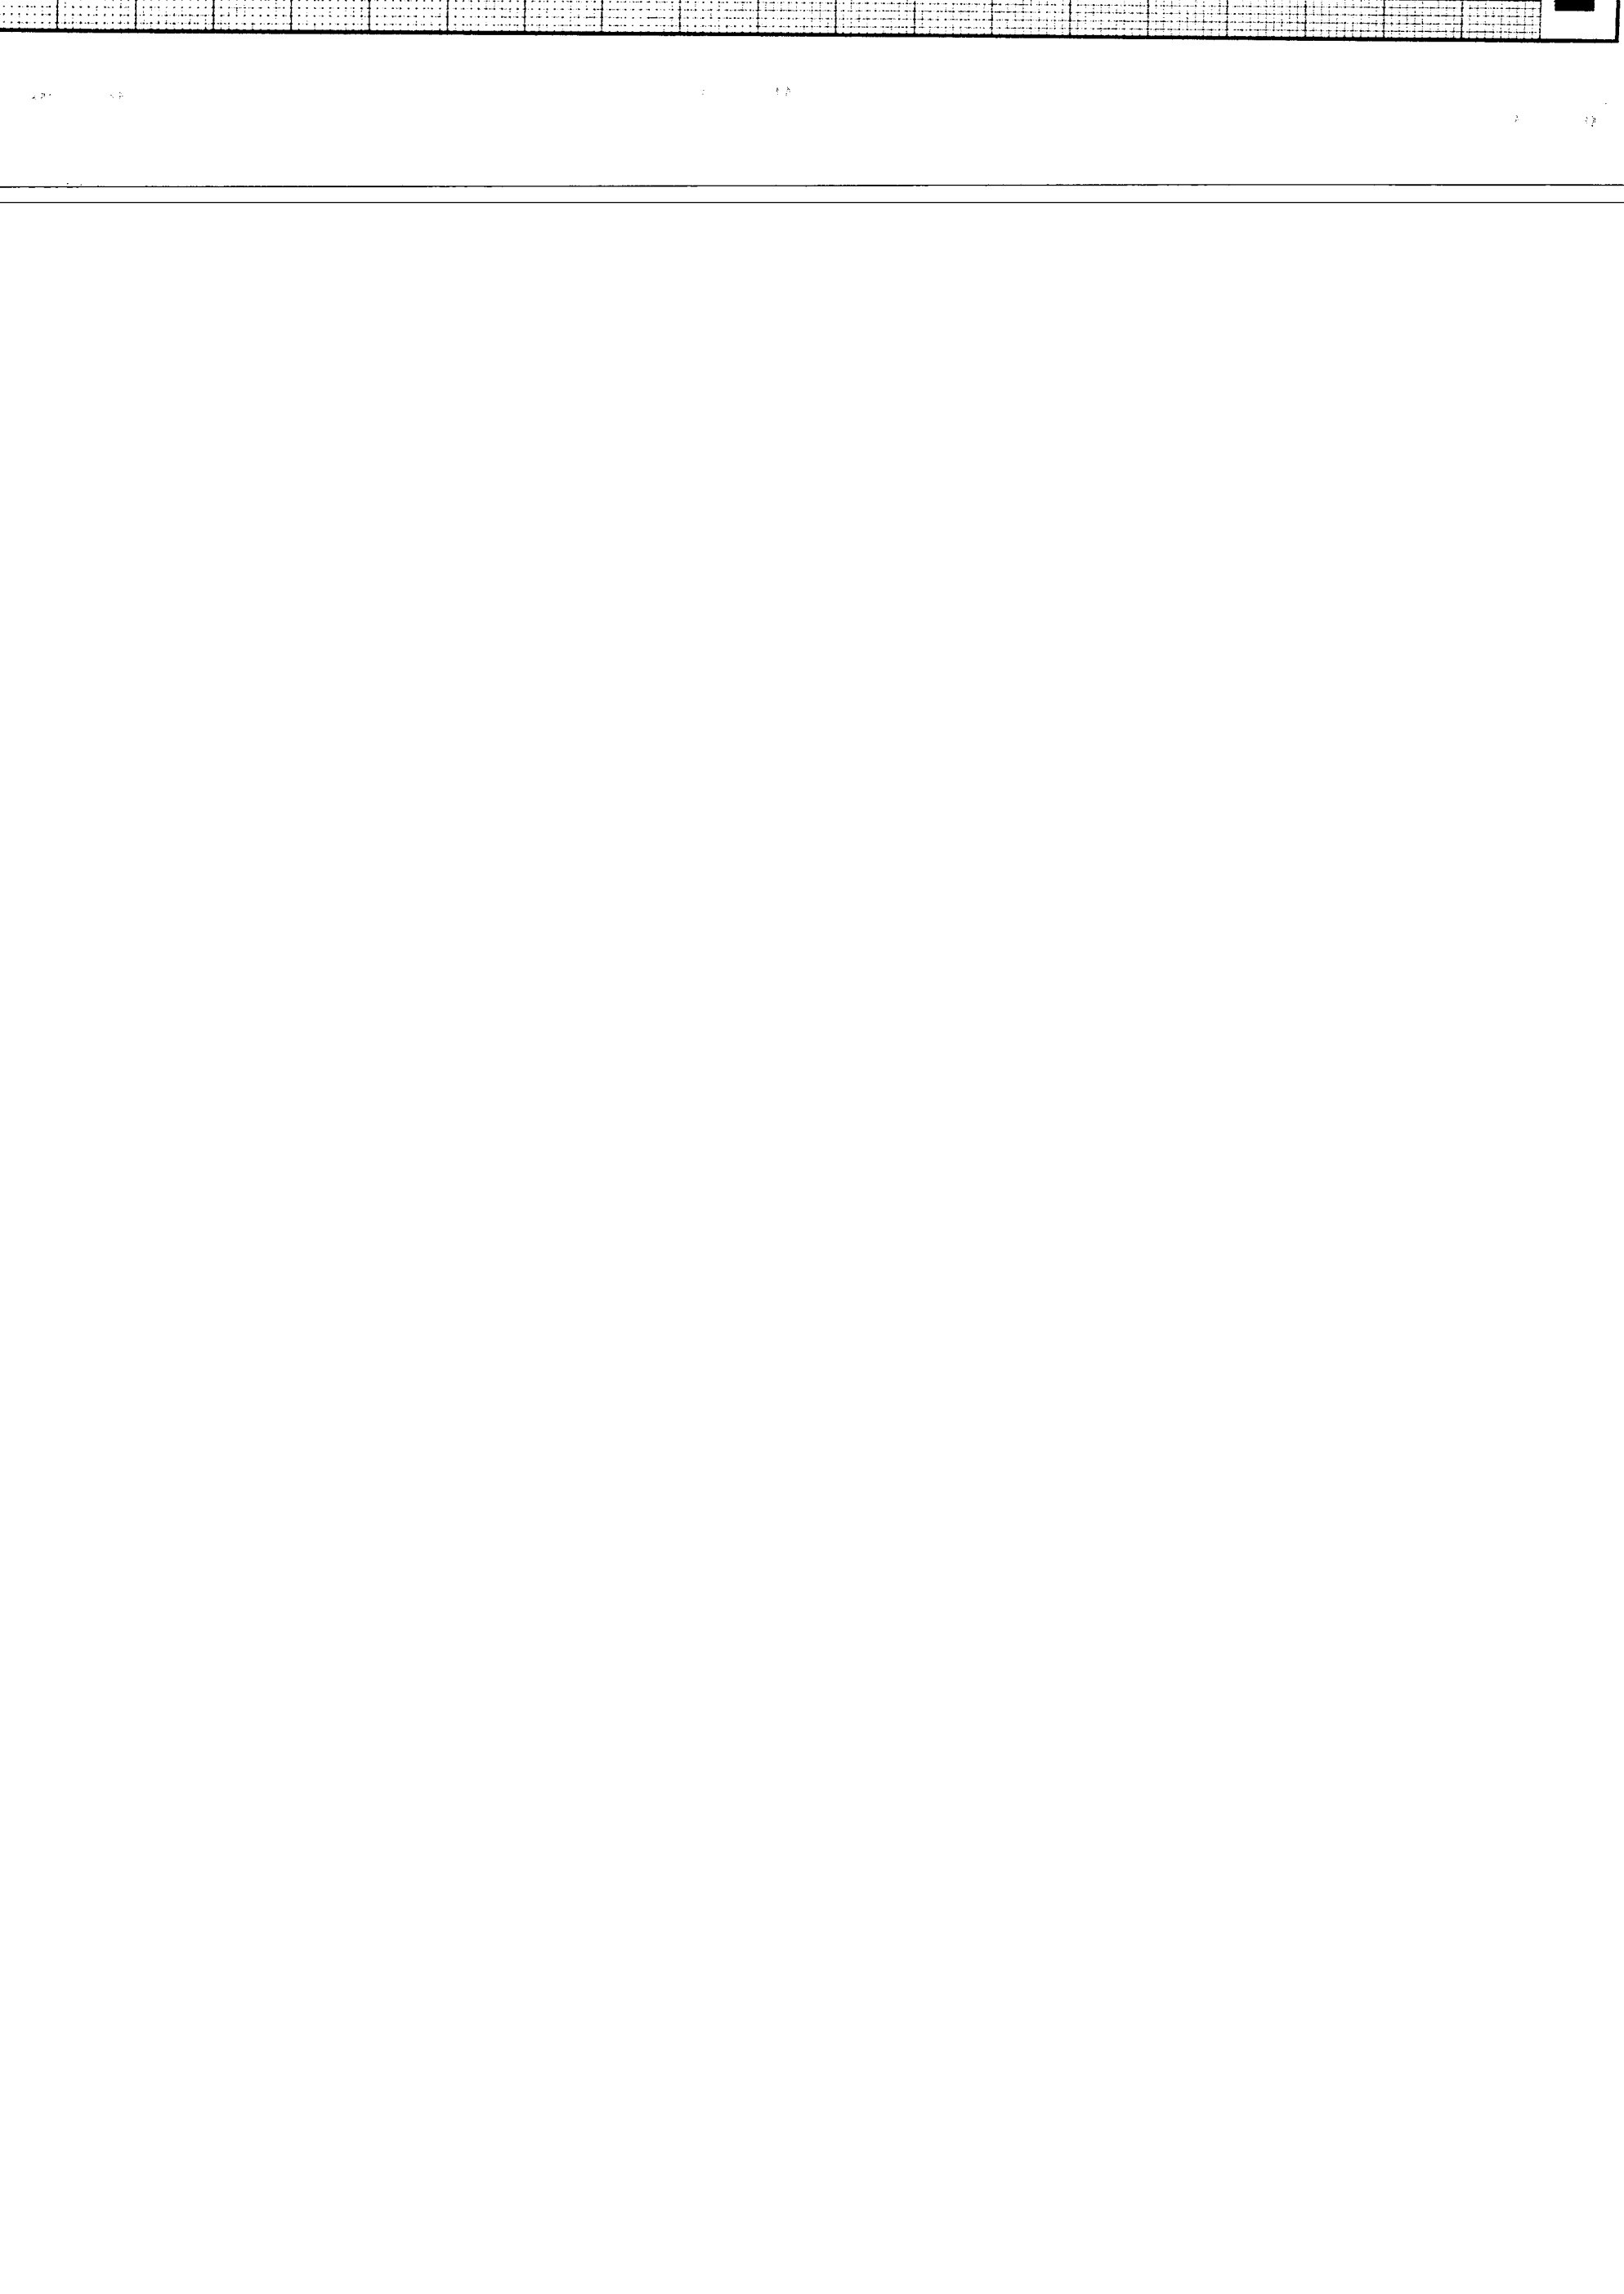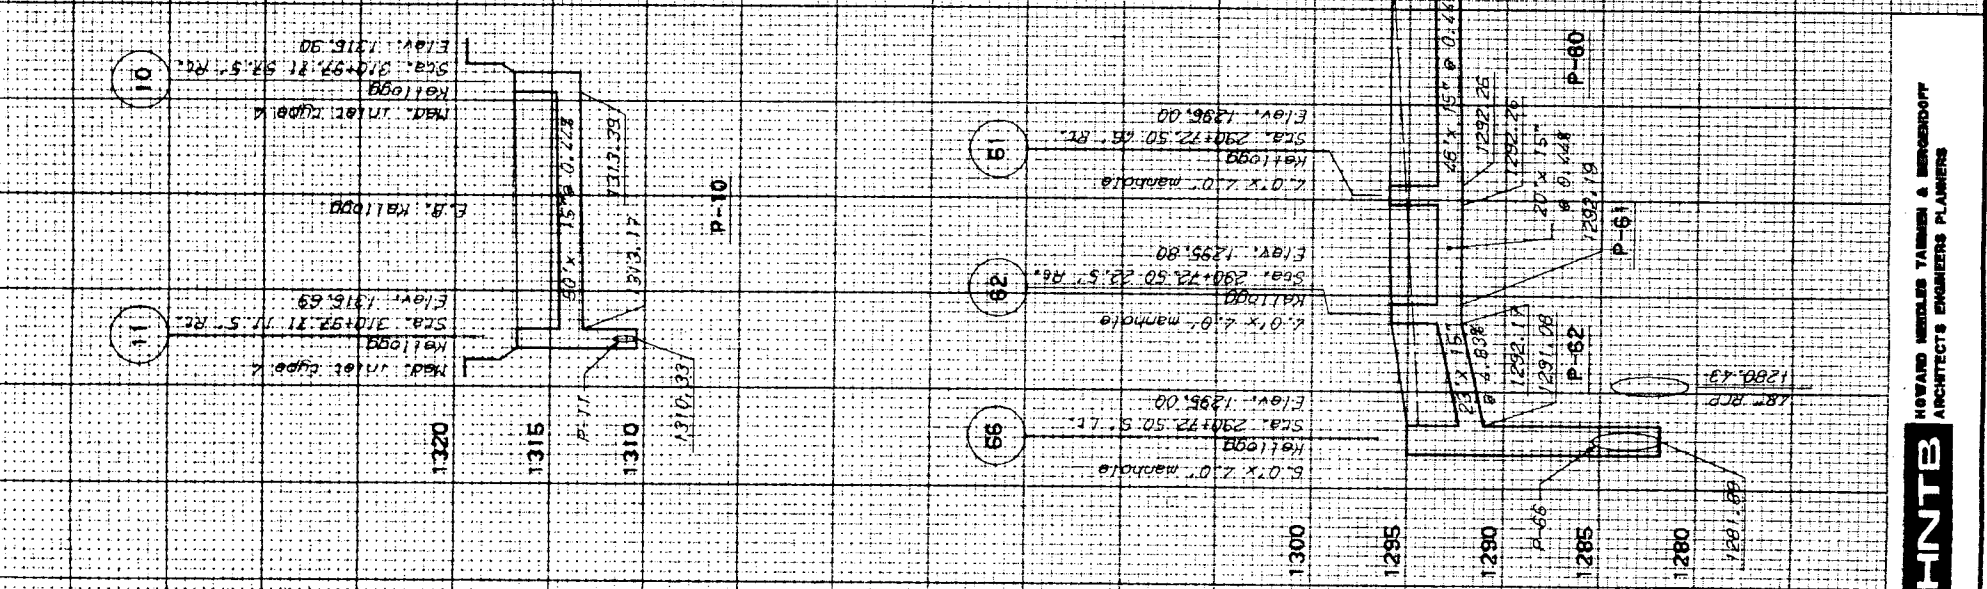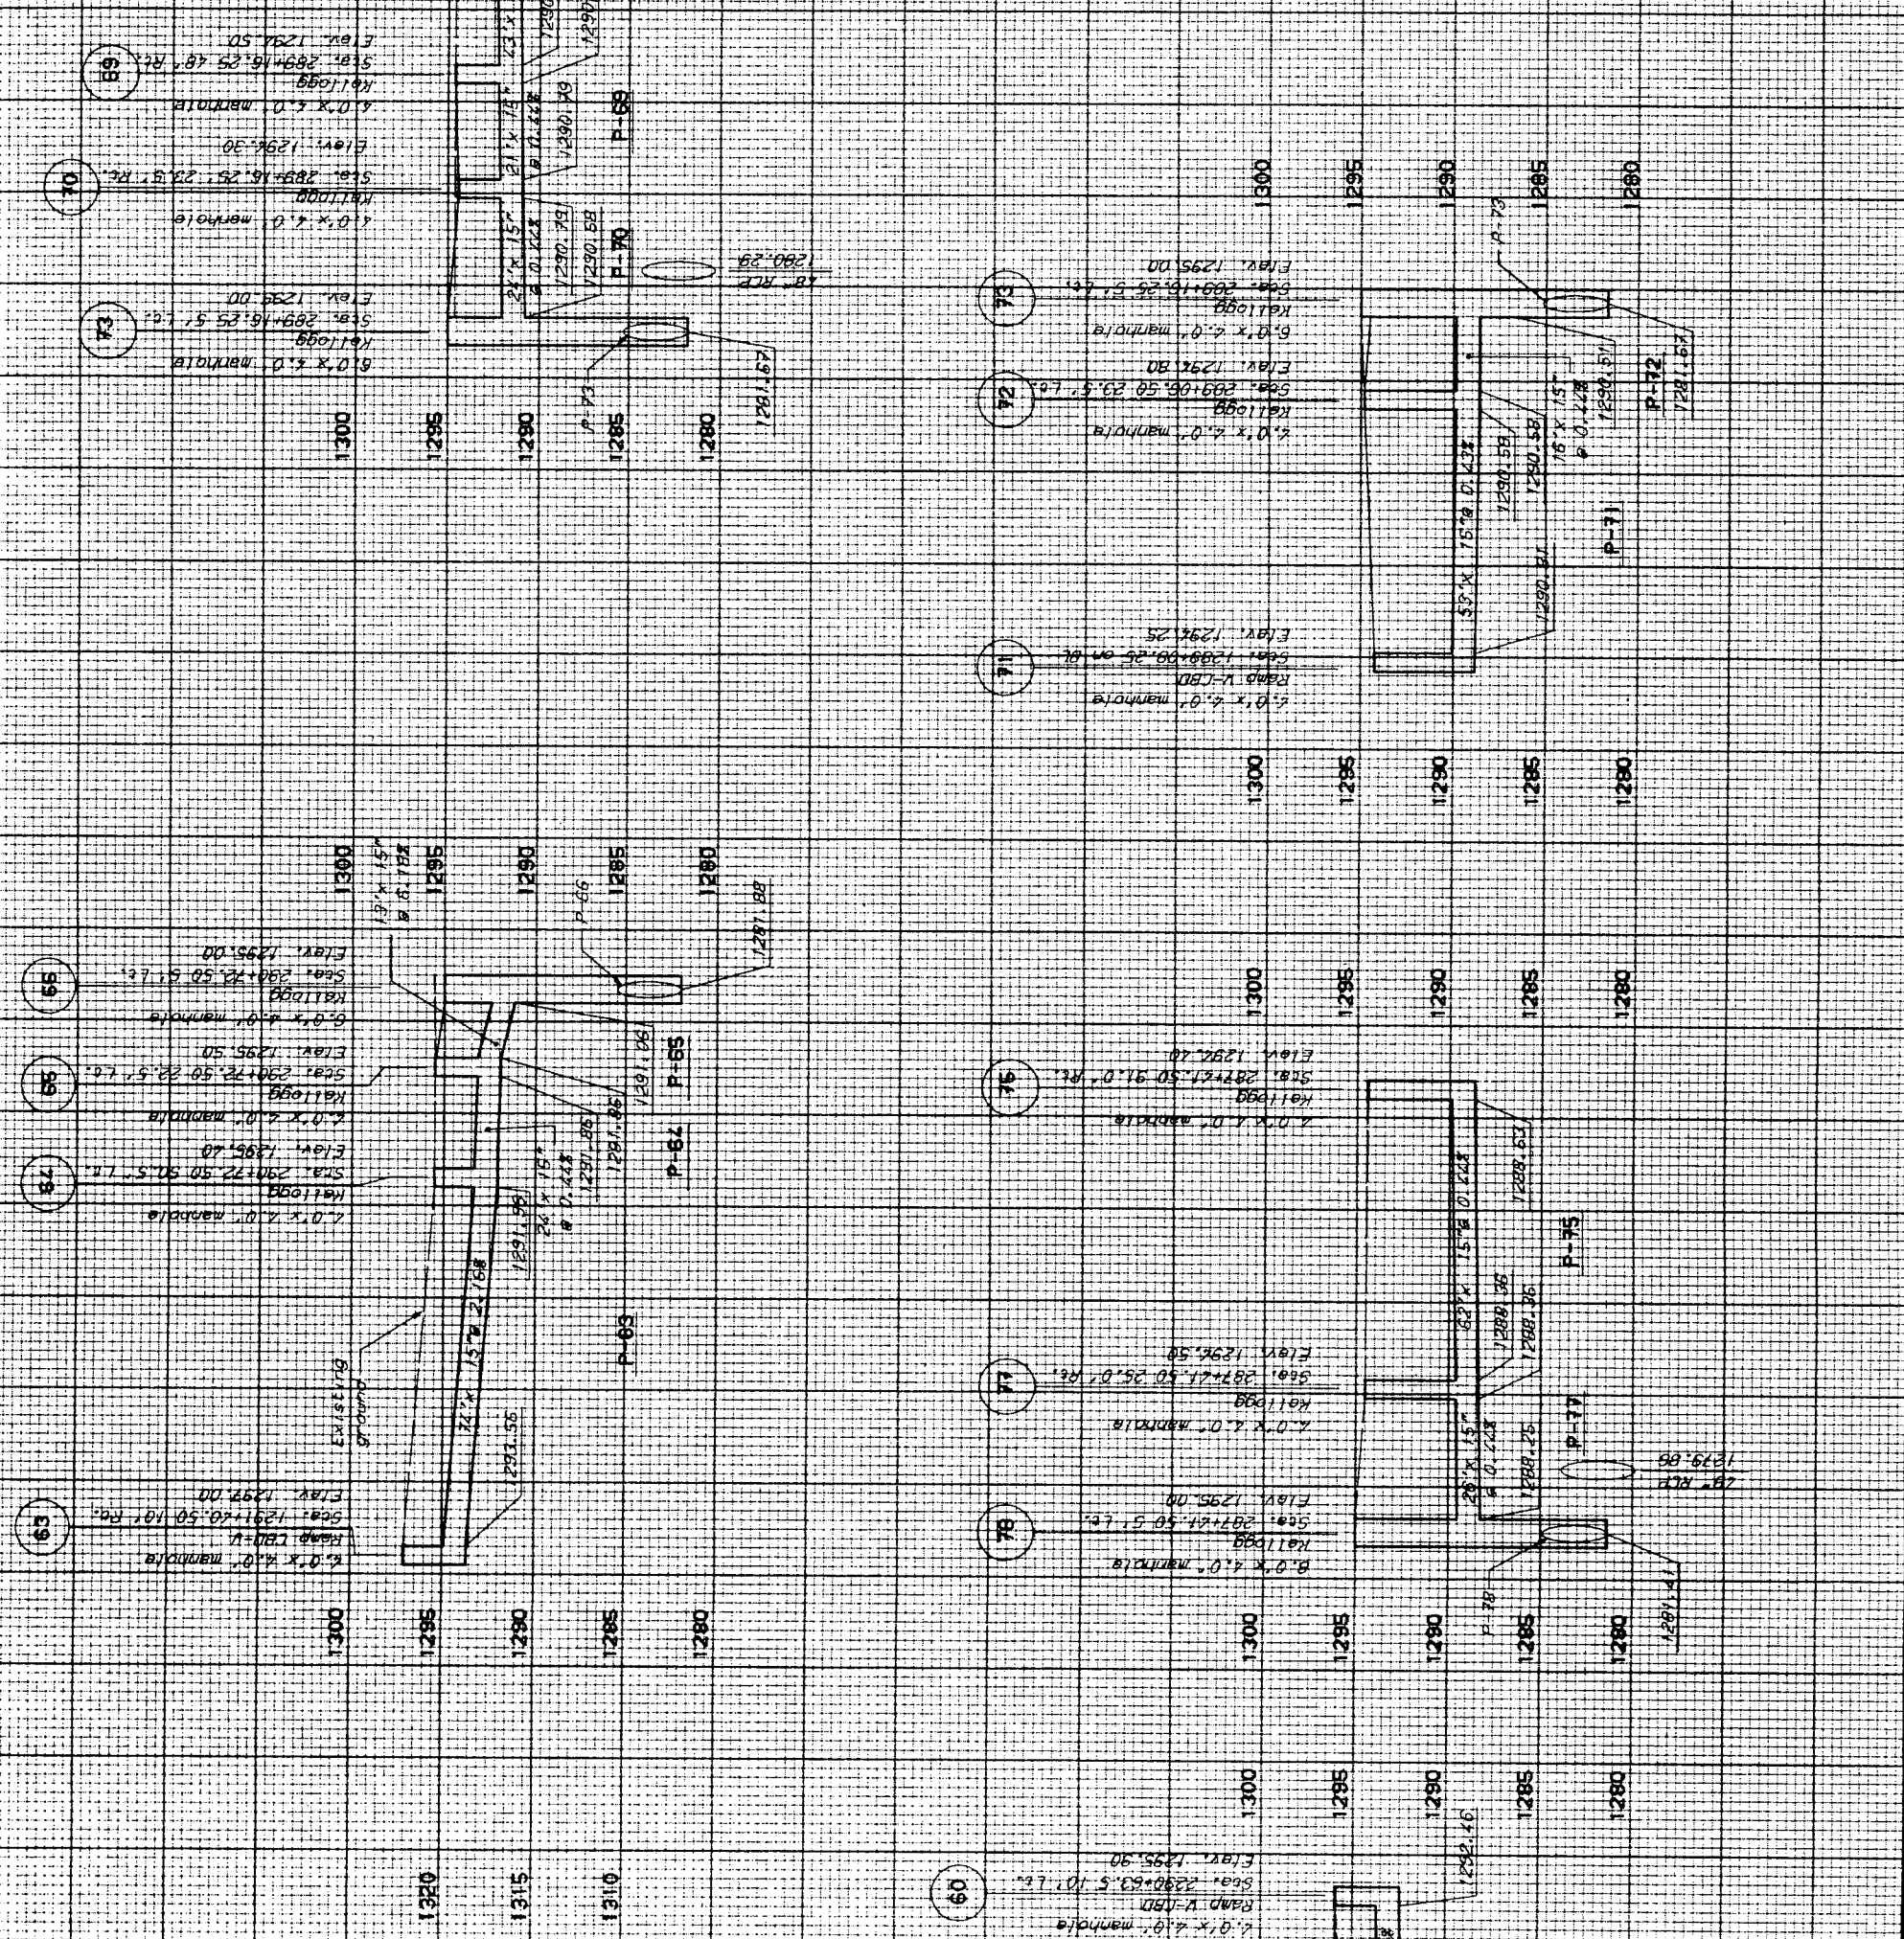


MANHOLE NO.	10	11	12	13	14	15	16	17	18	19	20	21	22	23	24	25	26	27	28	29	30	31	32	33	34	35	36	37	38	39	40
PIPE SIZE	18" x 18" RCP	18" x 18" RCP	
CITY OF WICHITA
 STORM SEWER
 PIPE PROFILES

HNTB
 ARCHITECTS ENGINEERS PLANNERS

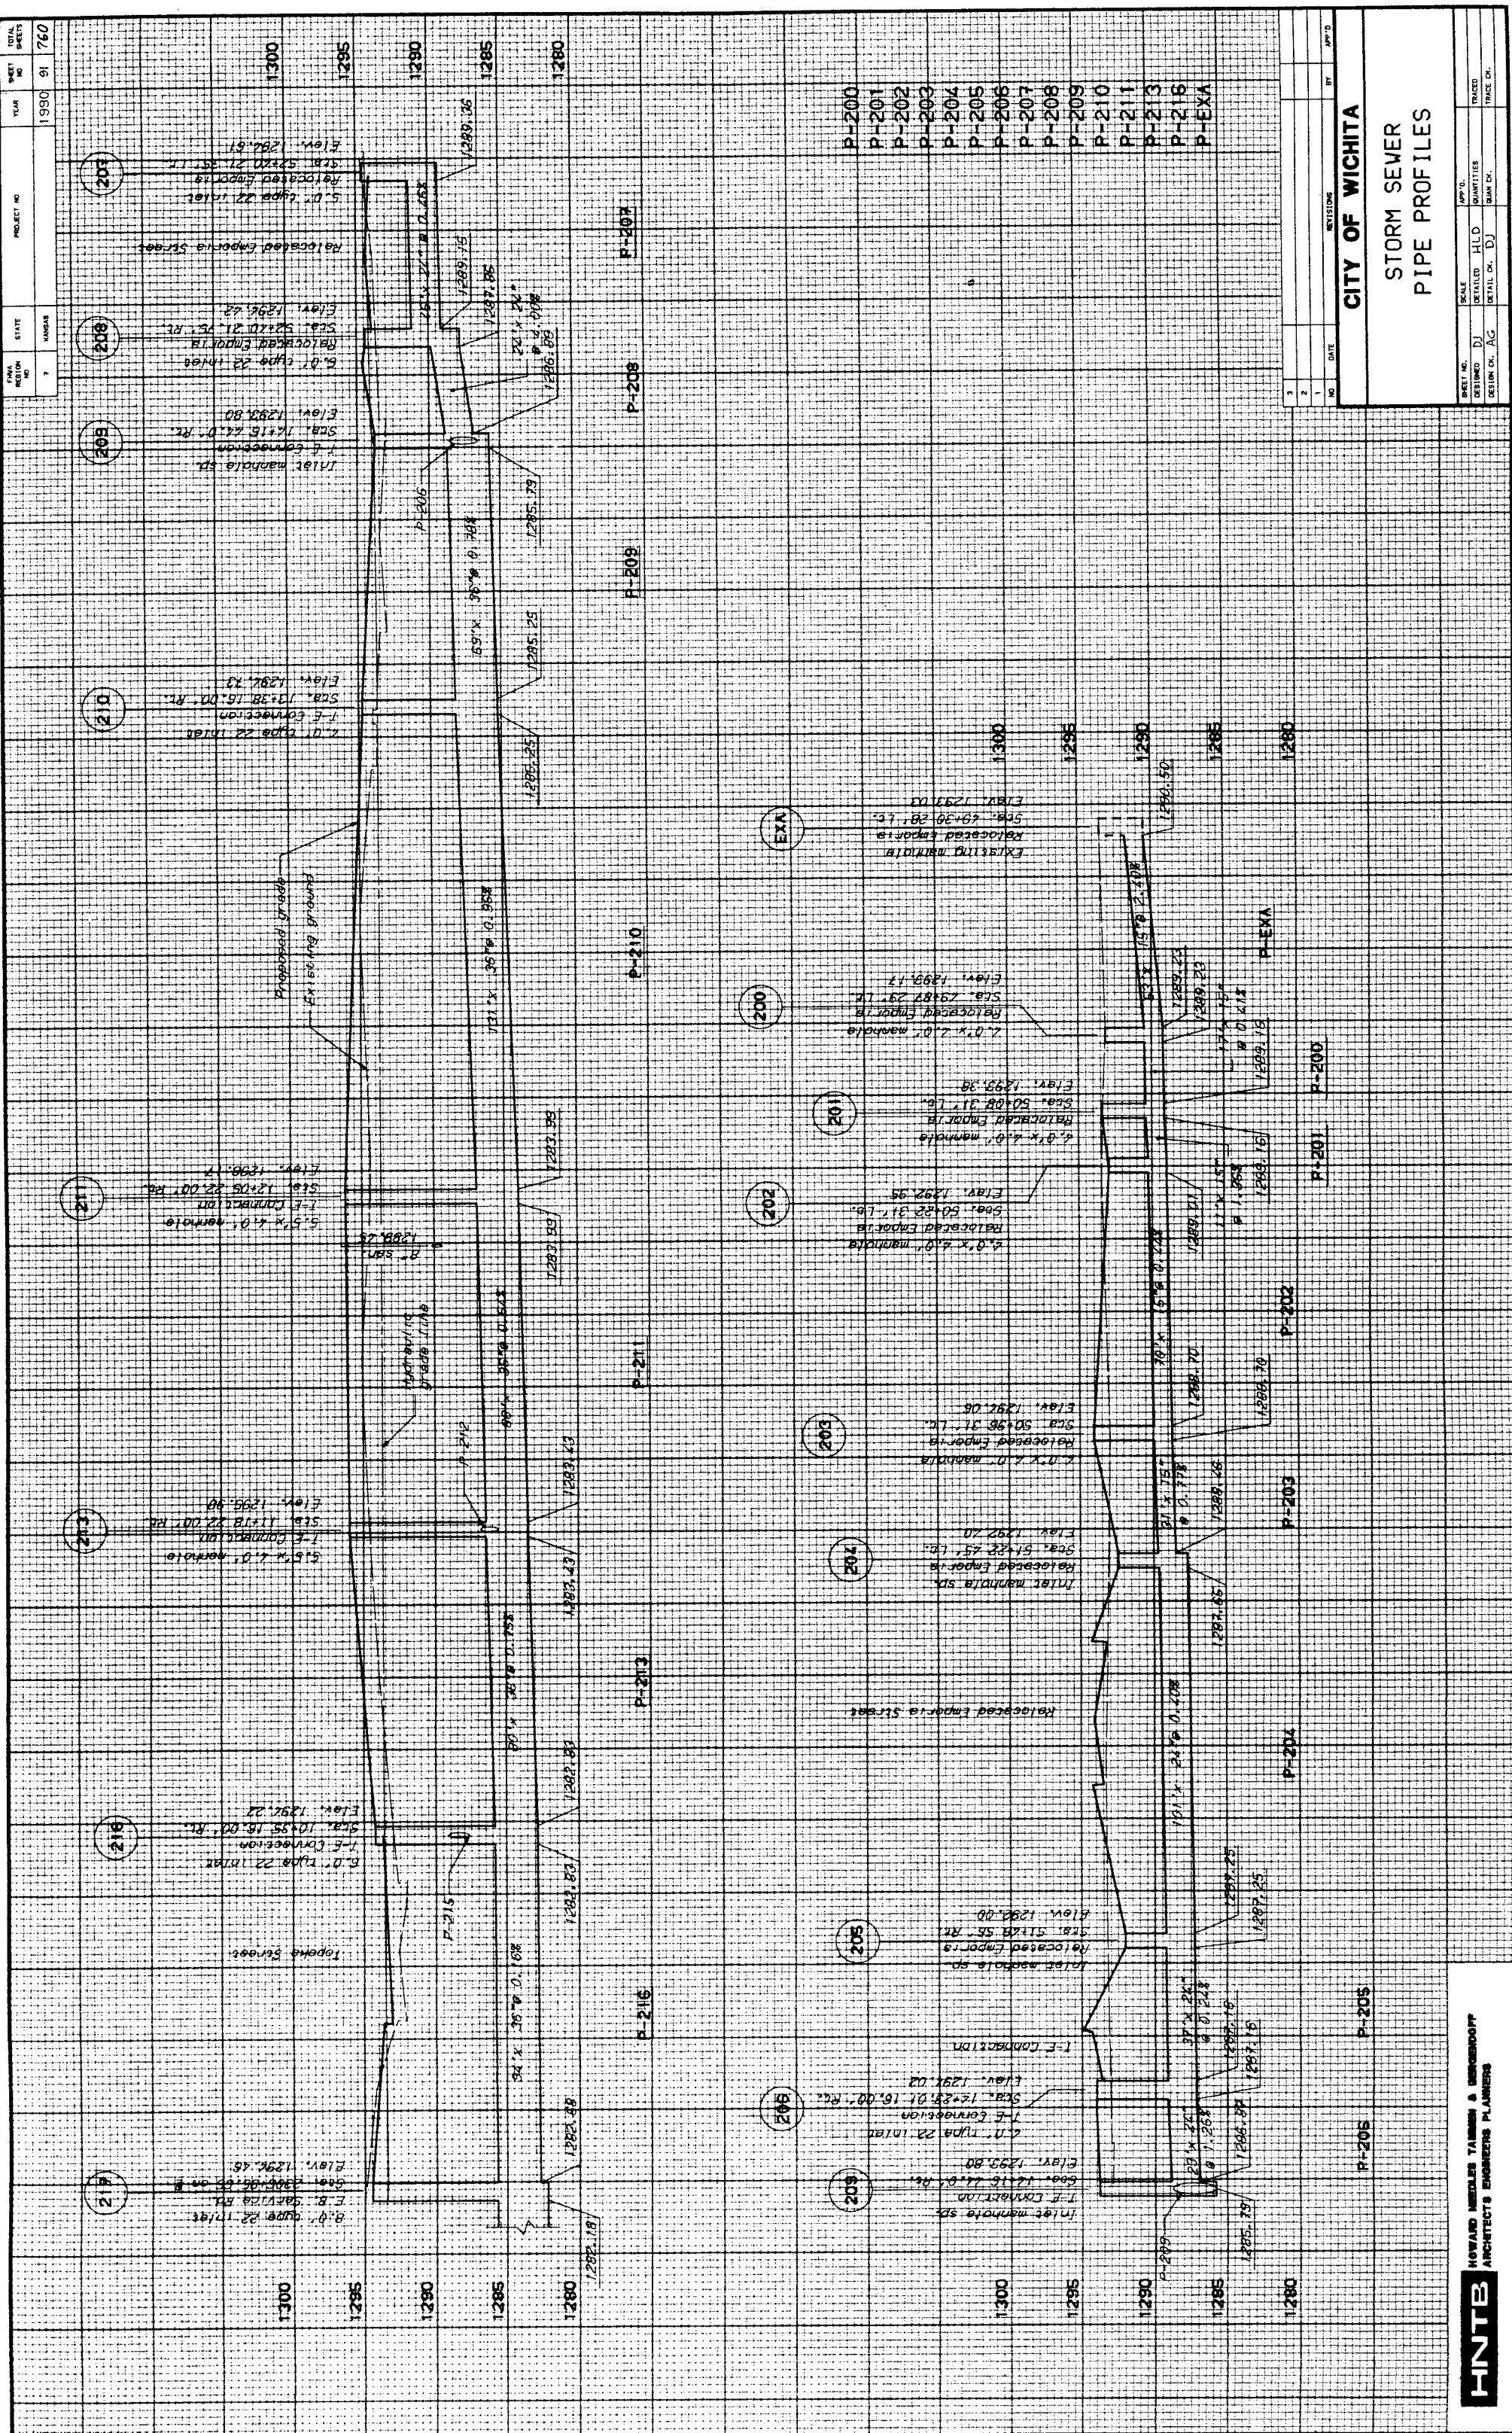

PIPE NO.	DATE	BY	CHKD.	DESCRIPTION
P-200				
P-201				
P-202				
P-203				
P-204				
P-205				
P-206				
P-207				
P-208				
P-209				
P-210				
P-211				
P-212				
P-213				
P-214				
P-215				
P-216				
P-EXA				

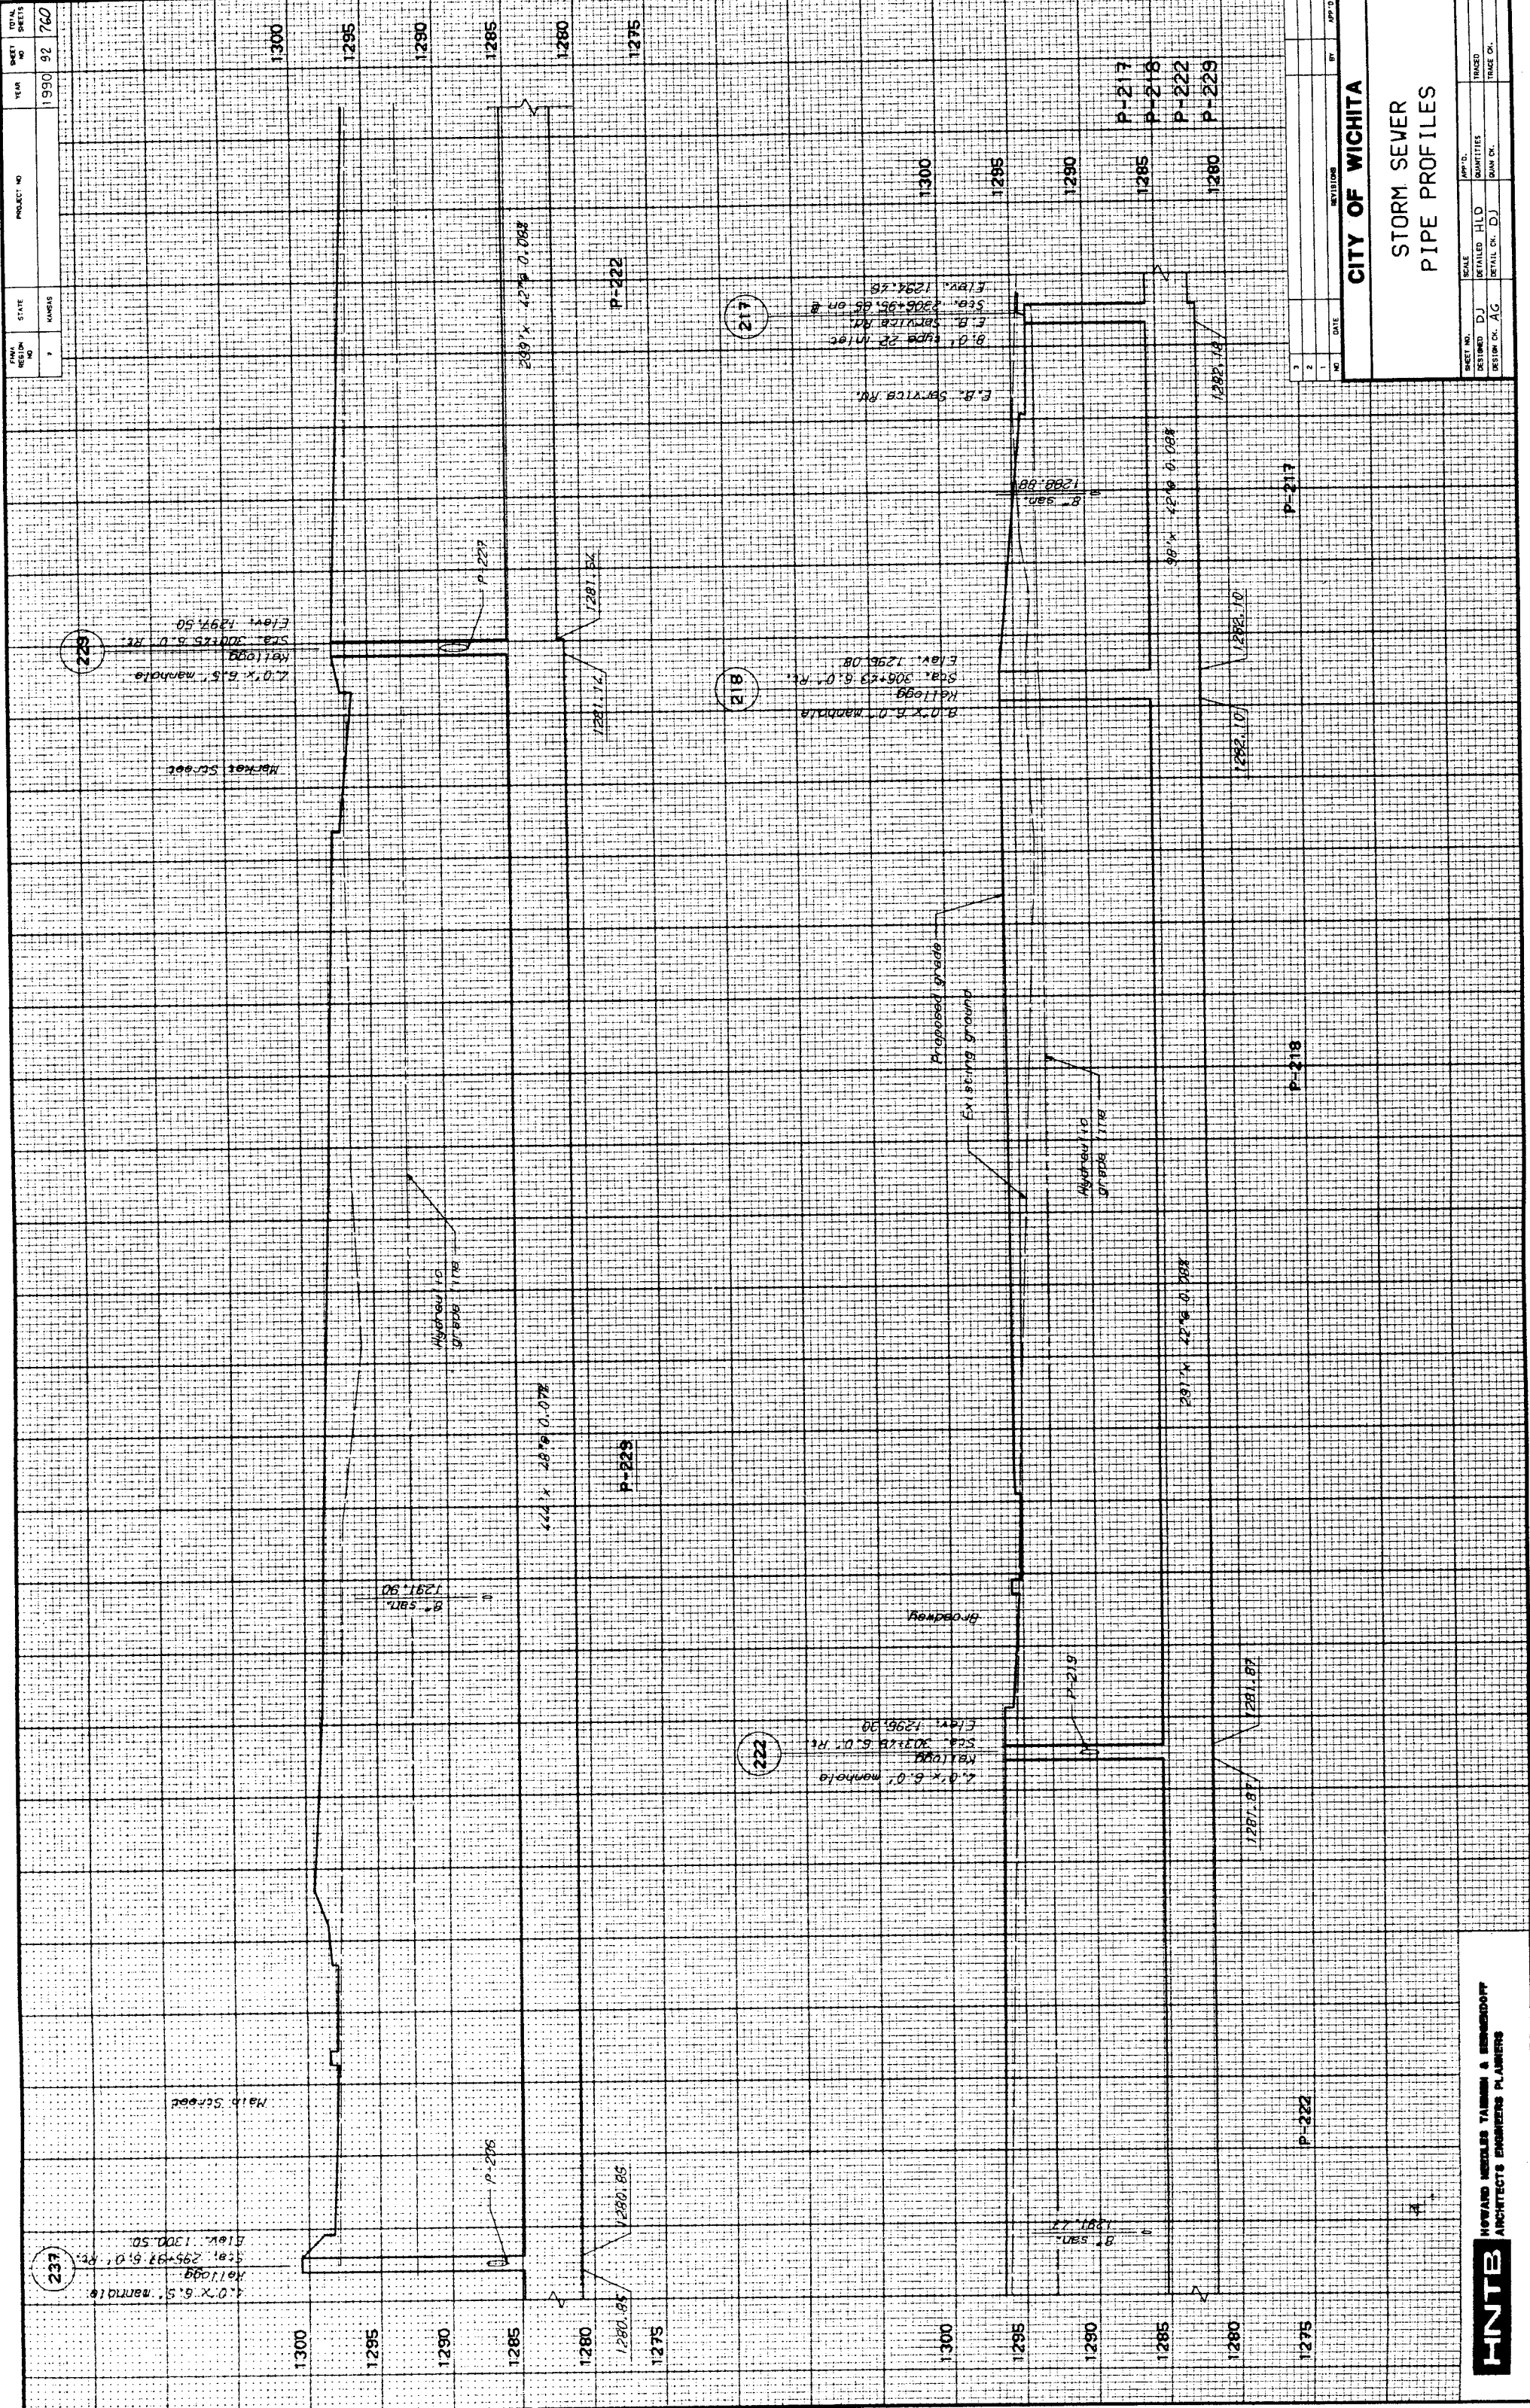

CITY OF WICHITA
STORM SEWER
PIPE PROFILES

DATE	BY	CHK'D
1990 02 17		

SCALE	DATE
AS SHOWN	


PROJECT NO.	DATE

DESIGNED BY	CHECKED BY
D.J.	

SCALE	DATE
AS SHOWN	

FNTB HOWARD GIBLES YALOW & BERNARDINI
 ARCHITECTS ENGINEERS PLANNERS


PROJECT NO. 1990 93 760
 SHEET NO. 7
 DATE 1990 03 16
 CITY WICHITA

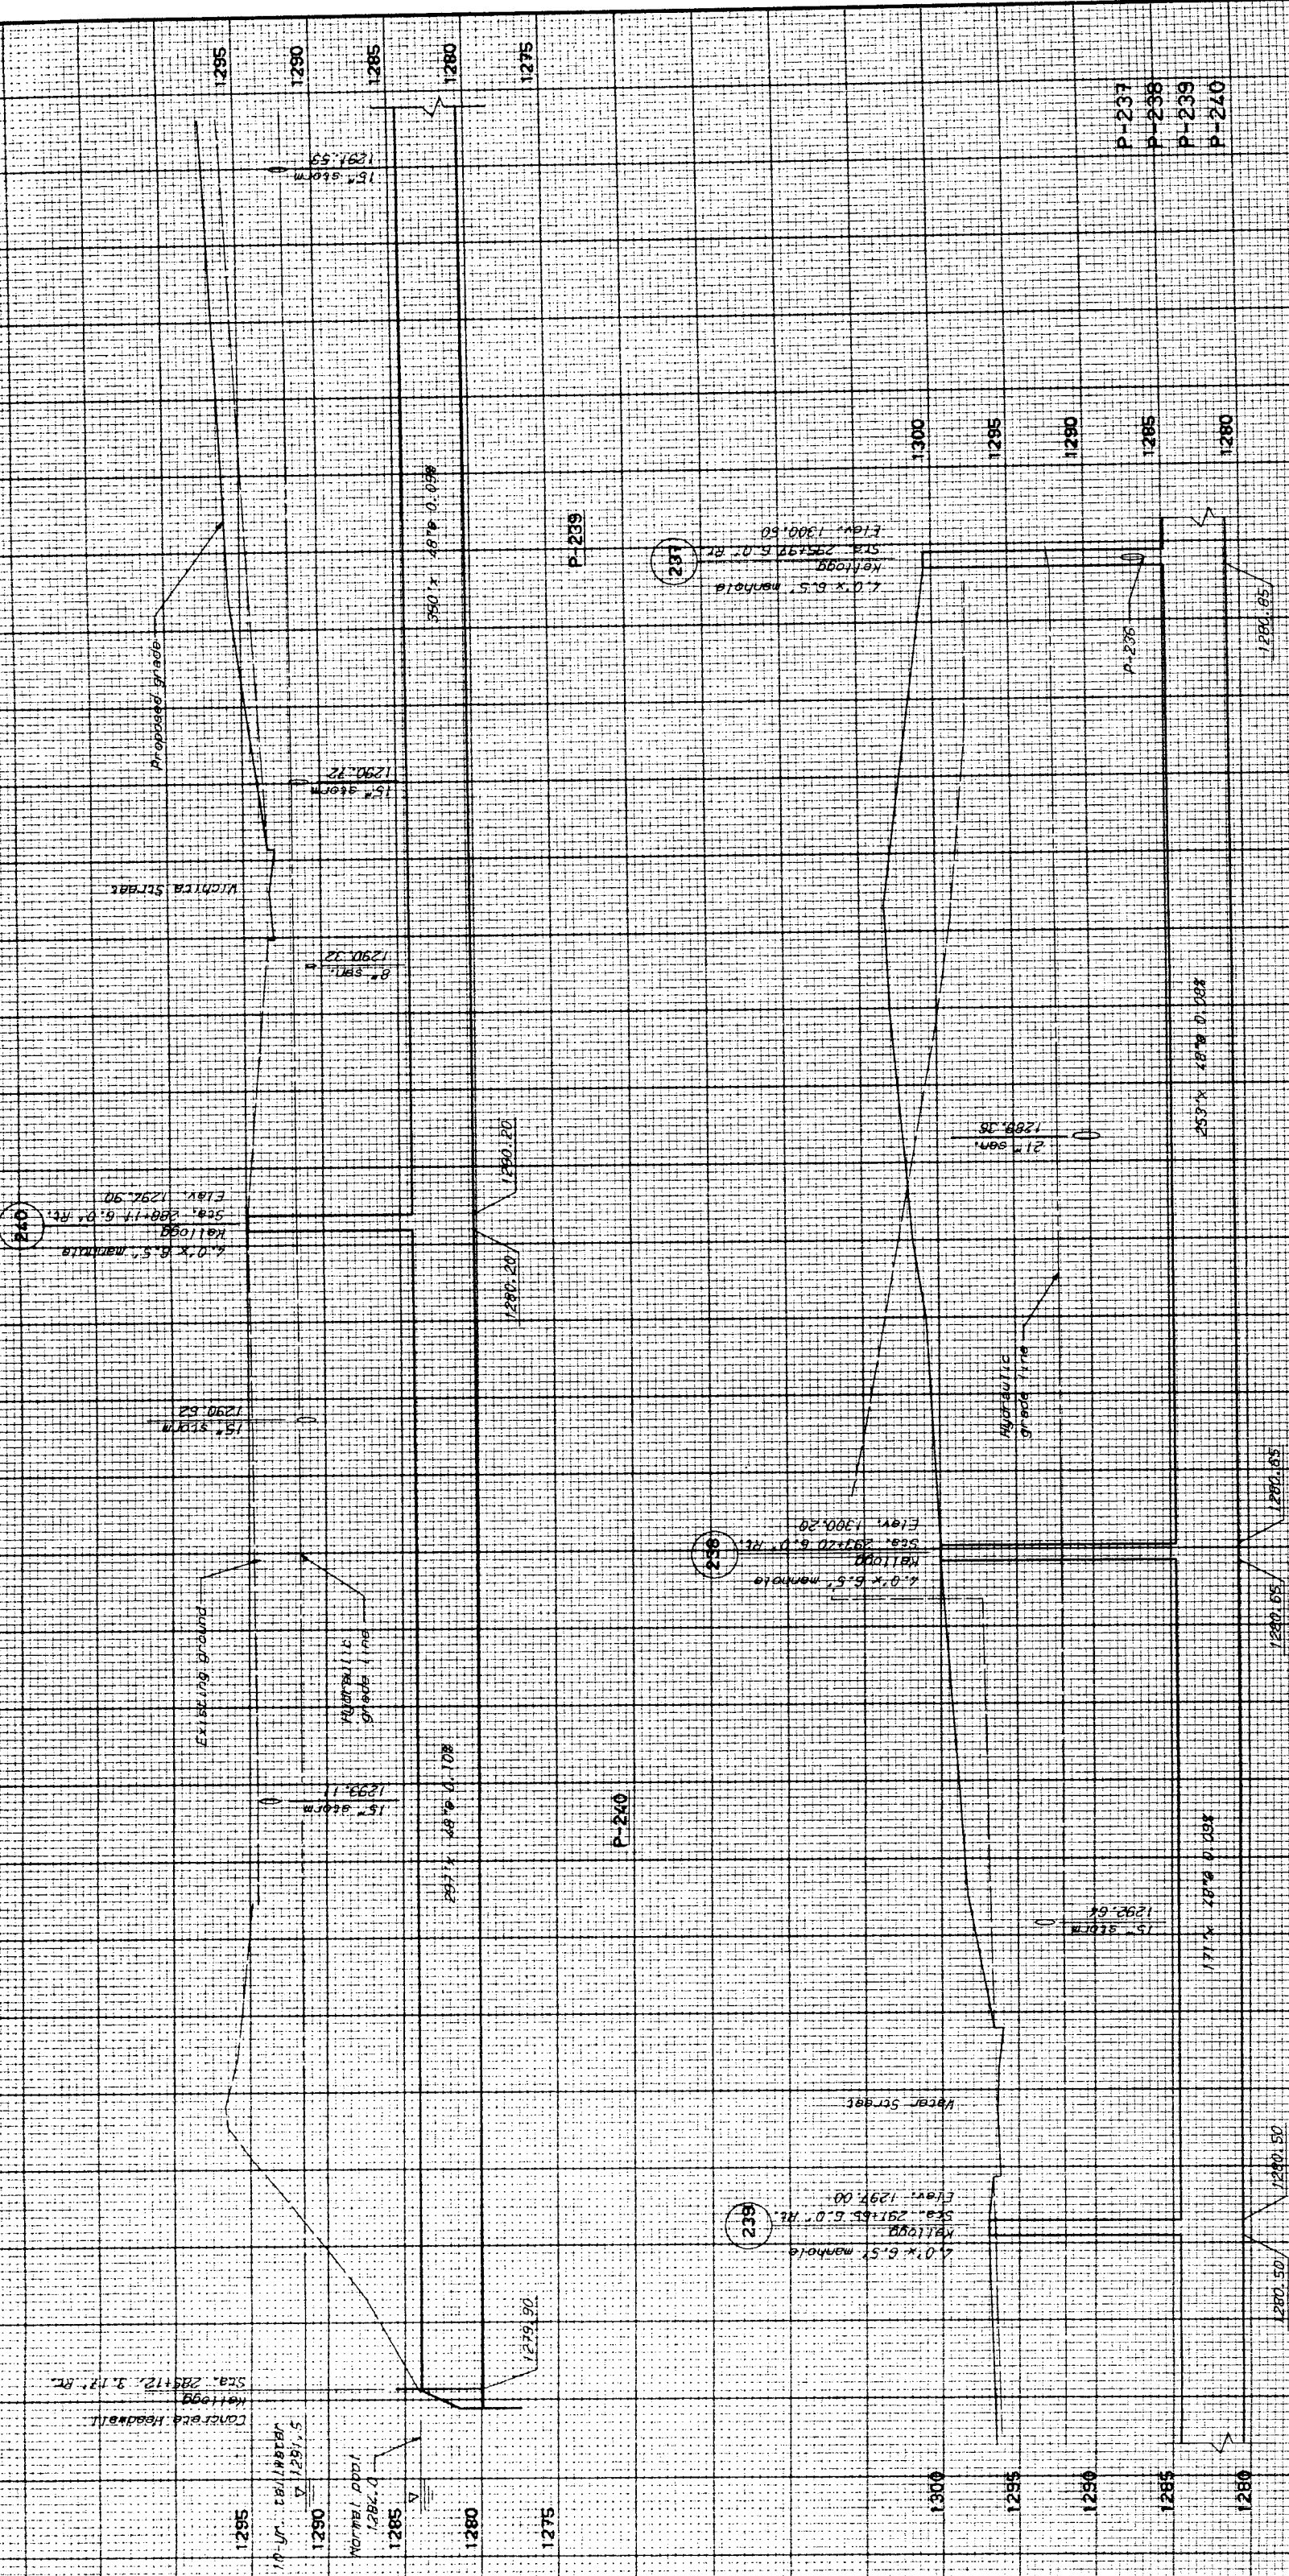

CITY OF WICHITA
 STORM SEWER
 PIPE PROFILES

DATE 1990 03 16
 DRAWN BY DJ
 CHECKED BY AG
 PROJECT NO. 1990 93 760
 SHEET NO. 7

HNTB
 HOWARD NEEDLES TAMM & BERENSON
 ARCHITECTS ENGINEERS PLANNERS

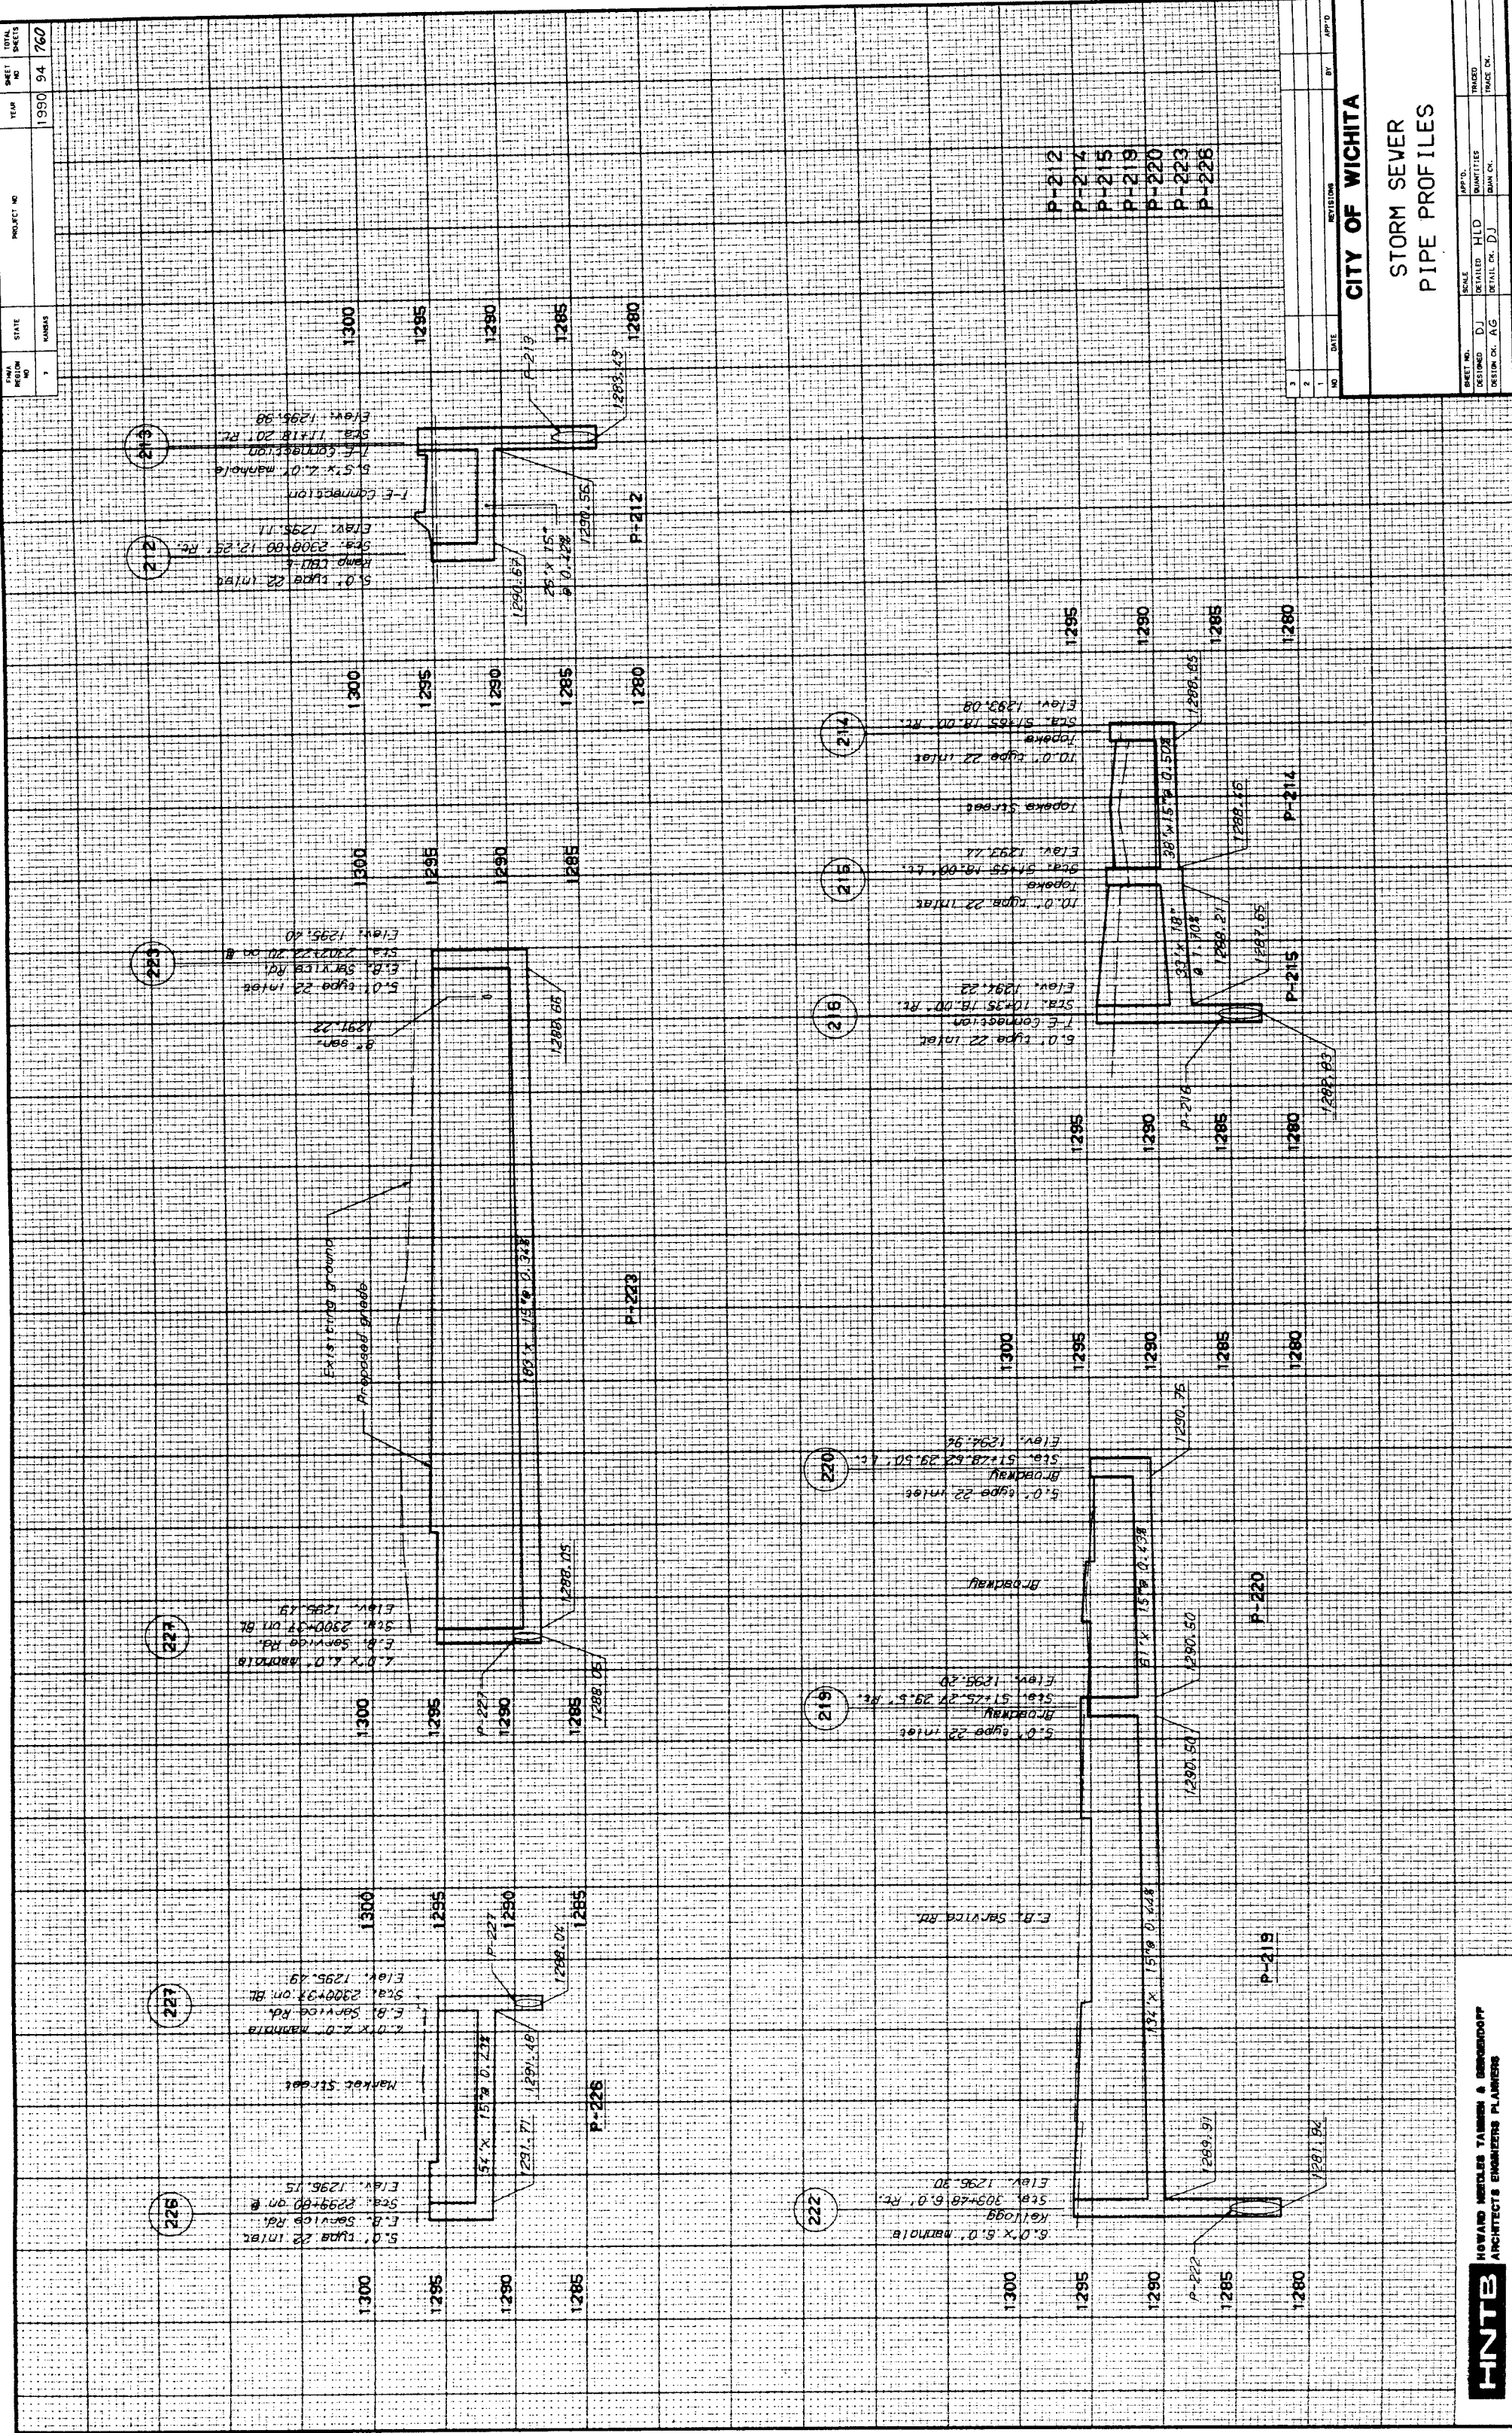







PROJECT NO. 1950 94 760
 DATE 1950 94 760
 SHEET NO. 1
 TOTAL SHEETS 760

CITY OF WICHITA
STORM SEWER
PIPE PROFILES

DRAWN BY: HLD
 CHECKED BY: DJ
 DATE: 10/11/00

HNTE
 HOWARD HENKES ENGINEERS & ARCHITECTS
 ARCHITECTS ENGINEERS PLANNERS

PROJECT NO. 1990 95 1760
 SHEET NO. 1
 DATE 7/1/95

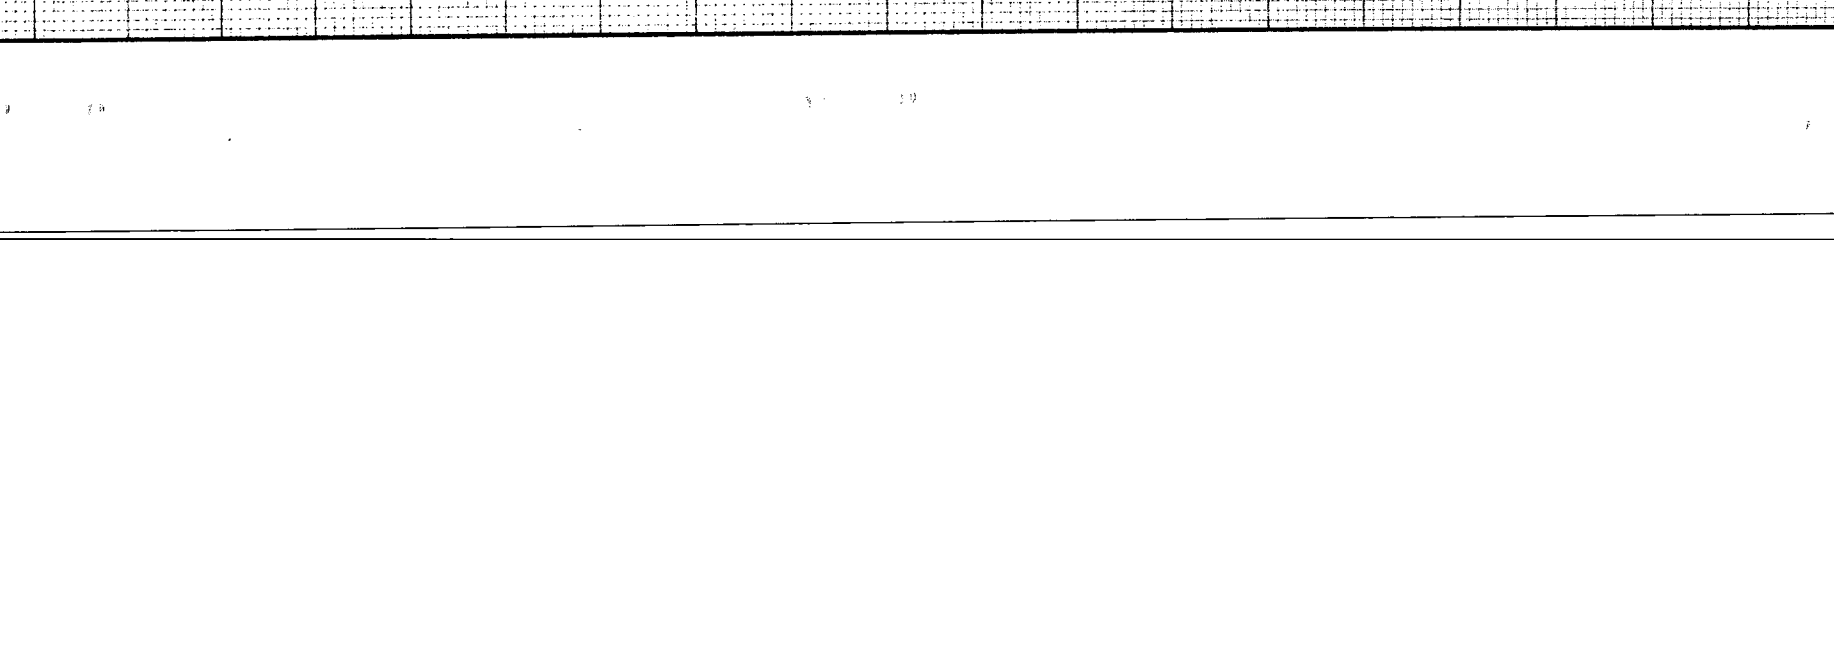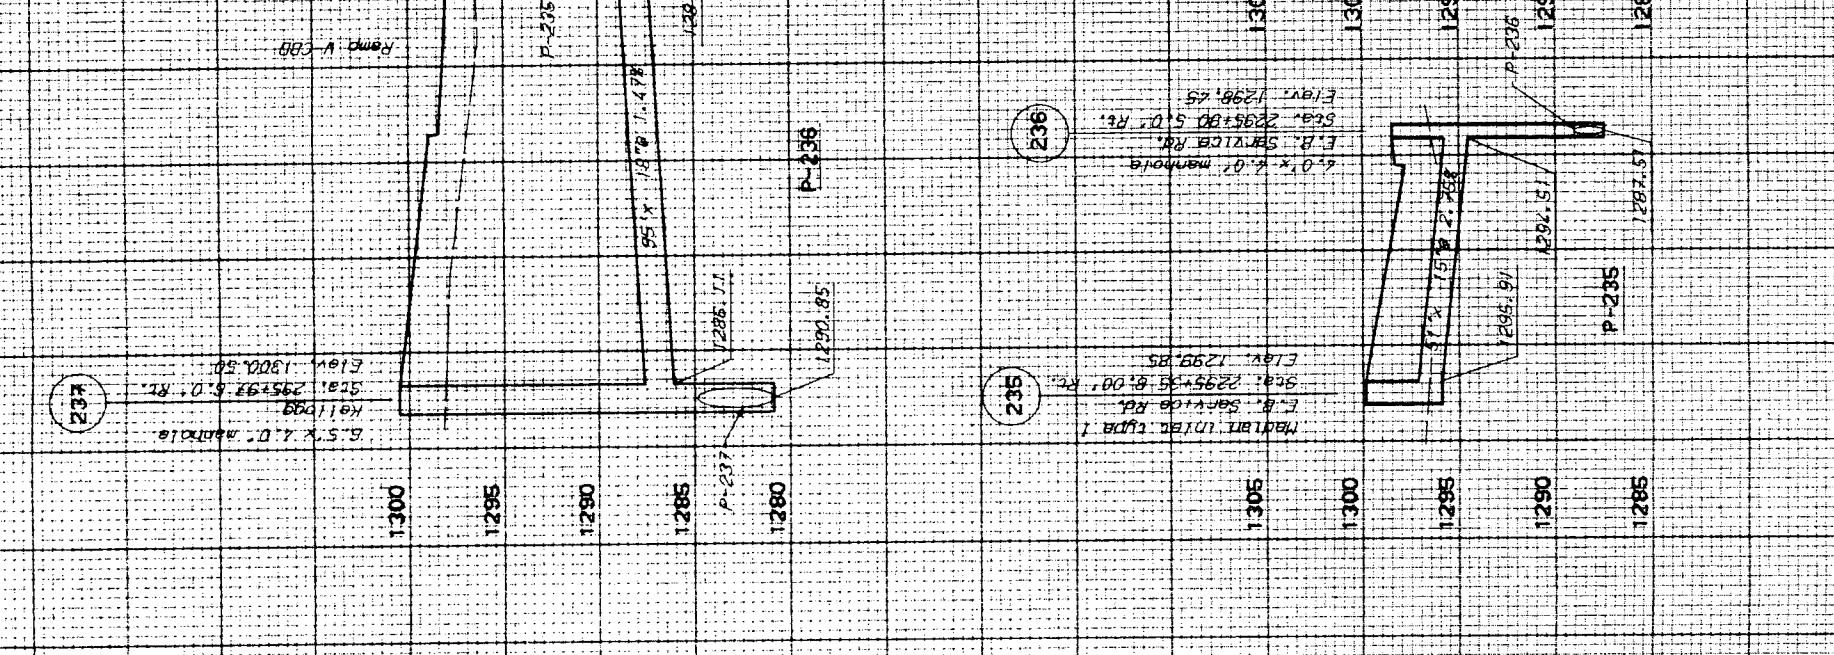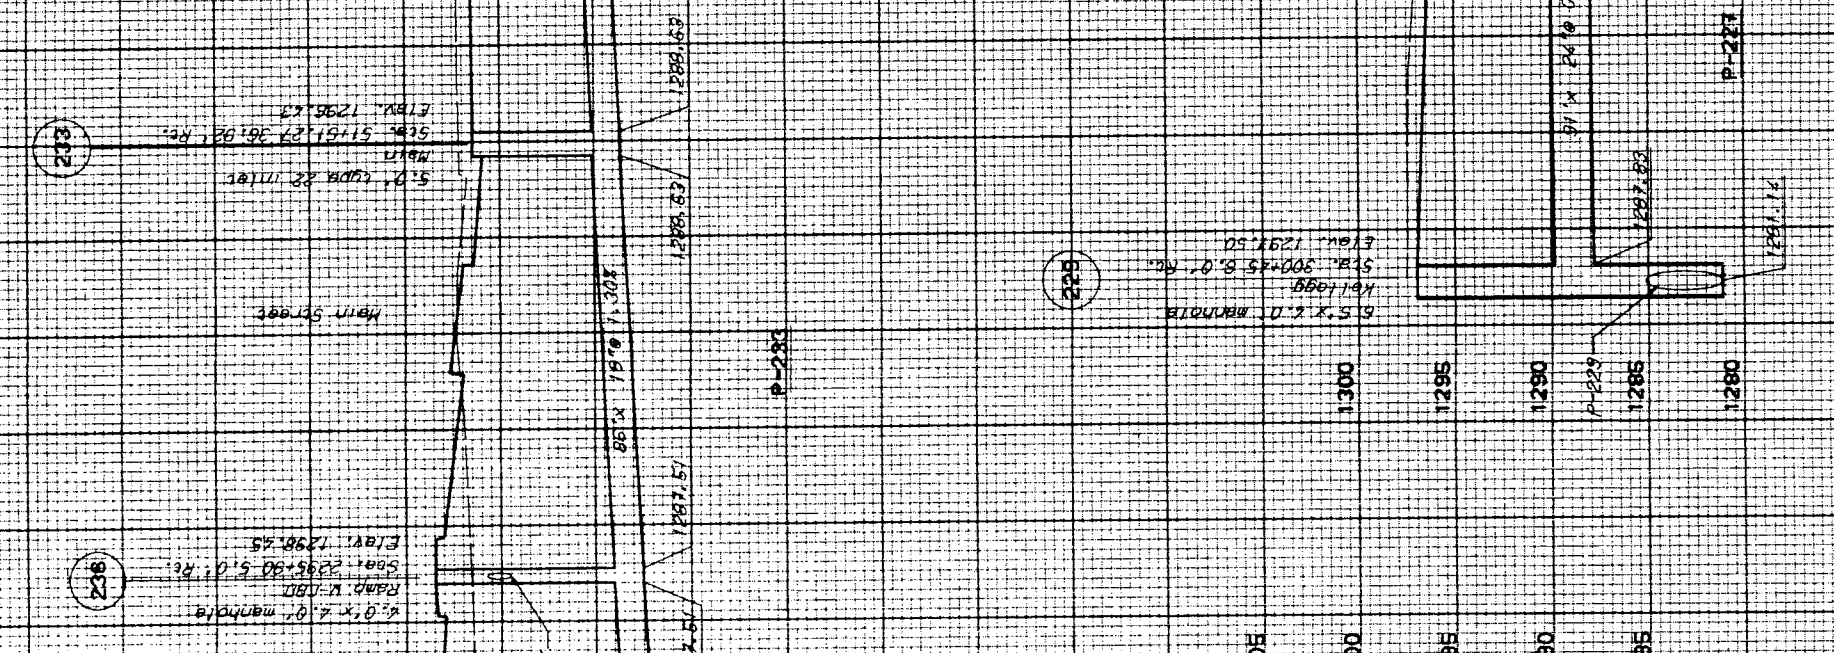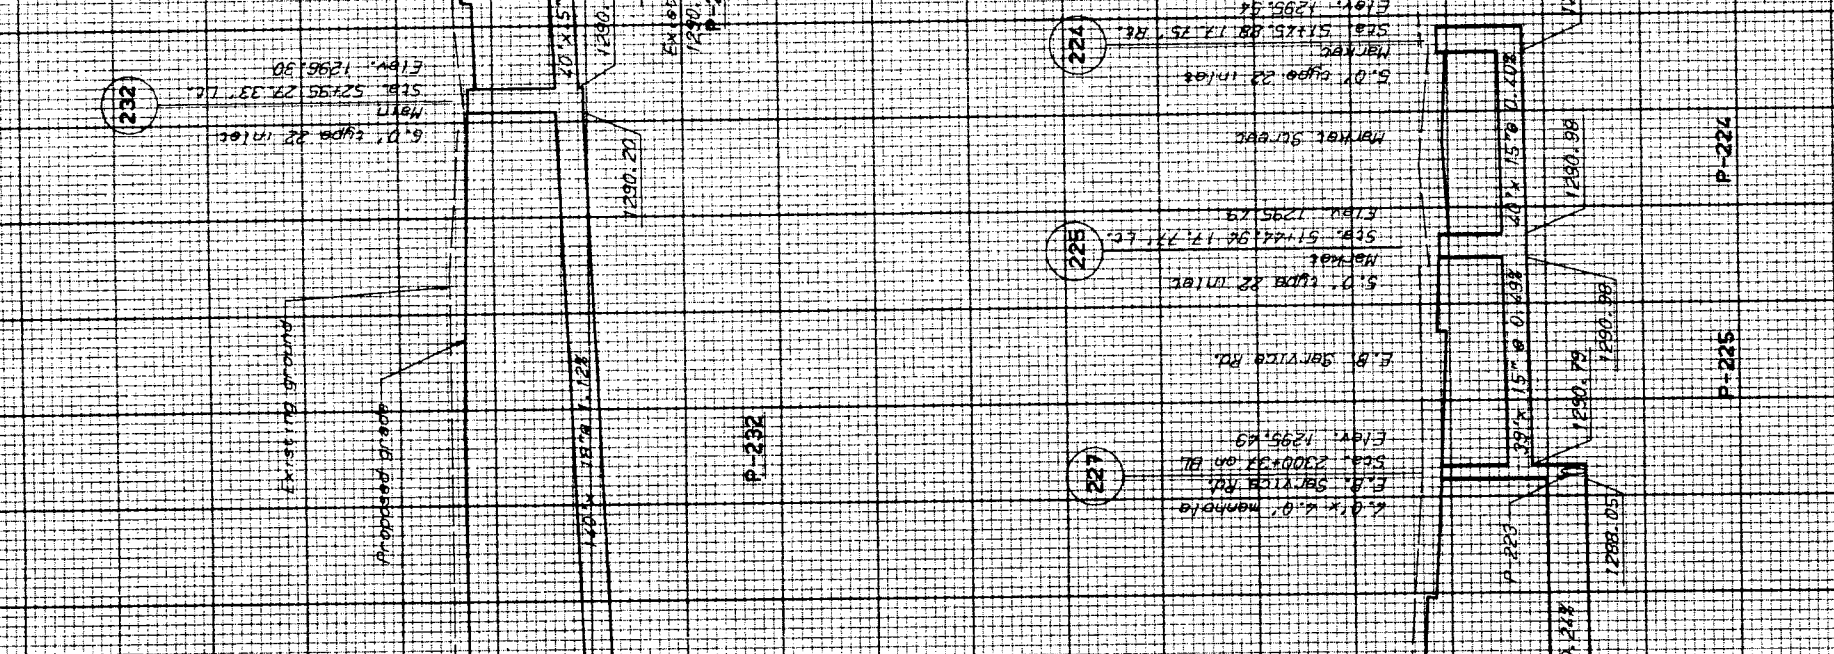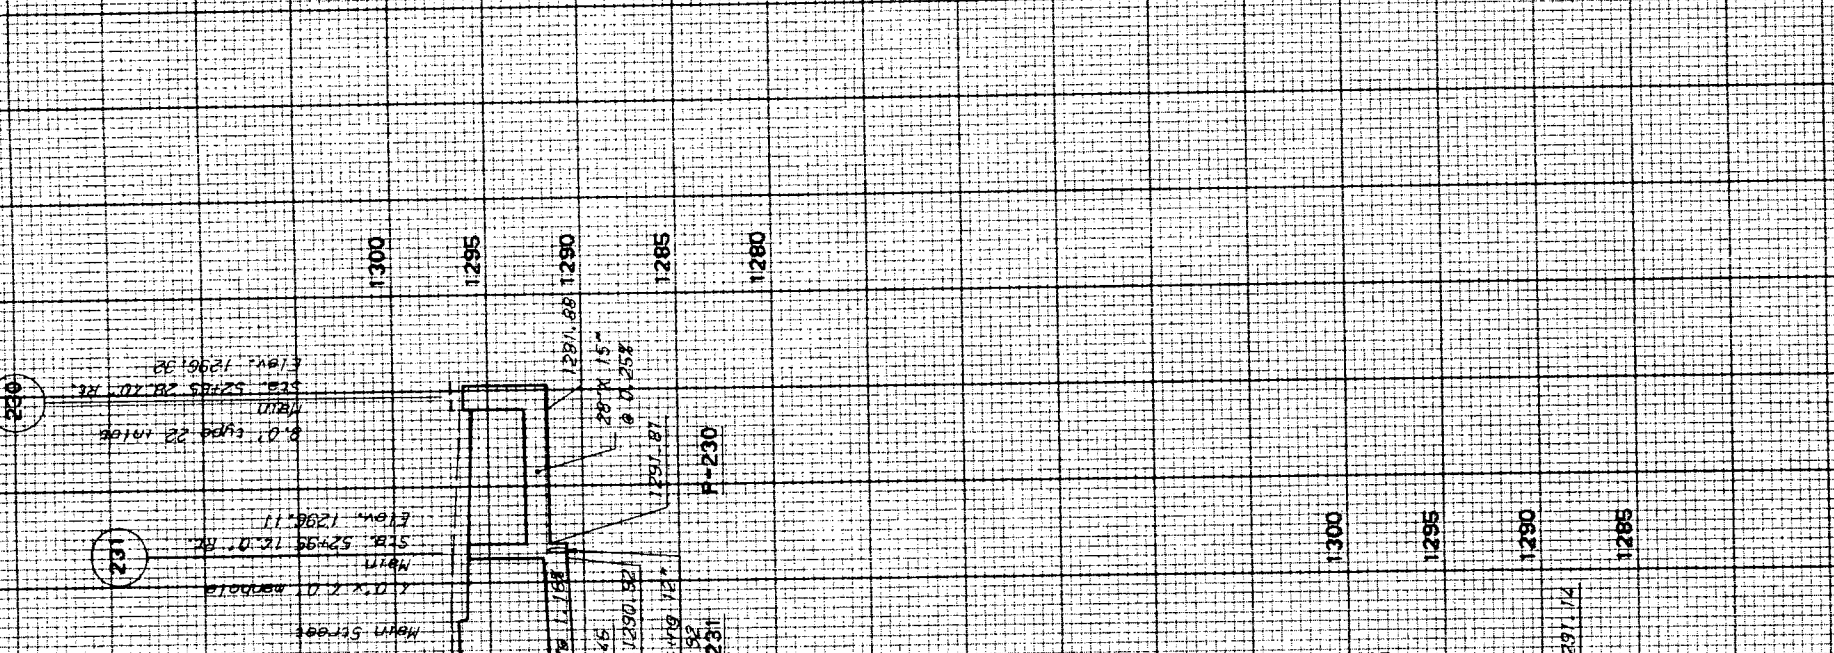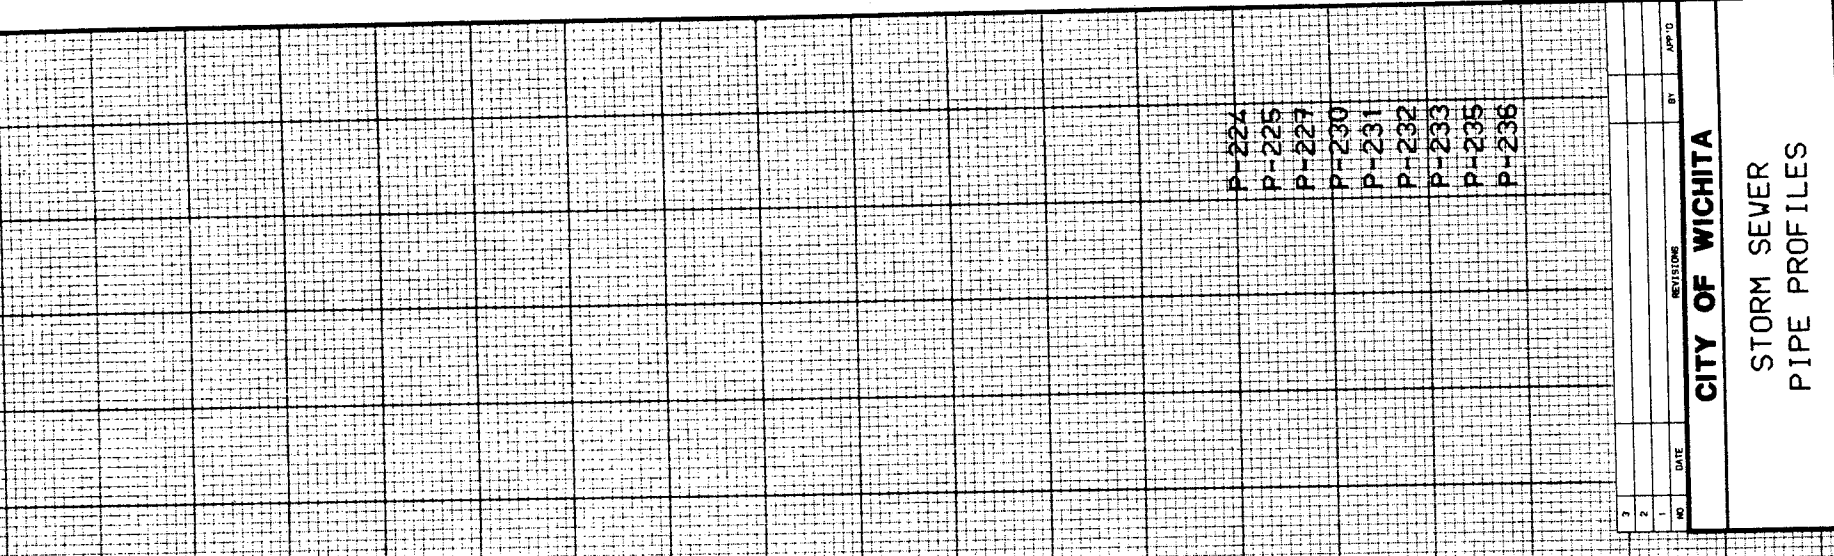

NO.	DATE	REVISION
1		
2		
3		

CITY OF WICHITA
 STORM SEWER
 PIPE PROFILES

PROJECT NO. 1990 95 1760
 SHEET NO. 1
 DATE 7/1/95

SCALE: 1" = 10'-0"
 DRAWN BY: J.L.D.
 CHECKED BY: J.L.D.

DATE: 7/1/95


PROJECT: STORM SEWER PIPE PROFILES

LOCATION: [Blank]

CONTRACT NO. [Blank]

DATE: 7/1/95

PROJECT: STORM SEWER PIPE PROFILES

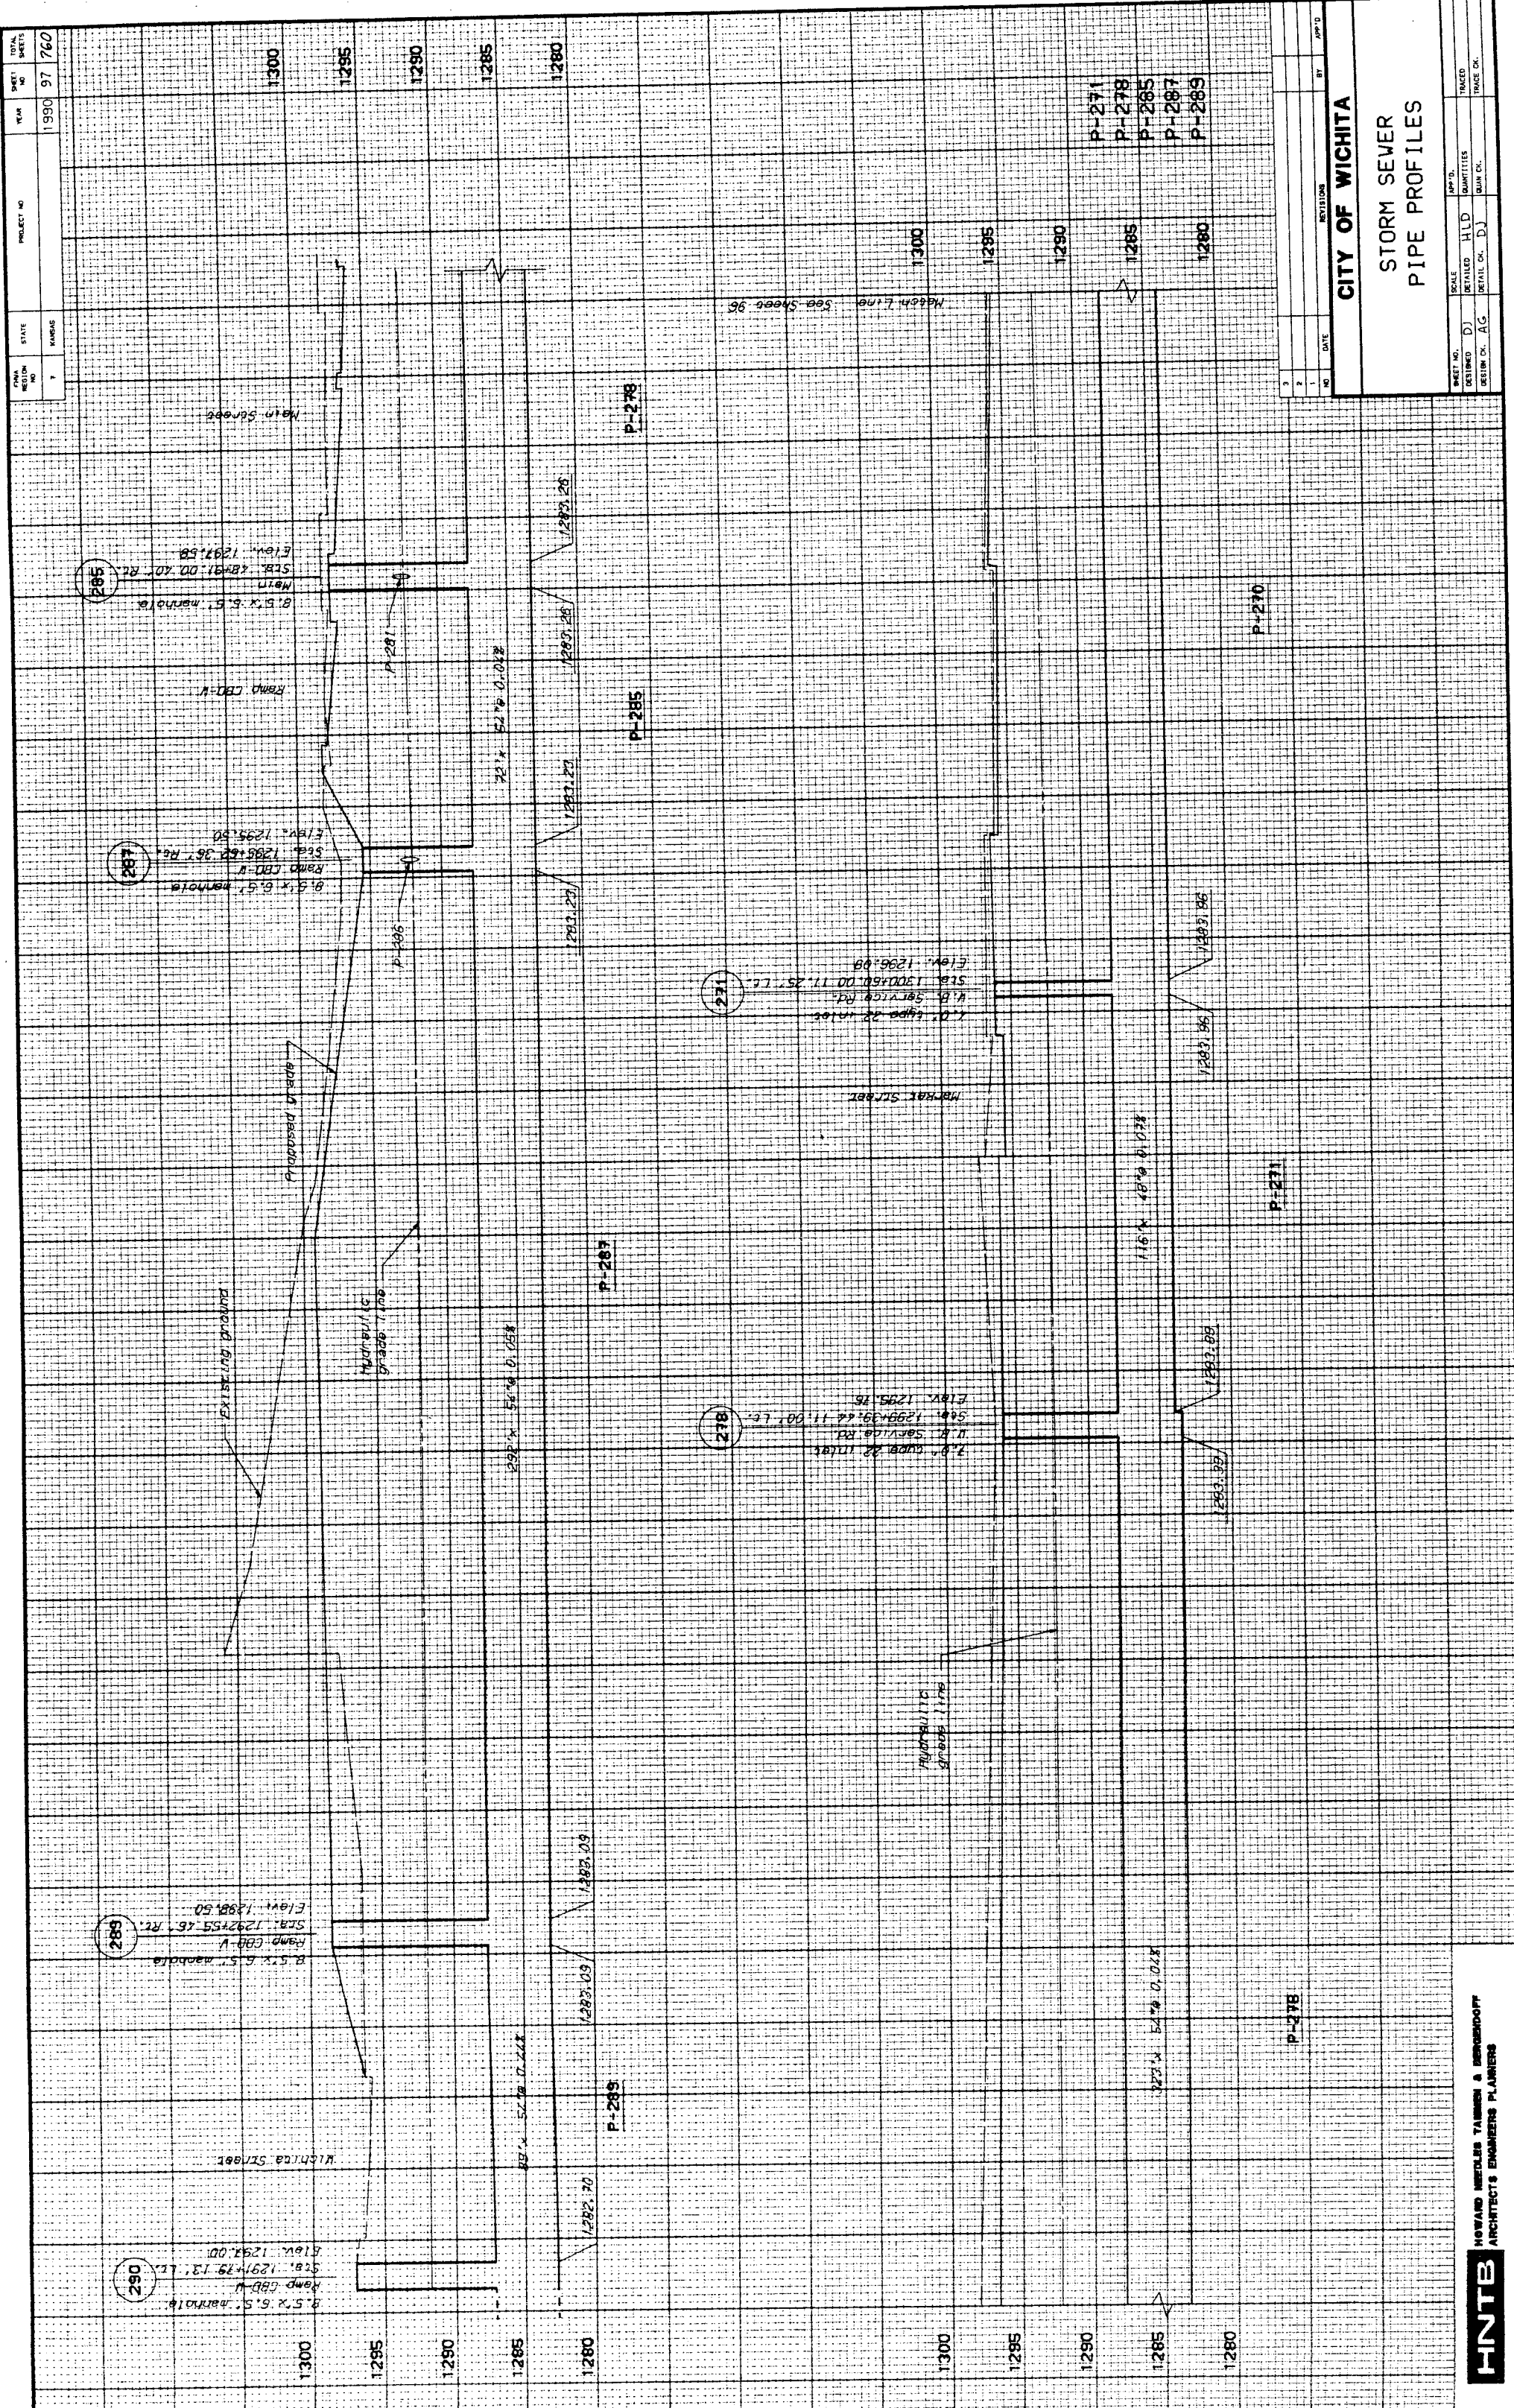

DATE	1997 07 16
PROJECT NO.	
SCALE	
DATE	
DATE	

NO.	1	DATE	
NO.	2	DATE	
NO.	3	DATE	
NO.	4	DATE	

NO.	1	DATE	
NO.	2	DATE	
NO.	3	DATE	
NO.	4	DATE	

CITY OF WICHITA
STORM SEWER
PIPE PROFILES

DATE	1997 07 16
PROJECT NO.	
SCALE	
DATE	
DATE	

NO.	1	DATE	
NO.	2	DATE	
NO.	3	DATE	
NO.	4	DATE	

NO.	1	DATE	
NO.	2	DATE	
NO.	3	DATE	
NO.	4	DATE	

NO.	1	DATE	
NO.	2	DATE	
NO.	3	DATE	
NO.	4	DATE	

NO.	1	DATE	
NO.	2	DATE	
NO.	3	DATE	
NO.	4	DATE	

NO.	1	DATE	
NO.	2	DATE	
NO.	3	DATE	
NO.	4	DATE	


NO.	1	DATE	
NO.	2	DATE	
NO.	3	DATE	
NO.	4	DATE	

NO.	1	DATE	
NO.	2	DATE	
NO.	3	DATE	
NO.	4	DATE	

NO.	1	DATE	
NO.	2	DATE	
NO.	3	DATE	
NO.	4	DATE	

HNTB
HOWARD MERRILL TAYLOR & ASSOCIATES
ARCHITECTS ENGINEERS PLANNERS

PROJECT NO.	1990
DATE	9/17/60
SCALE	AS SHOWN
BY	W.H.B.
CHECKED	J.H.B.
APPROVED	

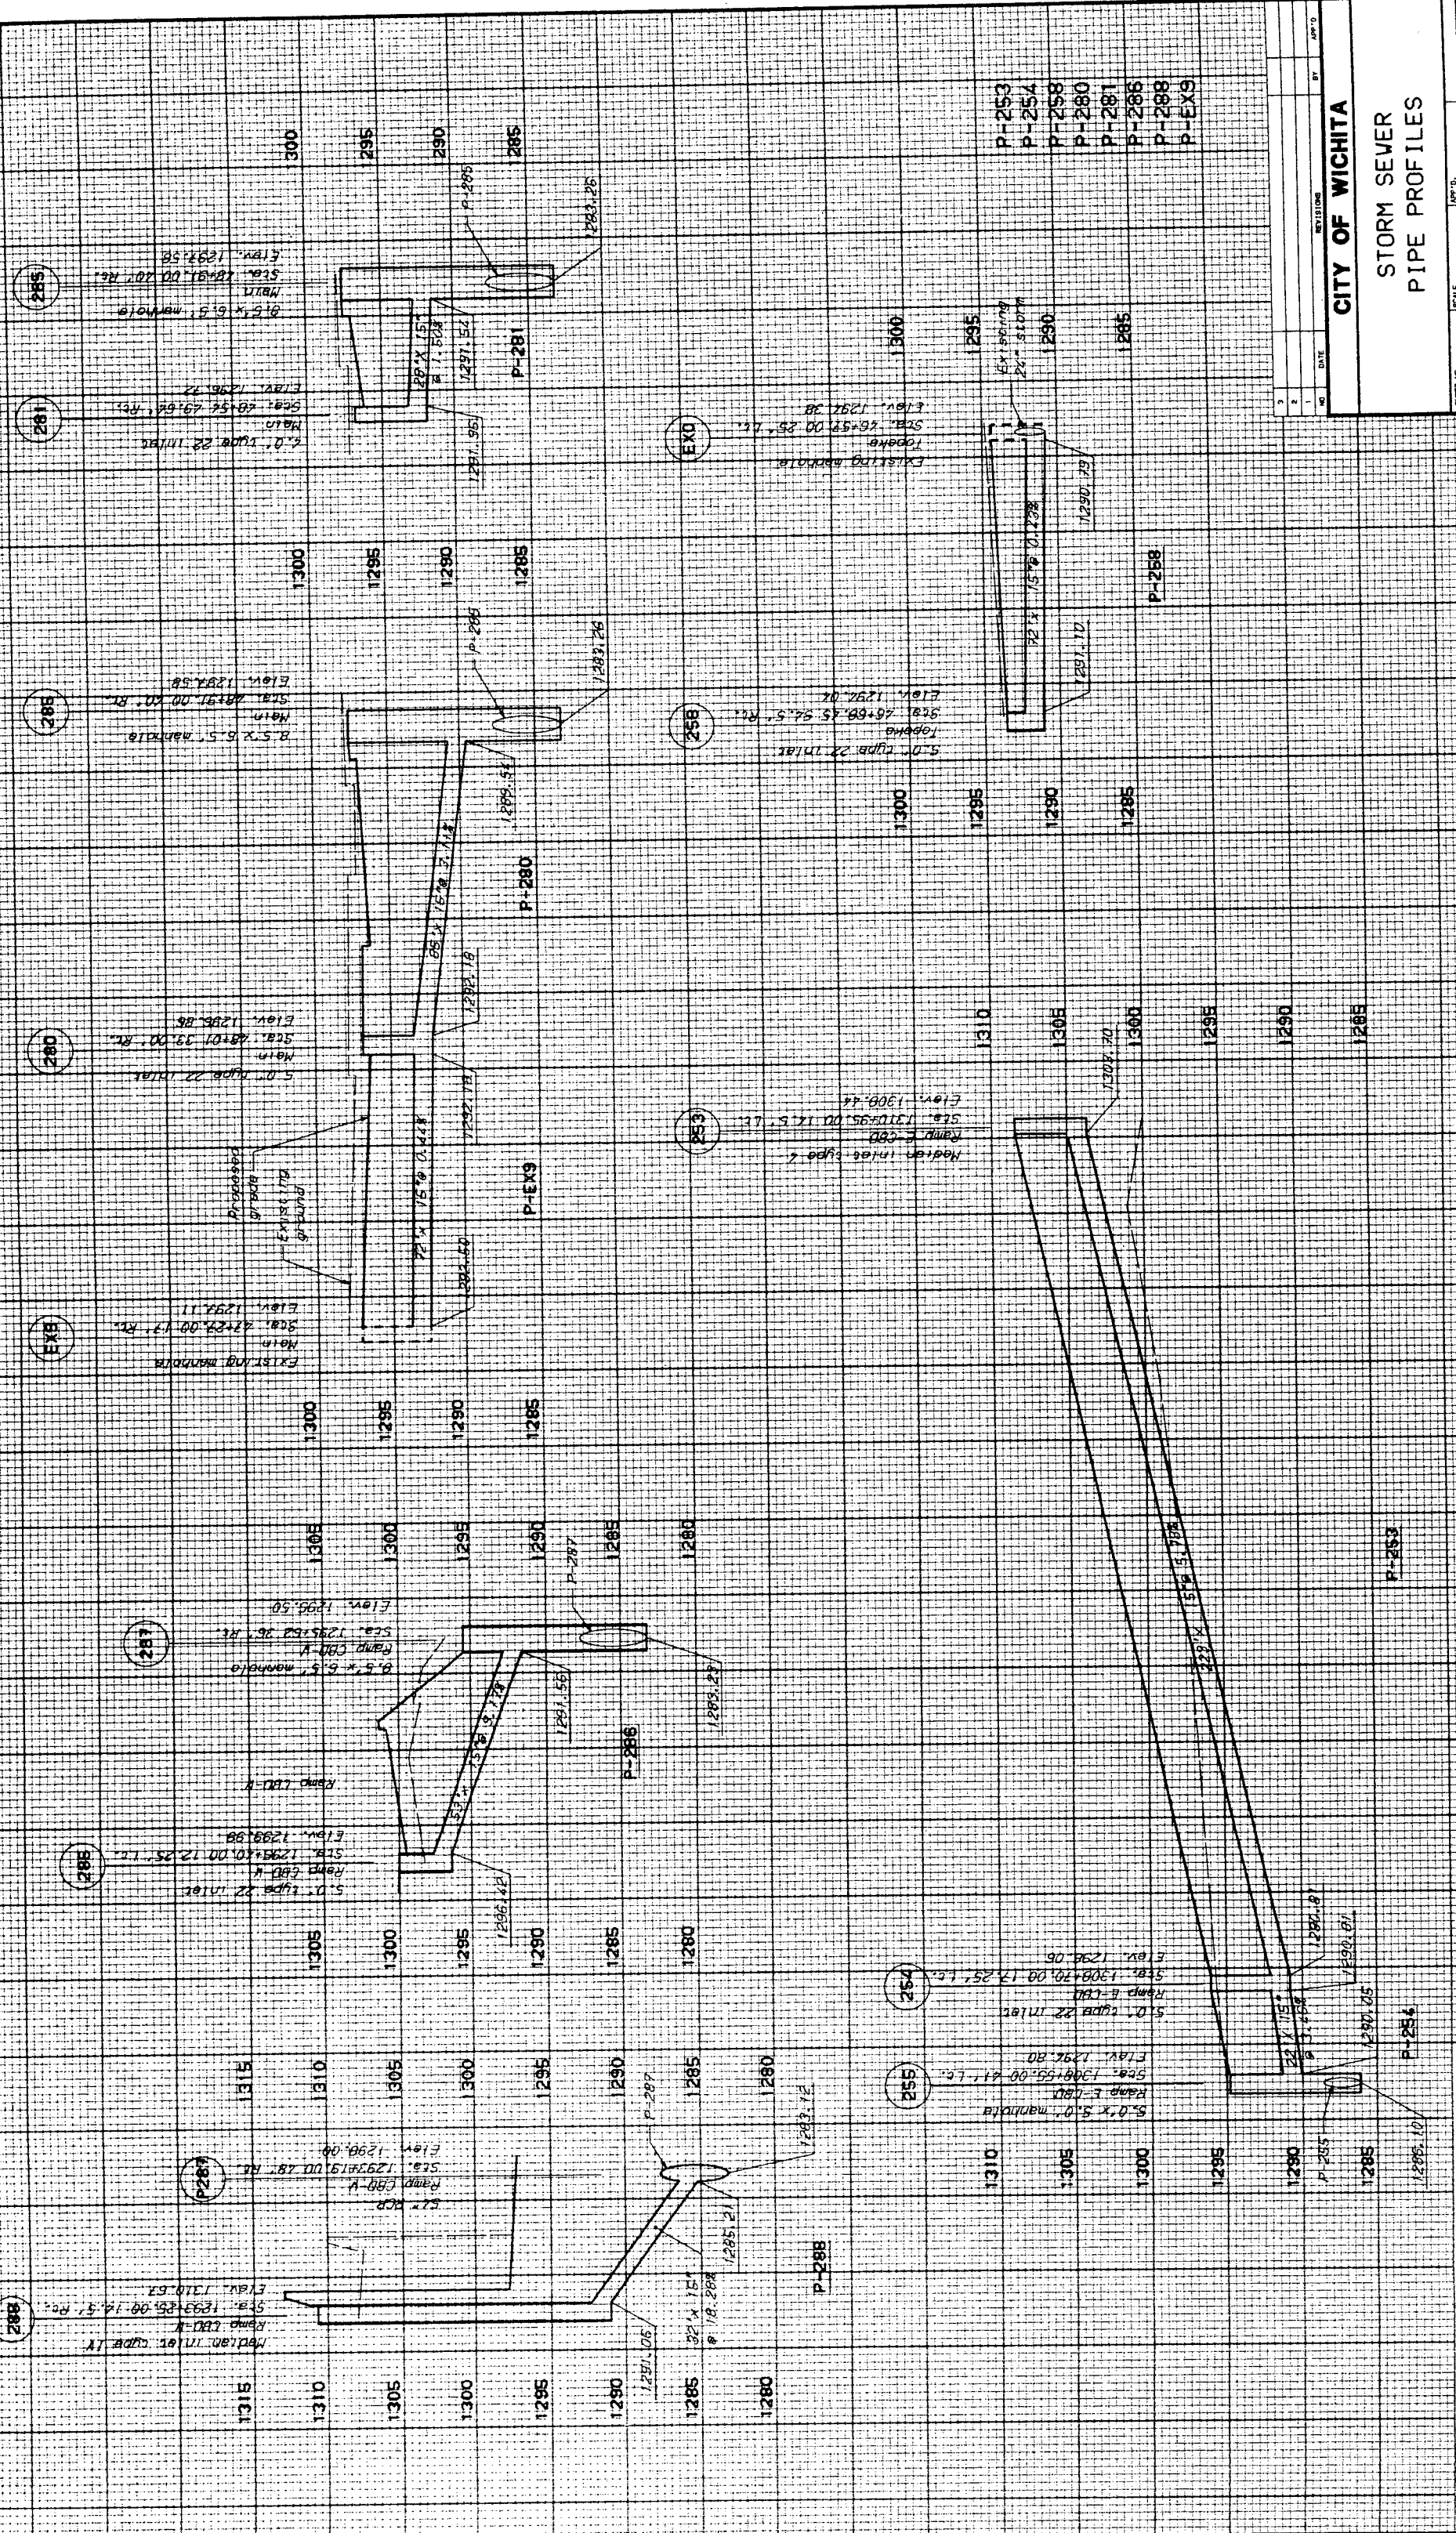

MANHOLE NO.	285	286	287	288	289	290	291	292	293	294	295	296	297
INVERT ELEVATION	1285.00	1285.00	1285.00	1285.00	1285.00	1285.00	1285.00	1285.00	1285.00	1285.00	1285.00	1285.00	1285.00
PIPE SIZE	12\"/>												


HNTB
 HENNING, MERRILL, TAYLOR & BERENSON
 ARCHITECTS ENGINEERS PLANNERS

CITY OF WICHITA
STORM SEWER
PIPE PROFILES

DATE: 9/17/60
 DRAWN BY: W.H.B.
 CHECKED BY: J.H.B.
 PROJECT NO.: 1990

PROJECT NO.	15800 59 760
DATE	
SCALE	
DATE	
SCALE	
DATE	
SCALE	
DATE	

CITY OF WICHITA
STORM SEWER
PIPE PROFILES

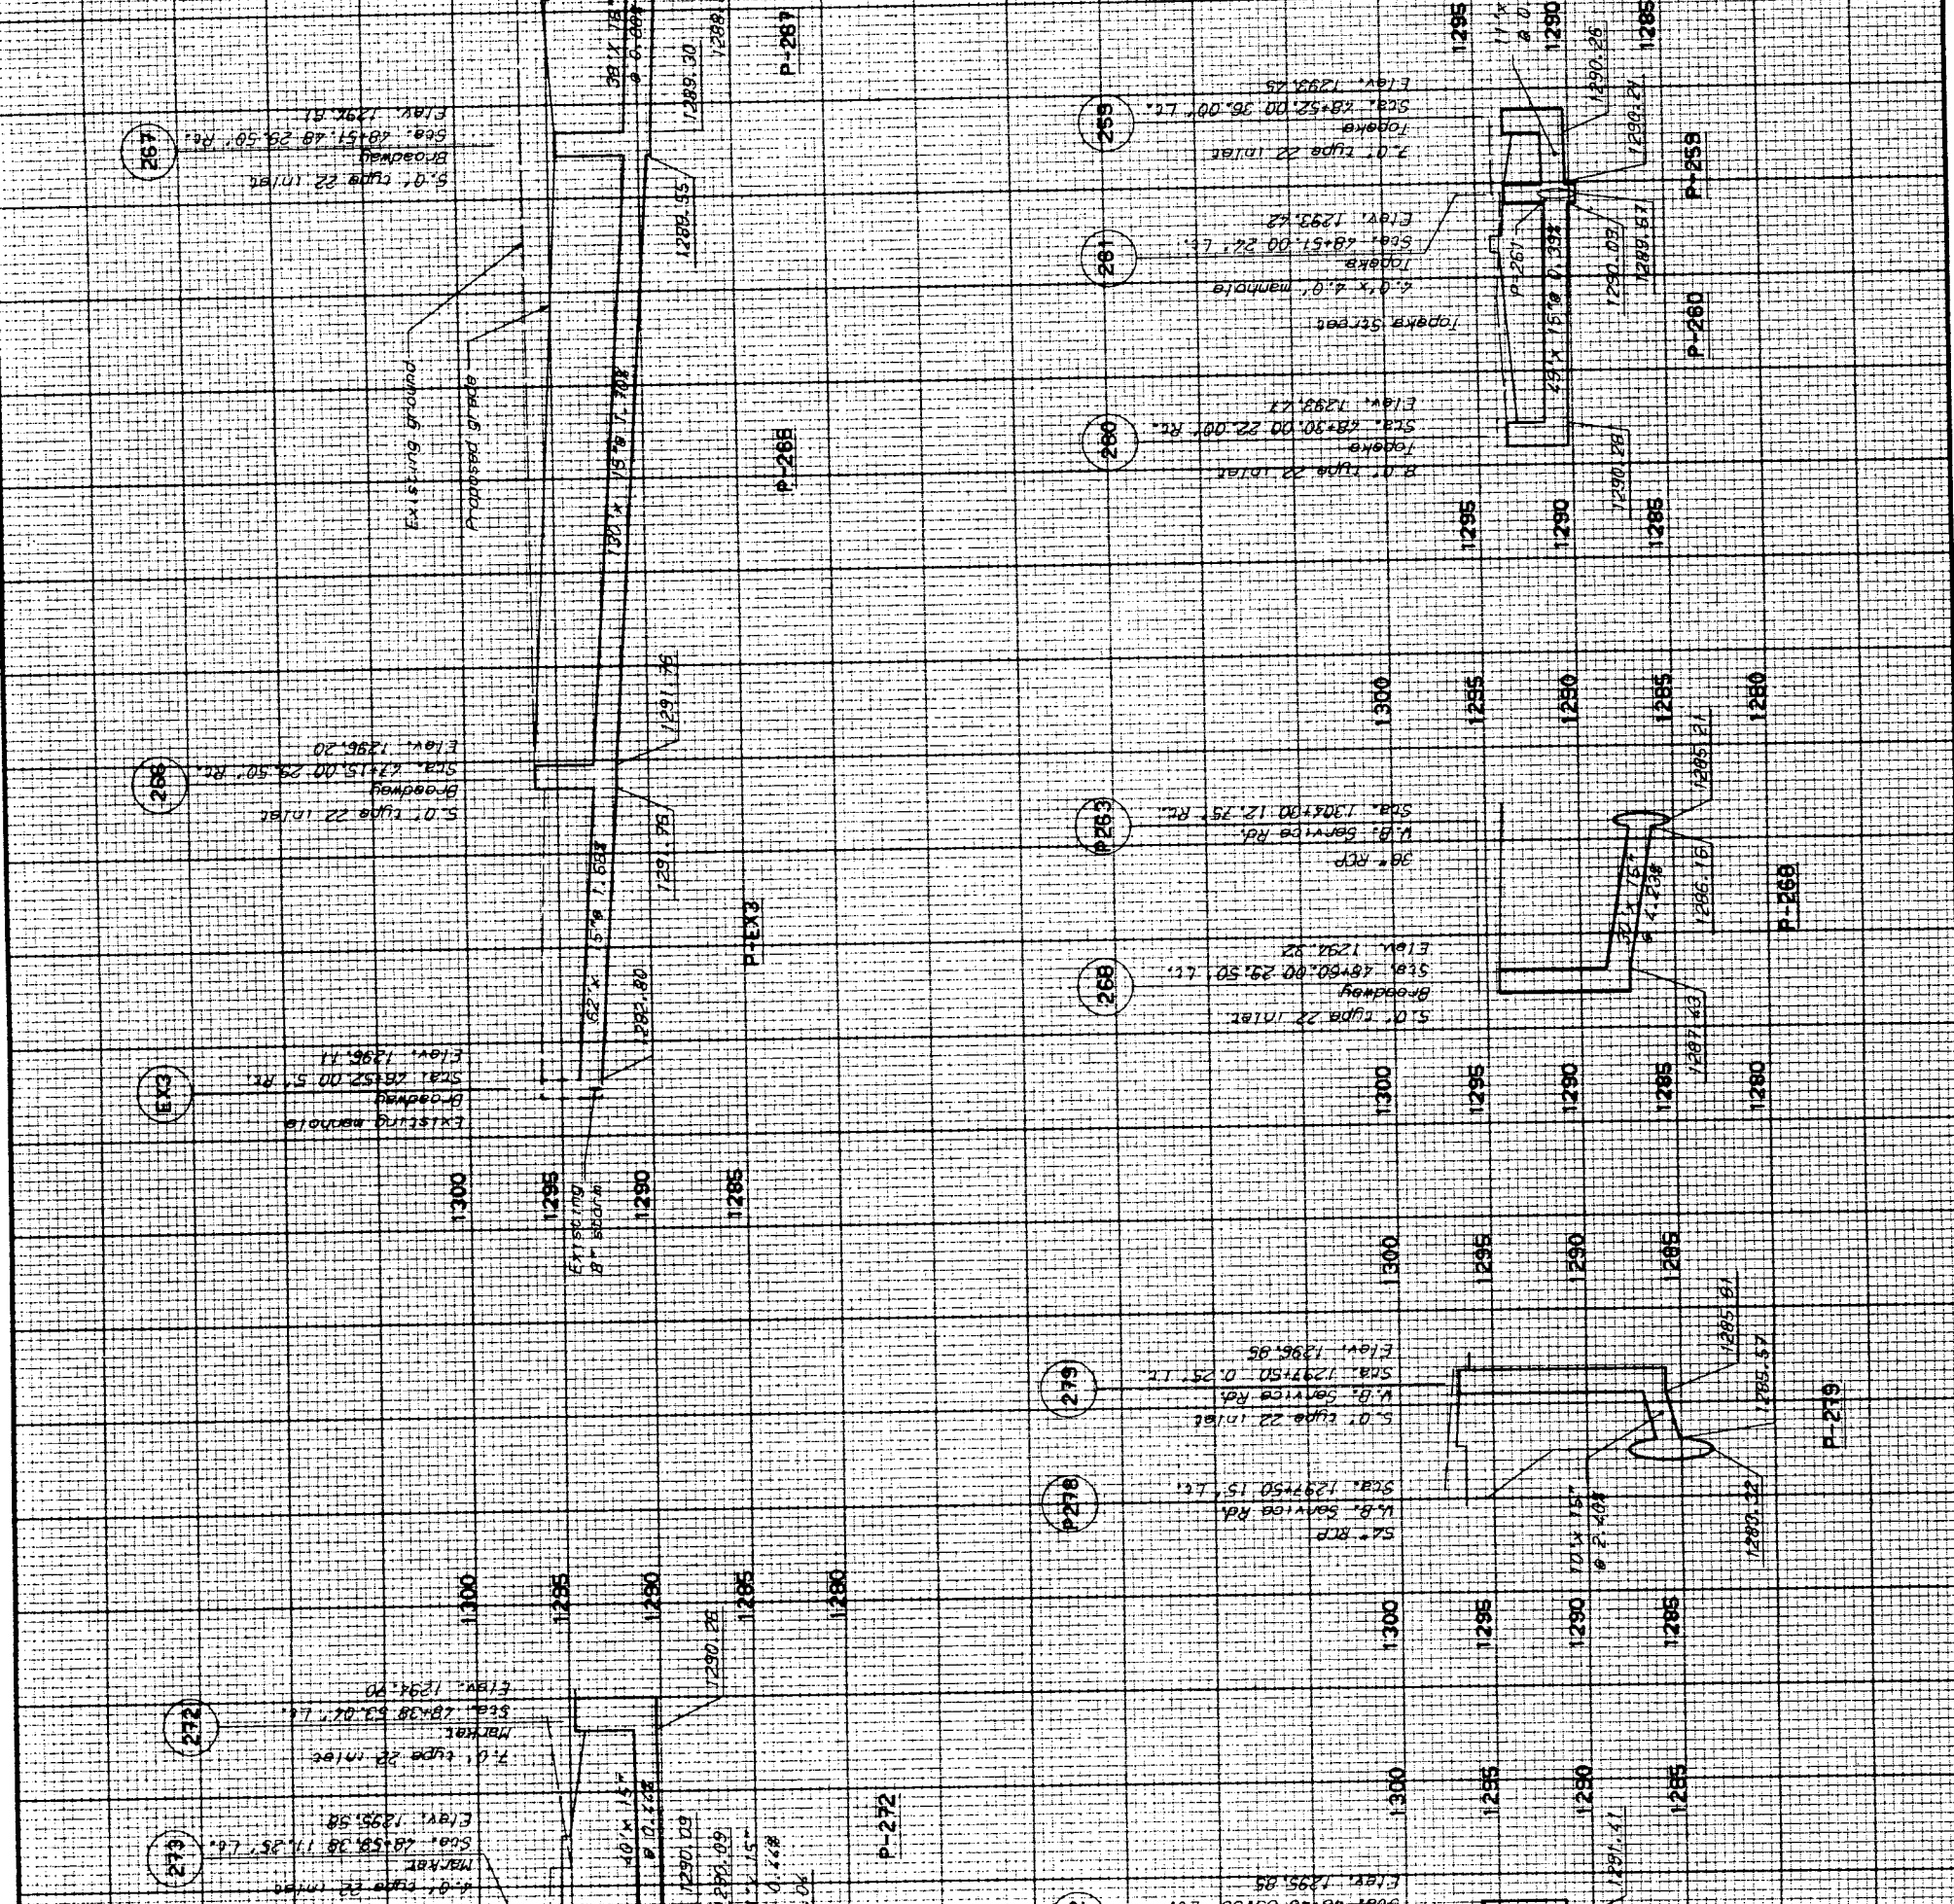


STATION	P-259	P-260	P-261	P-262	P-263	P-264	P-265	P-266	P-267	P-268	P-269	P-270	P-271	P-272	P-273	P-274	P-275	P-276	P-277	P-278	P-279	P-280	P-281	P-282	P-283	P-284
INVERT ELEVATION	1285	1285	1285	1285	1285	1285	1285	1285	1285	1285	1285	1285	1285	1285	1285	1285	1285	1285	1285	1285	1285	1285	1285	1285	1285	1285

INVENT
 ARCHITECTS ENGINEERS PLANNERS

DATE	BY	SCALE	PROJECT NO.	SHEET NO.	TOTAL SHEETS
1980	JCS	1" = 40'	1850 (00) 760	1	1

DATE	BY	SCALE	PROJECT NO.	SHEET NO.	TOTAL SHEETS
1980	JCS	1" = 40'	1850 (00) 760	1	1

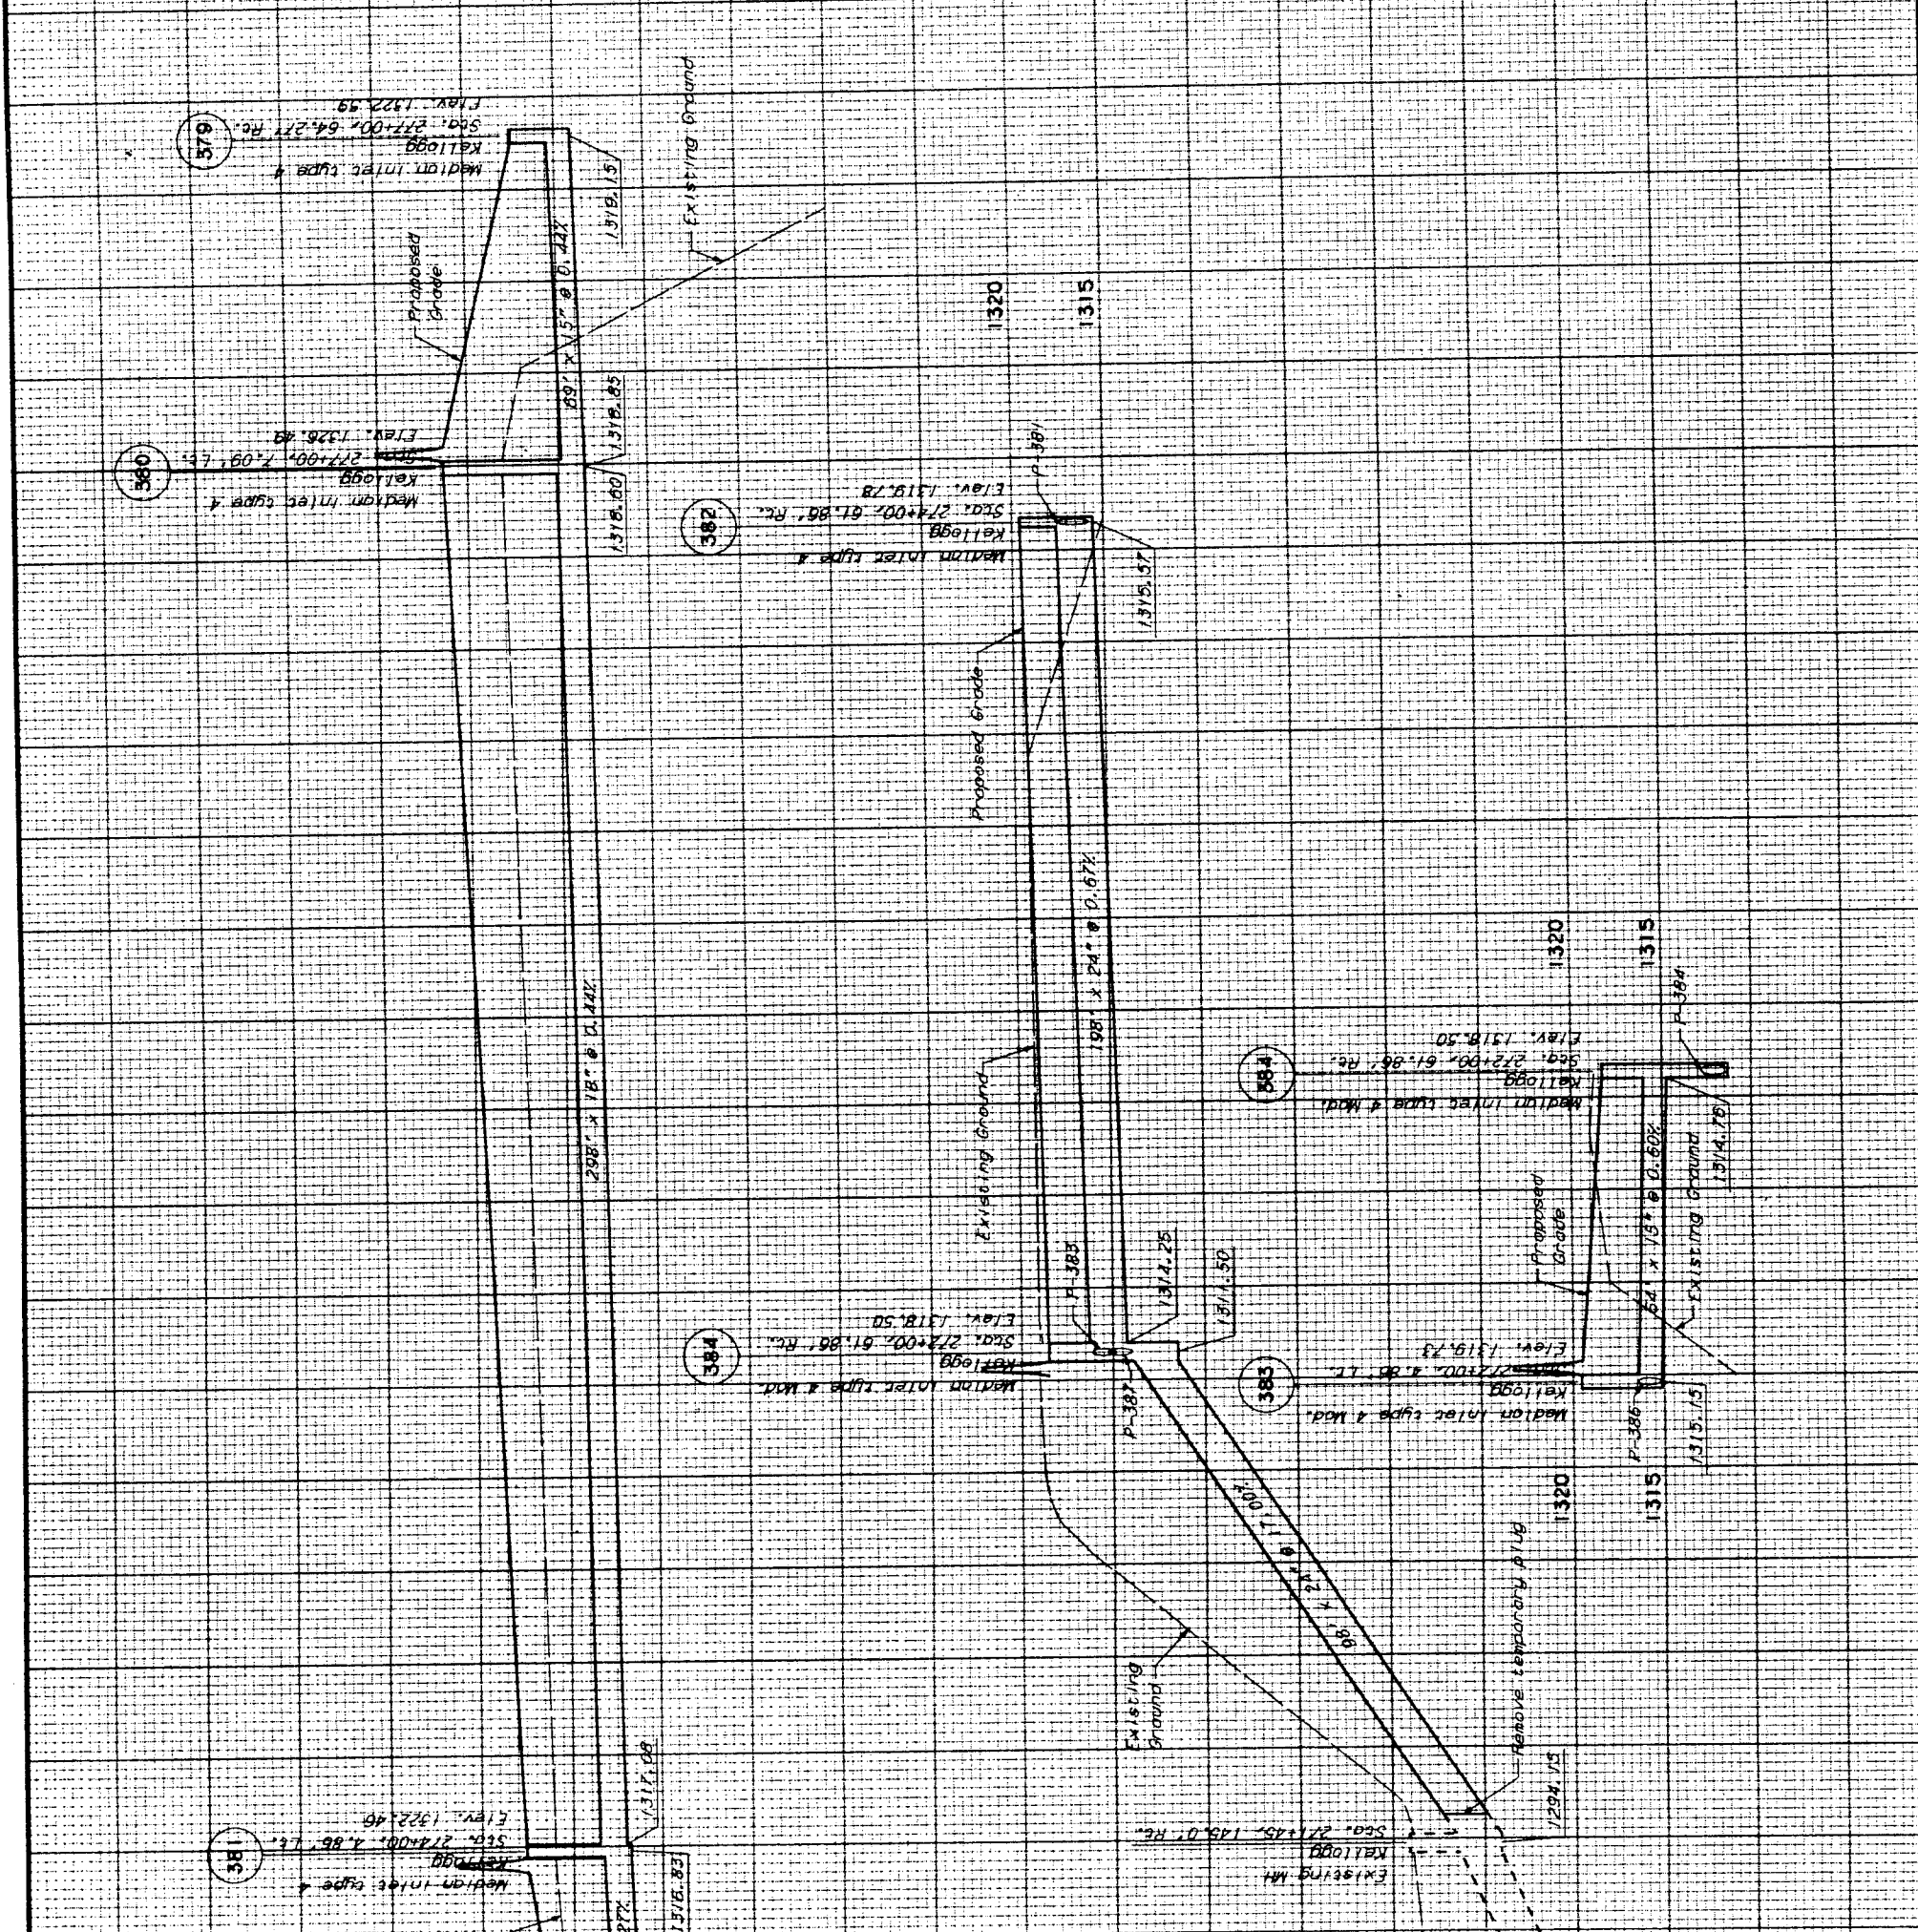

1325	1320	1315	1310	1305	1300	1295	1290	1285	1280
------	------	------	------	------	------	------	------	------	------

P-379	P-380	P-381	P-382	P-383	P-384
-------	-------	-------	-------	-------	-------

CITY OF WICHITA	
STORM SEWER	
PIPE PROFILES	

DATE	BY	SCALE	PROJECT NO.	SHEET NO.	TOTAL SHEETS
1980	JCS	1" = 40'	1850 (00) 760	1	1

DATE	BY	SCALE	PROJECT NO.	SHEET NO.	TOTAL SHEETS
1980	JCS	1" = 40'	1850 (00) 760	1	1



DATE	BY	SCALE	PROJECT NO.	SHEET NO.	TOTAL SHEETS
1980	JCS	1" = 40'	1850 (00) 760	1	1

DATE	BY	SCALE	PROJECT NO.	SHEET NO.	TOTAL SHEETS
1980	JCS	1" = 40'	1850 (00) 760	1	1

HNTB
HOWARD NEEDLES TAMM & BERENSON
ARCHITECTS ENGINEERS PLANNERS