
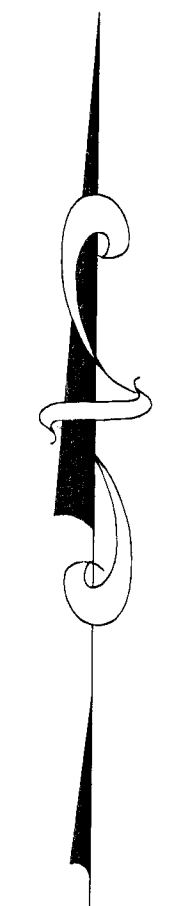


CITY OF WICHITA, KANSAS
 JAMES L. ARMOUR, P.E. - CITY ENGINEER

ALEY MINI-CITY HALL PARKING LOT

CITY OF WICHITA PROJECT NO. 472 - 83988
 OCA NO. 602529

PROJECT LOCATION

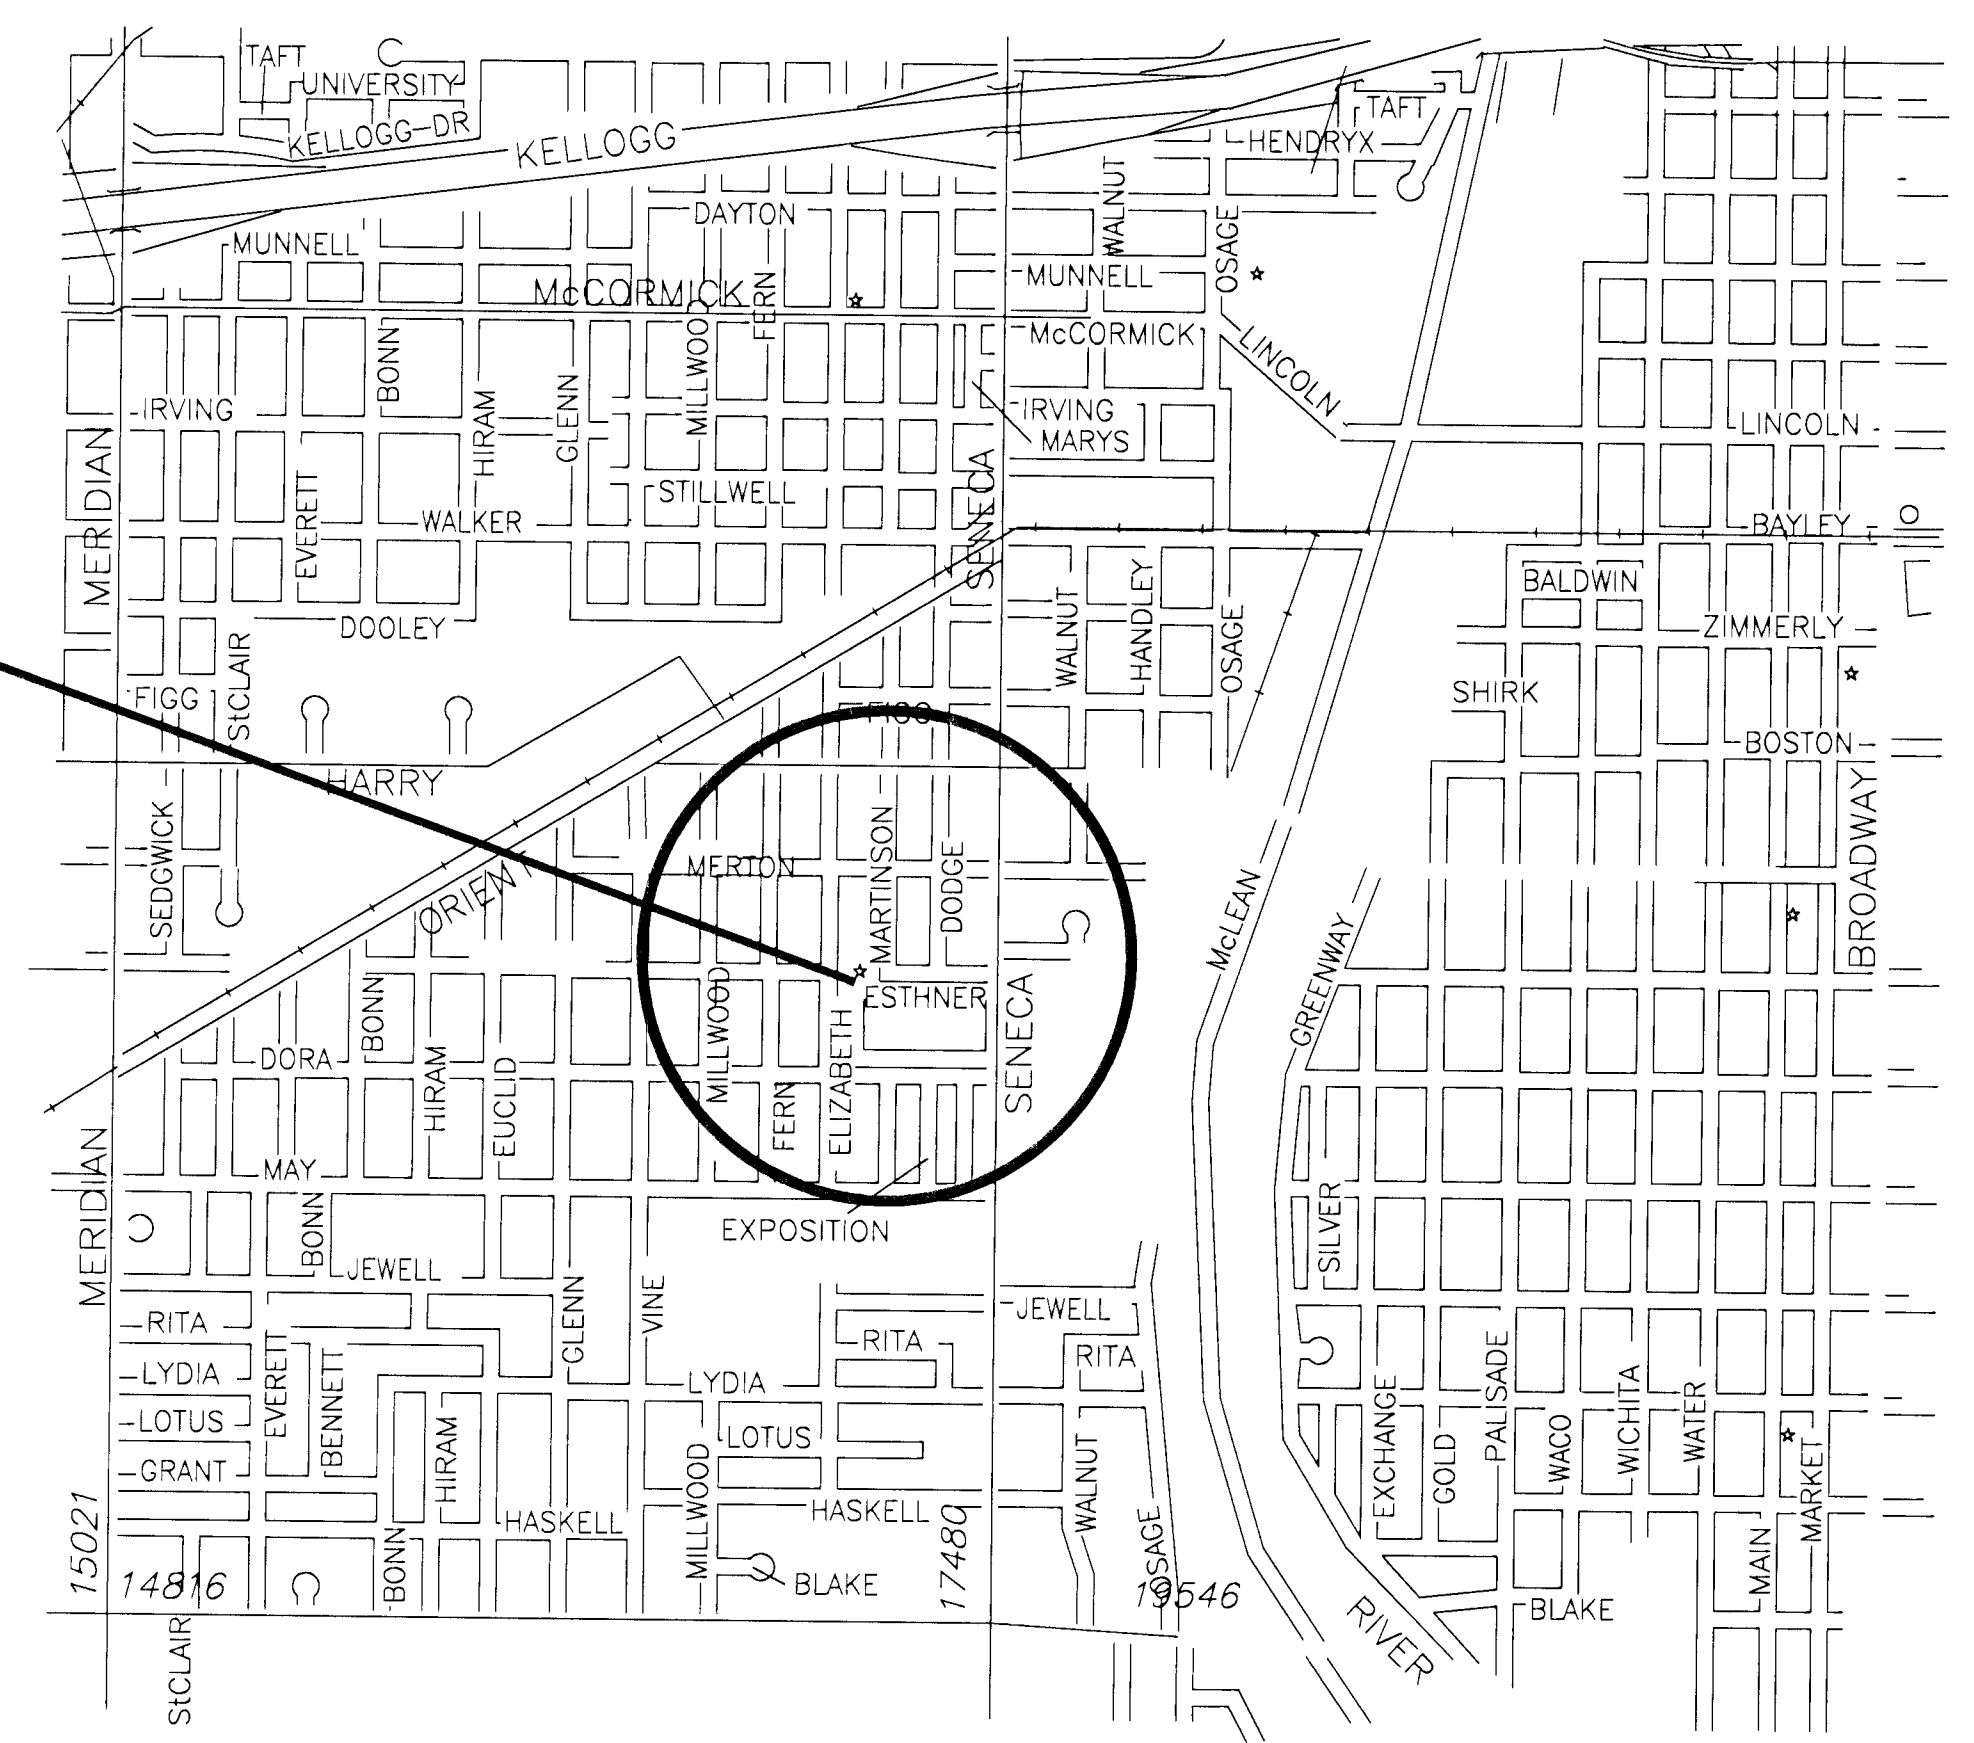

INDEX OF SHEETS


1. TITLE SHEET
2. EXISTING SITE PLAN
3. LIGHTING INSTALLATION

NOTES:

*PRIOR TO ALL WORK ON ANY ELECTRICAL SYSTEM, CONTACT:
 PRINCIPAL ANITA ALLARD, 973-1300, SUPERVISOR JOE HOOVER, 973-2239,
 AND RICK IVEY, 268-4122.*

*BUILDING SERVICES TO FIELD LOCATE CENTRAL CONTROL PANEL AND
 ELECTRICAL REQUIREMENTS OF BUILDING AUTOMATED CONTROL SYSTEMS.*

DRAWN: 7-03-03 LEWIS BLACKWELL

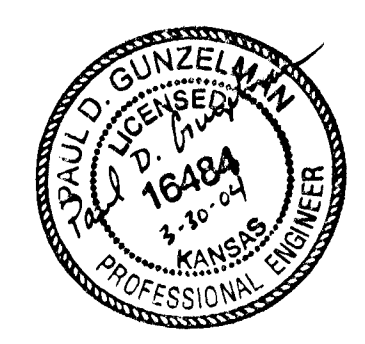

 WICHITA ENGINEERING	ALEY MINI-CITY HALL TITLE SHEET		
	CITY ENGINEER JAMES L. ARMOUR, P.E.		
	PROJECT NUMBER 472 - 83988	OCA NUMBER 602529	DATE MAR 2, 04
	CITY ENGINEER'S OFFICE CITY HALL - SEVENTH FLOOR 455 NORTH MAIN STREET WICHITA, KANSAS 67202-1820 (316) 268-4501 (316) 268-4114 FAX		DESIGN LRB
		SHEET 1 OF 3	