

WATER DISTRIBUTION SYSTEM IMPROVEMENTS

TO SERVE


HEARTLAND PREPAREDNESS CENTER

CITY OF WICHITA PROJECT NO. 448-90476

OCA NO. 792529

CITY OF WICHITA, KANSAS

JAMES L. ARMOUR, P.E. - CITY ENGINEER

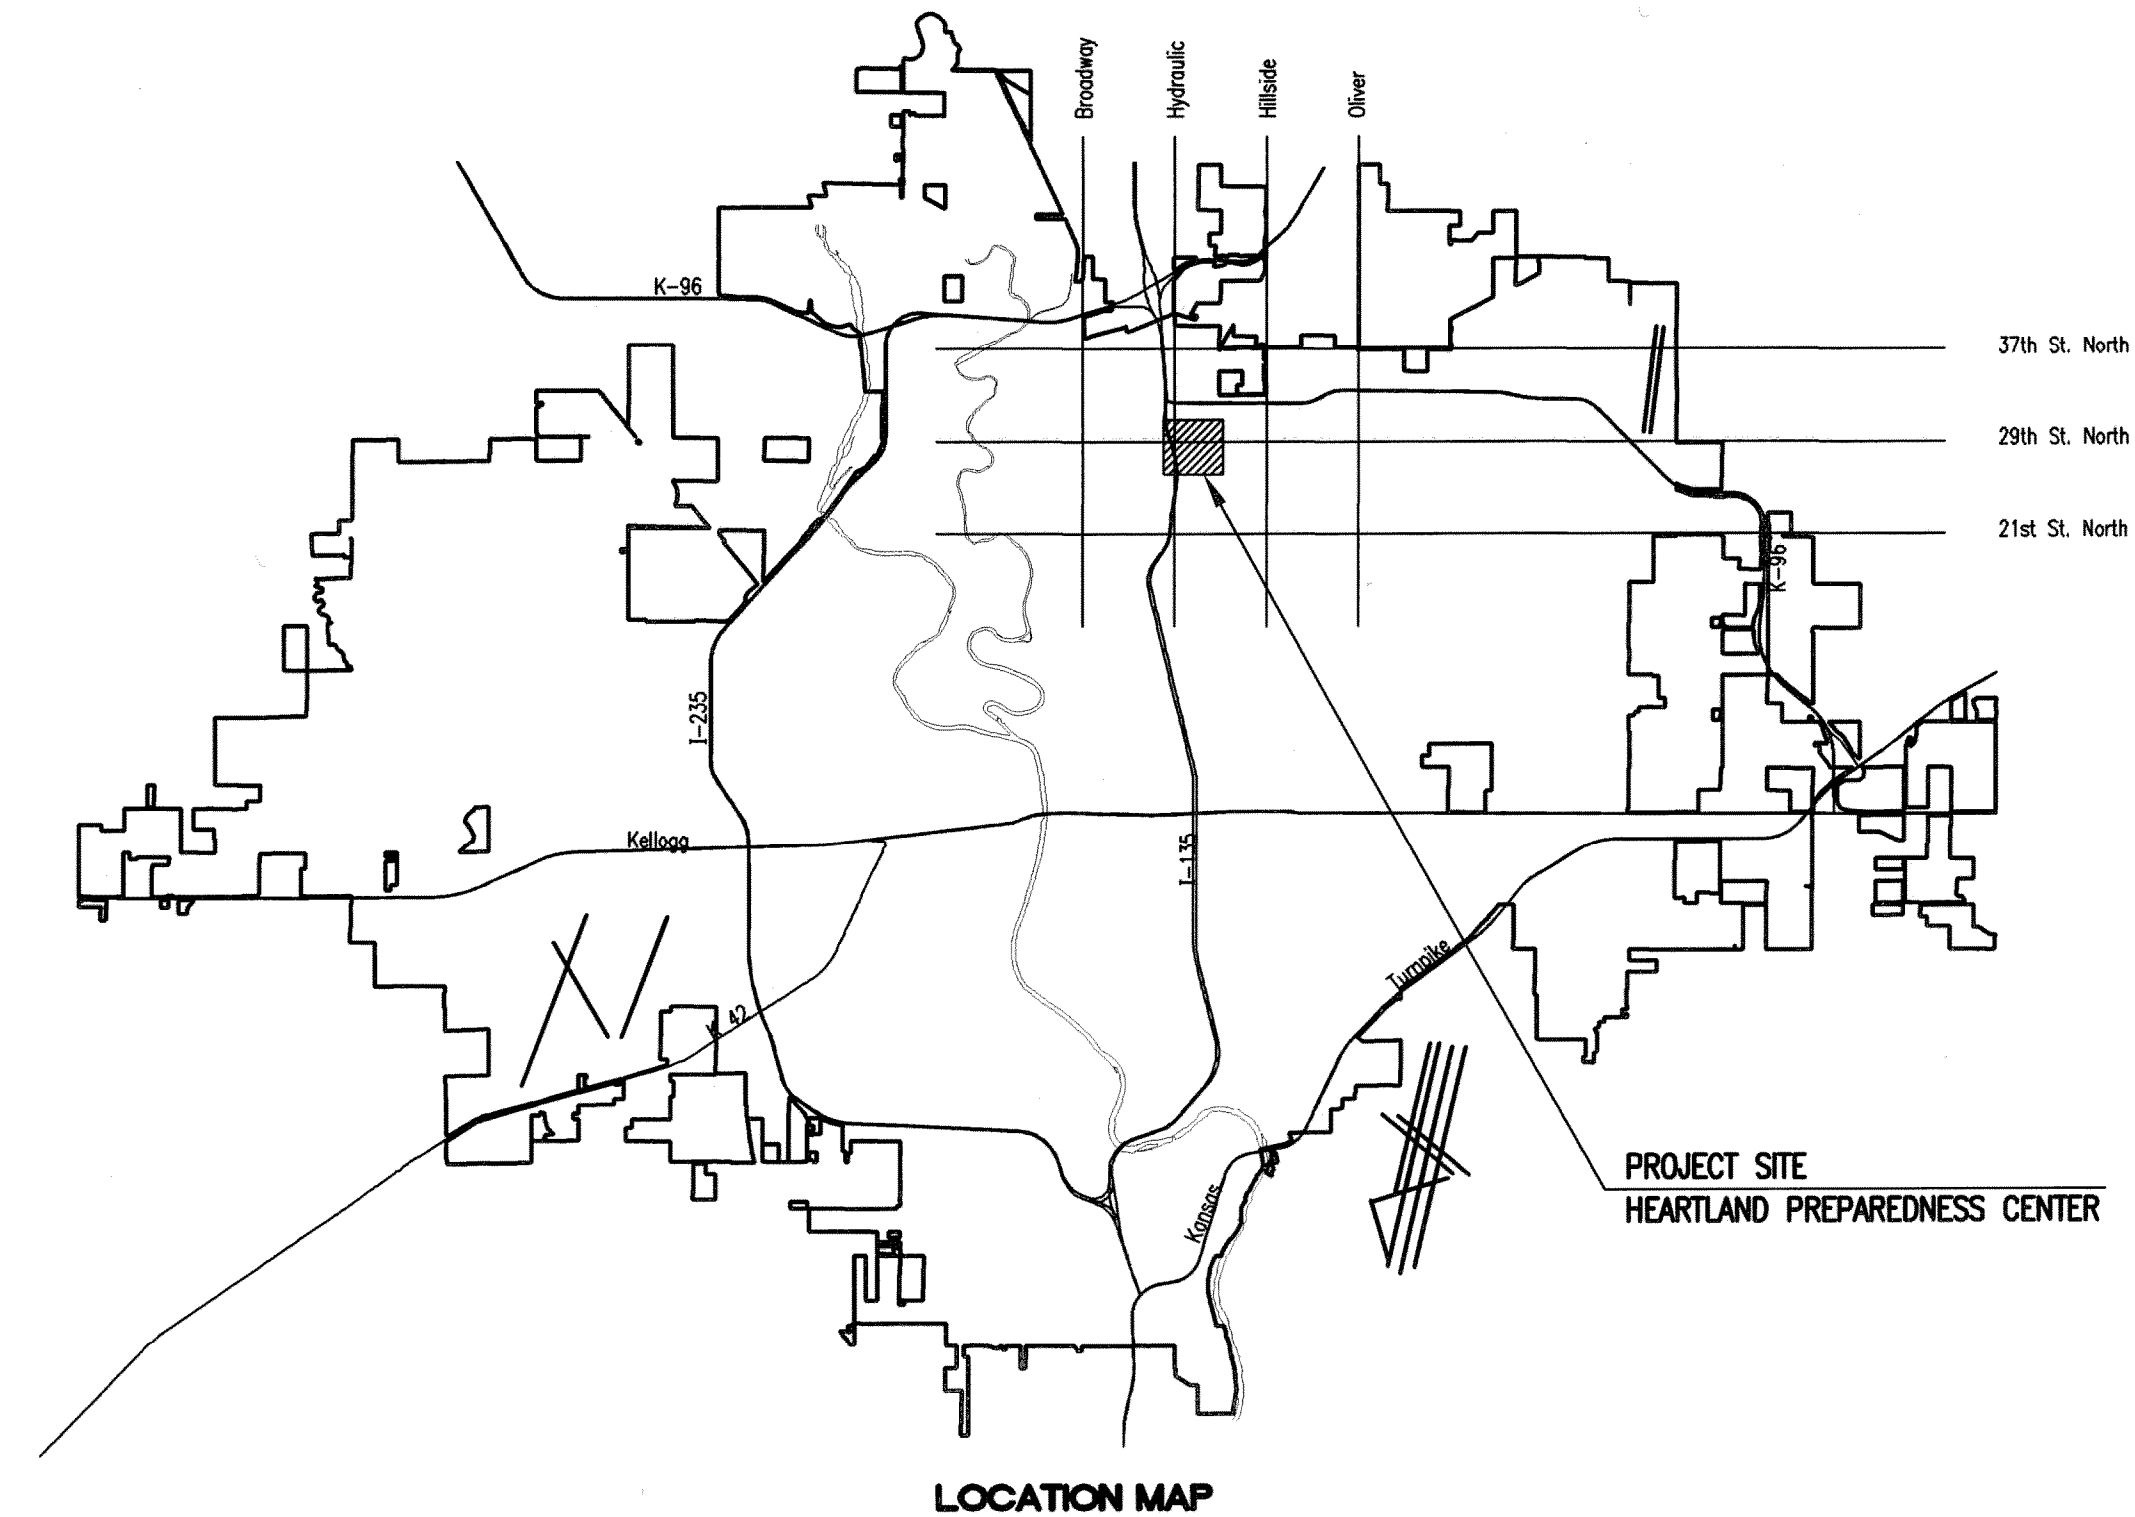

INDEX OF SHEETS

SHEET NO. 1	TITLE SHEET
SHEET NO. 2	KEY MAP AND GENERAL NOTES
SHEET NO. 3	HORIZONTAL AND VERTICAL CONTROL
SHEET NO. 4	STANDARD WATER ASSEMBLY DETAILS
SHEET NO. 5-12	WATERLINE PLAN AND PROFILE
SHEET NO. 13-14	PLAT
SHEET NO. 15-17	SOIL EROSION DETAILS



JULY 2010

PLANS PREPARED BY
PROFESSIONAL ENGINEERING CONSULTANTS, P.A.
 ENGINEERS
 WICHITA, KANSAS