
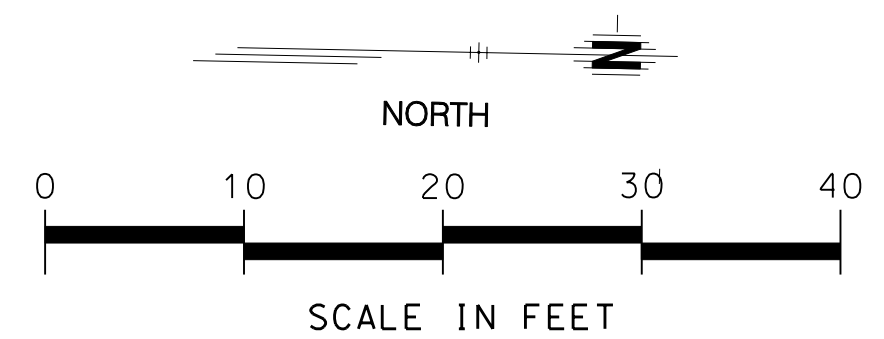


STATE	PROJECT NO.	YEAR	SHEET NO.	TOTAL SHEETS
KANSAS	472-84071	2005	LS3.11	

Alternate #4

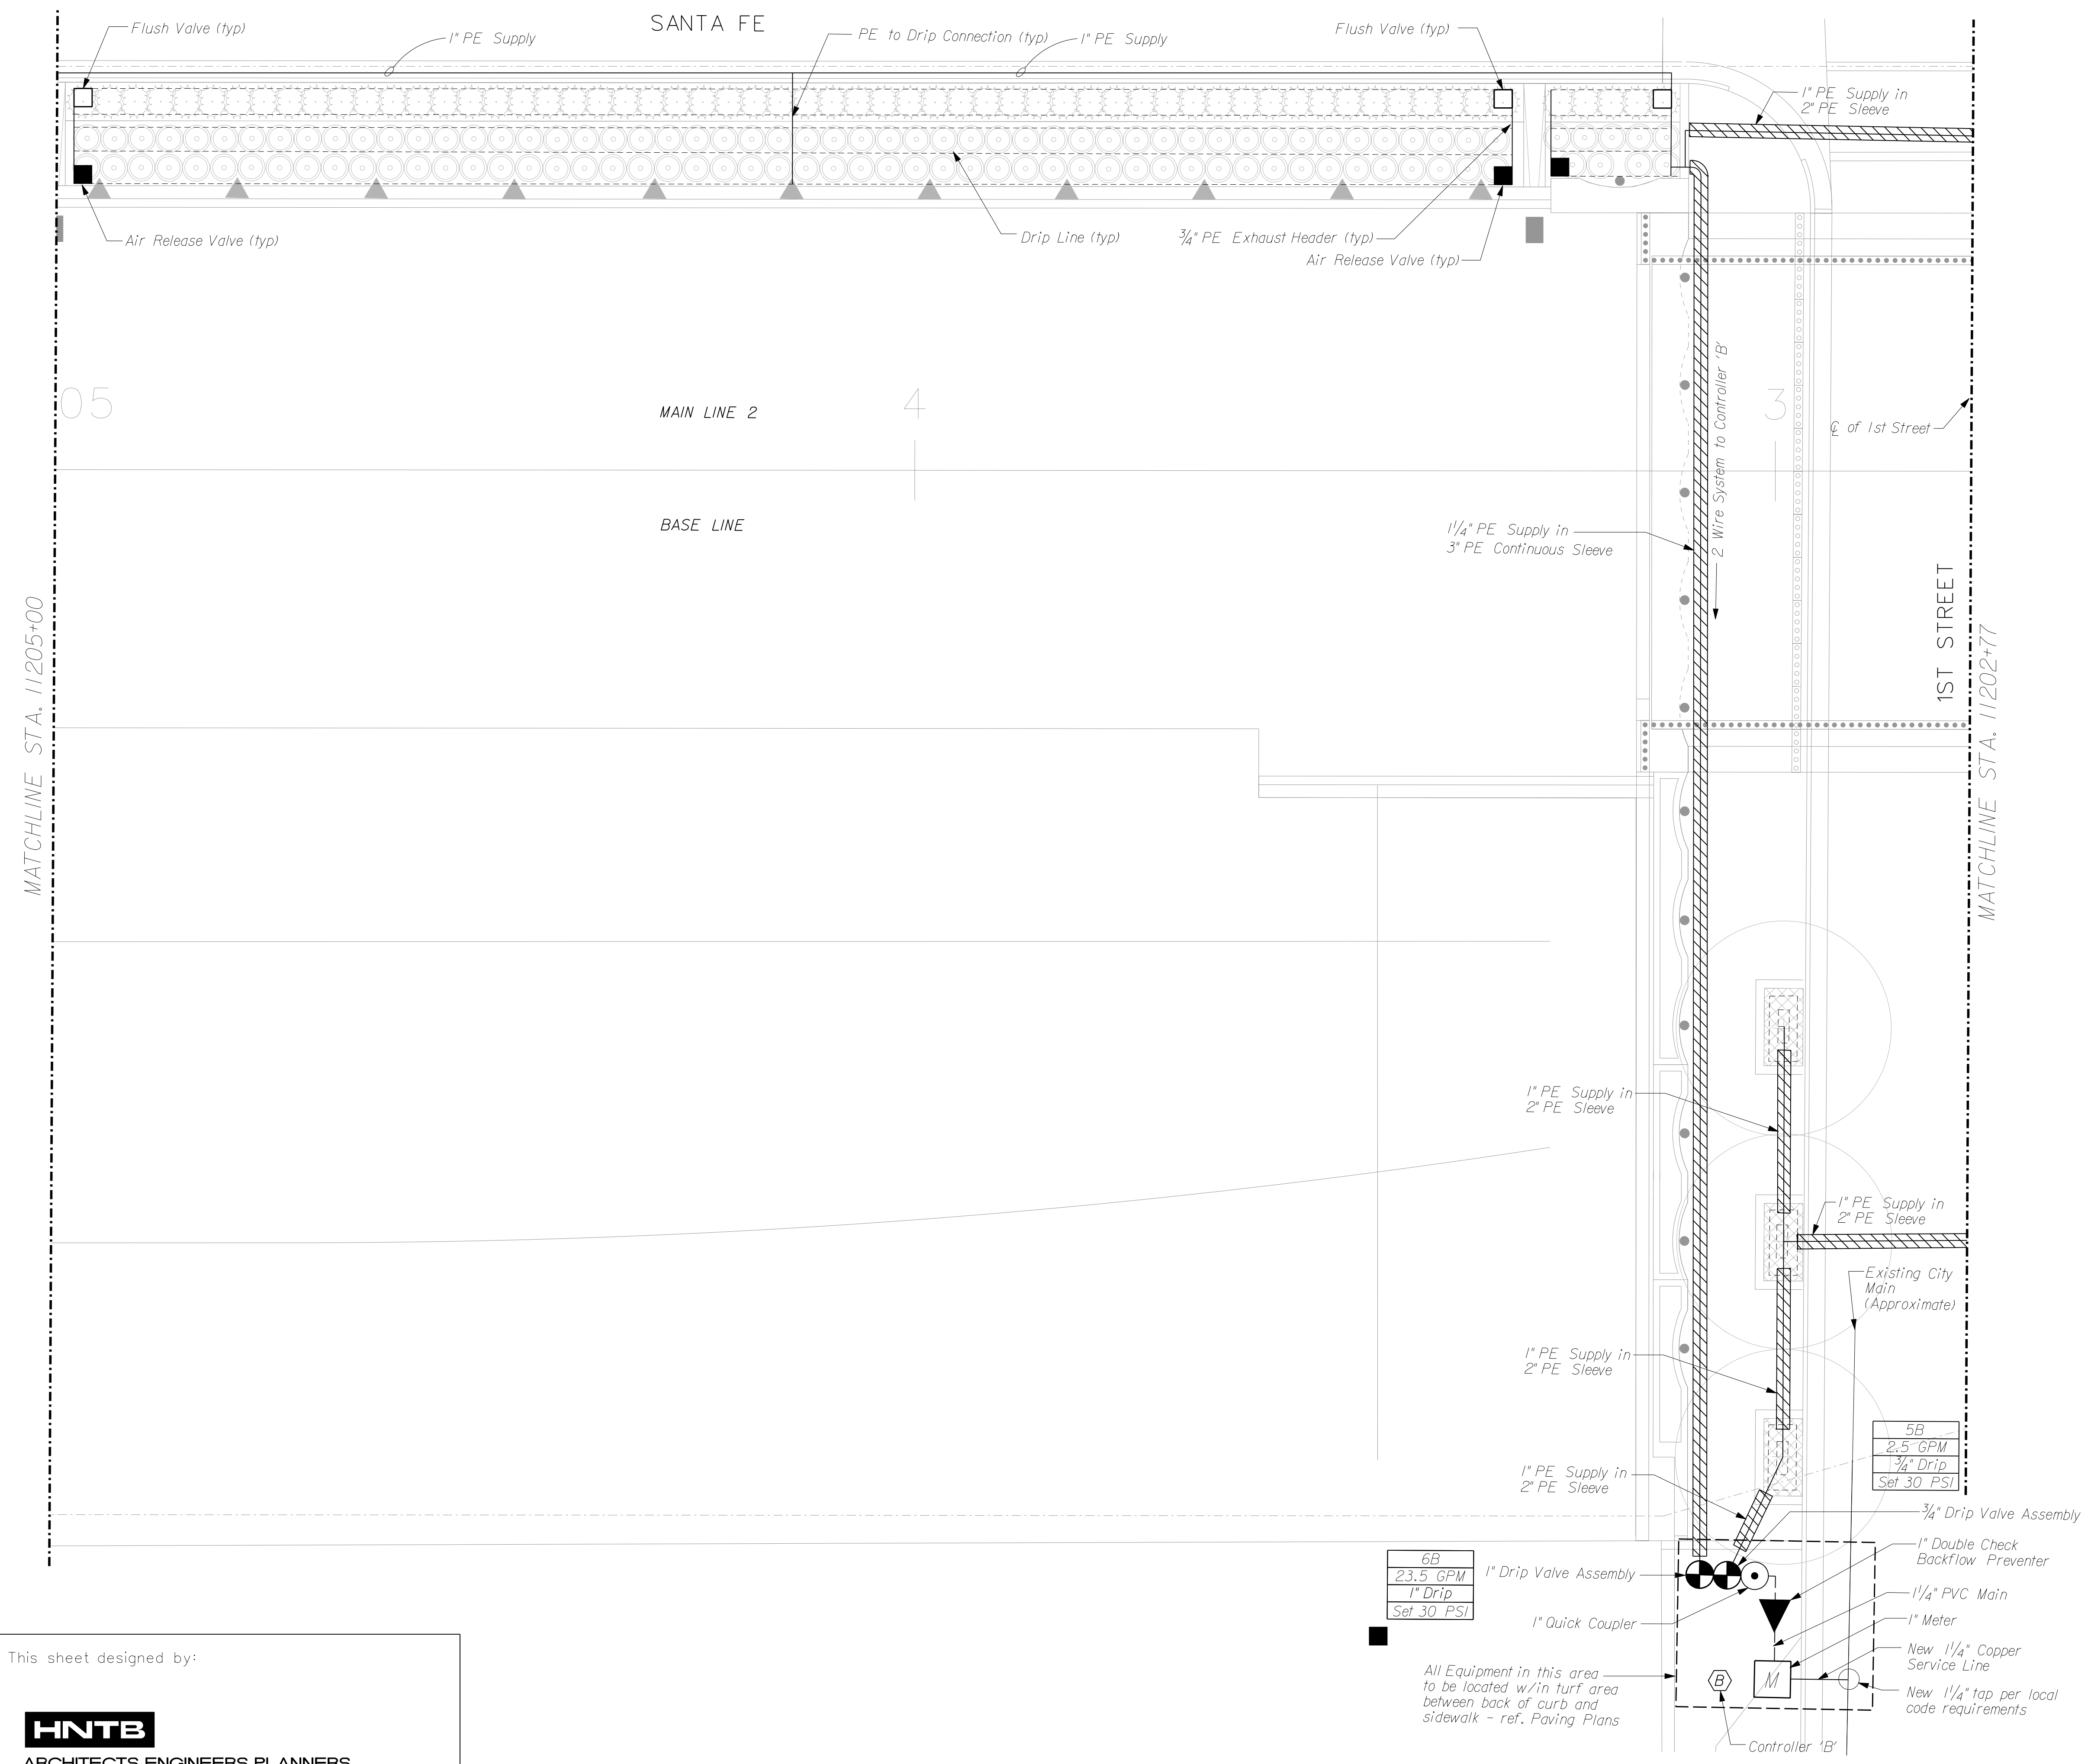

3				
2				
1				
NO.	DATE	REVISIONS	BY	APP'D
CITY OF WICHITA				
WICHITA CENTRAL CORRIDOR				
IRRIGATION PLAN				
1ST STREET BRIDGE				
SHEET NO. 10 OF 13	SCALE: 1" = 10'-0"	APP'D:	QUANTITIES: JRK, KA	TRACED:
DESIGNED: JF	DETAILED: JRK, KA	DESIGN CK.: WP	DETAIL CK.: WSN	TRACE CK.:

This sheet designed by:

6B
23.5 GPM
1" Drip
Set 30 PSI

1" Drip Valve Assembly
1" Quick Coupler

All Equipment in this area to be located w/in turf area between back of curb and sidewalk - ref. Paving Plans

5B
2.5 GPM
3/4" Drip
Set 30 PSI

3/4" Drip Valve Assembly
1" Double Check Backflow Preventer
1 1/4" PVC Main
1" Meter
New 1 1/4" Copper Service Line
New 1 1/4" tap per local code requirements

Controller 'B'