


Saved: 09-25-2009 10:28:40 AM by: NSM
 Plot Scale: 1:360 (9'-24"=2009 1:28:29 PM
 \\net_local_is\osgi_data\Drawings\DWG\2004\04274\04274-004 - 54A - EAST - ELECTRICAL SITE PLAN

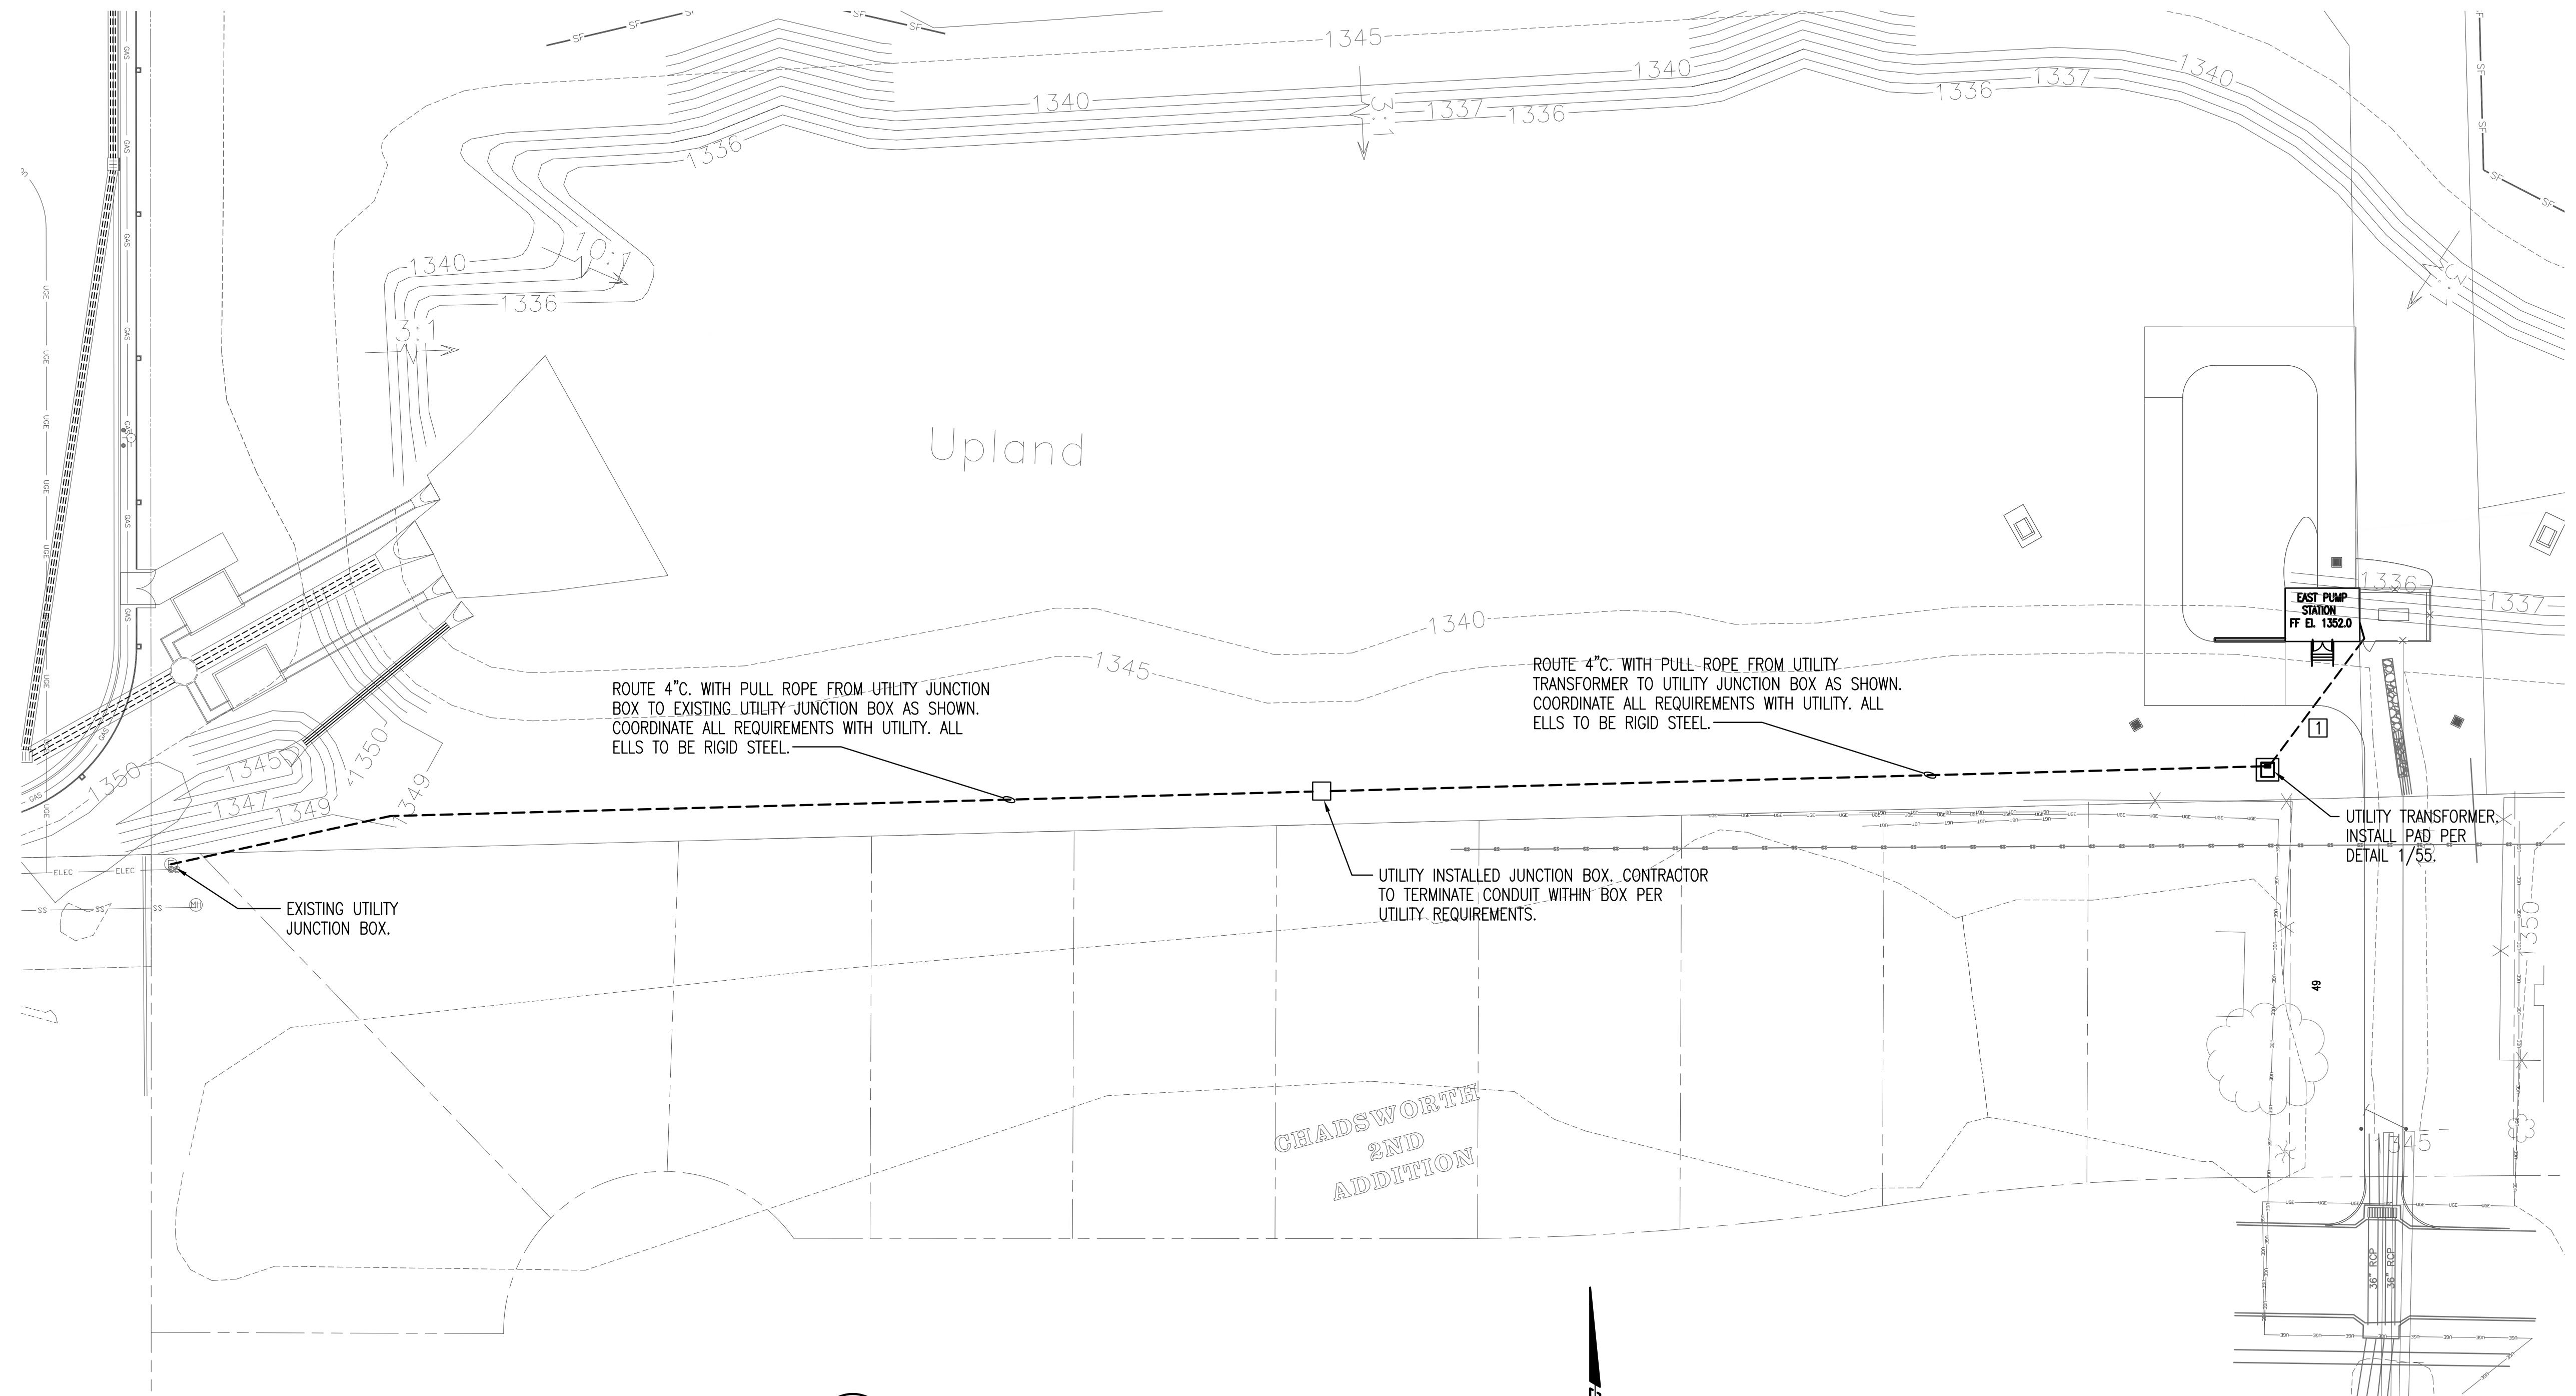

ROUTE 4" C. WITH PULL ROPE FROM UTILITY JUNCTION BOX TO EXISTING UTILITY JUNCTION BOX AS SHOWN. COORDINATE ALL REQUIREMENTS WITH UTILITY. ALL ELLS TO BE RIGID STEEL.

ROUTE 4" C. WITH PULL ROPE FROM UTILITY TRANSFORMER TO UTILITY JUNCTION BOX AS SHOWN. COORDINATE ALL REQUIREMENTS WITH UTILITY. ALL ELLS TO BE RIGID STEEL.


EXISTING UTILITY JUNCTION BOX.

UTILITY INSTALLED JUNCTION BOX. CONTRACTOR TO TERMINATE CONDUIT WITHIN BOX PER UTILITY REQUIREMENTS.

UTILITY TRANSFORMER. INSTALL PAD PER DETAIL 1/55.

CHADSWORTH
2ND
ADDITION

A ELECTRICAL SITE PLAN
 1" = 30'-0"

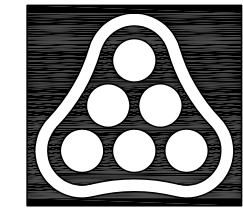

1	ADDENDUM #2	NSM	8/12/09
No.	Revision	By	Date
PHASE II - STORM WATER DRAIN #332 ELECTRICAL SITE PLAN EAST PUMP STATION JAMES L. ARMOUR, P.E. - CITY ENGINEER CITY OF WICHITA PROJECT NO. 468-84396 Professional Engineering Consultants, P.A. 303 S. TOPKA • WICHITA, KANSAS 67202 316-262-2691 • FAX 316-262-3003			
Designed by	RDB	Job No.	35-04274-042
Drawn by	NSM	Date	SEPTEMBER 2009
			Sht. 54A of 63