

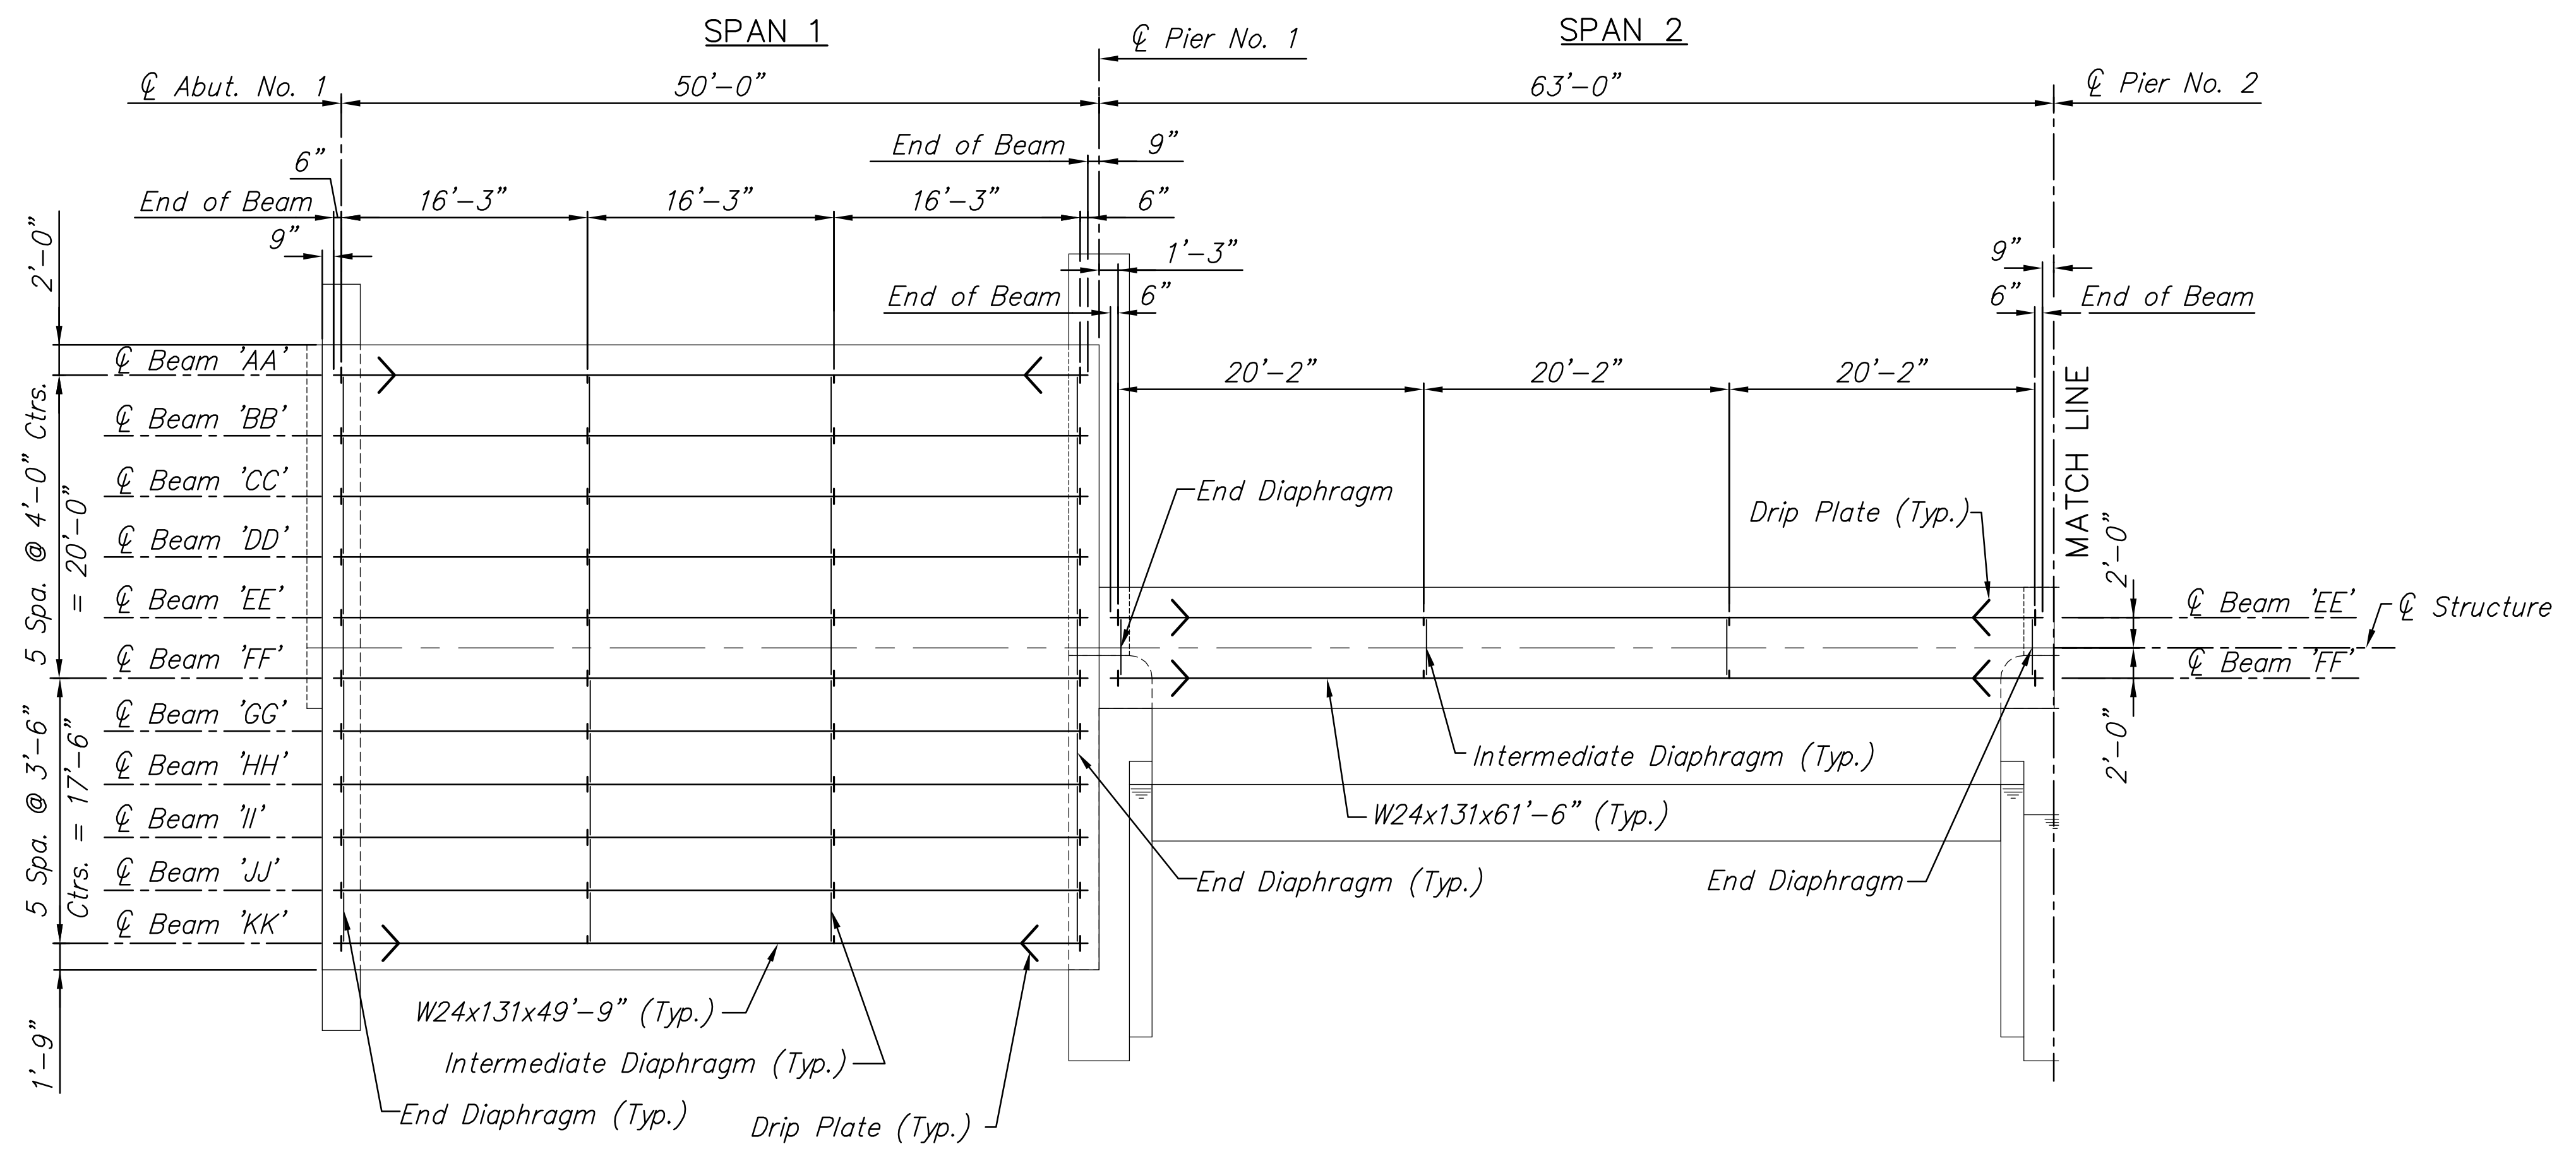


STATE	PROJECT NO.	YEAR	SHEET NO.	TOTAL SHEETS
KANSAS	87 N-0361-01	2011	97	169


**MKEC**  
ENGINEERING  
CONSULTANTS, INC.  
411 N. WEBB ROAD  
WICHITA, K.S. 67206  
316-684-9600

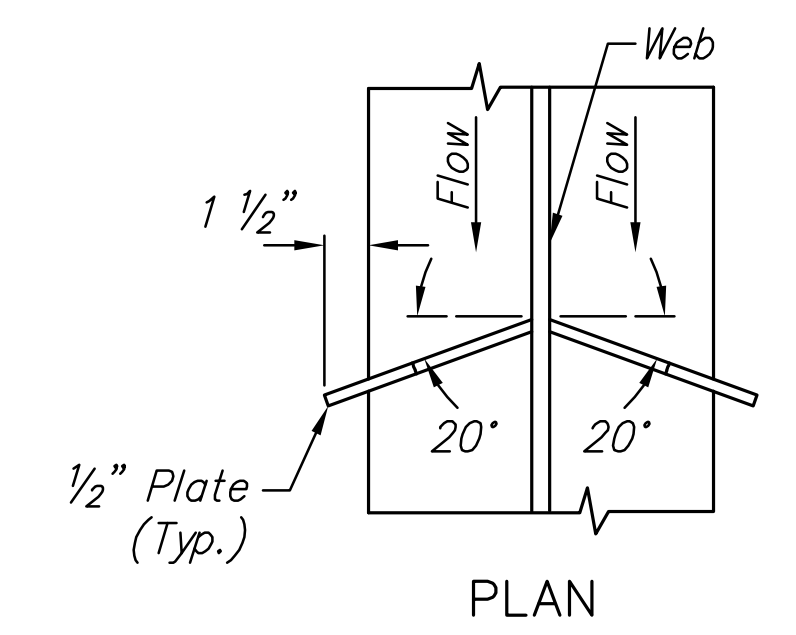

FRAMING PLAN - SPAN 1 & SPAN 2

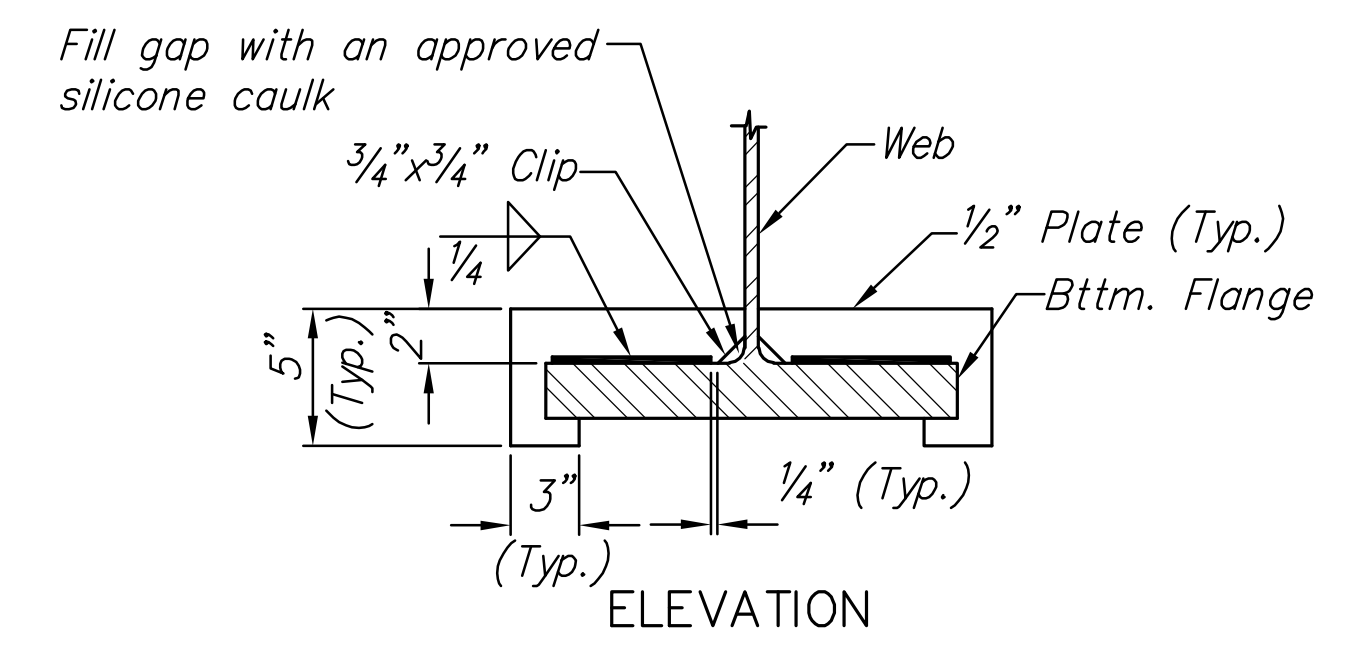

DRIP PLATE DETAIL  
Drip plates are located on the exterior beams as shown on framing plan

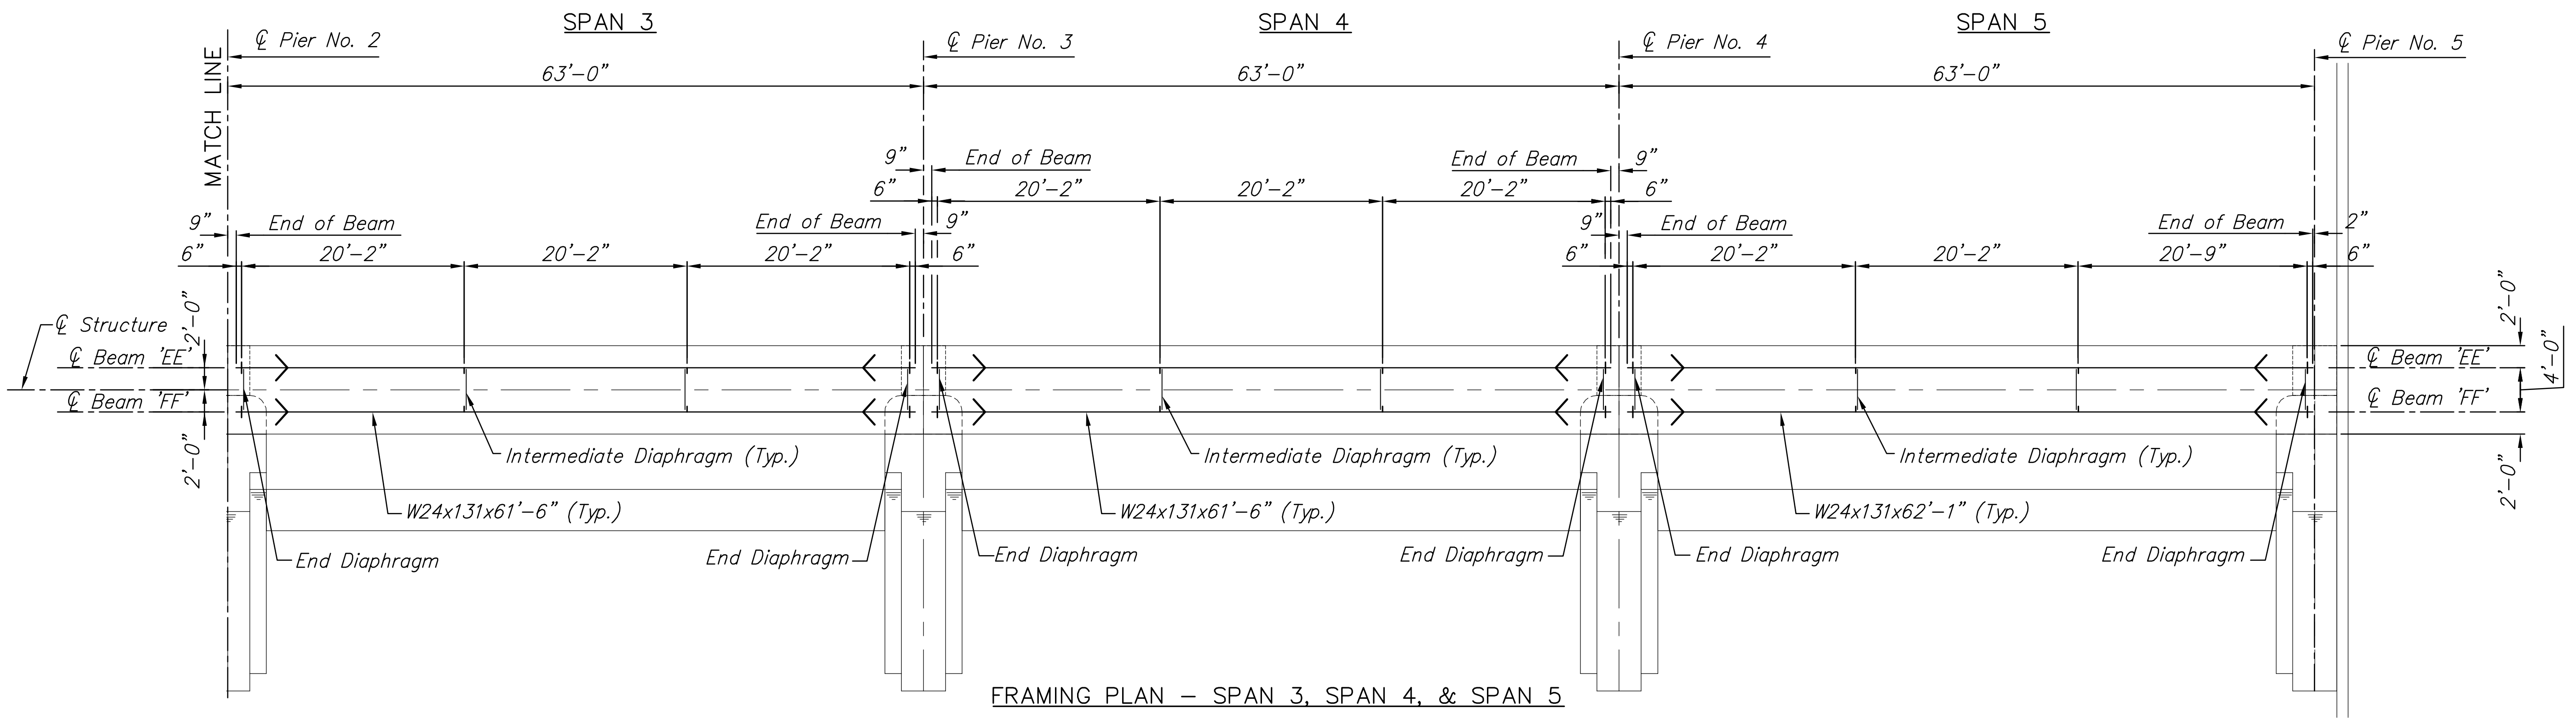

FRAMING PLAN - SPAN 3, SPAN 4, & SPAN 5

**LINCOLN STREET BRIDGE AND  
DAM IMPROVEMENTS OVER  
ARKANSAS RIVER**

**MAINTENANCE  
STRUCTURE  
FRAMING  
PLAN**  
SHEET TITLE  
472-84883  
PROJECT NUMBER

DESIGN BY: JAG  
DRAWN BY: DPG  
CHECKED BY: KJS

ISSUED: 1/24/2011  
REVISED:

SHEET NO.  
**97 of 169**

PLOTTED: Tuesday, January 25, 2011 8:42 AM

J:\CIVIL\07433\DWG\DA\PLANS\07433 MAINT BR FRAME PLAN.DWG