
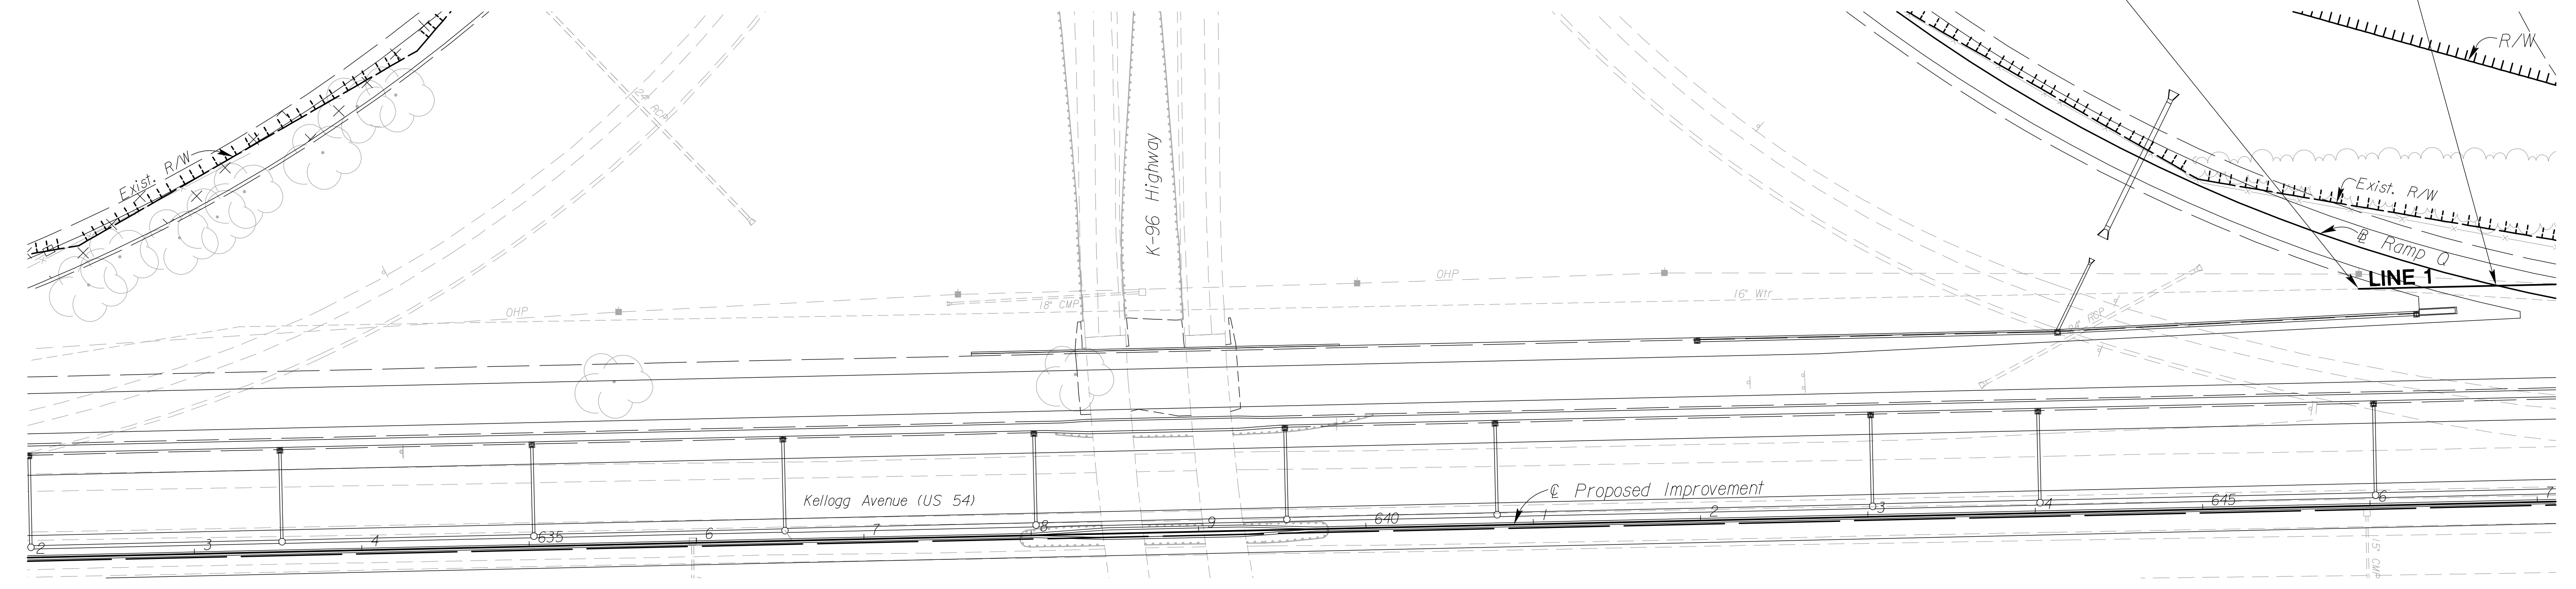


STATE	PROJECT NO.	YEAR	SHEET NO.	TOTAL SHEETS
KANSAS	472 84614	.	140	534


Sta. 10+00 Line 1 =
 Sta. 645+95.97 129.63' Lt.
 Connect To Exist. 16" Pipe
 1-16" Anchor Valve Assy.
 (MJ Butterfly Valve) Valve Box El.=
 1-DIMJ 16" Plug (E) To Abandon Exist. 16" (E)

Install 104.03' of 16" Pipe

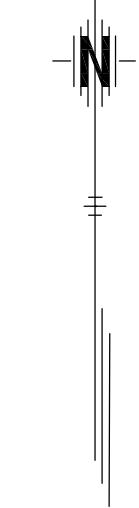

PLAN - LINE 1
 SCALE: 1" = 50'
 PROFILE - LINE 1
 HORIZ: 1" = 50'
 VERTICAL: 1" = 5'

See Sh. No's. 102-130 for SWS Plans.
 See Sh. No's. 136-139 for San. Sewer Plans.

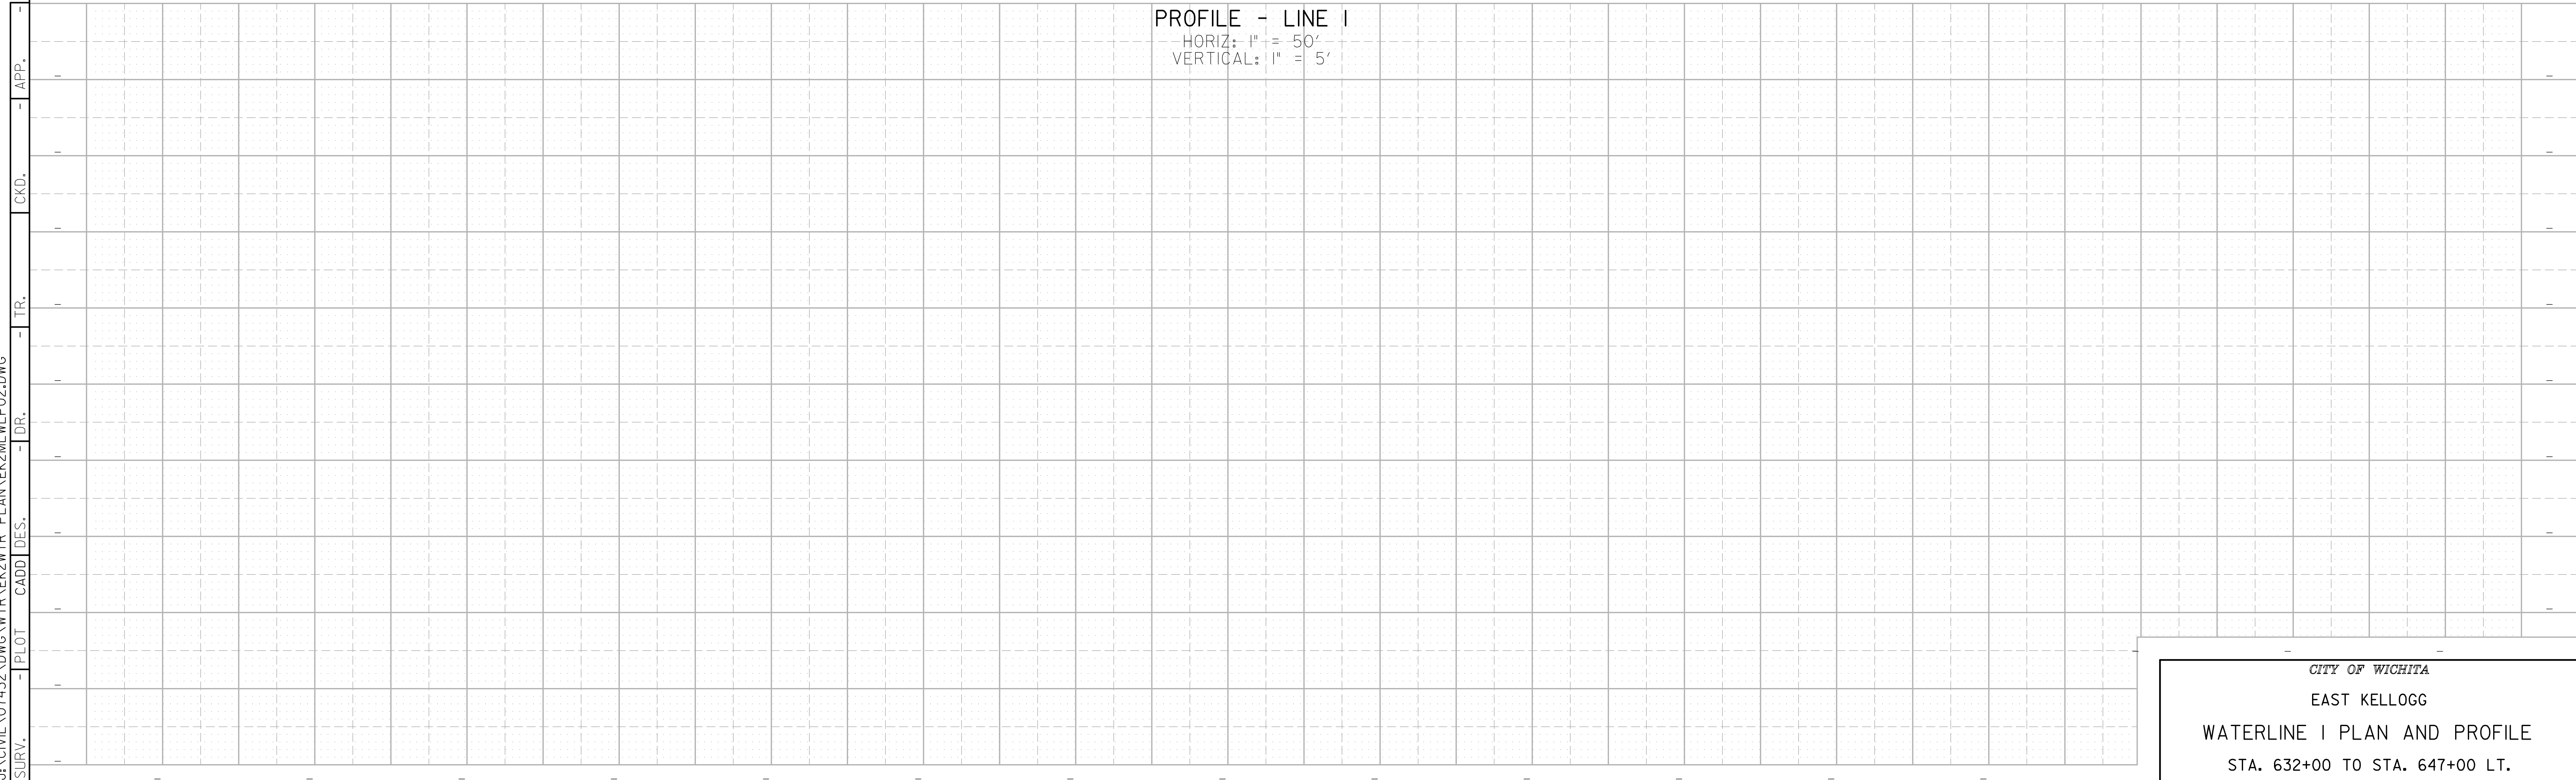

CITY OF WICHITA
 EAST KELLOGG
 WATERLINE 1 PLAN AND PROFILE
 STA. 632+00 TO STA. 647+00 LT.

2:46 PM
 2/18/2011
 J:\CIVIL\07432\DWG\WTR\K2WTR_PLAN\K2ML\LP02.DWG
 SURV. - PLOT CADD DES. - DR. - TR. - CKD. - APP.