

SWS210 (Begin Construction)
Sta. 20+00.00, SWS Line 2
Connect to Proposed Inlet
by 205 PPP (607879)
Install 183.1 LF 30" SWS (E)
30" E.in(E)=1408.50
36" E.out(W)=1407.09


SWS220
Sta. 21+83.09, SWS Line 2
Sta. 0+00.00, SWS Line 2A
Install Type D Manhole (4'-0" Dia.)
Top Elev.=1415.51
Install 66.0 LF 24" SWS (N)
Install 198.0 LF 30" SWS (S)
30" E.in(W)=1409.25
24" E.in(N)=1410.00
30" E.in(S)=1410.00 (SWS Line 2A)
See Sheet No. 11

SWS240
Sta. 22+49.09, SWS Line 2
Install Drop Inlet
(L=4'-0", W=2'-0")
Top Elev.=1414.60
Install 126.9 LF 18" SWS (N)
18" E.in(N)=1411.60
24" E.out(S)=1410.60
See Sheet No. 13

SWS250
Sta. 23+75.96, SWS Line 2
Install Std. Type 1 Curb Inlet (5'-0")
(W=4'-0")
Top Elev.=1418.33
Install 335.8 LF 15" SWS (W)
15" E.in(E)=1414.99
18" E.out(S)=1414.74
See Sheet No. 14

Existing SSMH and Pipe
to be Removed and Capped
at Property Line

SWS Line 2A
See Sheet No. 6

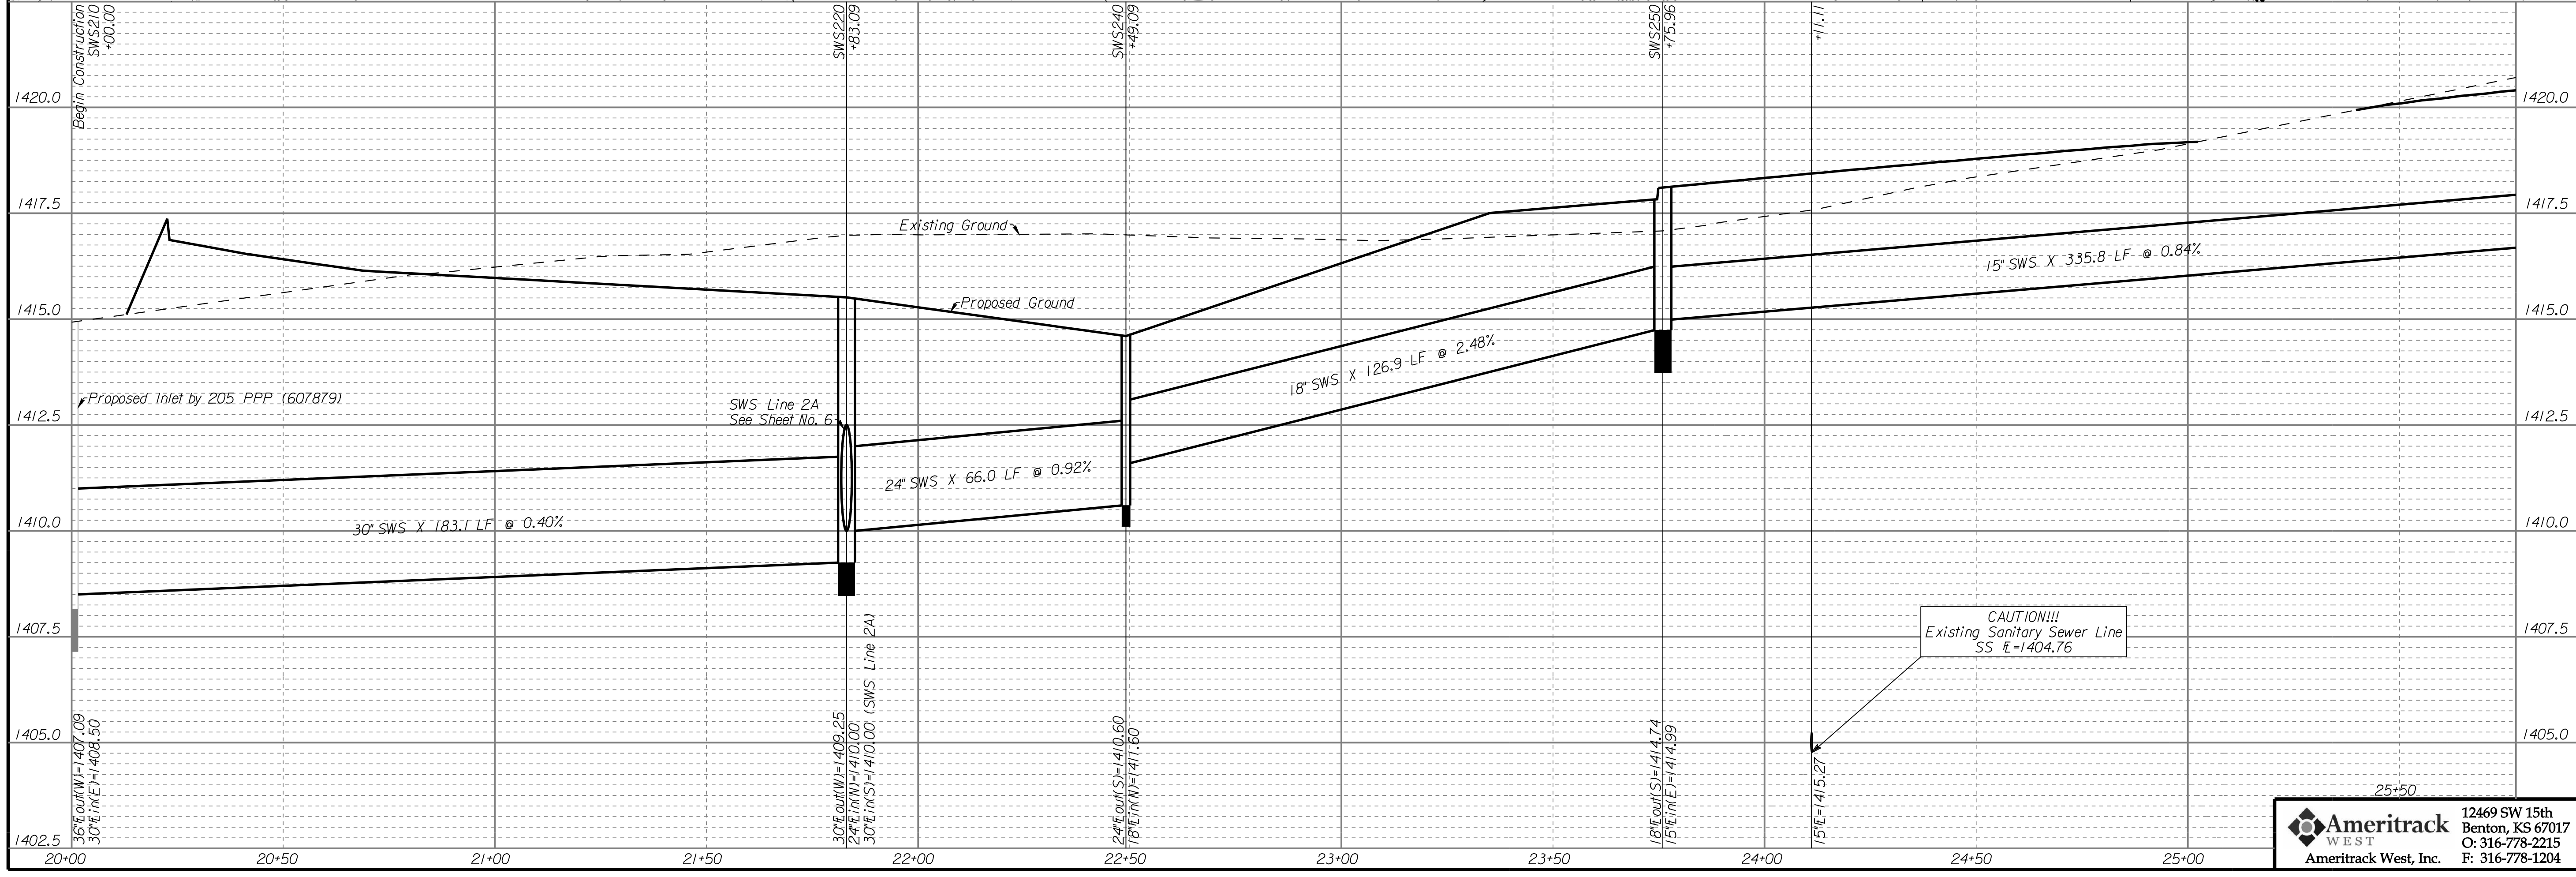

CAUTION!!!
Existing Sanitary Sewer Line
SS E=1404.76

Ameritrack WEST
12469 SW 15th
Benton, KS 67017
O: 316-778-2215
F: 316-778-1204

FIREPOINT ADDITION SWS LINE 2 PLAN AND PROFILE WICHITA, KANSAS JAMES ARMOUR, P.E. - CITY ENGINEER Project No. 2042 PPS - OCA No. 607861				
No.	Date	By	Approved	Revision
POE & ASSOCIATES OF KANSAS, INC. CONSULTING ENGINEERS 8940 E. Central, Suite 200a Wichita, KS 67208-4242 Phone 316/695-4114 • FAX 316/695-4444				
FINAL				
Designed By:	BLB			
Drawn By:	JGF			
Drawing:	463_PPS4_SWS_Line 2_P.P.dgn			
Date:	April 27, 2010			
Sheet	4 of 23			