
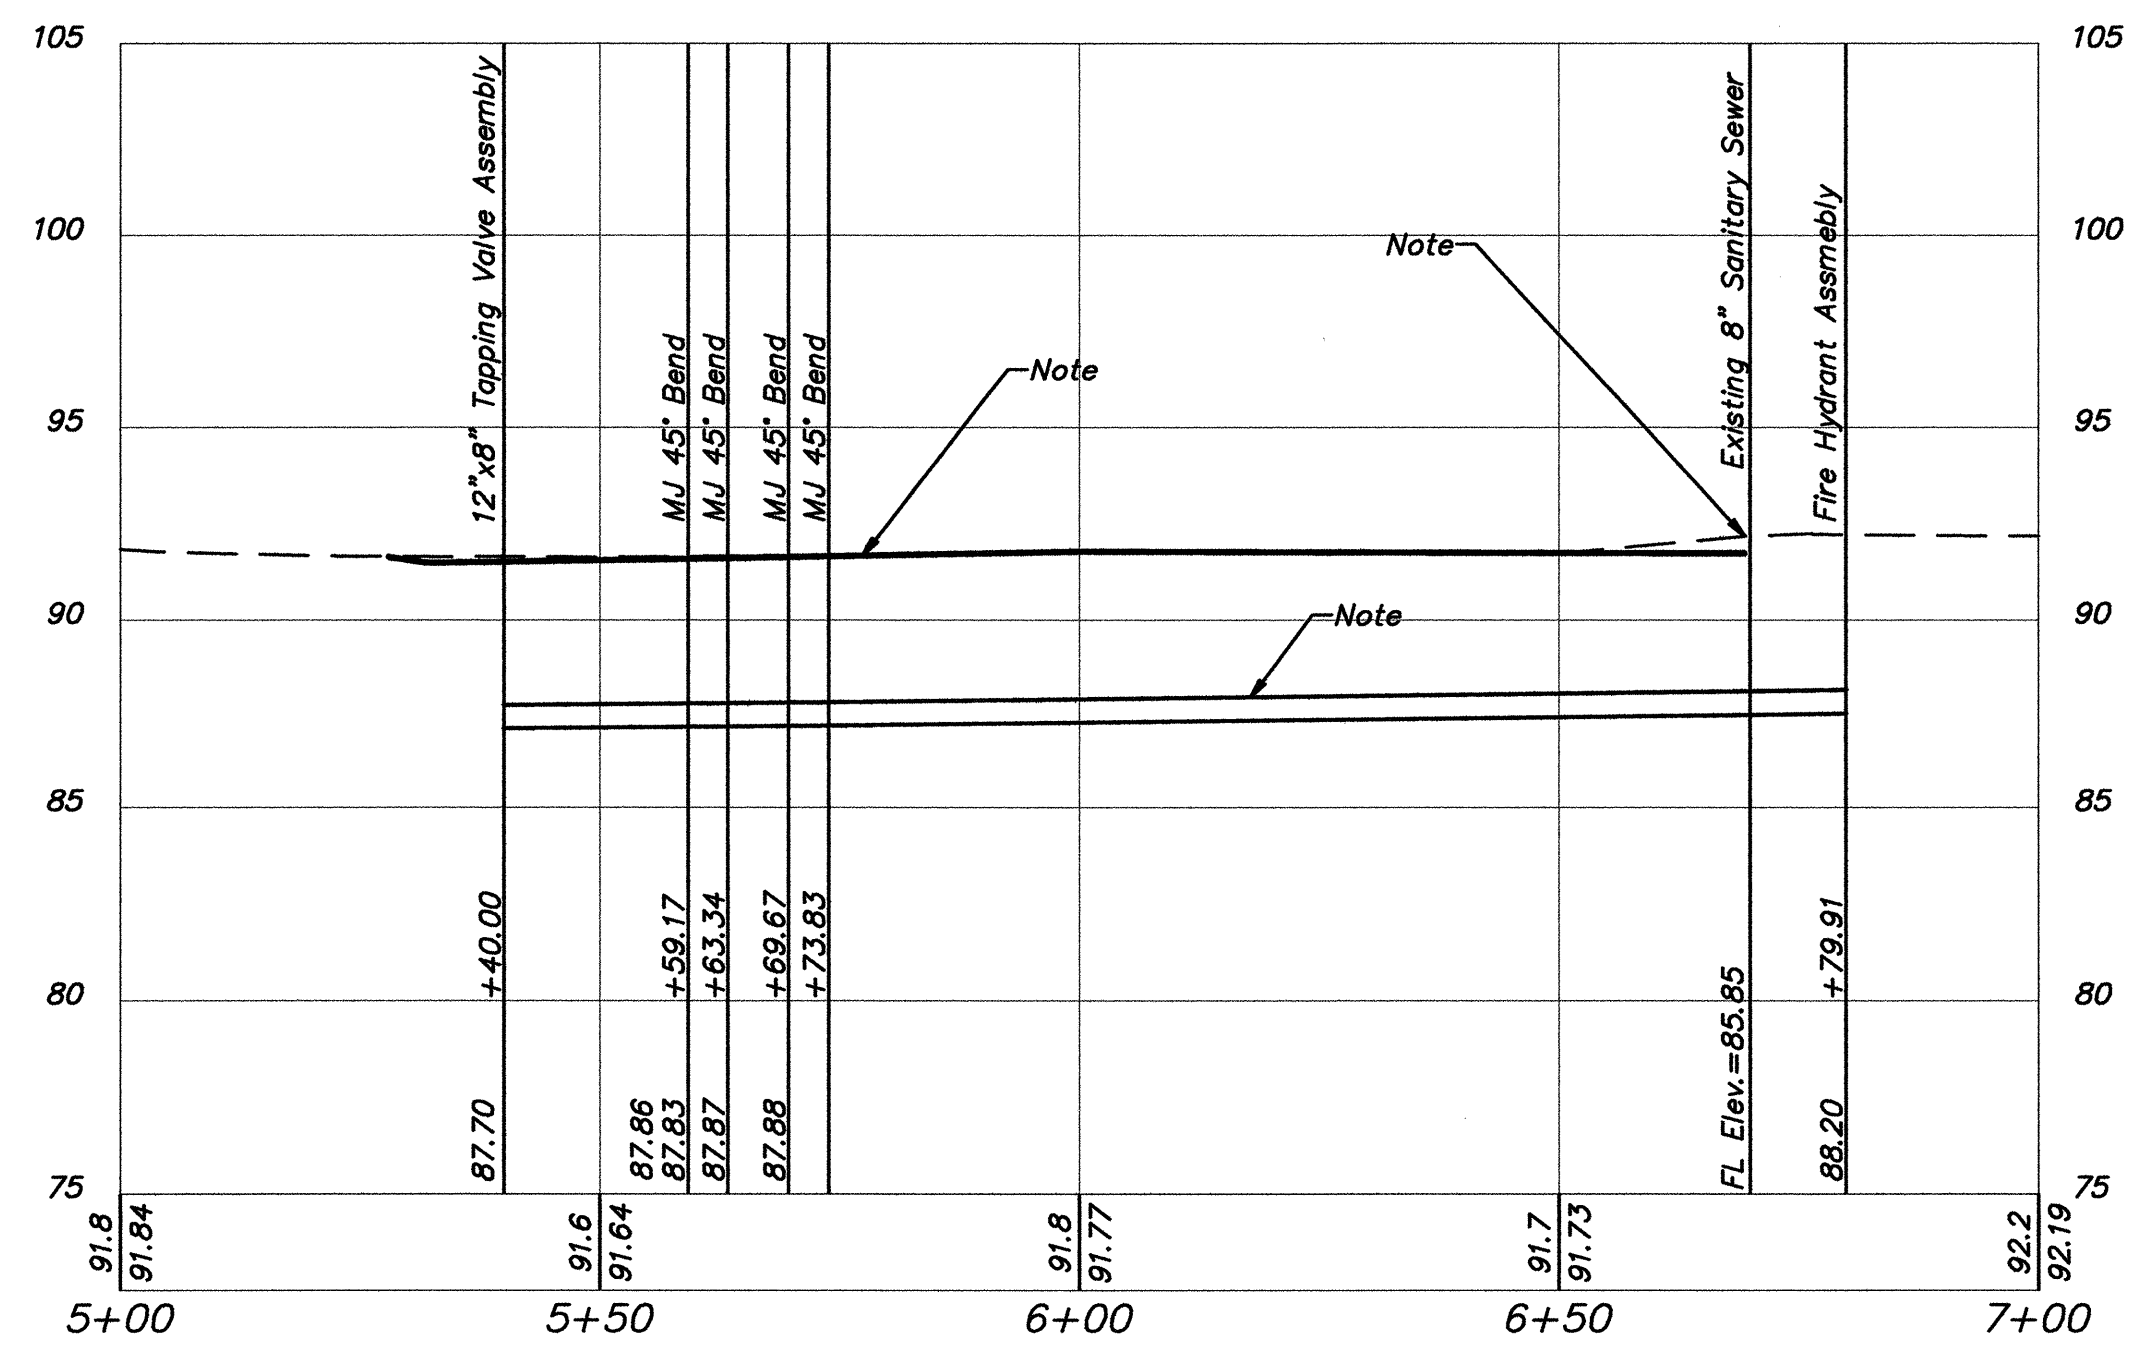


STATE	PROJECT NO.	YEAR	SHEET NO.	TOTAL SHEETS
KANSAS	87 N-0243-01	2005	167	169

Federal Aid No. STP N024(301)

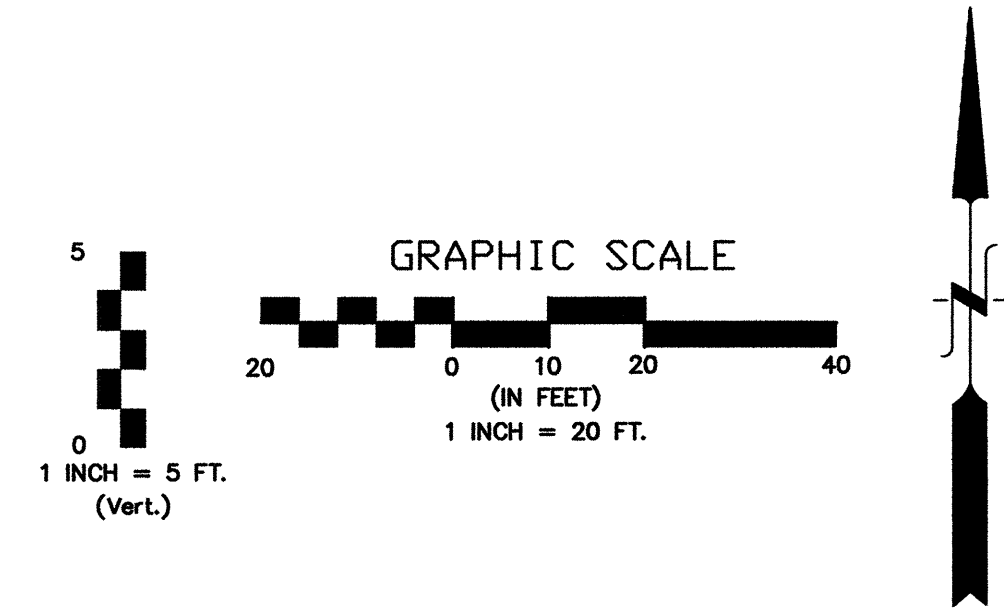

SENECA STREET  
1-235 TO 31ST STREET  
CITY OF WICHITA, KANSAS  
WATERLINE PLAN AND PROFILE

POE & ASSOCIATES, INC.  
CONSULTING ENGINEERS  
5940 E. Central, Suite 200 Wichita, KS  
67208-4242  
Phone 316/685-4114 FAX 316/685-4444

**FINAL**

Engineer: P. FERGUSON  
Designer: J. UNRUH  
KDOT Job No.: 87 N-0243-01 Proc Job No.: 1794  
Date: JANUARY 2010

Sheet 167 of 169