



project no.
11279.00
The drawing and all information here-
in is the exclusive property of Howard
& Helmer Architects P.A., and is not to
be copied or used in any way without
the express written consent of Howard
& Helmer Architects P.A. All drawings,
specifications, ideas, designs and ar-
rangements appearing herein constitute
the original and unaltered work of
the Architect.
Copyright © 2012
Howard & Helmer
Architects P.A.

BOMBARDIER FLIGHT TEST CENTER
BUILDING B15
ONE LEARJET WAY
WICHITA, KANSAS

sheet

C-7.1

WATER DISTRIBUTION SYSTEM IMPROVEMENTS

TO SERVE BOMBARDIER LEARJET BUILDING #15 ADDITION


PRIVATE PROJECT NO. 1656 PPW (607853)

CITY OF WICHITA, KANSAS

JAMES L. ARMOUR, P.E. - CITY ENGINEER

INDEX OF SHEETS

SHEET NO. C-7.1	PPW TITLE SHEET
SHEET NO. C-7.2	PPW KEY MAP AND GENERAL NOTES
SHEET NO. C-7.3	STANDARD WATERLINE DETAILS
SHEET NO. C-7.4	MISCELLANEOUS DETAILS
SHEET NO. C-7.5	FIRE SERVICE PLAN/PROFILE
SHEET NO. C-8.1	EROSION CONTROL PLANS
SHEET NO. C-8.2 THRU C-8.4	SOIL EROSION BMP DETAILS

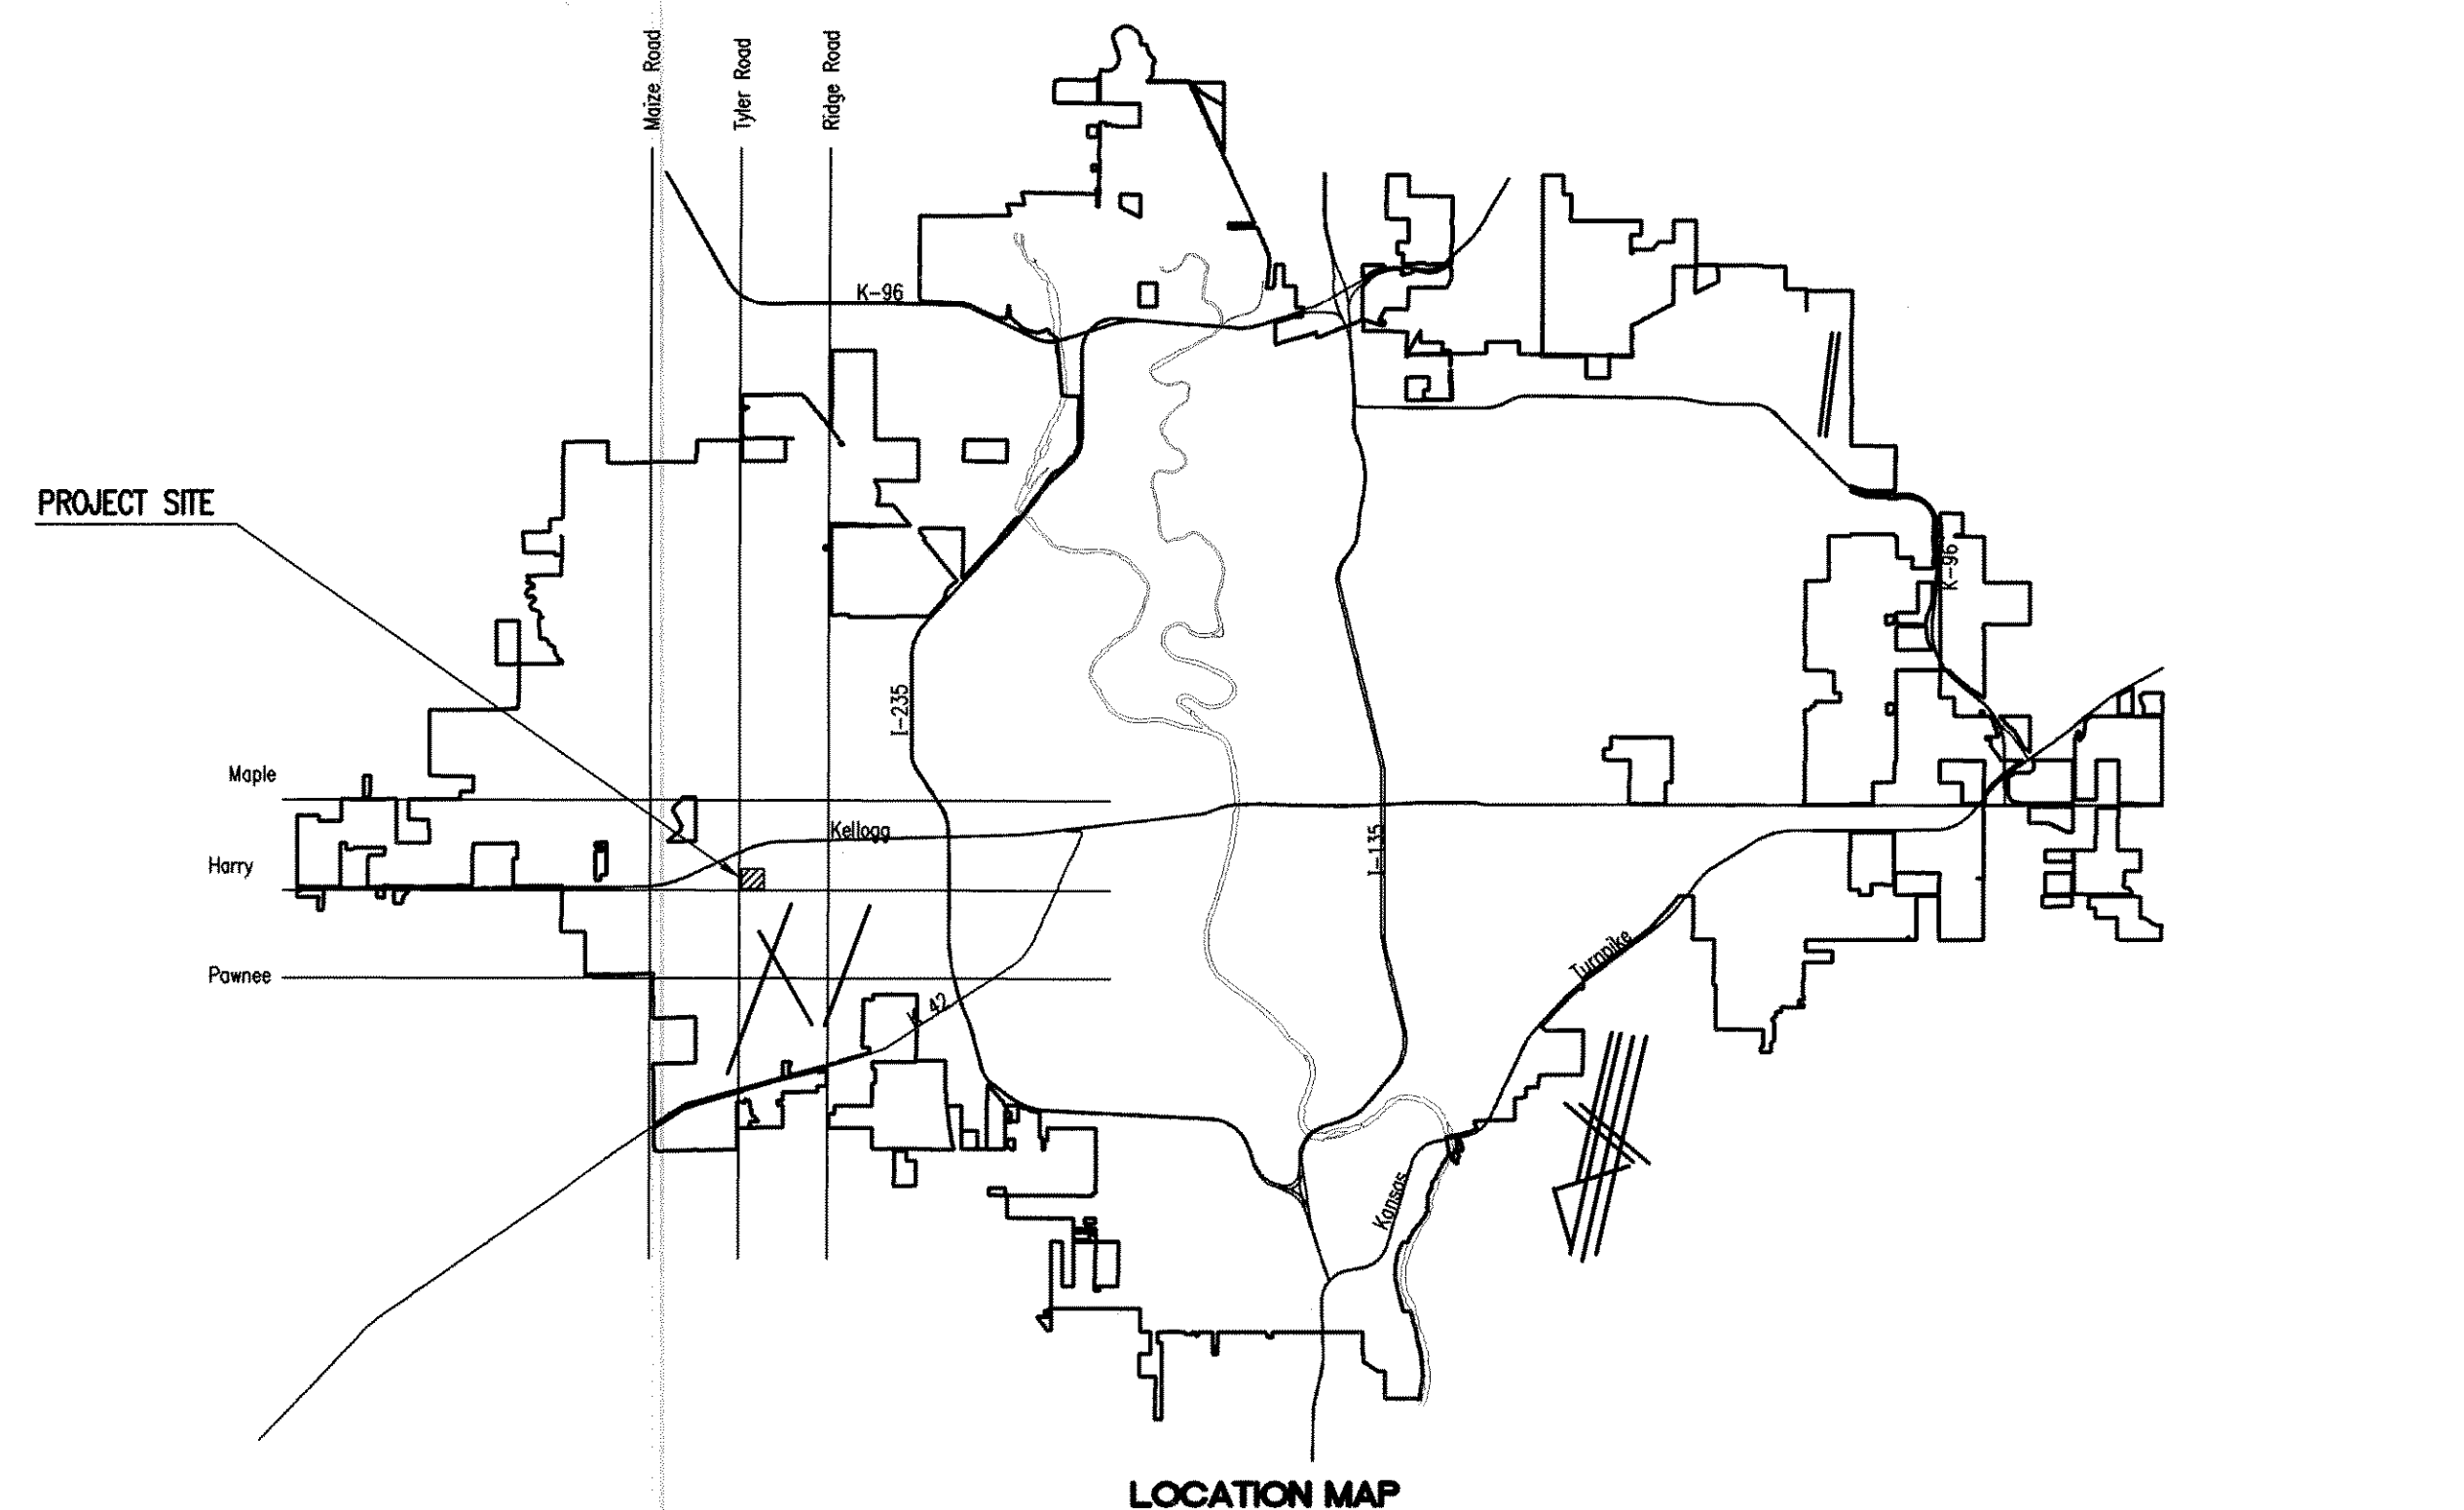

AS BUILTS	
Contractor: Fire Protection Services 8/7/2012	Project Inspector: Tom Jones kemiller engineering 516 S. Market, Wichita, KS 67202 (316)264-0242

APPROVED AS NOTED
BY CITY ENGINEER OF WICHITA
& BY WICHITA FIRE DEPARTMENT

Water Mains (Engineering) *Julianne Kallman 4-5-12*

Water Mains (Water) *Greg Tuller 4-4-12*

Fire Prot. Line *[Signature]*

NOTE TO CONTRACTORS

PUBLIC PROPERTY:
Inspection and testing for the waterline is to be provided by a Licensed Consulting Engineering Firm under contract with the Owner/Developer. Said inspection to be in accordance with the City of Wichita standard construction engineering practices and certified by a Licensed Professional Engineer licensed in the State of Kansas. No work shall be performed in dedicated easements or public right-of-way by the Contractor without such inspection nor shall any work be commenced without written authorization by the City Engineer. All Construction and Materials shall comply with the City of Wichita Specifications and Standards (on file and available in the City Engineer's Office).

PRIVATE PROPERTY:
Installation and testing for the fire protection line is to be performed by a City of Wichita licensed fire protection contractor in accordance with the fire codes as adopted by the City of Wichita. All materials and construction practices for the fire protection line shall comply with the fire codes as adopted by the City of Wichita (available from the City of Wichita Fire Department). The Contractor shall not commence work without notification and approval of the Wichita Fire Department.
Inspection of the fire protection line is to be provided by the City of Wichita Fire Department and by a licensed Consulting Engineering Firm under contract with the Owner/Developer.
The contractor shall not start work until the project inspector is assigned to the project and present on the site. Any work done without inspection will be required to be uncovered for inspection.

APRIL 2012
PLANS PREPARED BY
PROFESSIONAL ENGINEERING CONSULTANTS, P.A.
ENGINEERS
WICHITA, KANSAS

Saved 04-04-2012 10:17:52 AM by JLN
Plot Scale 1:1 04-04-2012 10:37:28 AM by JOSEPH A. MESTELER/DAD
C:\2011\1594\000\Site Com\1594-006-07.dwg - PPW TITLE