

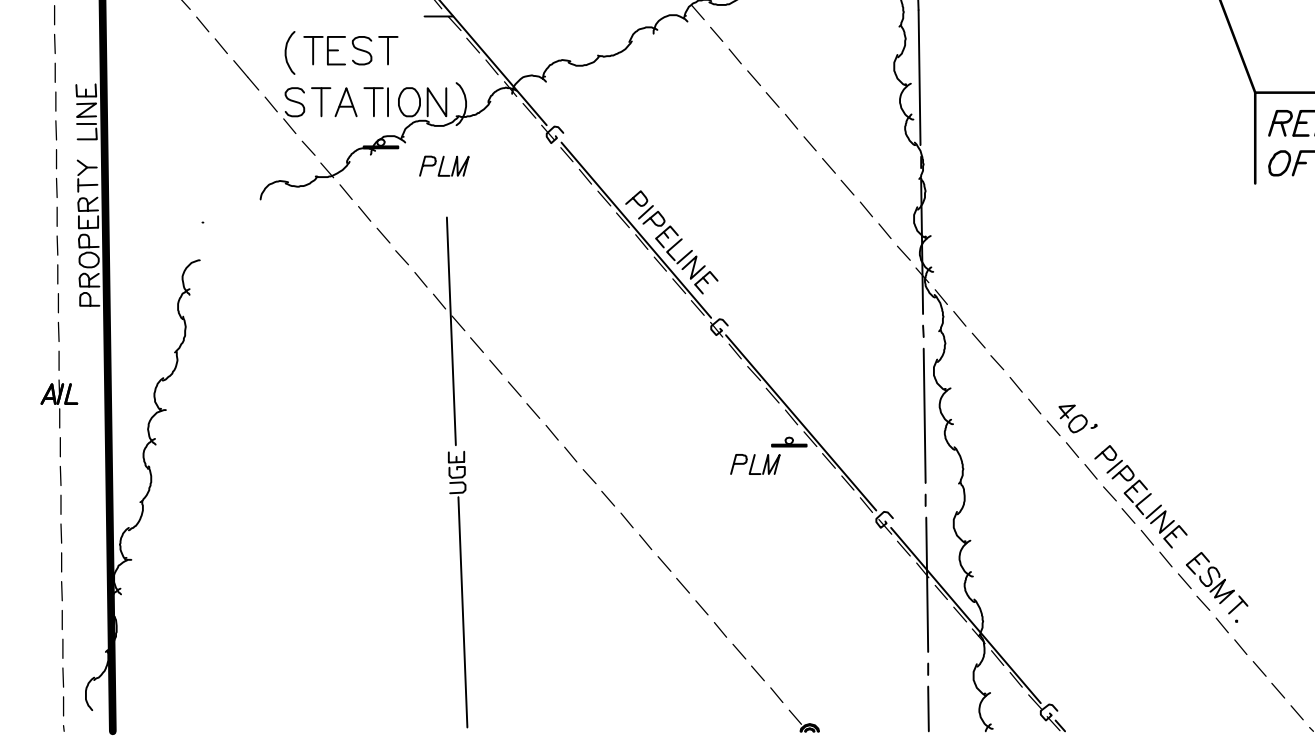
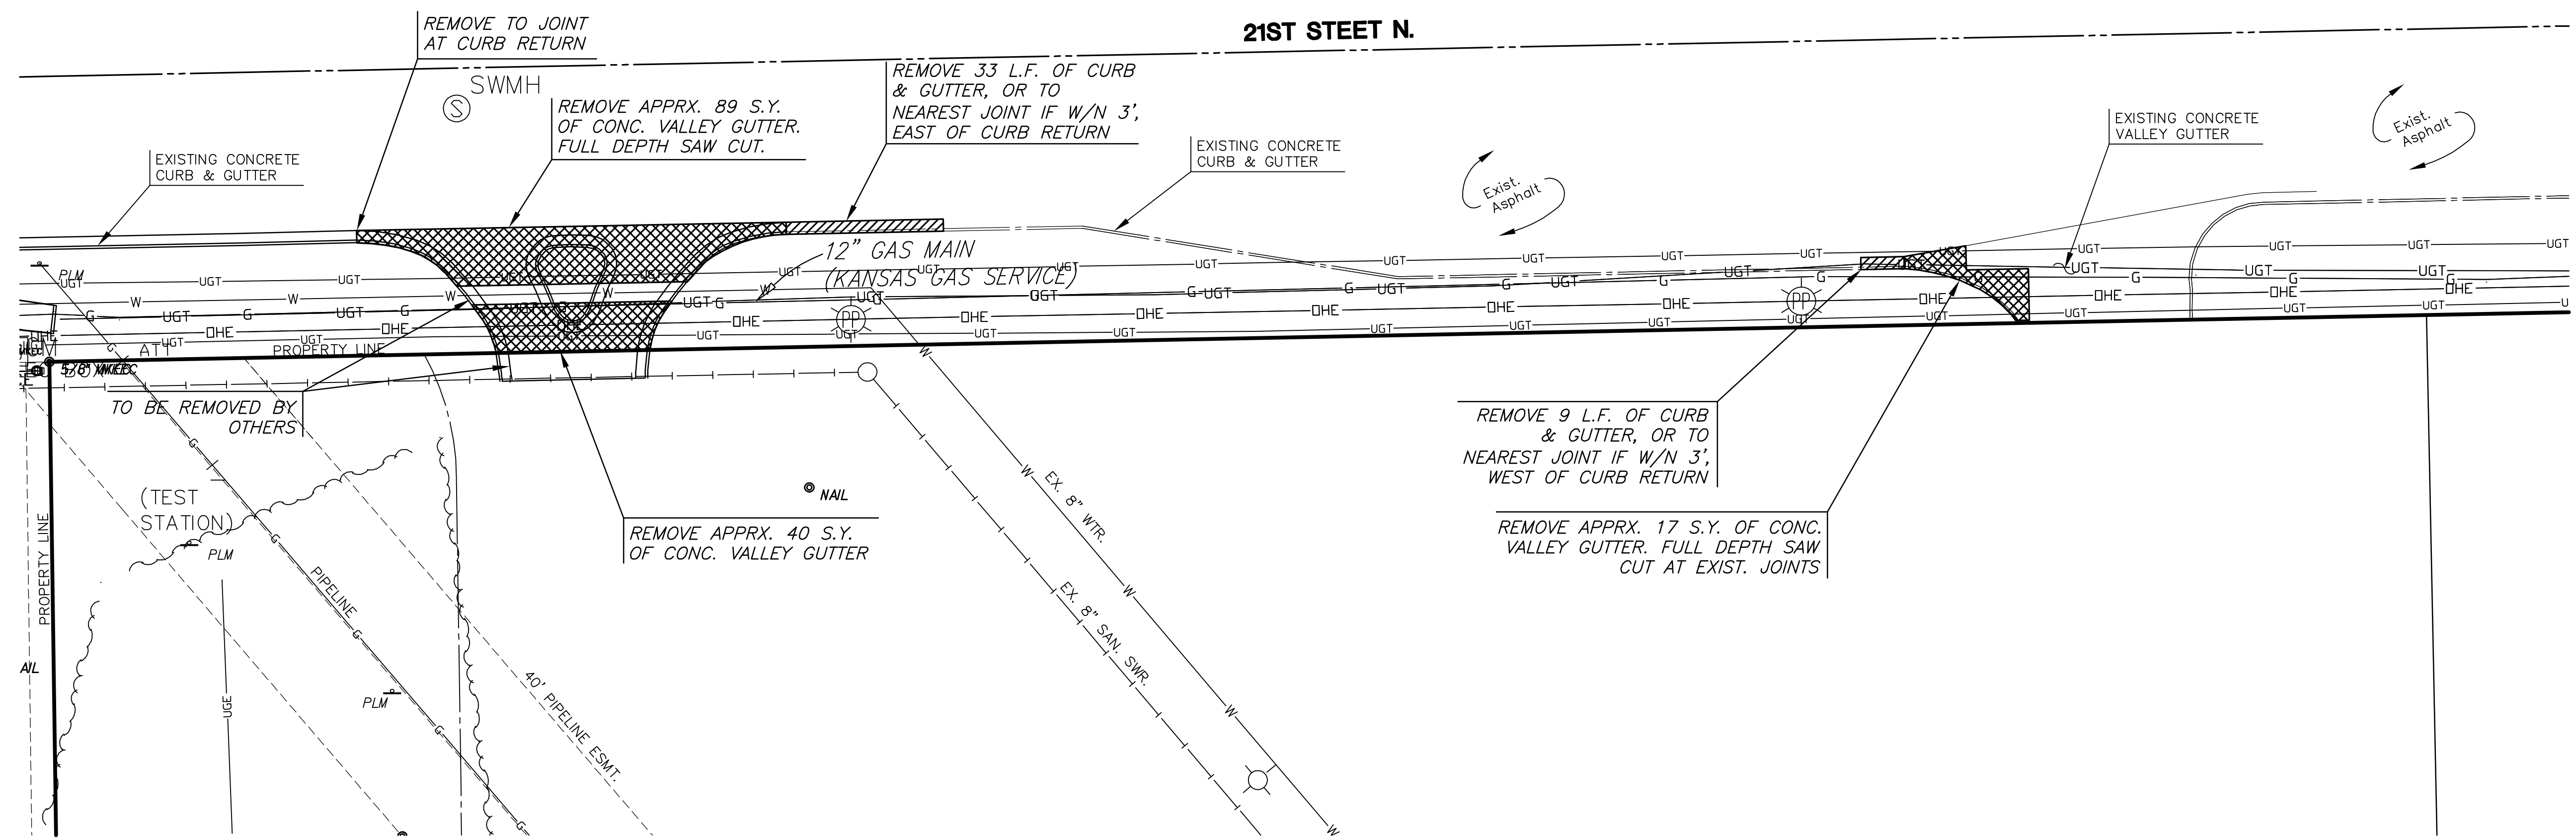


PAVING PLANS FOR
REMINGTON PLACE ADDITION
PROJECT NO. 472-85061

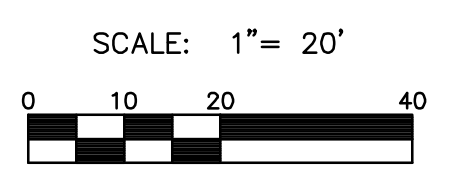

LEGEND

- | | |
|---------------------------------|--|
| ⊙ - SURVEY MONUMENT | — DHE — — — — — OVERHEAD ELECTRIC LINE |
| ★ 6IN - TREE AND DIAMETER | — S — — — — — STORM SEWER PIPE |
| ⊙ 13IN - TREE AND DIAMETER | — S — — — — — SANITARY SEWER |
| ⊙ 18" - TREE STUMP AND DIAMETER | — W — — — — — WATER LINE |
| ⊙ - POWER POLE | — G — — — — — GAS LINE |
| ⊙ - WATER METER | — UGT — — — — — UNDERGROUND TELEPHONE |
| ⊙ - GAS METER | — UGE — — — — — UNDERGROUND ELECTRIC |

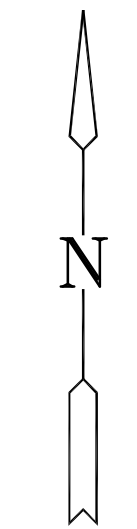

DEMOLITION PLAN

SHEET TITLE
472-85061
PROJECT NUMBER

SPE / SPE / BLB
DESIGNED / DRAWN / CHECKED

ISSUED
November 2012

REVISED