

SITE LIGHTING PLANS FOR  
**WATERFRONT EIGHTH ADDITION**


AN ADDITION TO THE CITY OF WICHITA  
 SEDGWICK COUNTY, KANSAS

PROJECT NO. 472-85097

GARY L. JANZEN, P.E. - CITY ENGINEER

OCA 766293



STONEGATE LANE: LOT 1 THROUGH 5, BLOCK 1;  
 LOT 1 THROUGH 4, BLOCK 2

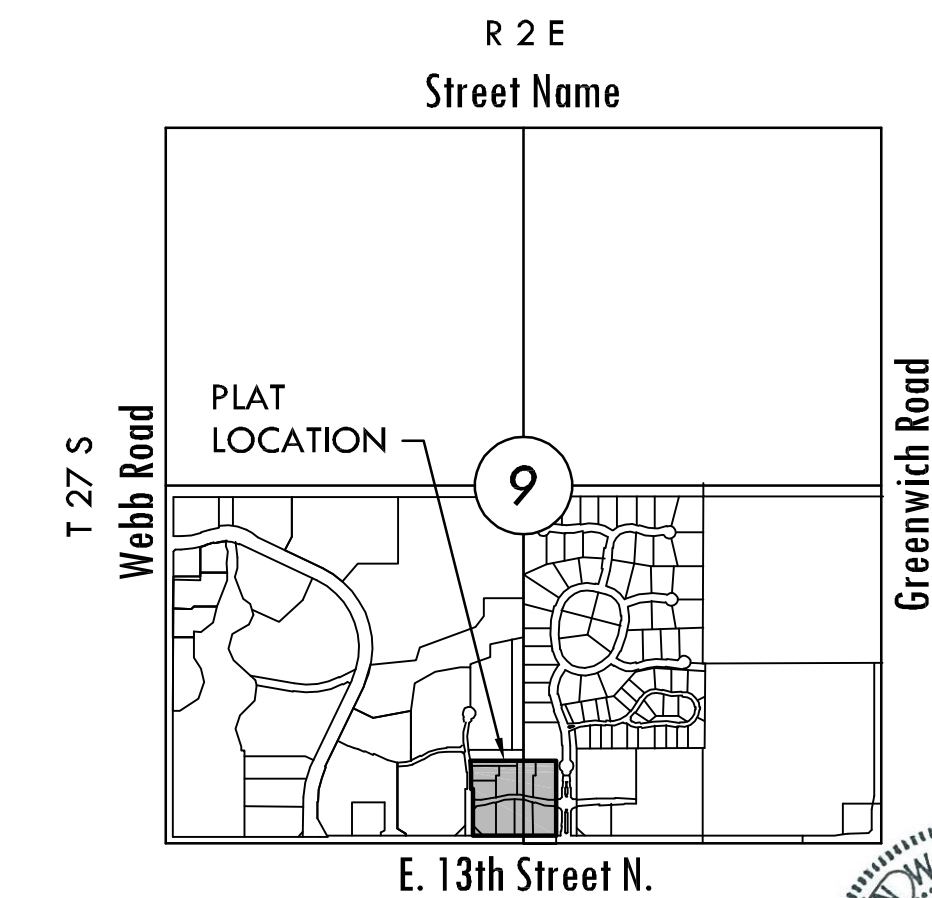

**VICINITY MAP**  
 No Scale



**MKEC**  
 ENGINEERING  
 CONSULTANTS, INC.  
 411 NORTH WEBB ROAD  
 WICHITA, KS 67206  
 PHONE: 316.684.9600  
 FAX: 316.616.0841  
 WWW.MKEC.COM

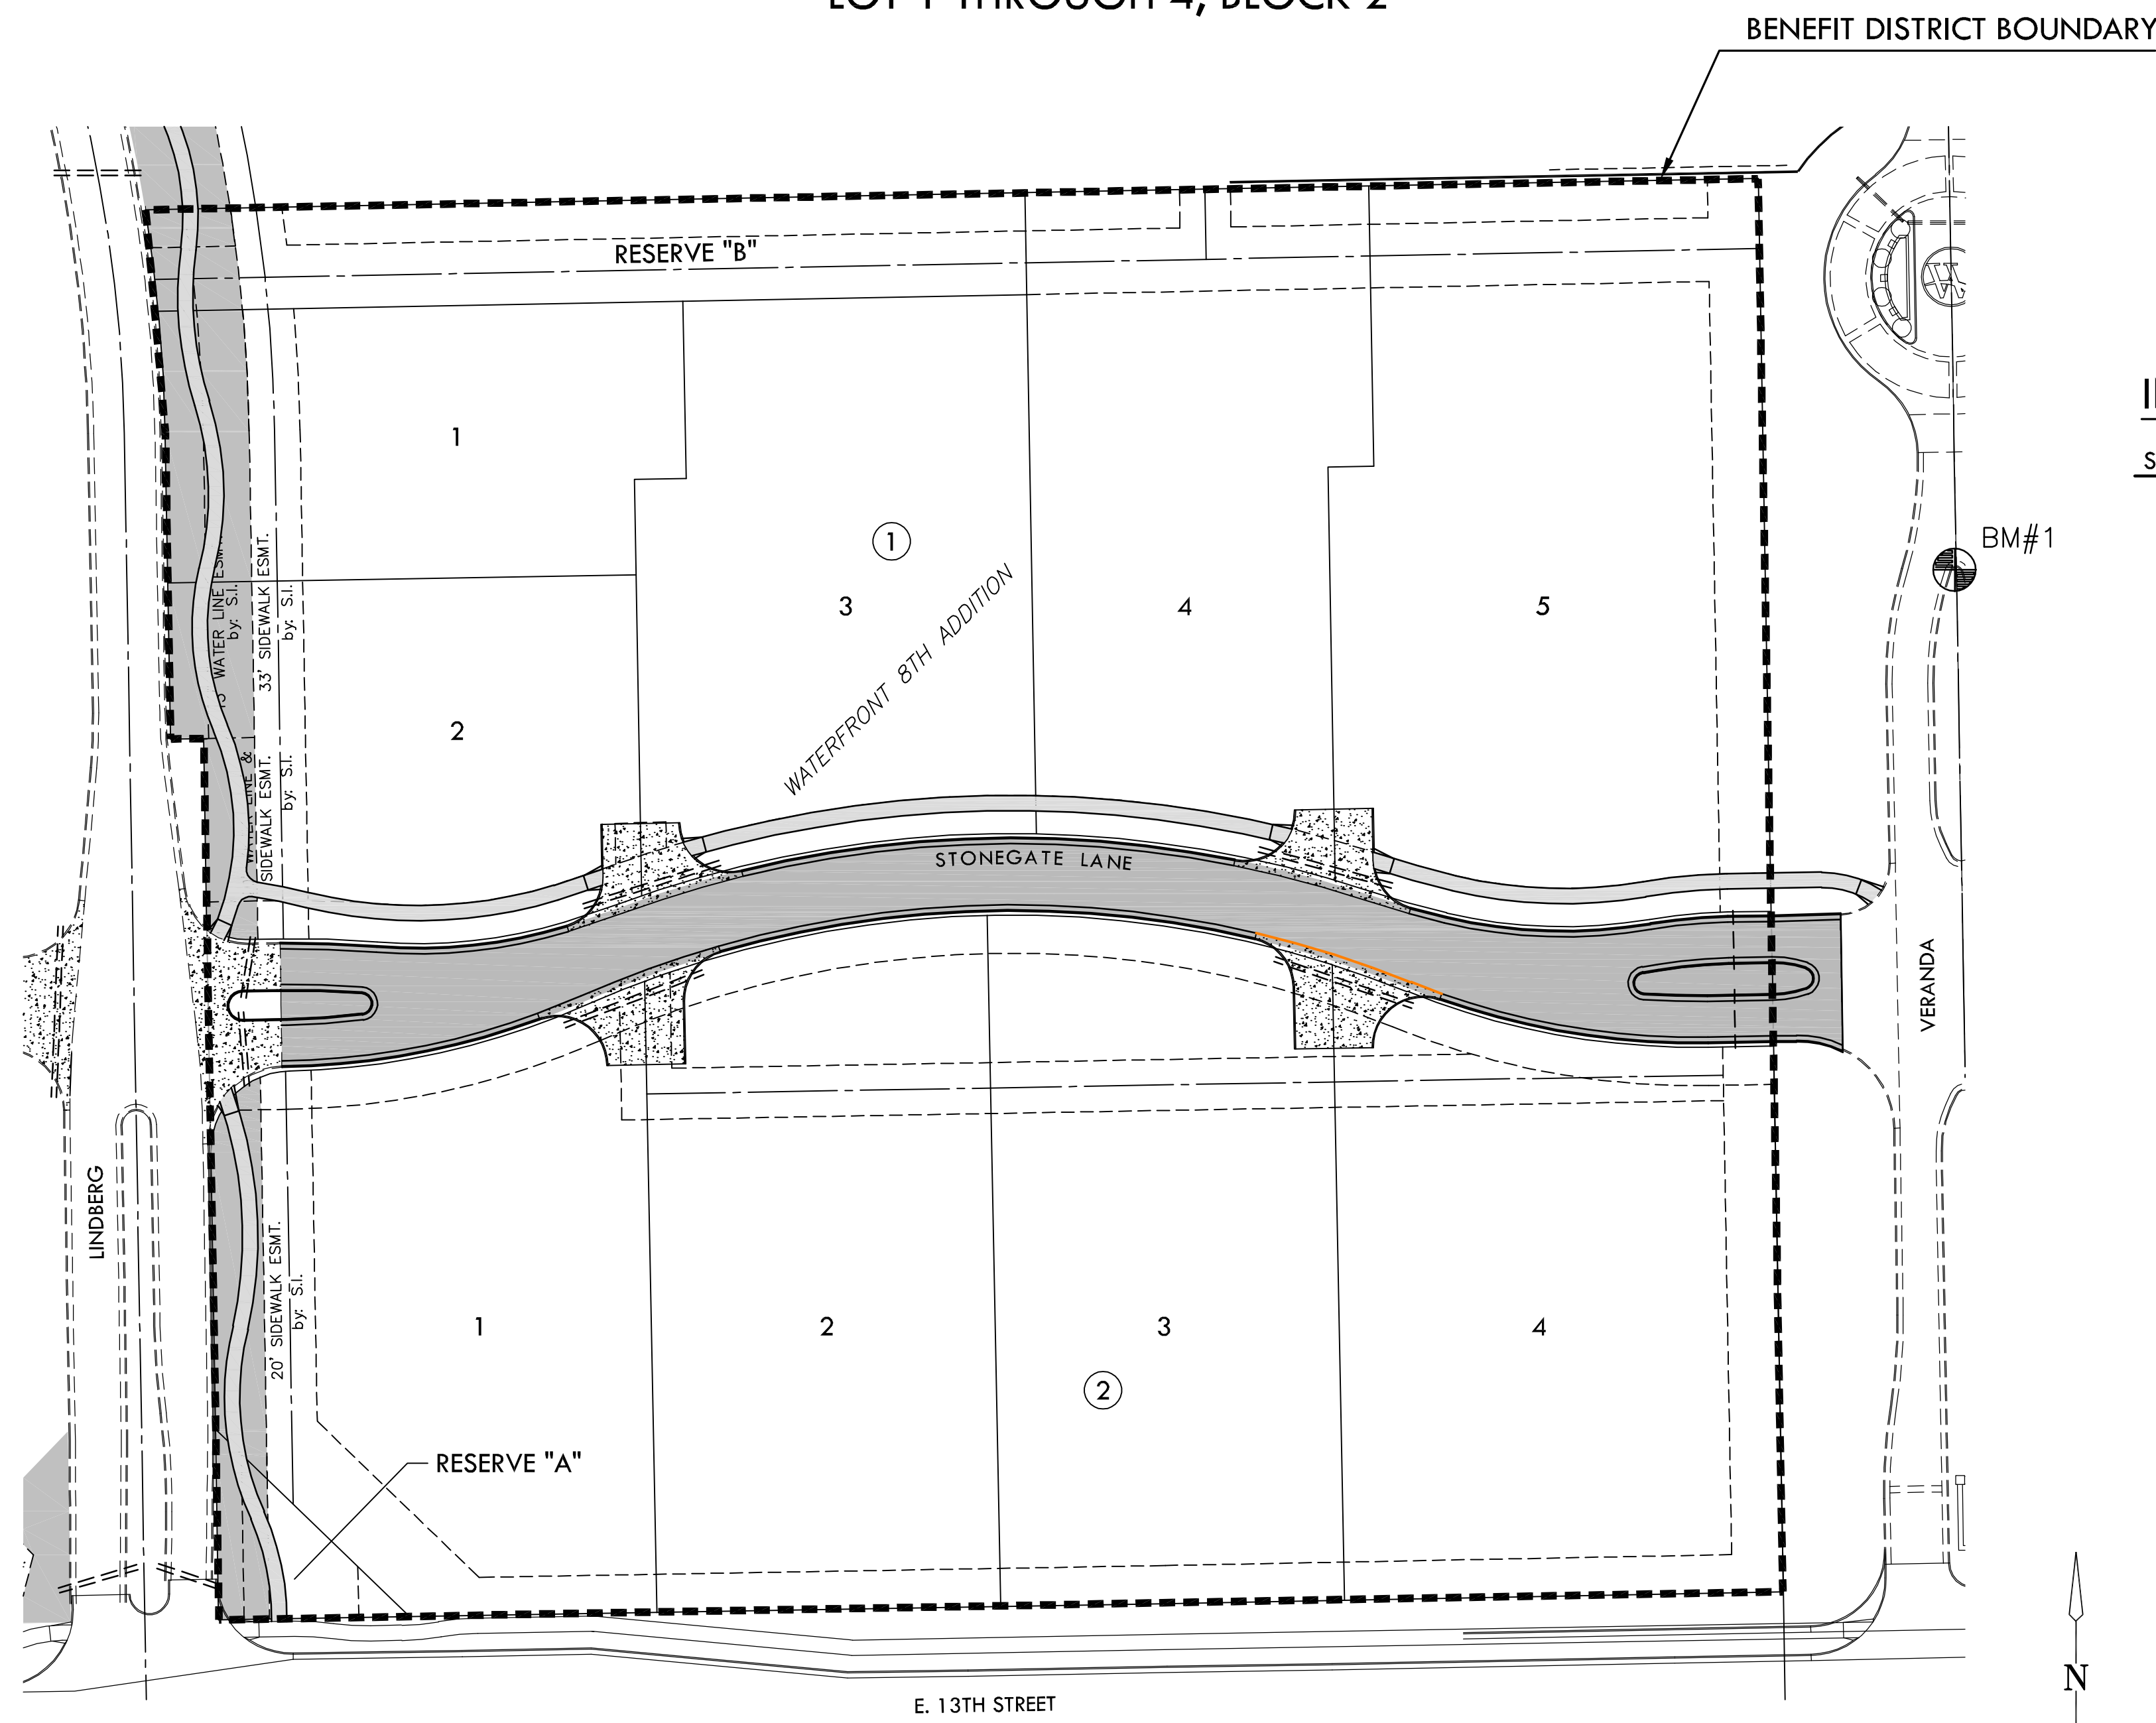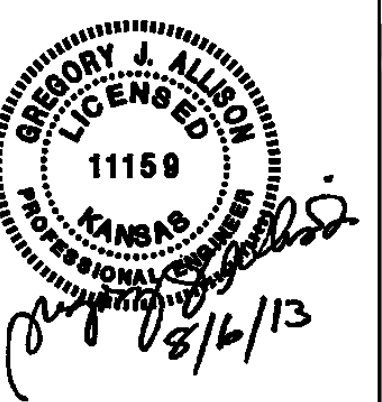


**INDEX TO DRAWINGS**

SHEET NO.	DESCRIPTION
1	TITLE SHEET
2	ELECTRICAL GENERAL NOTES
3	ELECTRICAL SITE PLAN
4	ELECTRICAL SCHEDULES AND SPECIFICATIONS
5	ELECTRICAL DETAILS
6	BUBBLE MAP
7-11	BMP SHEETS
12	FINAL PLAT

**BENCHMARKS**

- BM#1 CHISELED SQUARE NORTH CURB OF ISLAND ON VERANDA, 460' NORTH OF 13TH STREET NORTH. ELEV.=1387.03 NAVD 88
- BM#2 SQUARE CUT ON SW. CORNER OF SIGNAL LIGHT POLE BASE AT NE CORNER OF WEBB RD. AND 13TH ST. ELEV.=1373.345 (NGVD 29)

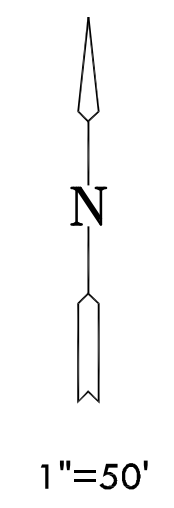

**ELECTRICAL SITE LIGHTING PLANS FOR**  
**WATERFRONT EIGHTH ADDITION**  
**PART B**

**TITLE SHEET**  
 SHEET TITLE  
 472-85097  
 PROJECT NUMBER

DFL / JWC /  
 DESIGNED / DRAWN / CHECKED

ISSUED  
 August 2013  
 REVISED

SHEET NO.  
 1 of 12