



NOTE: INSTALL ALL POLE BASES 6'-0" FROM BACK OF CURB.
 NOTE: LEVELING NUTS SHALL BE USED.
 POLE BEARING PLATE SHALL NOT BE SHIMMED AGAINST PIER CONCRETE.


1 POLE BASE DETAIL
NO SCALE

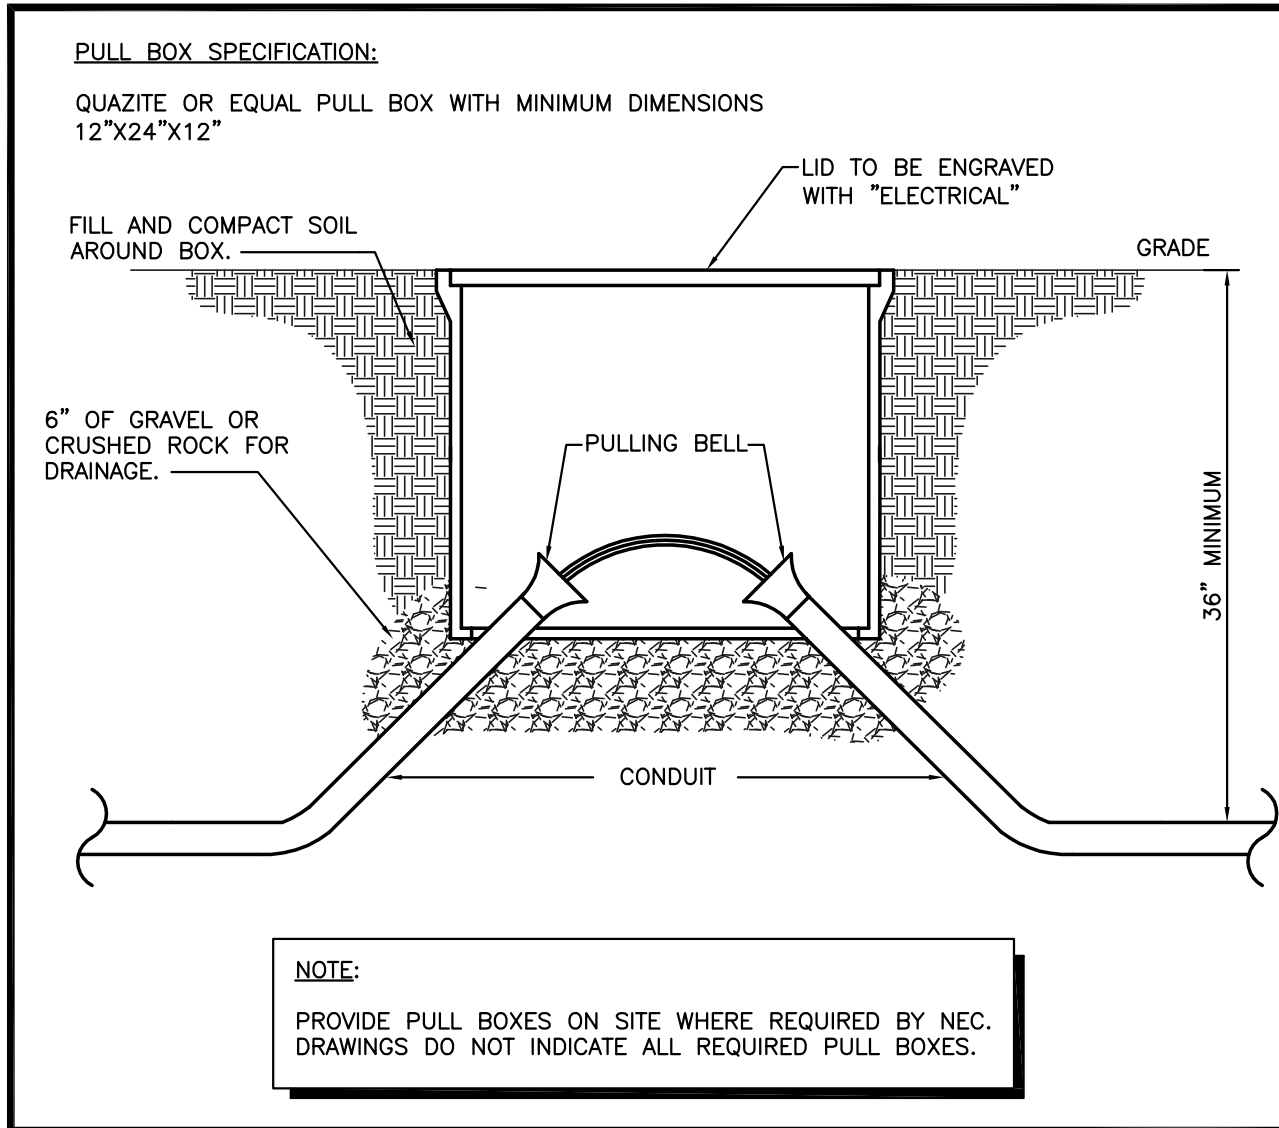

2 PULL BOX DETAIL
NO SCALE

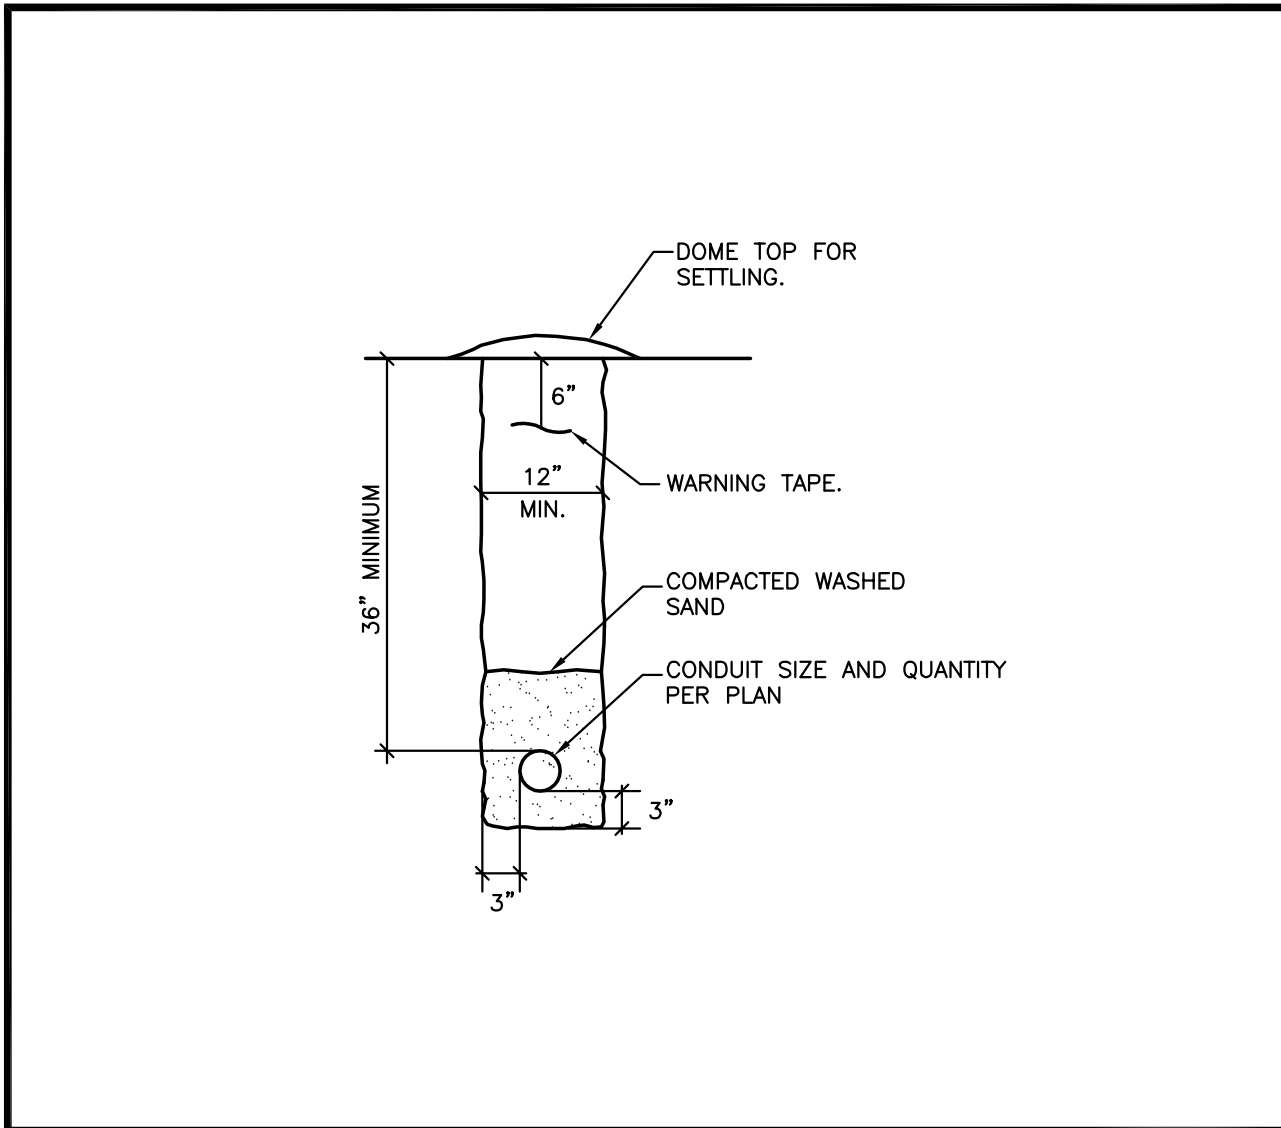


3 TYPICAL TRENCH TRENCH CROSS SECTION
NO SCALE

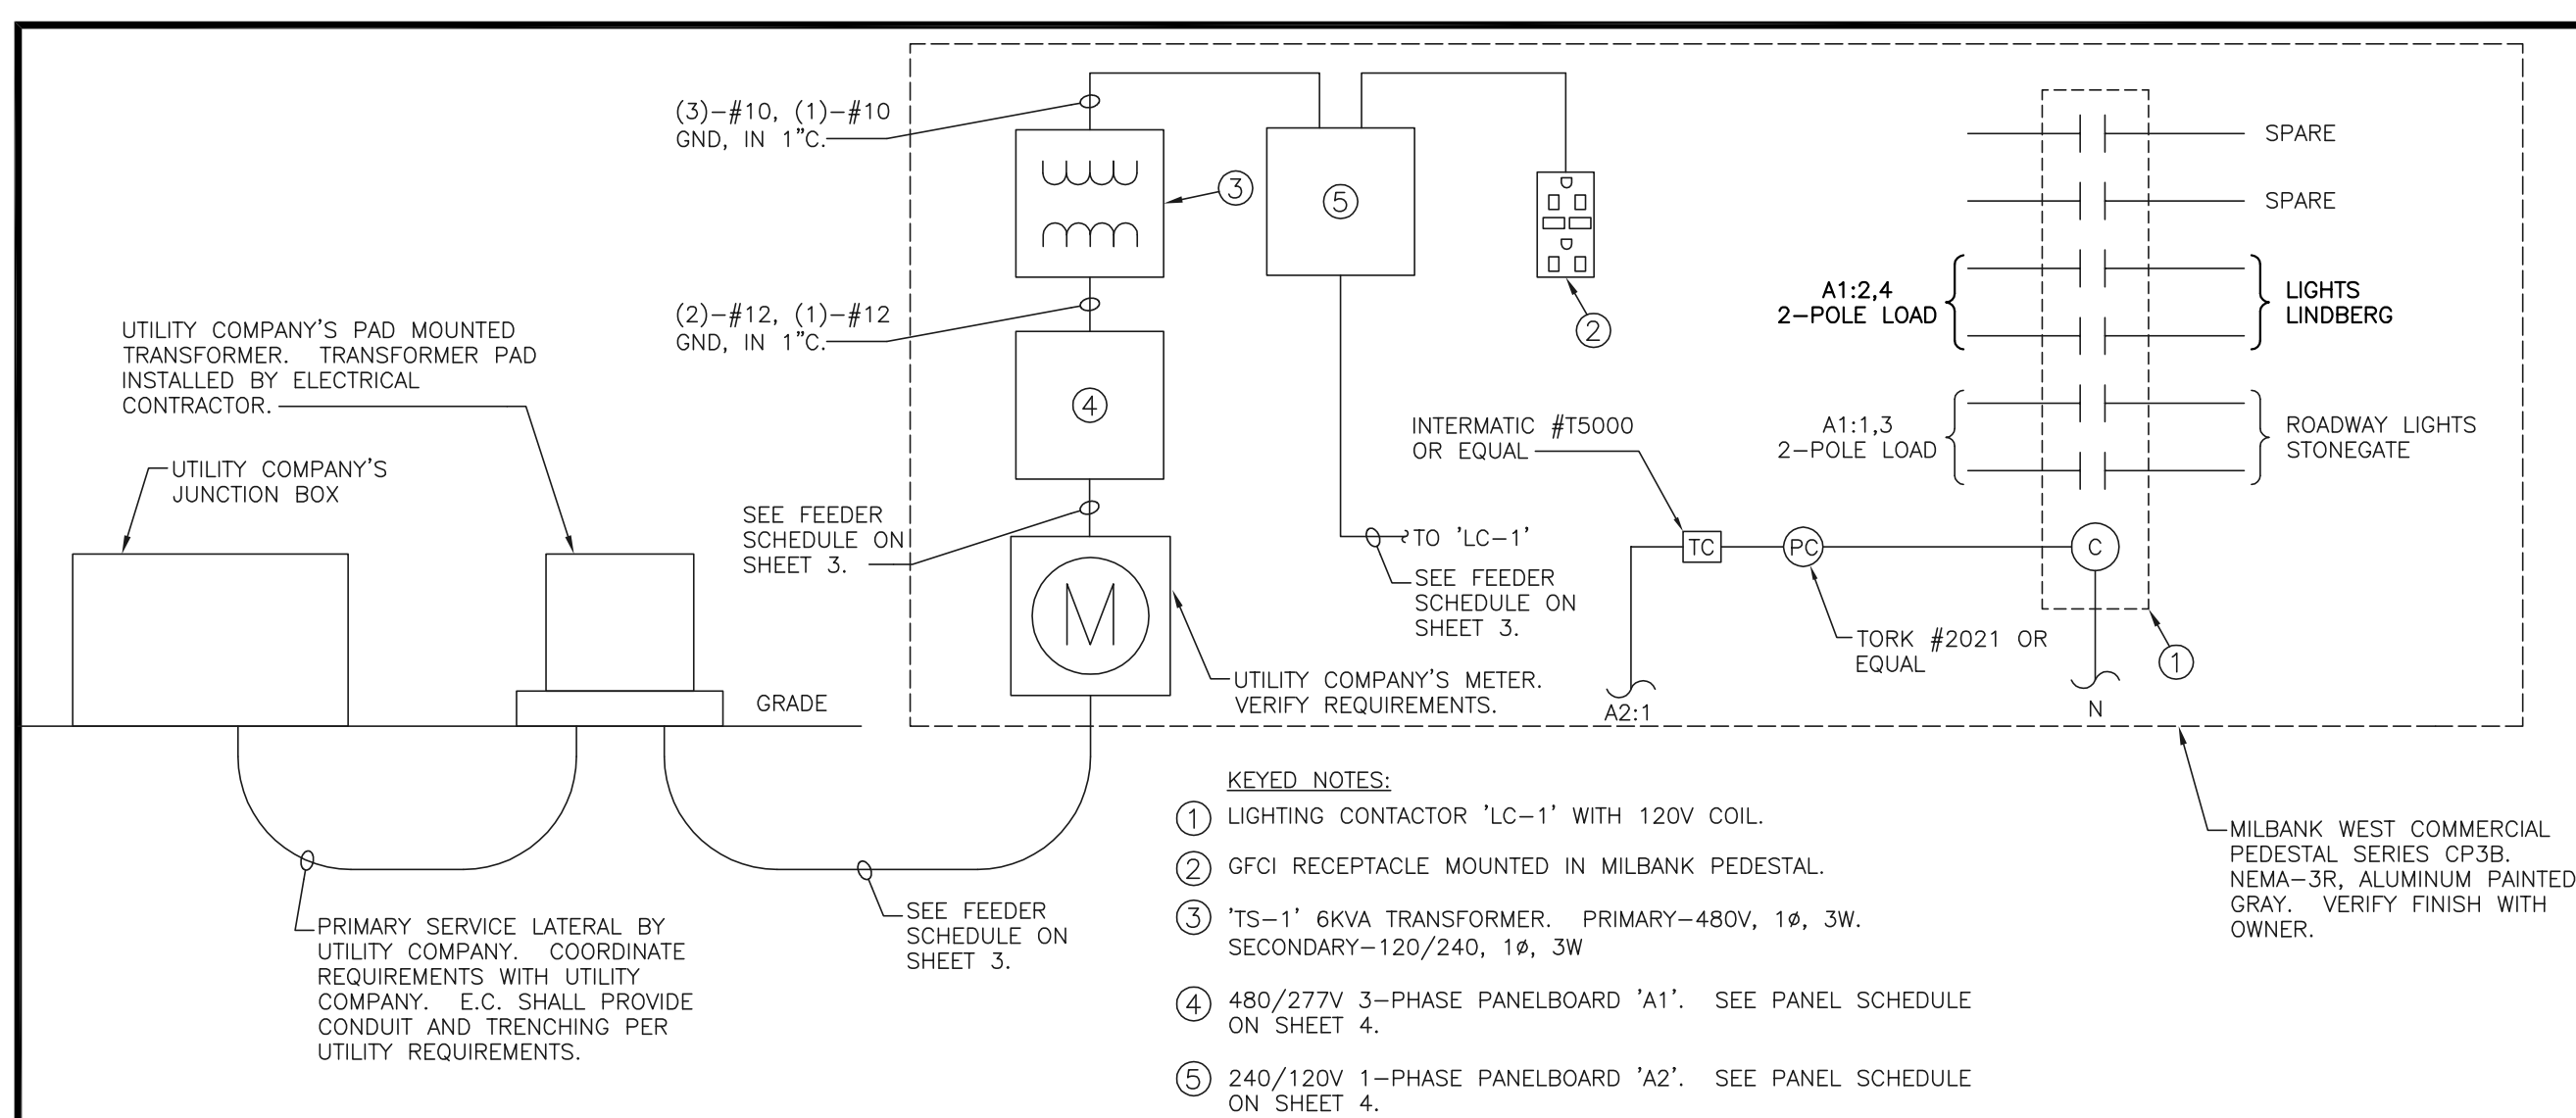

4 WIRING DIAGRAM FOR EXISTING ELECTRICAL PEDESTAL 'A'
NO SCALE

MKEC
ENGINEERING
CONSULTANTS, INC.
411 NORTH WEBB ROAD
WICHITA, KS 67206
PHONE: 316.684.9600
FAX: 316.616.0841
WWW.MKEC.COM

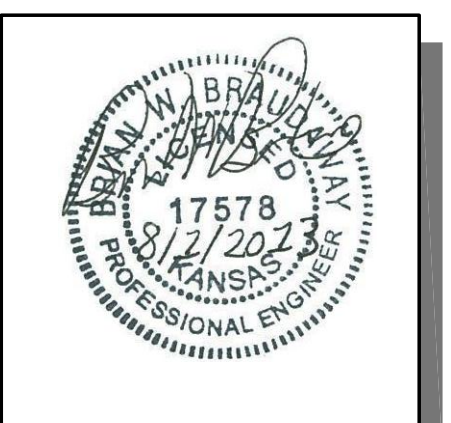

ELECTRICAL SITE LIGHTING PLANS FOR WATERFRONT EIGHTH ADDITION PART B

ELECTRICAL DETAILS
SHEET TITLE
472-85097
PROJECT NUMBER

CNG / JSR / BWB
DESIGNED DRAWN CHECKED

ISSUED
August 2013
REVISED

SHEET NO.
5 of 12