

# CONSTRUCTION PLANS FOR WATER DISTRIBUTION SYSTEM IMPROVEMENTS

CITY OF WICHITA PROJECT NO. 448-90558

OCA #(735475)

TO SERVE



## SOUTHFORK COMMERCIAL ADDITION

## THE CITY OF WICHITA, KANSAS

SEDGWICK COUNTY, KANSAS


GARY JANZEN, P.E. CITY ENGINEER

No.	Date	By	Approved	Revision

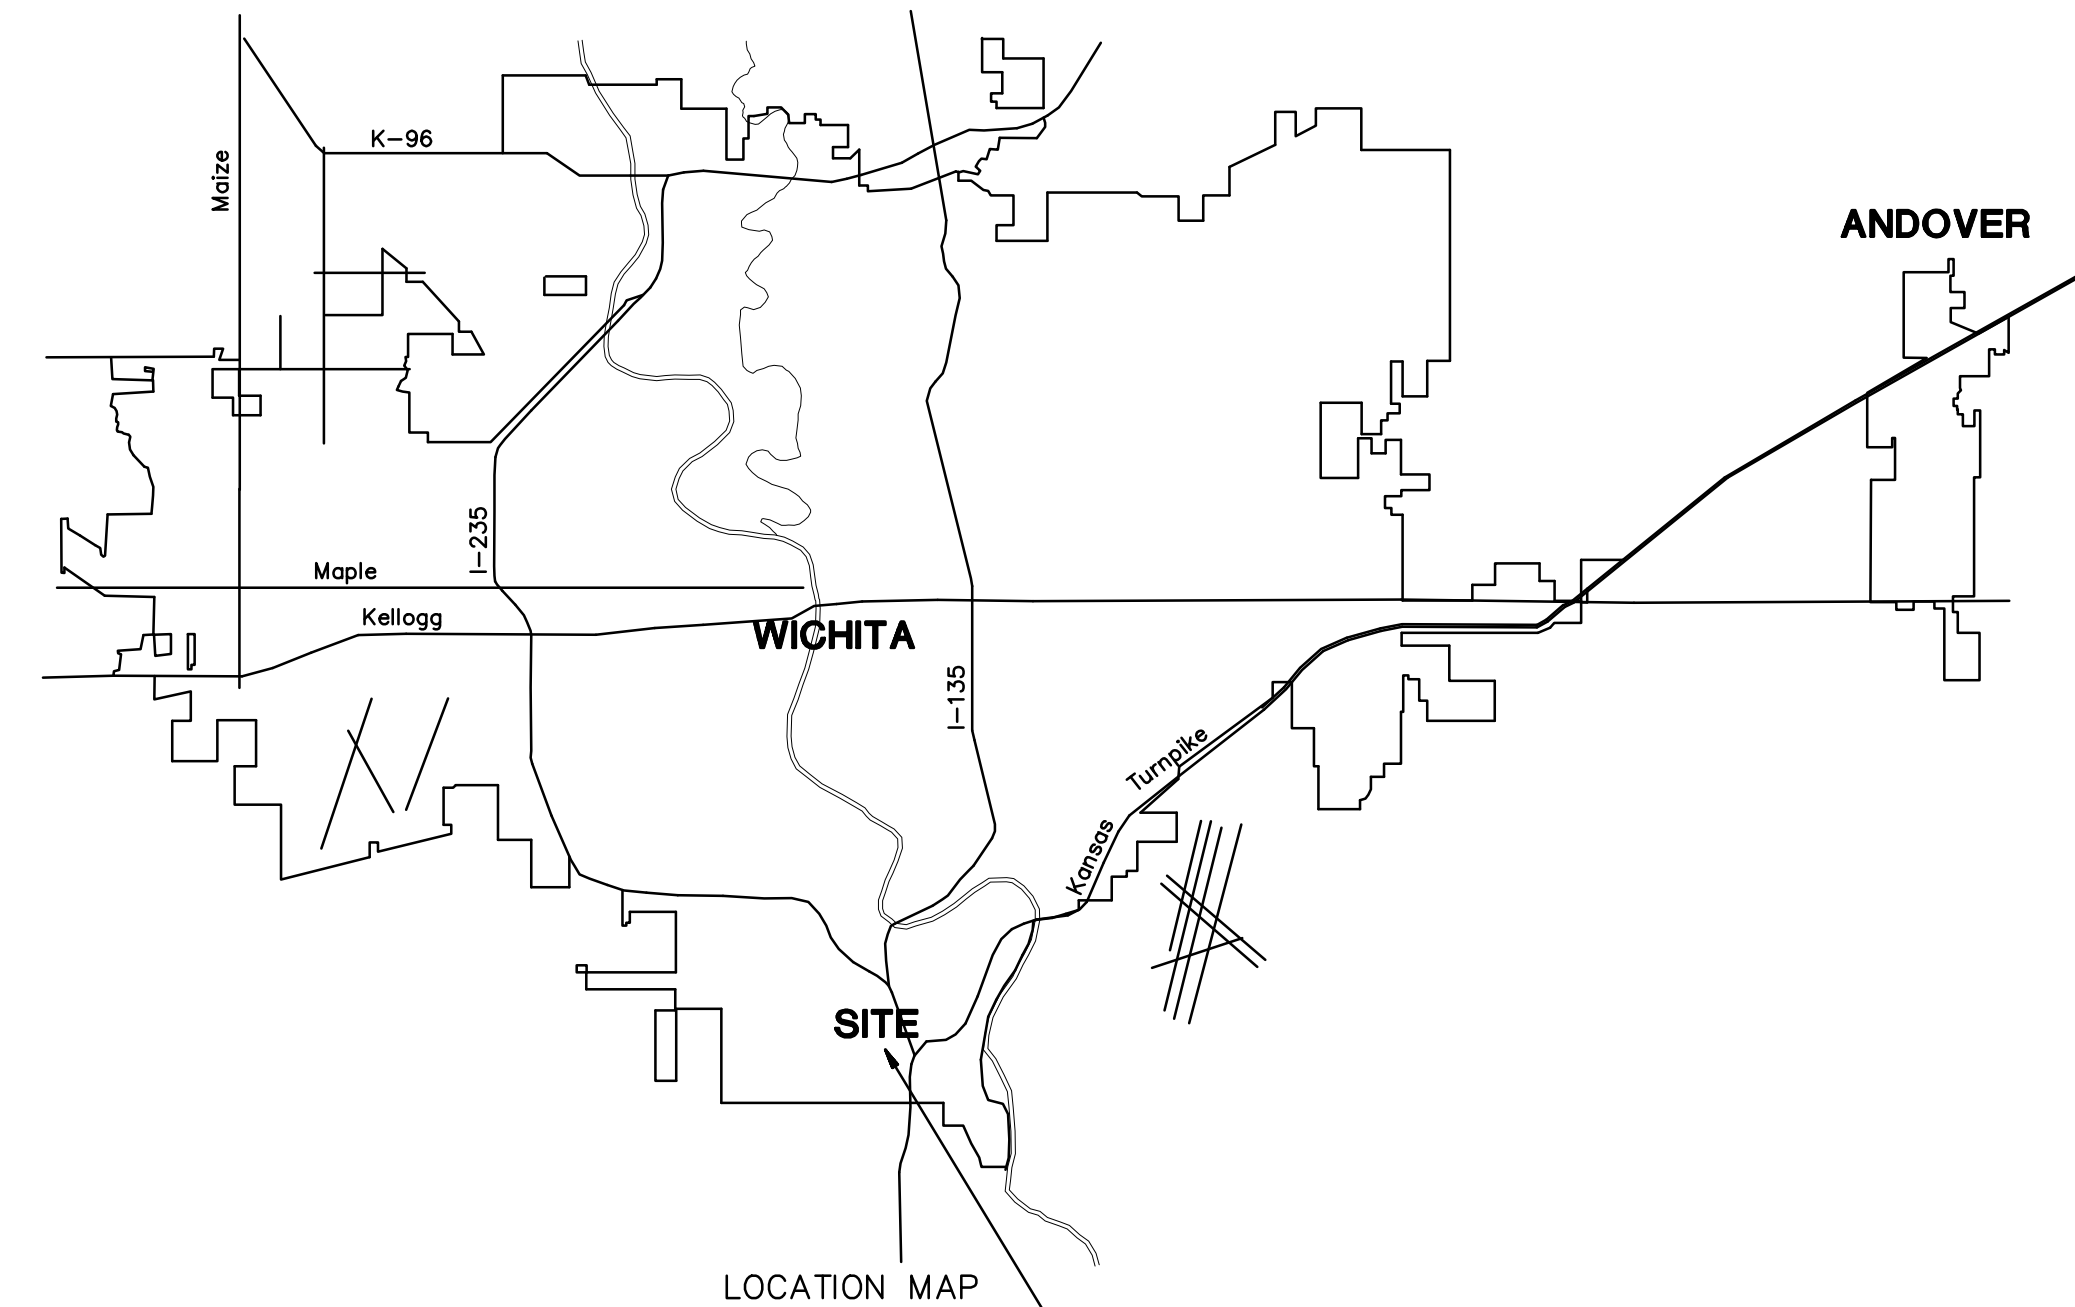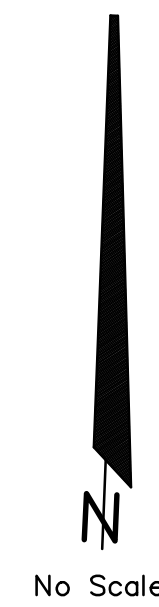

### INDEX OF SHEETS

SHEET NO. 1	TITLE SHEET
SHEET NO. 2	KEY MAP
SHEET NO. 3	STANDARD DETAILS
SHEET NO. 4-5	PLAN PROFILE
SHEET NO. 6-9	BMP'S
SHEET NO. 10	SWPPP/COORDINATE POINTS LIST
SHEET NO. 11	PLAT

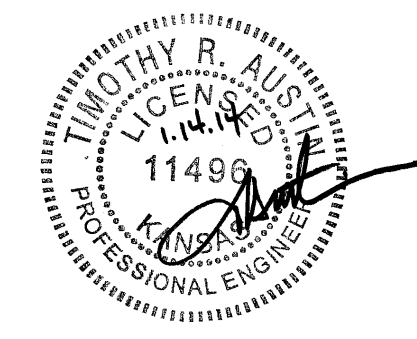

**JANUARY 2014**  
PLANS PREPARED BY



POE & ASSOCIATES, INC.  
CONSULTING ENGINEERS  
5940 E. Central, Suite 200 ■ Wichita, KS 67208-4242  
Phone 316/685-4114 ■ FAX 316/685-4444

