



*Existing 29"x18" CMMAAC were not field located.
Contractor shall verify size and location.

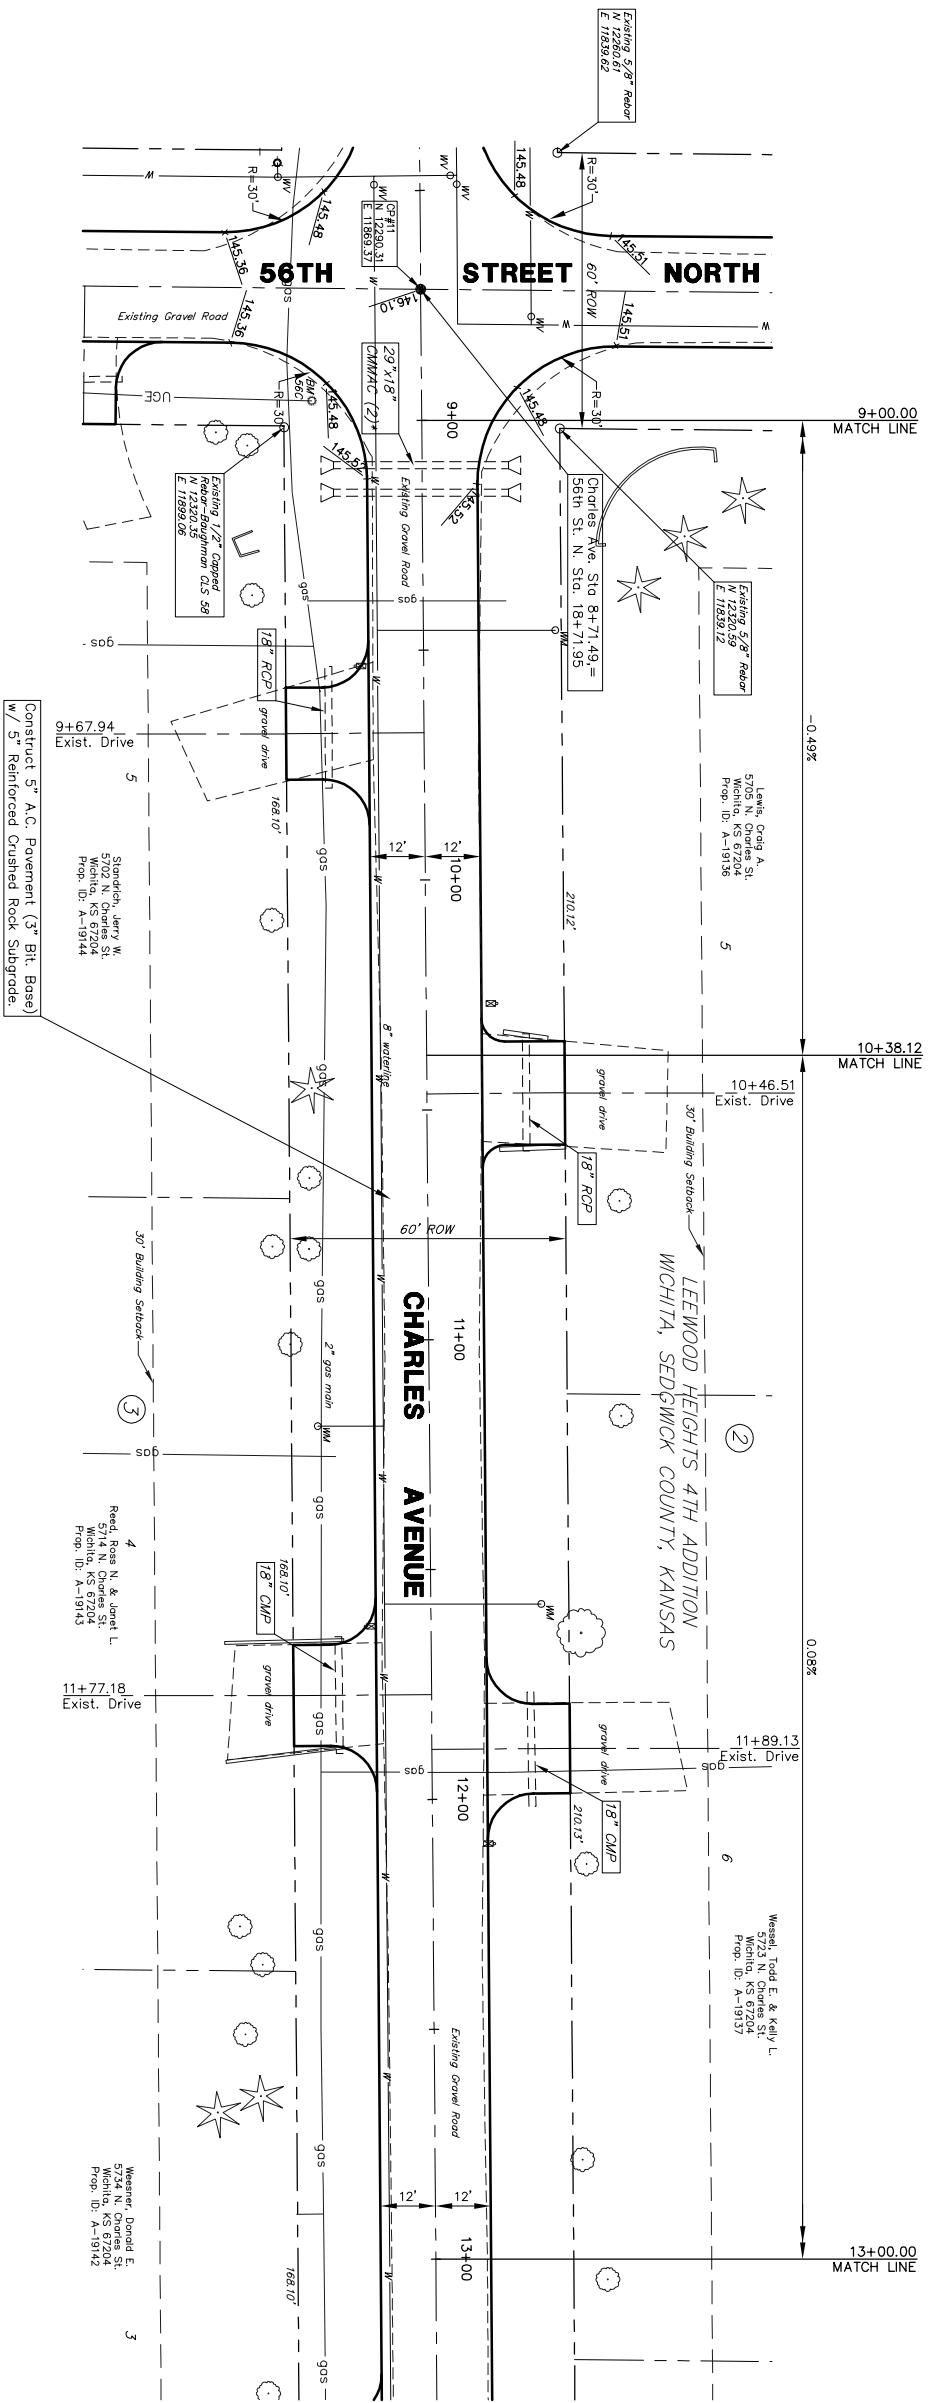

UTILITIES SHOWN REPRESENT THE BEST INFORMATION AVAILABLE FOR DESIGN. ADDITIONAL UTILITIES MAY BE PRESENT ON THIS PROJECT. THE CONTRACTOR SHALL BE RESPONSIBLE FOR DETERMINING THE EXACT LOCATION, DEPTH AND SIZE OF ALL UNDERGROUND UTILITIES PRIOR TO CONSTRUCTION. THE CONTRACTOR SHALL BE LIABLE FOR ANY DAMAGE CAUSED BY THE FAILURE TO DO SO.

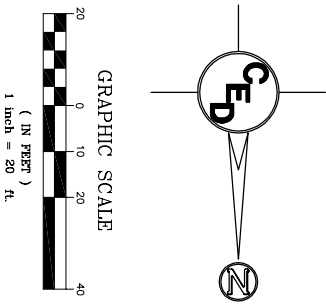

Station	Elevation	Notes
40	145.95	
8+80	145.6	PVI STA = 8+71.49 PVI ELEV = 146.10
9+20	145.3	
9+60	145.1	
10+00	145.0	
10+40	144.9	PVI STA = 10+38.12 PVI ELEV = 145.28
10+80	144.9	
11+20	144.9	
11+60	145.0	
12+00	145.1	
12+40	145.1	
12+80	145.1	
13+20	145.2	PVI STA = 13+06.11 PVI ELEV = 145.49

SURVEY DISCLAIMER:
TOPOGRAPHIC SURVEY USED IN PREPARING PLANS WAS PROVIDED BY GABER SURVEYING SERVICE, (620) 665-7033 423 WEST FIRST AVE. HUTCHINSON, KS. ENGINEER DOES NOT GUARANTEE SURVEY ELEVATIONS FOR ACCURACY. CONTRACTOR SHALL VERIFY ELEVATIONS AND NOTIFY ENGINEER OF ANY DISCREPANCIES.

UTILITY LEGEND	
	= Cat Box
	= Water Wall
	= Sprinkler Head
	= Water Meter
	= Water Valve
	= Gas Meter
	= Gas Valve
	= Telephone Riser
	= Section Corner
	= Set 5/8" x 24" Rebar
	= Mailbox
	= Flag Pole
	= SS Manhole
	= SWS Manhole
	= Sign
	= Fire Hydrant
	= Misc. Post
	= Guy Anchor
	= Power Pole
	= Light Pole
	= Deciduous Tree or Shrub
	= Coniferous Tree
	= Existing Fence
	= Property Line
	= Underground Telephone
	= Underground Electric
	= Overhead Electric
	= Water Line
	= Sanitary Sewer
	= Gas Line
	= Cable TV or Fiber Optic

**STREET PAVING PLAN FOR
CHARLES AVENUE**
WICHITA, SEDGWICK CO., KANSAS

CED PROJ. NO.: 20020917

CERTIFIED ENGINEERING DESIGN, P.A.

810 WEST DOUGLAS, SUITE C
WICHITA, KANSAS 67203
PH. (316) 262-8808 FAX. (316) 262-1669

DESIGNED: HDF
DRAWN: OKW
DATE: 12/02
SCALE: 1"=20'
SHEET 16
CHECKED: HDF
CED FILE: 53-d&w&rd-Base TOTAL 74