


UTILITY LEGEND

CB	= Catv Box	OP	= Flag Pole
MW	= Water Well	SM	= SS Manhole
SH	= Sprinkler Head	OW	= SWS Manhole
WM	= Water Meter	OS	= Sign
WV	= Water Valve	OH	= Fire Hydrant
GM	= Gas Meter	OV	= Misc. Post
GV	= Gas Valve	PA	= Guy Anchor
TR	= Telephone Riser	PP	= Power Pole
SC	= Section Corner	LP	= Light Pole
RS	= Set 5/8"x24" Rebar	MB	= Manhole
CTV	= Contiguous Tree or Shrub		
PR	= Property Line		
UT	= Underground Telephone		
UE	= Underground Electric		
OE	= Overhead Electric		
WL	= Water Line		
SL	= Sanitary Sewer		
GL	= Gas Line		
FO	= Cable TV or Fiber Optic		

UTILITIES SHOWN REPRESENT THE BEST INFORMATION AVAILABLE FOR DESIGN. ADDITIONAL UTILITIES MAY BE PRESENT ON THIS PROJECT. THE CONTRACTOR SHALL BE RESPONSIBLE FOR DETERMINING THE EXACT LOCATION, DEPTH AND SIZE OF ALL UNDERGROUND UTILITIES PRIOR TO CONSTRUCTION. THE CONTRACTOR SHALL BE LIABLE FOR ANY DAMAGE CAUSED BY THE FAILURE TO DO SO.

GRAPHIC SCALE
1 inch = 20 feet
(IN FEET)

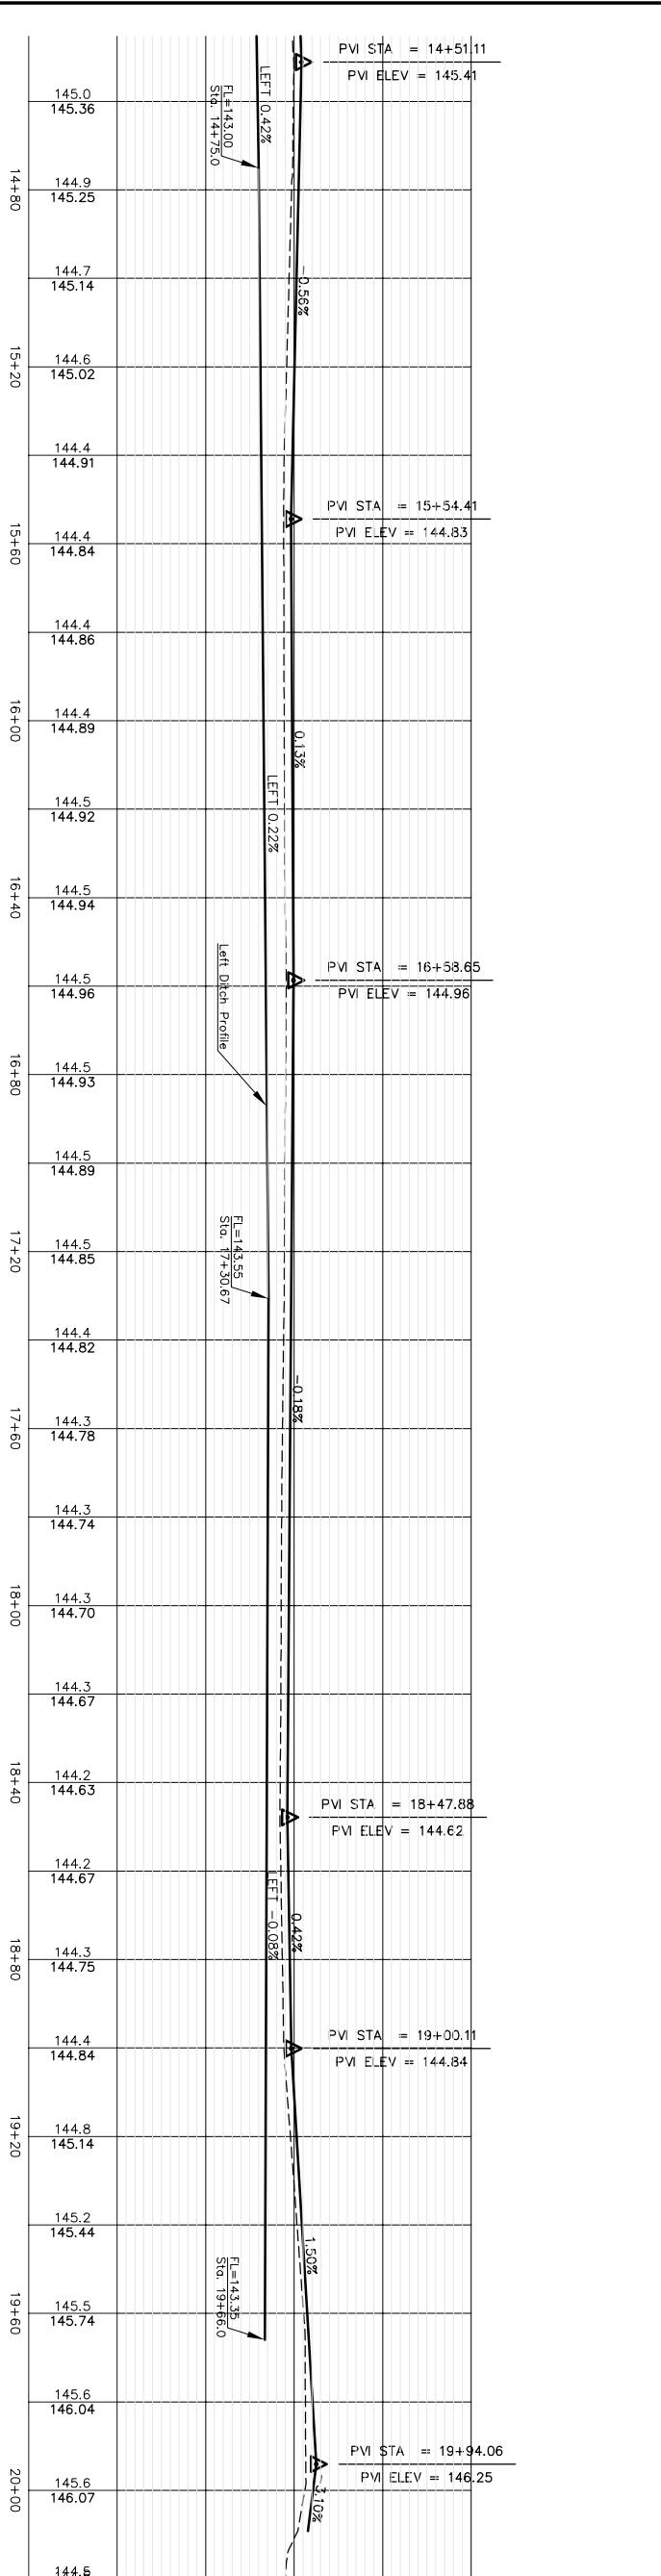

STREET PAVING PLAN FOR 54TH STREET NORTH
WICHITA, SEDGWICK CO., KANSAS
CED PROJ. NO.: 20020917

CERTIFIED ENGINEERING DESIGN, P.A.
810 WEST DOUGLAS, SUITE C
WICHITA, KANSAS 67203
PH. (316) 262-8808 FAX. (316) 262-1669

DESIGNED: HOF
DRAWN: OKW
SCALE: 1"=20'
DATE: 12/02
SHEET: 25
CHECKED: HOF
CED FILE: 53rd&Hend-Base TOTAL: 74

SURVEY DISCLAIMER
TOPOGRAPHIC SURVEY USED IN PREPARING PLANS WAS PROVIDED BY GARBER SURVEYING SERVICE, (620) 665-7032, 423 WEST FIRST AVE., HUTCHINSON, KS. ENGINEER DOES NOT GUARANTEE SURVEY ELEVATIONS FOR ACCURACY. CONTRACTOR SHALL VERIFY ELEVATIONS AND NOTIFY ENGINEER OF ANY DISCREPANCIES.