


Save: 02-22-2015 09:56:14 AM by CAL
 Plot Scale: 1" = 20'-2015 11:27:01 AM by CRAIG LEWIS
 U:\Wichita-Facility\2014\14229\001\W&M\Drawings\14229-001 C2 Demo Plan

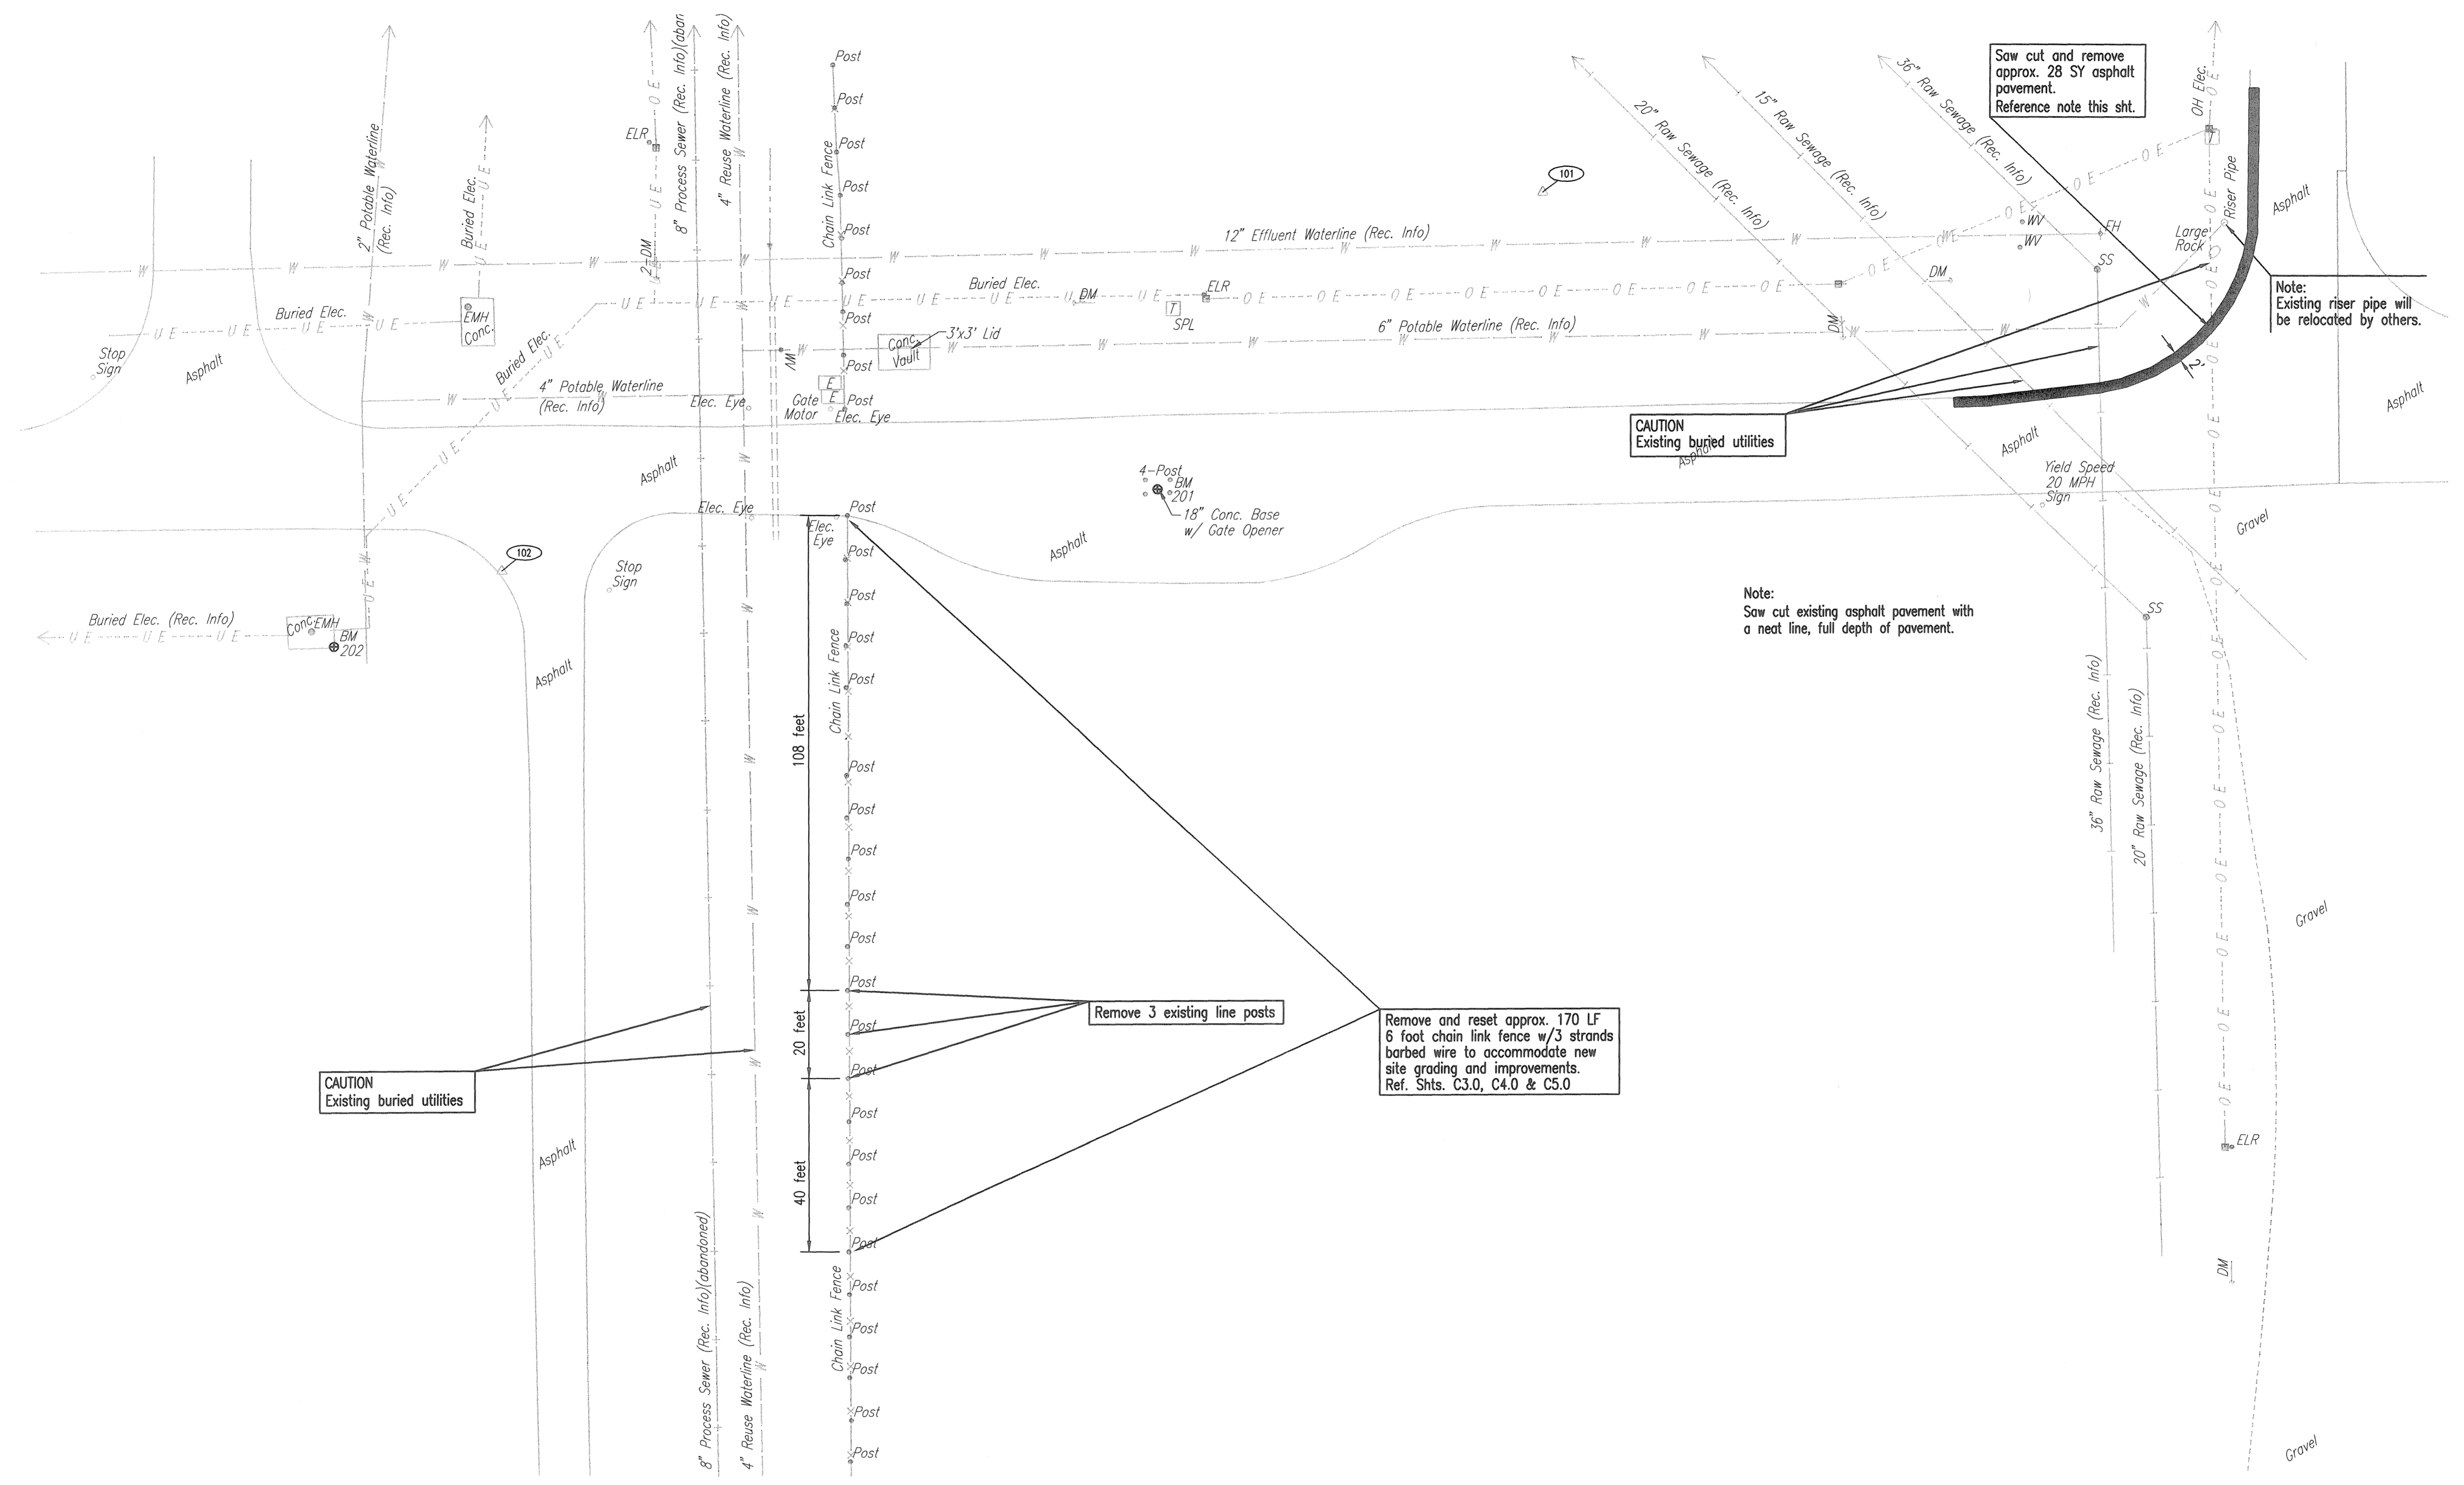

Scale: 1" = 20'

	Revision		By	Date
	CITY OF WICHITA, KANSAS			
	DEMOLITION SITE PLAN			
	WWTP #2 EMERGENCY POWER PROJECT C.O.W. PROJECT NO. 468-84956			
PROFESSIONAL ENGINEERING CONSULTANTS, P.A. 303 SOUTH TOPEKA WICHITA, KS 67202 316-262-2691 www.pec1.com		Designed by MEB Job No. 34-14229-001-0042 Drawn by CAL	Date February 2015	Sht. C2.0 of 36