

PLOTTED: Thursday, April 21, 2016 @ 03:47PM

J:\PROJECTS\2015\1510100623_COWI_REUSE_WATER_SUPPLY_SYSTEM_150623_CAD\SHOTS05_CIVIL\GENERAL\150623_TITLE_SHT.DWG

INDEX TO DRAWINGS

SHEET NO.	DESCRIPTION
GENERAL SHEET SET:	
G1.0	TITLE SHEET
G2.0	PIPING AND INST. DIAGRAM
CIVIL SHEET SET:	
C1.0	SITE PLAN
C2.0	GRADING PLAN
C3.0	PAVING PLAN
C3.1	PAVING DETAILS
STRUCTURAL SHEET SET:	
S0.1	LOCATION PLAN & STRUCTURAL GENERAL NOTES
S1.0	FOUNDATION PLAN - VAULT
S1.1	FOUNDATION PLAN - BLDG
S2.0	FOUNDATION SECTIONS
S2.1	FOUNDATION SECTIONS
S2.2	FOUNDATION SECTIONS
S2.3	FOUNDATION SECTIONS
S2.4	FOUNDATION SECTIONS
ARCHITECTURAL SHEET SET:	
A1.0	FLOOR PLANS
A2.0	EXTERIOR ELEVATIONS
A2.1	EXTERIOR ELEVATIONS
A3.0	BUILDING SECTIONS
A4.0	WALL SECTIONS
A5.0	ROOF PLAN
A6.0	SCHEDULES & OPENING DETAILS
A7.0	ARCHITECTURAL SPECIFICATIONS
A7.1	ARCHITECTURAL SPECIFICATIONS
A7.2	ARCHITECTURAL SPECIFICATIONS
A7.3	ARCHITECTURAL SPECIFICATIONS
A7.4	ARCHITECTURAL SPECIFICATIONS
A7.5	ARCHITECTURAL SPECIFICATIONS
ELECTRICAL SHEET SET:	
E1.0	ELECTRICAL COVERSHEET
E2.0	ELECTRICAL PLANS
E2.1	CONTROL PIPING PLAN
E3.0	ELECTRICAL SITE PLAN
E4.0	ELECTRICAL DETAILS
E4.1	ELECTRICAL DETAILS
E4.2	ELECTRICAL SCHEDULES
E4.3	ELECTRICAL SPECIFICATIONS
MECHANICAL SHEET SET:	
M1.0	MECHANICAL COVERSHEET
M2.0	HVAC PLAN
M3.0	MECHANICAL DETAILS & SCHEDULES
M4.0	MECHANICAL SPECIFICATIONS
M4.1	MECHANICAL SPECIFICATIONS
M5.0	MECHANICAL PLAN
M5.1	PUMP ROOM DETAILS
M5.2	CHLORINATION ROOM PLAN
M5.3	PIPING DETAILS
M6.0	EQUIPMENT AND PIPING NOTES
M6.1	EQUIPMENT AND PIPING NOTES (CONT.)
PLUMBING SHEET SET:	
P1.0	PLUMBING PLANS


RE-USE WATER PUMP STATION

TO SERVE SPIRIT AEROSYSTEMS

PROJECT NO. 468-85112


O.C.A. NO. 620784

THE CITY OF WICHITA, KANSAS
GARY JANZEN, P.E. - CITY ENGINEER

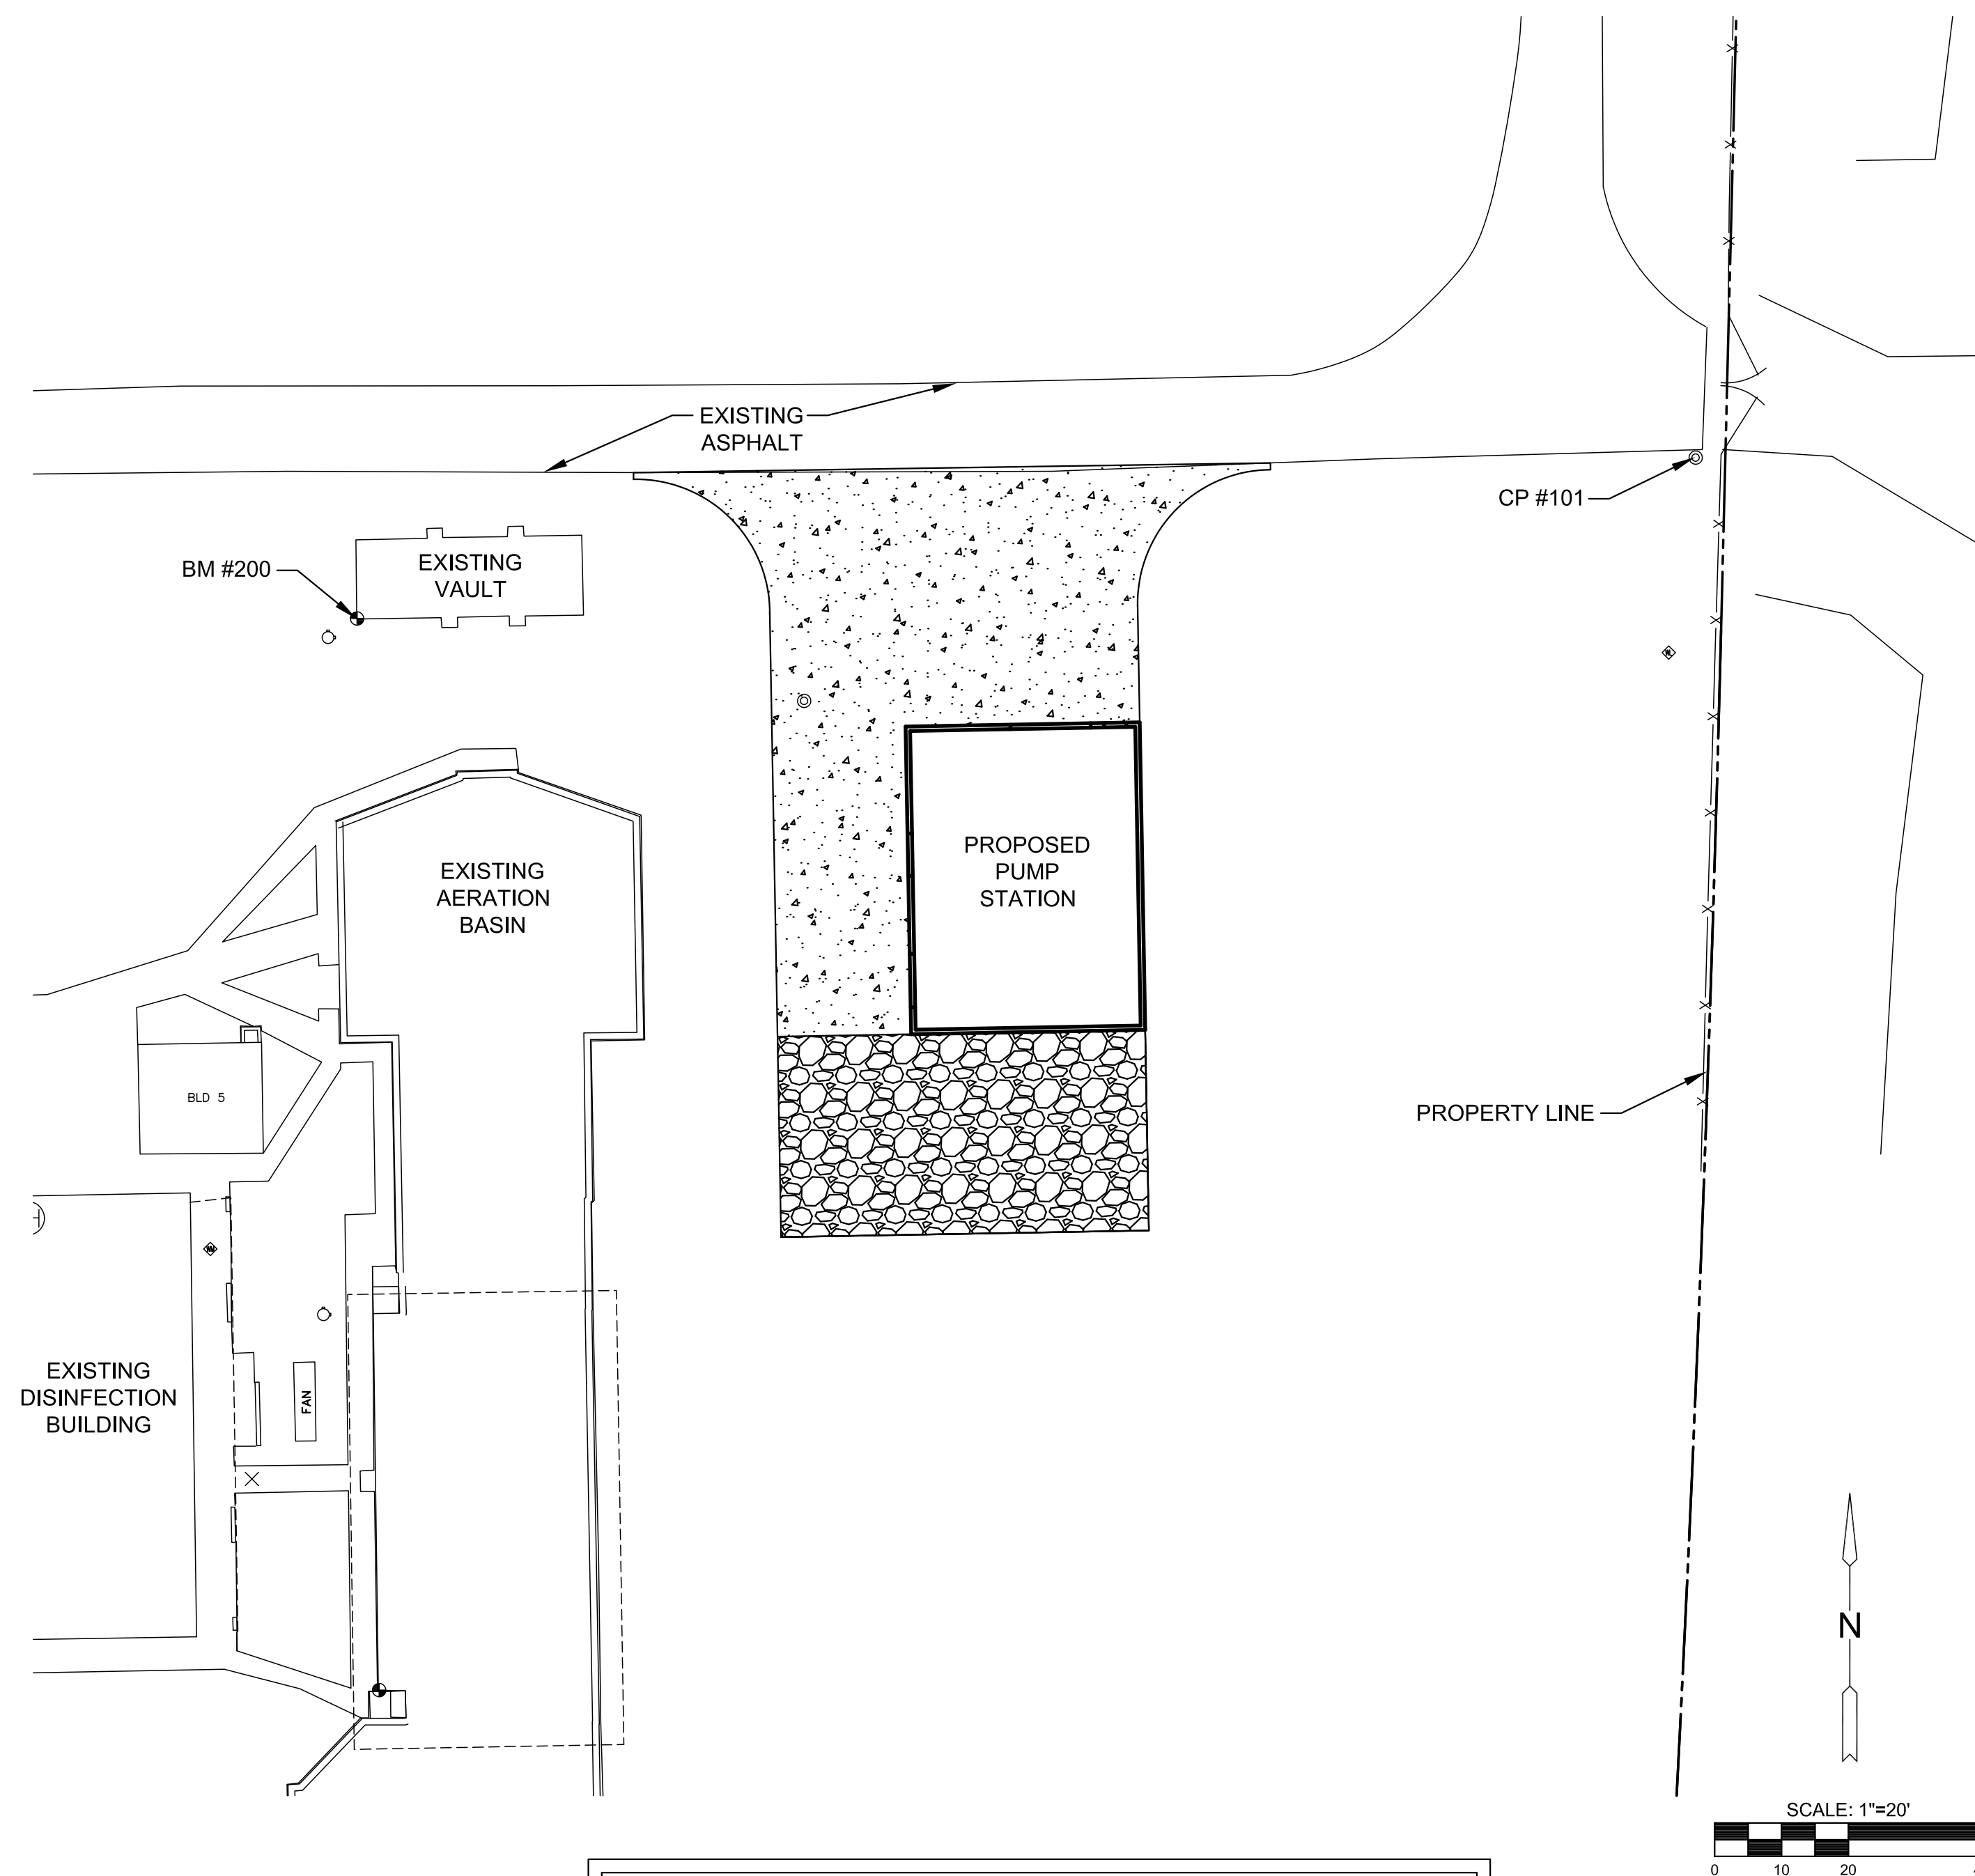

GENERAL NOTES:

1. ALL MEASUREMENTS AND QUANTITIES SHOWN IN THE PLANS AND BID DOCUMENTS ARE FOR INFORMATION ONLY. THE CONTRACTOR SHALL BE RESPONSIBLE FOR VERIFYING ALL QUANTITIES.
2. THIS PROJECT IS A LUMP SUM BID. UNIT PRICES WILL ONLY BE USED SHOULD THE PROJECT SCOPE OF WORK BE INCREASED OR DECREASED.

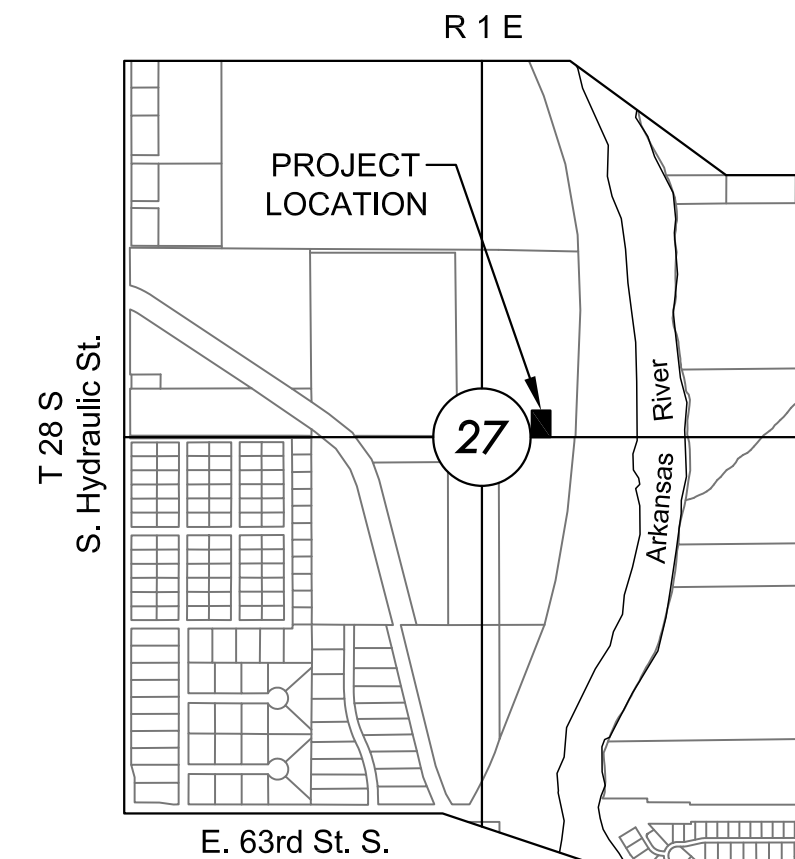

VICINITY MAP

No Scale

PROJECT CONTROL & INFORMATION

CONTROL:

Pt. No.	North	East	Elev	Description
101	1649787.611	1658833.460	1266.440	5/8" rebar w/ red MKEC CP ID cap
102	1650586.569	1658732.288	1266.260	5/8" rebar w/ red MKEC CP ID cap

Bench Marks

BM 200 - Chiseled square on S.W. corner of concrete vault for out flow pipe

N=1649763.546

E=1658633.307

Elev.=1264.490 (NAVD 88)

BM 201 - Chiseled square on the retaining wall at an inlet grate on the N. side of rock sprinkler pond #1

N=1650489.185

E=1658648.512

Elev.=1270.695 (NAVD 88)

DATUM:

1) The Project Horizontal Datum is based on the NAD83, Kansas State Plane Coordinate System, South Zone, (US Survey Feet Definition), with a Combined Adjustment Factor (CAF) of 1.000120014.

All coordinate and dimensions shown on these plans are modified to Ground values.

The following equations can be used for conversion:


Ground Coordinates to State Plane Coordinates = Ground x 1/CAF

State Plane Coordinates to Ground Coordinates = State Plane x CAF

2) The Vertical Datum used is NAVD88.

UTILITIES:

The underground utilities shown hereon were marked in the field by the utility owners in response to Kansas One Call Ticket Number:16059879, 16059923, 16059950, 16061251, 16061269, 16061294, 16066685, 16066718, 16081169, 16082890, 16082924, 16086816, 16086842, 16093649, 16093667, and 16105347. The surveyor makes no guarantee that the underground utilities shown comprise all such utilities in the area, either in service or abandoned. The surveyor further does not warrant that the underground utilities shown are in the exact location indicated although he does certify that they are located as accurately as possible from information available. The surveyor has not physically located the underground utilities.

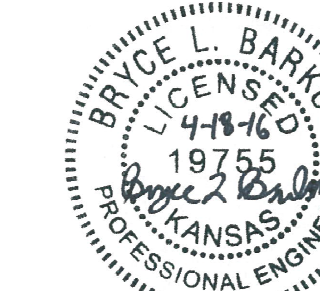

CITY OF WICHITA, KANSAS
RE-USE WATER PUMP STATION
 TO SERVE SPIRIT AEROSYSTEMS

©2016
MKEC Engineering
All Rights Reserved
www.mkec.com
These drawings and their contents, including, but not limited to, all concepts, designs, & ideas are the exclusive property of MKEC Engineering (MKEC), and may not be used or reproduced in any way without the express consent of MKEC.

TITLE SHEET

PROJECT NO.	468-85112	
DATE	04/18/16	
SCALE	AS NOTED	
DESIGNED	DRAWN	CHECKED
BLB	MCW	MAB

ISSUED FOR CONSTRUCTION	04/18/16	
NO.	REVISION	DATE

SHEET NO.

G1.0