

J:\PROJECTS\2015\1501010623\_COW\_REUSE\_WATER\_SUPPLY\_SYSTEM\SYSTEM\_150623\_CAD\SHOTS\05\_CIVIL\WTR150623-CT-01.DWG  
 PLOTTED: Thursday, June 02, 2016 @ 10:28AM

### INDEX TO DRAWINGS

SHEET NO.	DESCRIPTION
01	TITLE SHEET
02	PROJECT NOTES
03-04	PROJECT DETAILS
05-24	WATER PLAN & PROFILE
25	GRADING PLANS
26	SWS PLAN
27	BUBBLE MAP
28-31	EROSION CONTROL SHEETS
32-36	BMP SHEETS


# CITY OF WICHITA, KS

## 12" RE-USE WATER PIPELINE

PROJECT NO. 468-85095

THE CITY OF WICHITA, KANSAS  
GARY JANZEN, P.E. - CITY ENGINEER

OCA NO. 620784

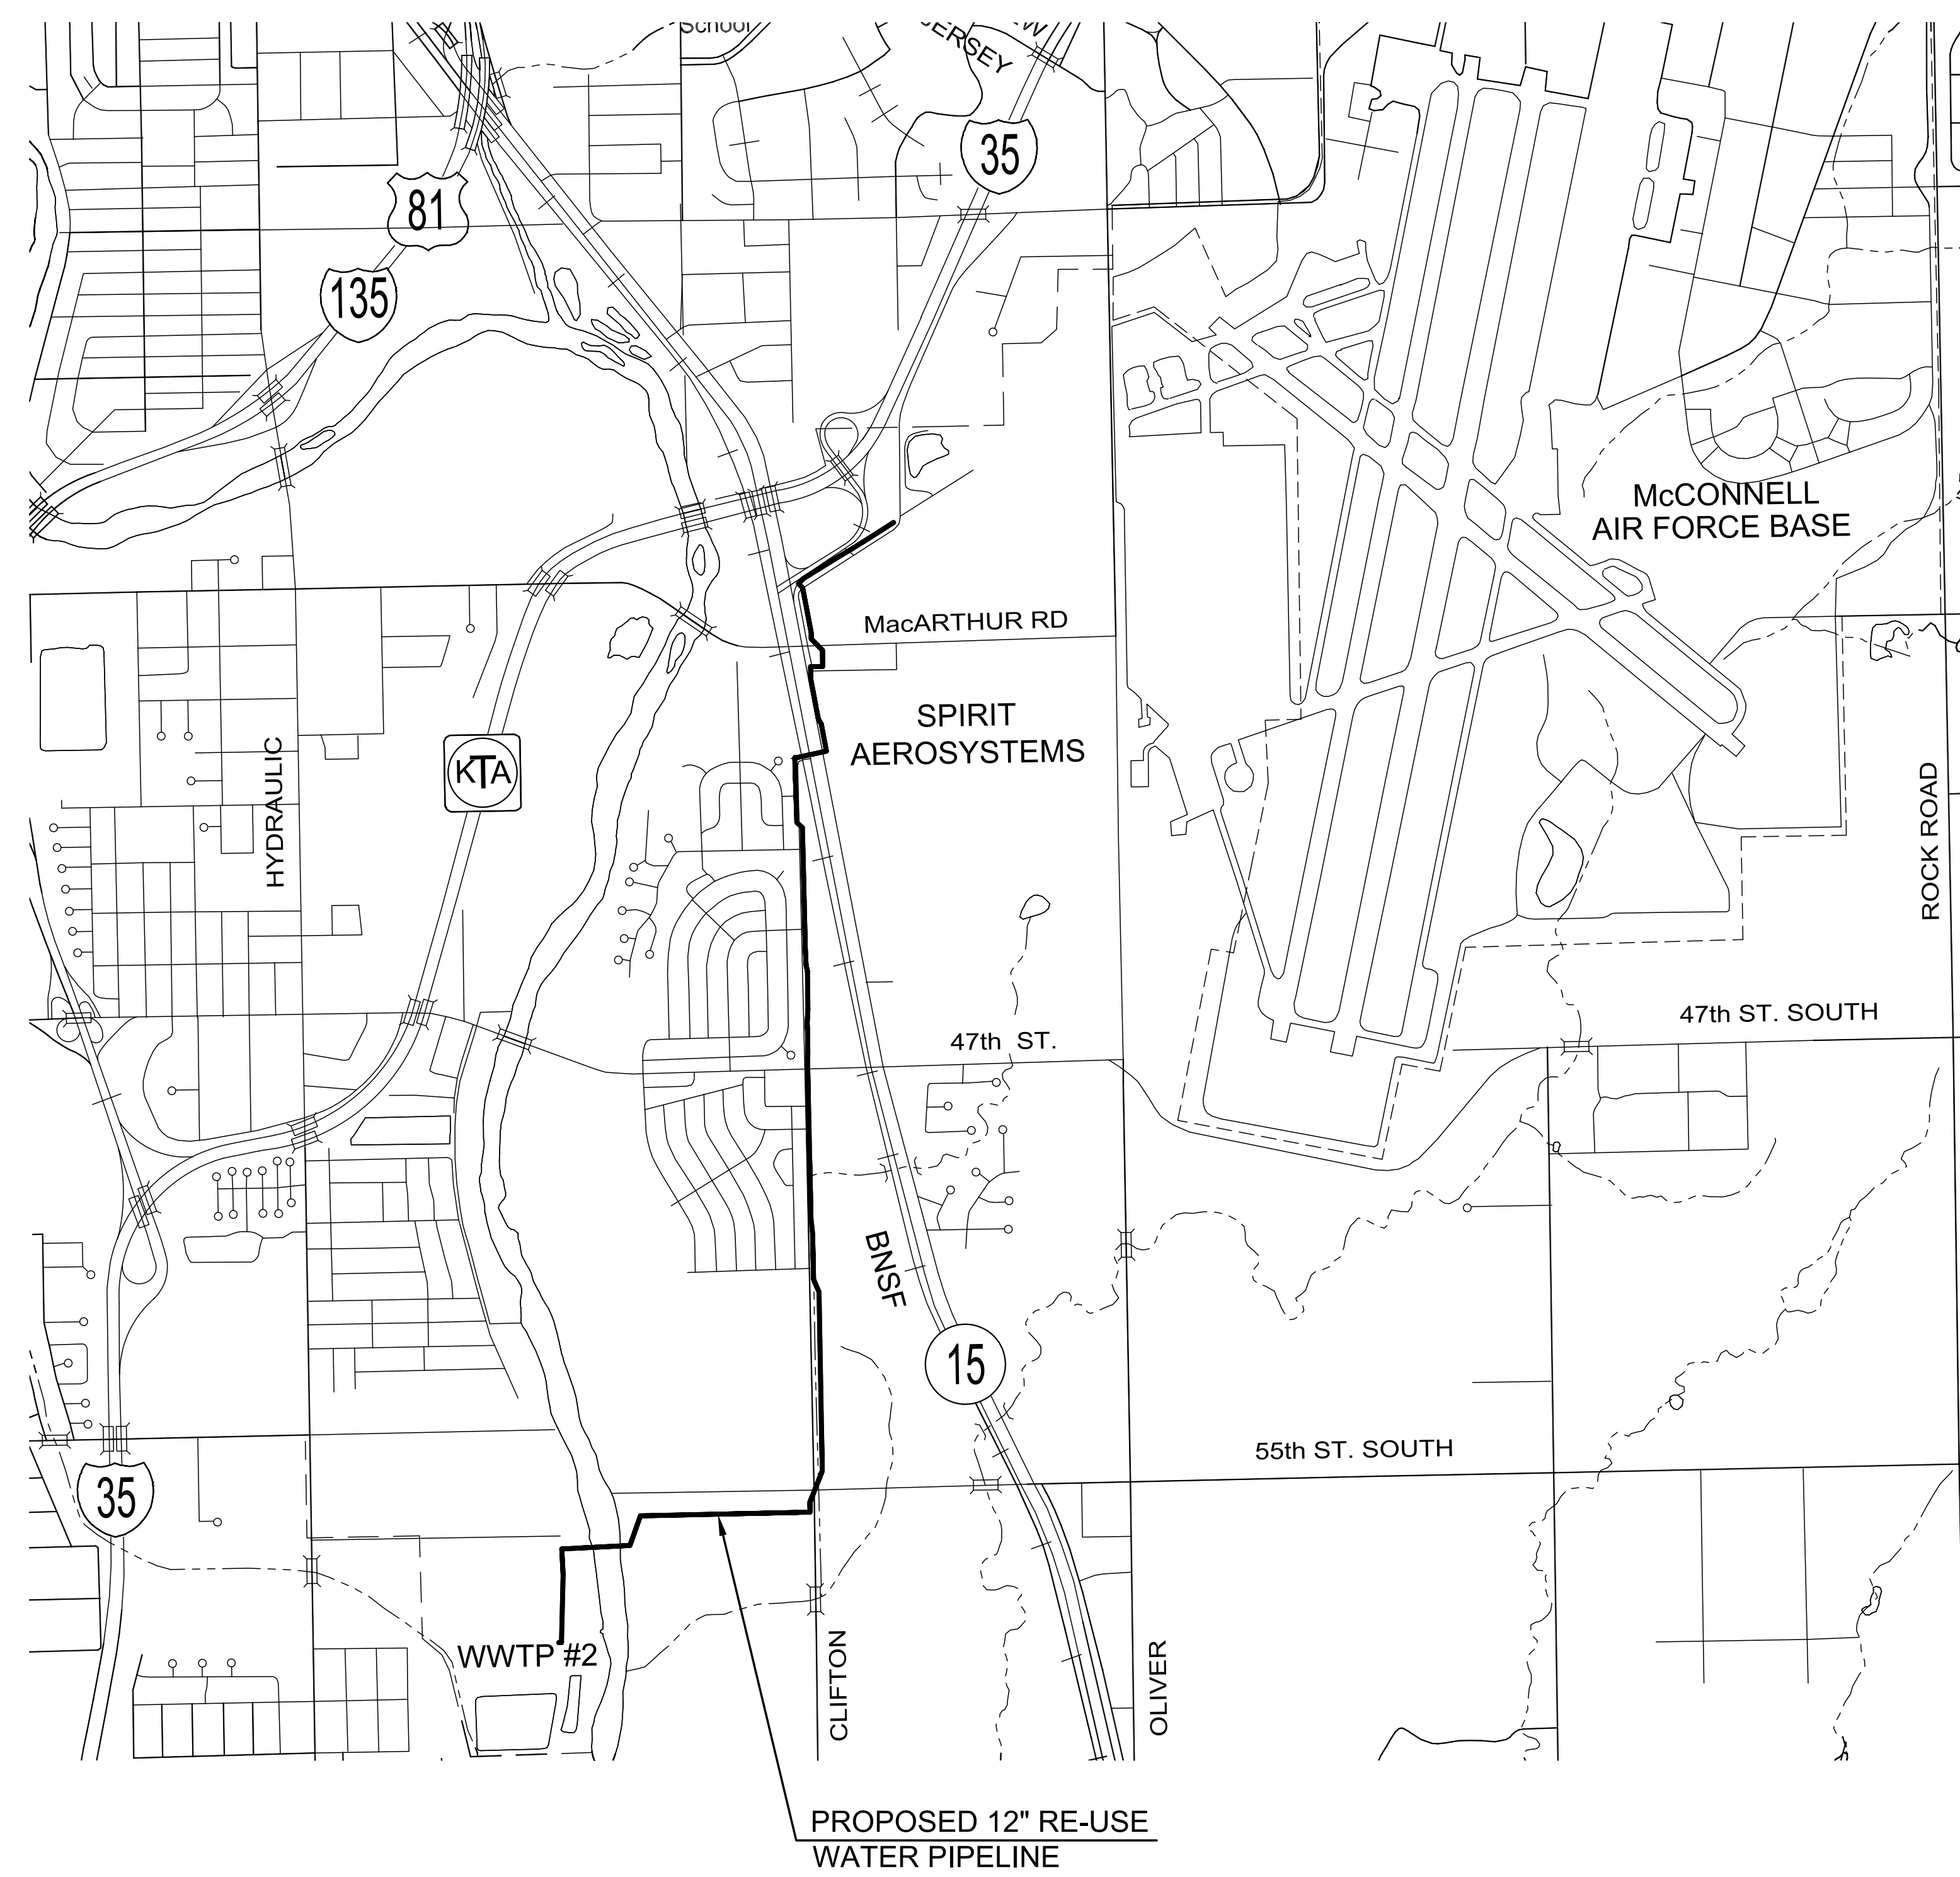

R 1 E  
RIVERSIDE

6	5	4	3	2	1
7	8	9	10	11	12
18	17	16	15	14	13
19	20	21	22	23	24
30	29	28	27	26	25
31	32	33	34	35	36

VICINITY MAP  
No Scale



CITY OF WICHITA, KS


# 12" RE-USE WATER PIPELINE

TO SERVE SPIRIT AEROSYSTEMS

©2016  
 MKEC Engineering  
 All Rights Reserved  
 www.mkec.com  
 These drawings and their contents, including, but not limited to, all concepts, designs, & ideas are the exclusive property of MKEC Engineering (MKEC), and may not be used or reproduced in any way without the express consent of MKEC.

### TITLE SHEET

PROJECT NO.	468-85095	
DATE	APRIL 2016	
SCALE	1" = 1500'	
DESIGNED	DRAWN	CHECKED
DFL	JWC	MAB

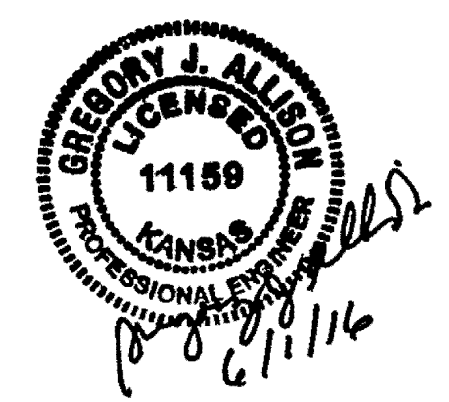

NO.	ISSUED FOR CONST.	06/01/16
	REVISION	DATE

SHEET NO.  
01 OF 36