



J:\PROJECTS\2017\101010567_COW_STRYKER_170567_CAD\SH1505_OVALS\SW170567_05-4200.DWG
 J:\PROJECTS\2017\101010567_COW_STRYKER_170567_CAD\SH1505_OVALS\SW170567_05-4200.DWG
 PLOTTED: Wednesday, January 10, 2018 @ 10:36AM

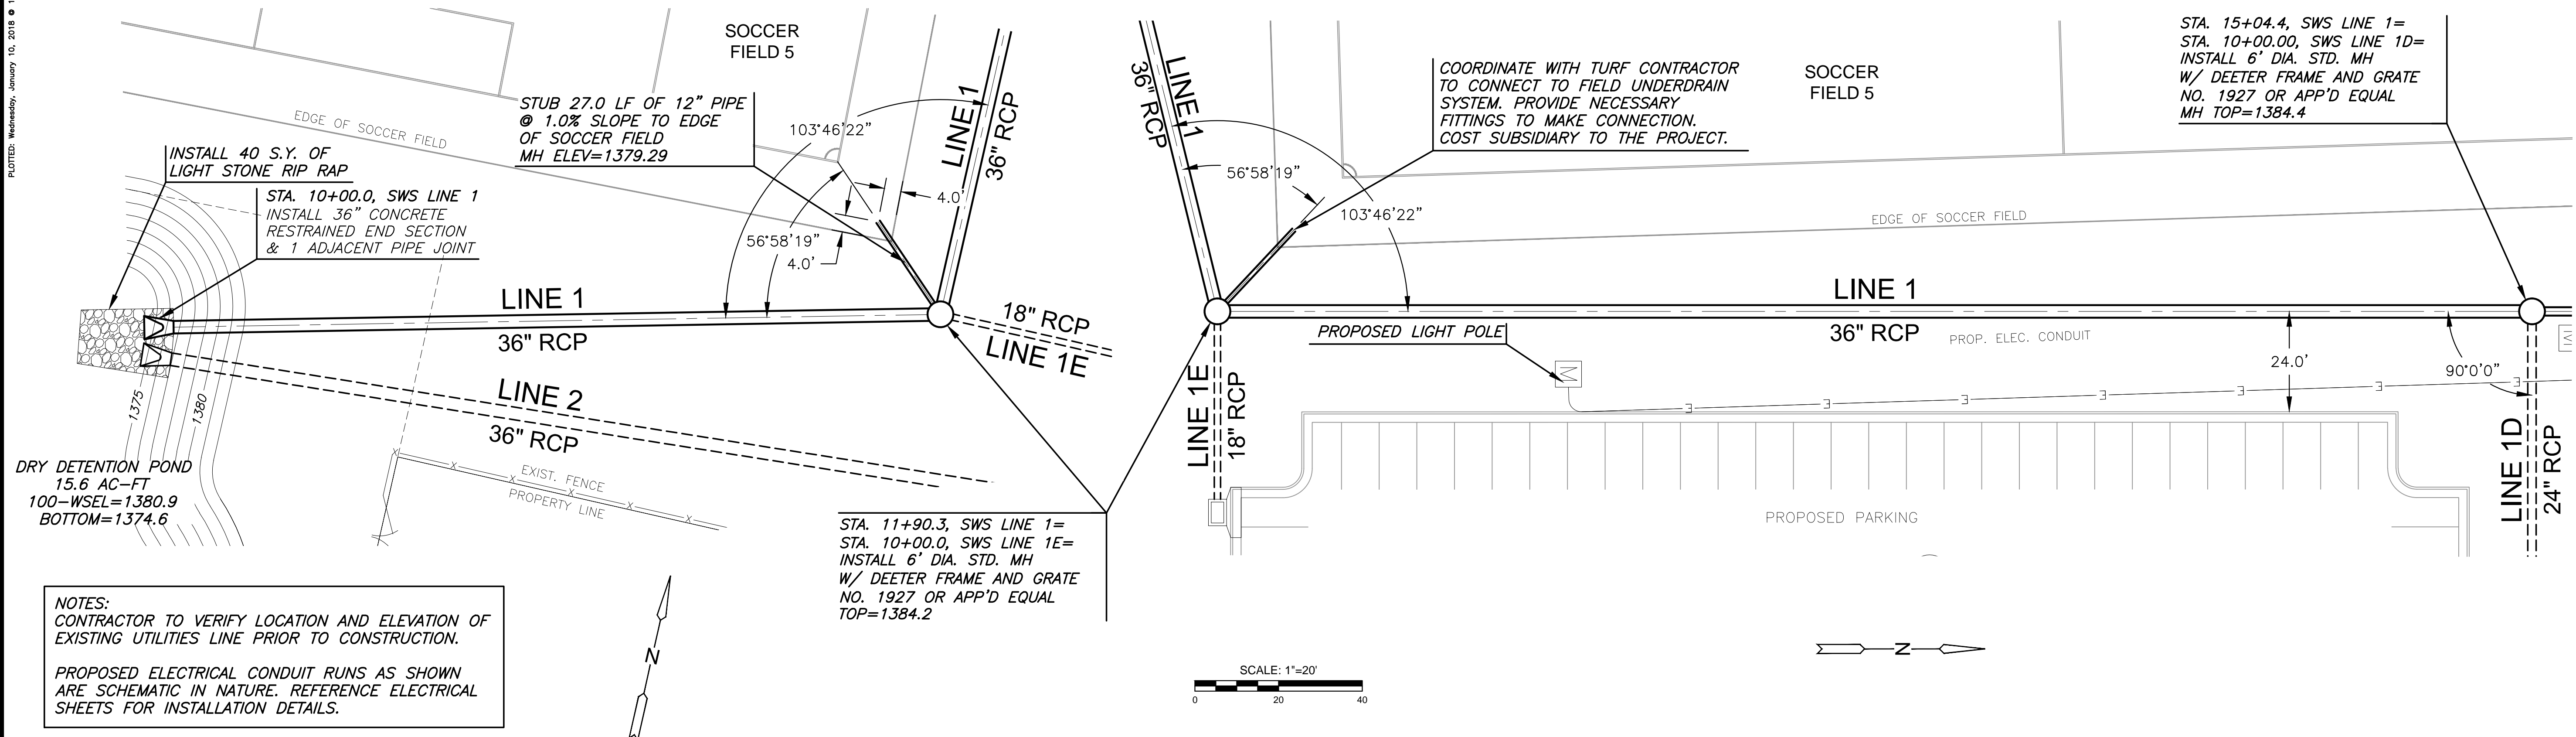

NOTES:
 CONTRACTOR TO VERIFY LOCATION AND ELEVATION OF EXISTING UTILITIES LINE PRIOR TO CONSTRUCTION.
 PROPOSED ELECTRICAL CONDUIT RUNS AS SHOWN ARE SCHEMATIC IN NATURE. REFERENCE ELECTRICAL SHEETS FOR INSTALLATION DETAILS.

**PLAN LINE 1
 PROFILE LINE 1**

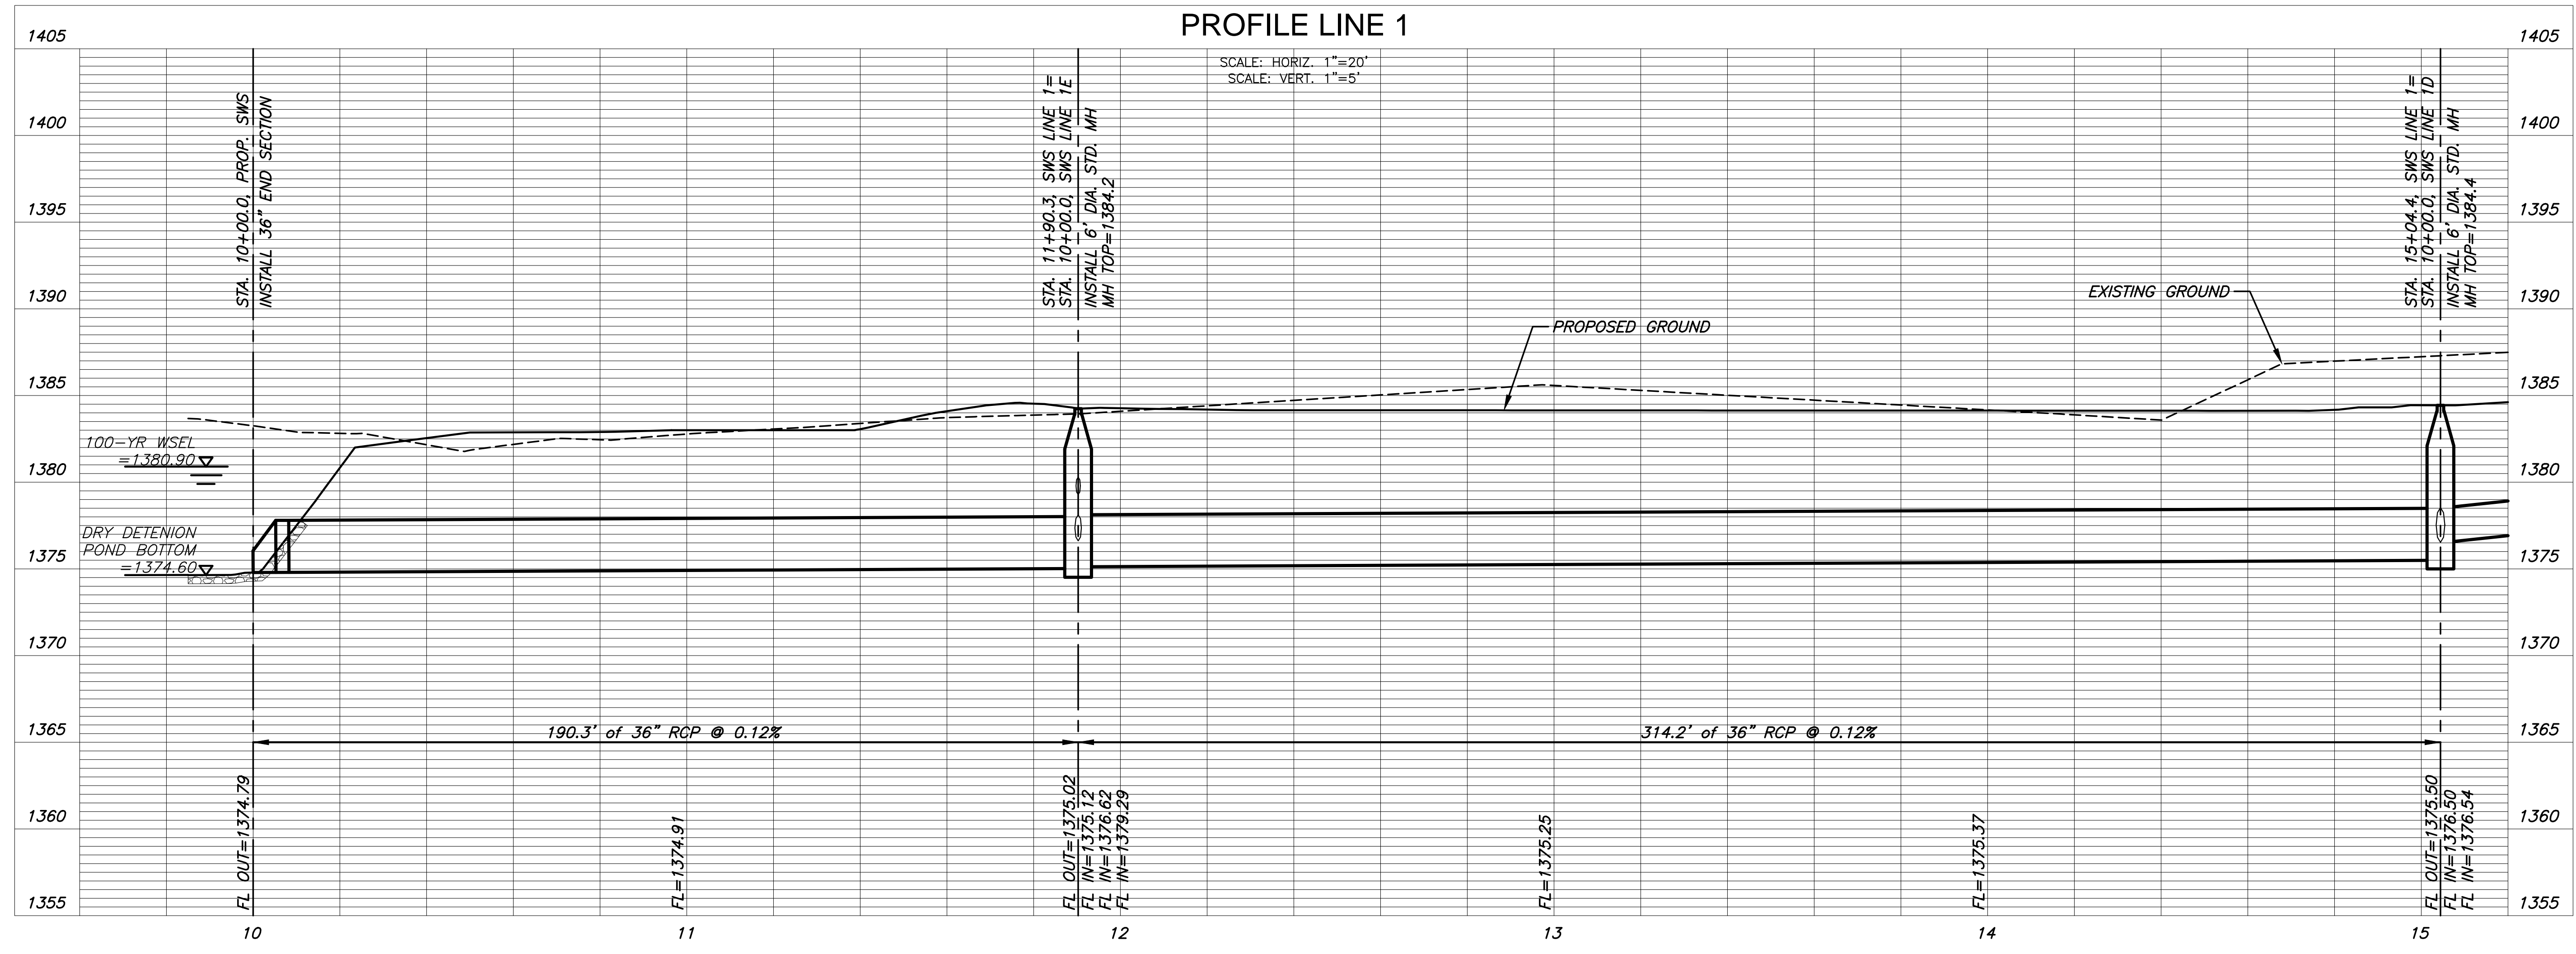

GRADING AND UTILITY PLANS
STRYKER SPORTS
 WICHITA, KANSAS



©2018 MKEC Engineering
 All Rights Reserved
 www.mkec.com
 These drawings and their contents, including, but not limited to, all concepts, designs, & ideas are the exclusive property of MKEC Engineering (MKEC), and may not be used or reproduced in any way without the express consent of MKEC.

SWS LINE 1	
PROJECT NO.	170567
DATE	01-10-18
SCALE	1" = 20'
DESIGNED	MAB
DRAWN	CRM
CHECKED	MAB
ISSUED FOR CONST. NO.	1-10-18
REVISION	DATE
SHEET NO. 37 OF 70	