

STATE	PROJECT NO.	YEAR	SHEET NO.	TOTAL SHEETS
KANSAS	87 N-0615-01	2017	20	183



STREET IMPROVEMENTS FOR
127TH STREET EAST
 FROM 13TH STREET NORTH TO 21ST STREET NORTH

©2017
 MKEC Engineering
 All Rights Reserved
 www.mkec.com
 These drawings and their contents, including, but not limited to, all concepts, designs, & ideas are the exclusive property of MKEC Engineering (MKEC), and may not be used or reproduced in any way without the express consent of MKEC.


UTILITY KEY MAP

PROJECT NO.	472-85158	
DATE	11/29/17	
SCALE	1"=100'	
DESIGNED	DRAWN	CHECKED
JRA	LES	JRA

NO.	REVISION	DATE

SHEET NO.
20 OF 183

J:\PROJECTS\2017\1401040290 - COW_127THE_13TH TO 21ST\05-CIVIL\CAO\SWS\14290_UBR01.DWG
 PLOTTED: Wednesday, November 29, 2017 @ 02:24PM

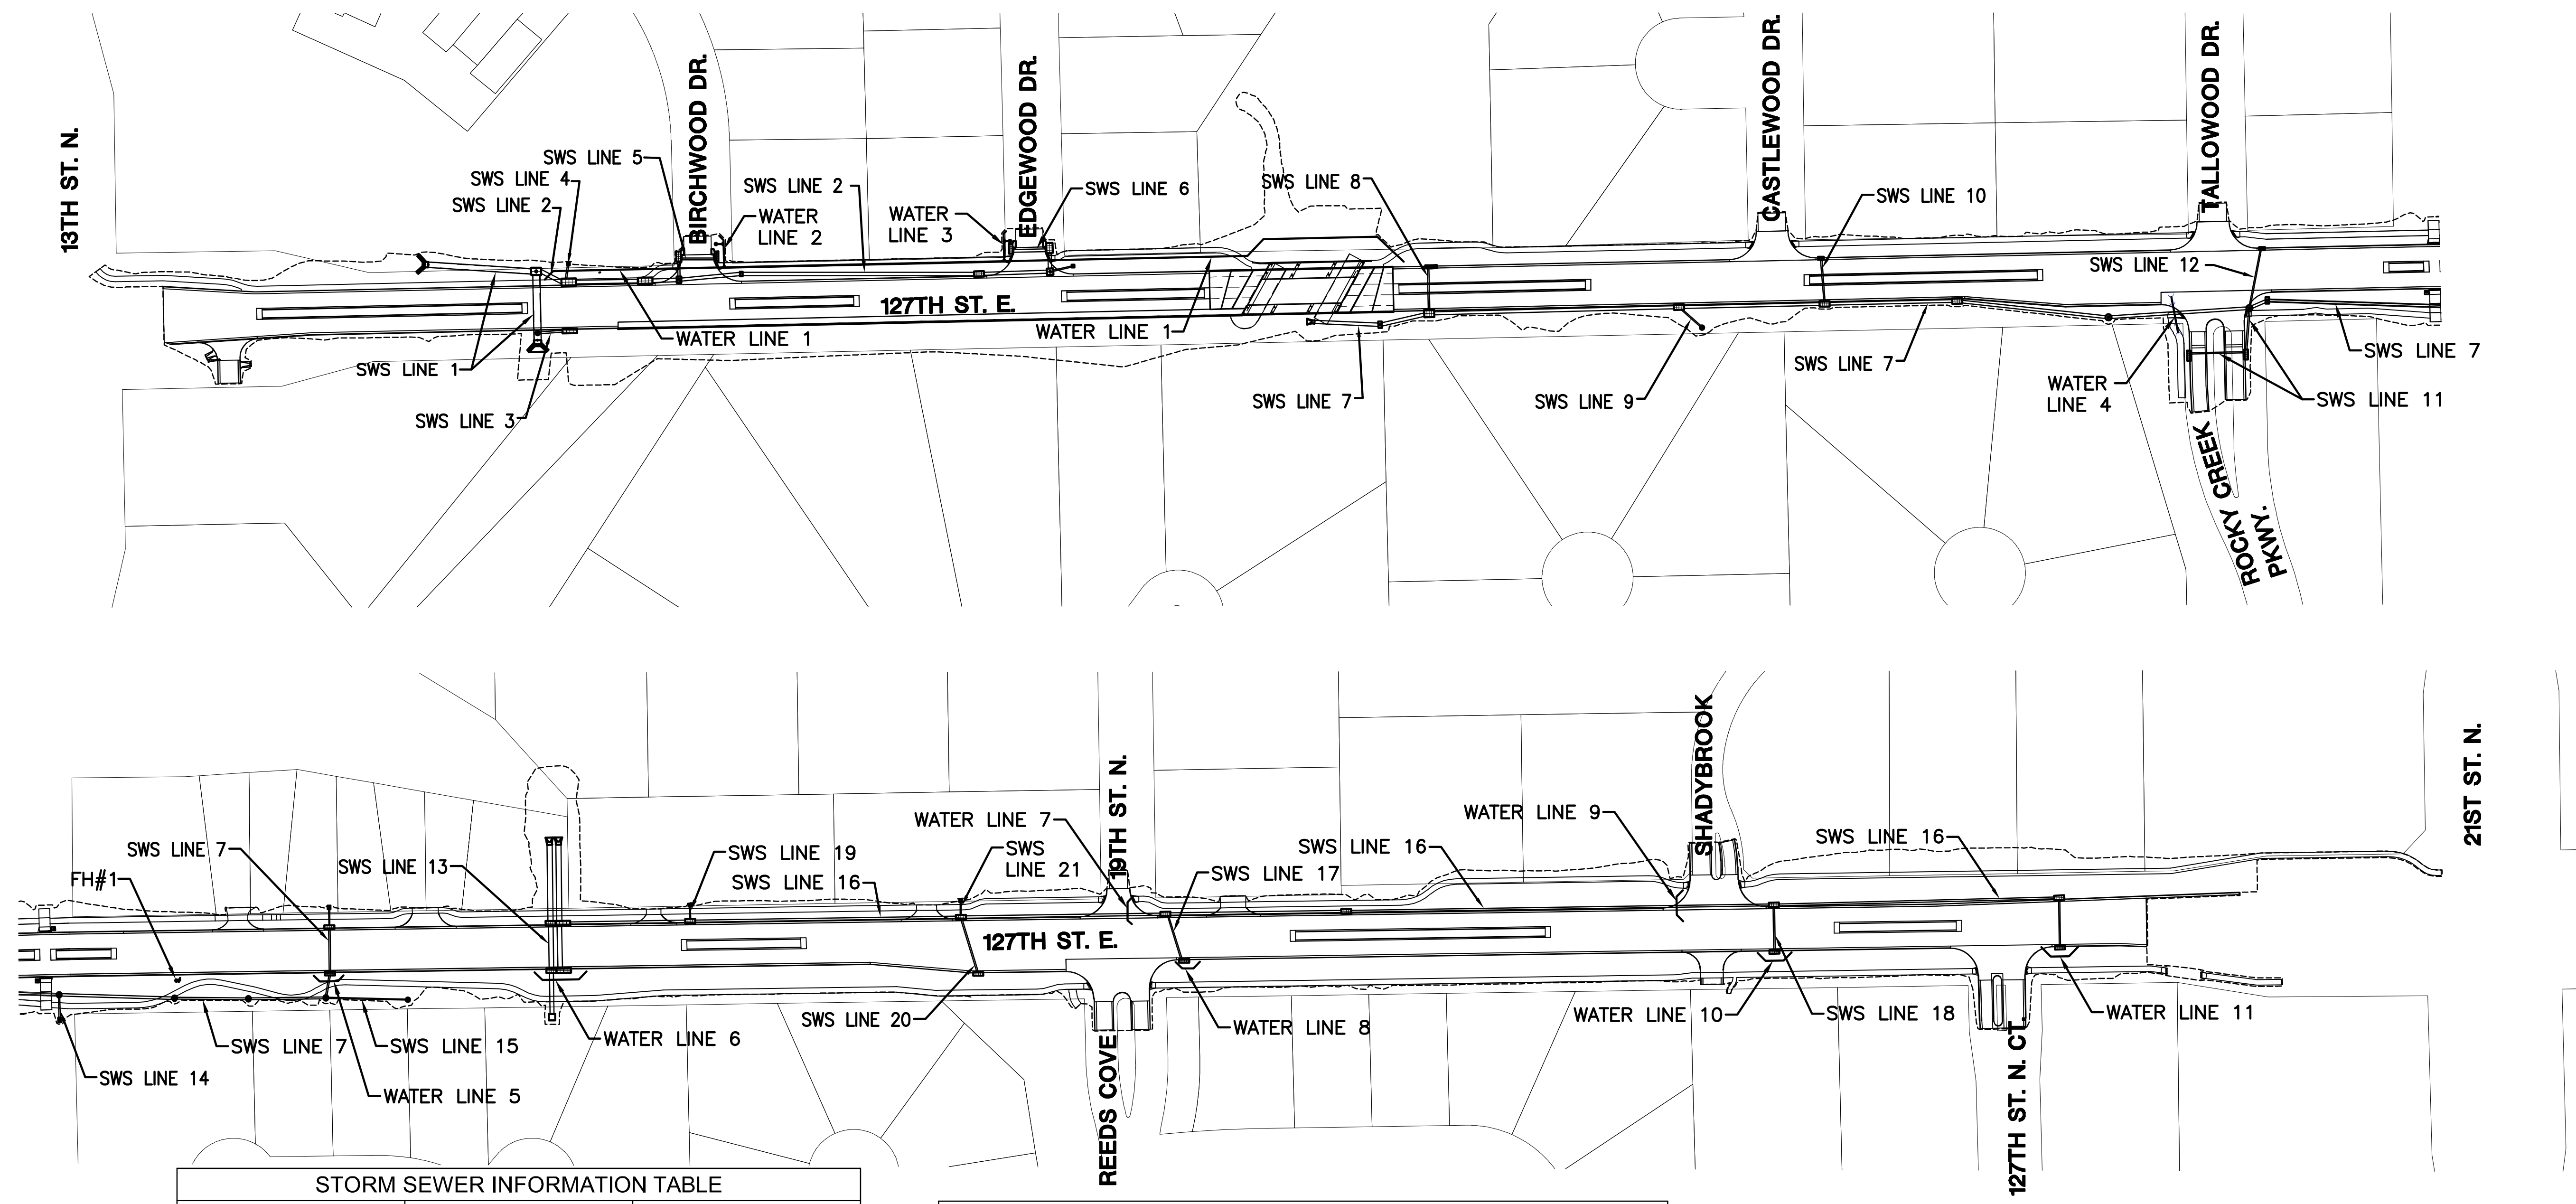

SWS LINE NO.	SHEET NO.	SHEET DESCRIPTION
SWS LINE 1	22	SWS PLAN AND PROFILE
SWS LINE 2	23, 24	SWS PLAN AND PROFILE
SWS LINE 3	22	SWS PLAN AND PROFILE
SWS LINE 4	24	SWS PLAN AND PROFILE
SWS LINE 5	24	SWS PLAN AND PROFILE
SWS LINE 6	24	SWS PLAN AND PROFILE
SWS LINE 7	25, 26, 27	SWS PLAN AND PROFILE
SWS LINE 8	28	SWS PLAN AND PROFILE
SWS LINE 9	28	SWS PLAN AND PROFILE
SWS LINE 10	28	SWS PLAN AND PROFILE
SWS LINE 11	29	SWS PLAN AND PROFILE
SWS LINE 12	29	SWS PLAN AND PROFILE
SWS LINE 13	30	SWS PLAN AND PROFILE
SWS LINE 14	30	SWS PLAN AND PROFILE
SWS LINE 15	31	SWS PLAN AND PROFILE
SWS LINE 16	32, 33, 34, 35	SWS PLAN AND PROFILE
SWS LINE 17	35	SWS PLAN AND PROFILE
SWS LINE 18	35	SWS PLAN AND PROFILE
SWS LINE 19	29	SWS PLAN AND PROFILE
SWS LINE 20	31	SWS PLAN AND PROFILE
SWS LINE 21	31	SWS PLAN AND PROFILE

WATER LINE NO.	SHEET NO.	SHEET DESCRIPTION
WATER LINE 1	105, 106	WATER PLAN AND PROFILE
WATER LINE 2	105	WATER & FH PLAN AND PROFILE
WATER LINE 3	106	WATER & FH PLAN AND PROFILE
WATER LINE 4	107	WATER PLAN AND PROFILE
WATER LINE 5	107	WATER PLAN AND PROFILE
WATER LINE 6	107	WATER PLAN AND PROFILE
WATER LINE 7	108	WATER PLAN AND PROFILE
WATER LINE 8	108	WATER PLAN AND PROFILE
WATER LINE 9	109	WATER PLAN AND PROFILE
WATER LINE 10	109	WATER PLAN AND PROFILE
WATER LINE 11	109	WATER PLAN AND PROFILE
FH#1	108	FH PLAN AND PROFILE

