

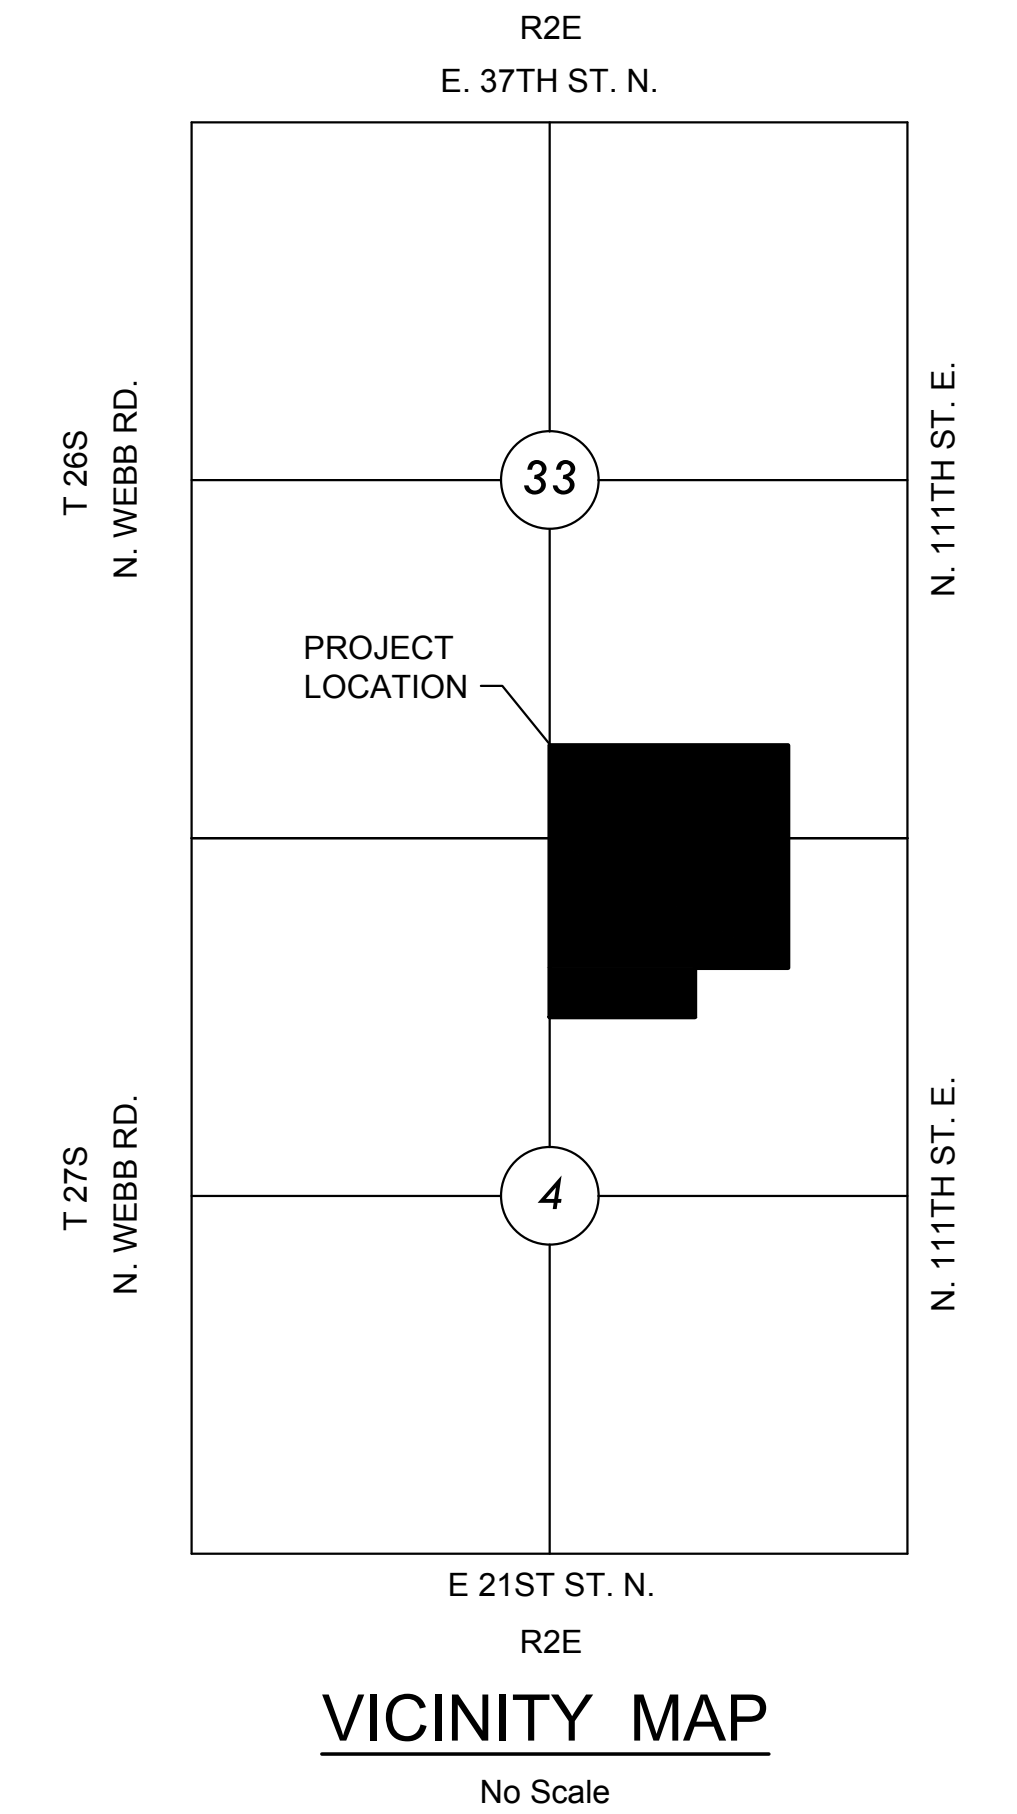


BUILDING PLANS FOR
STRYKER SPORTS
PHASE 4 - INDOOR FACILITY AND STADIUM IMPROVEMENTS

PROJECT NO. 472-85380
 AN ADDITION TO THE CITY OF WICHITA, SEDGWICK COUNTY, KANSAS
 GARY JANZEN, P.E. - CITY ENGINEER
 OCA NO. 796031

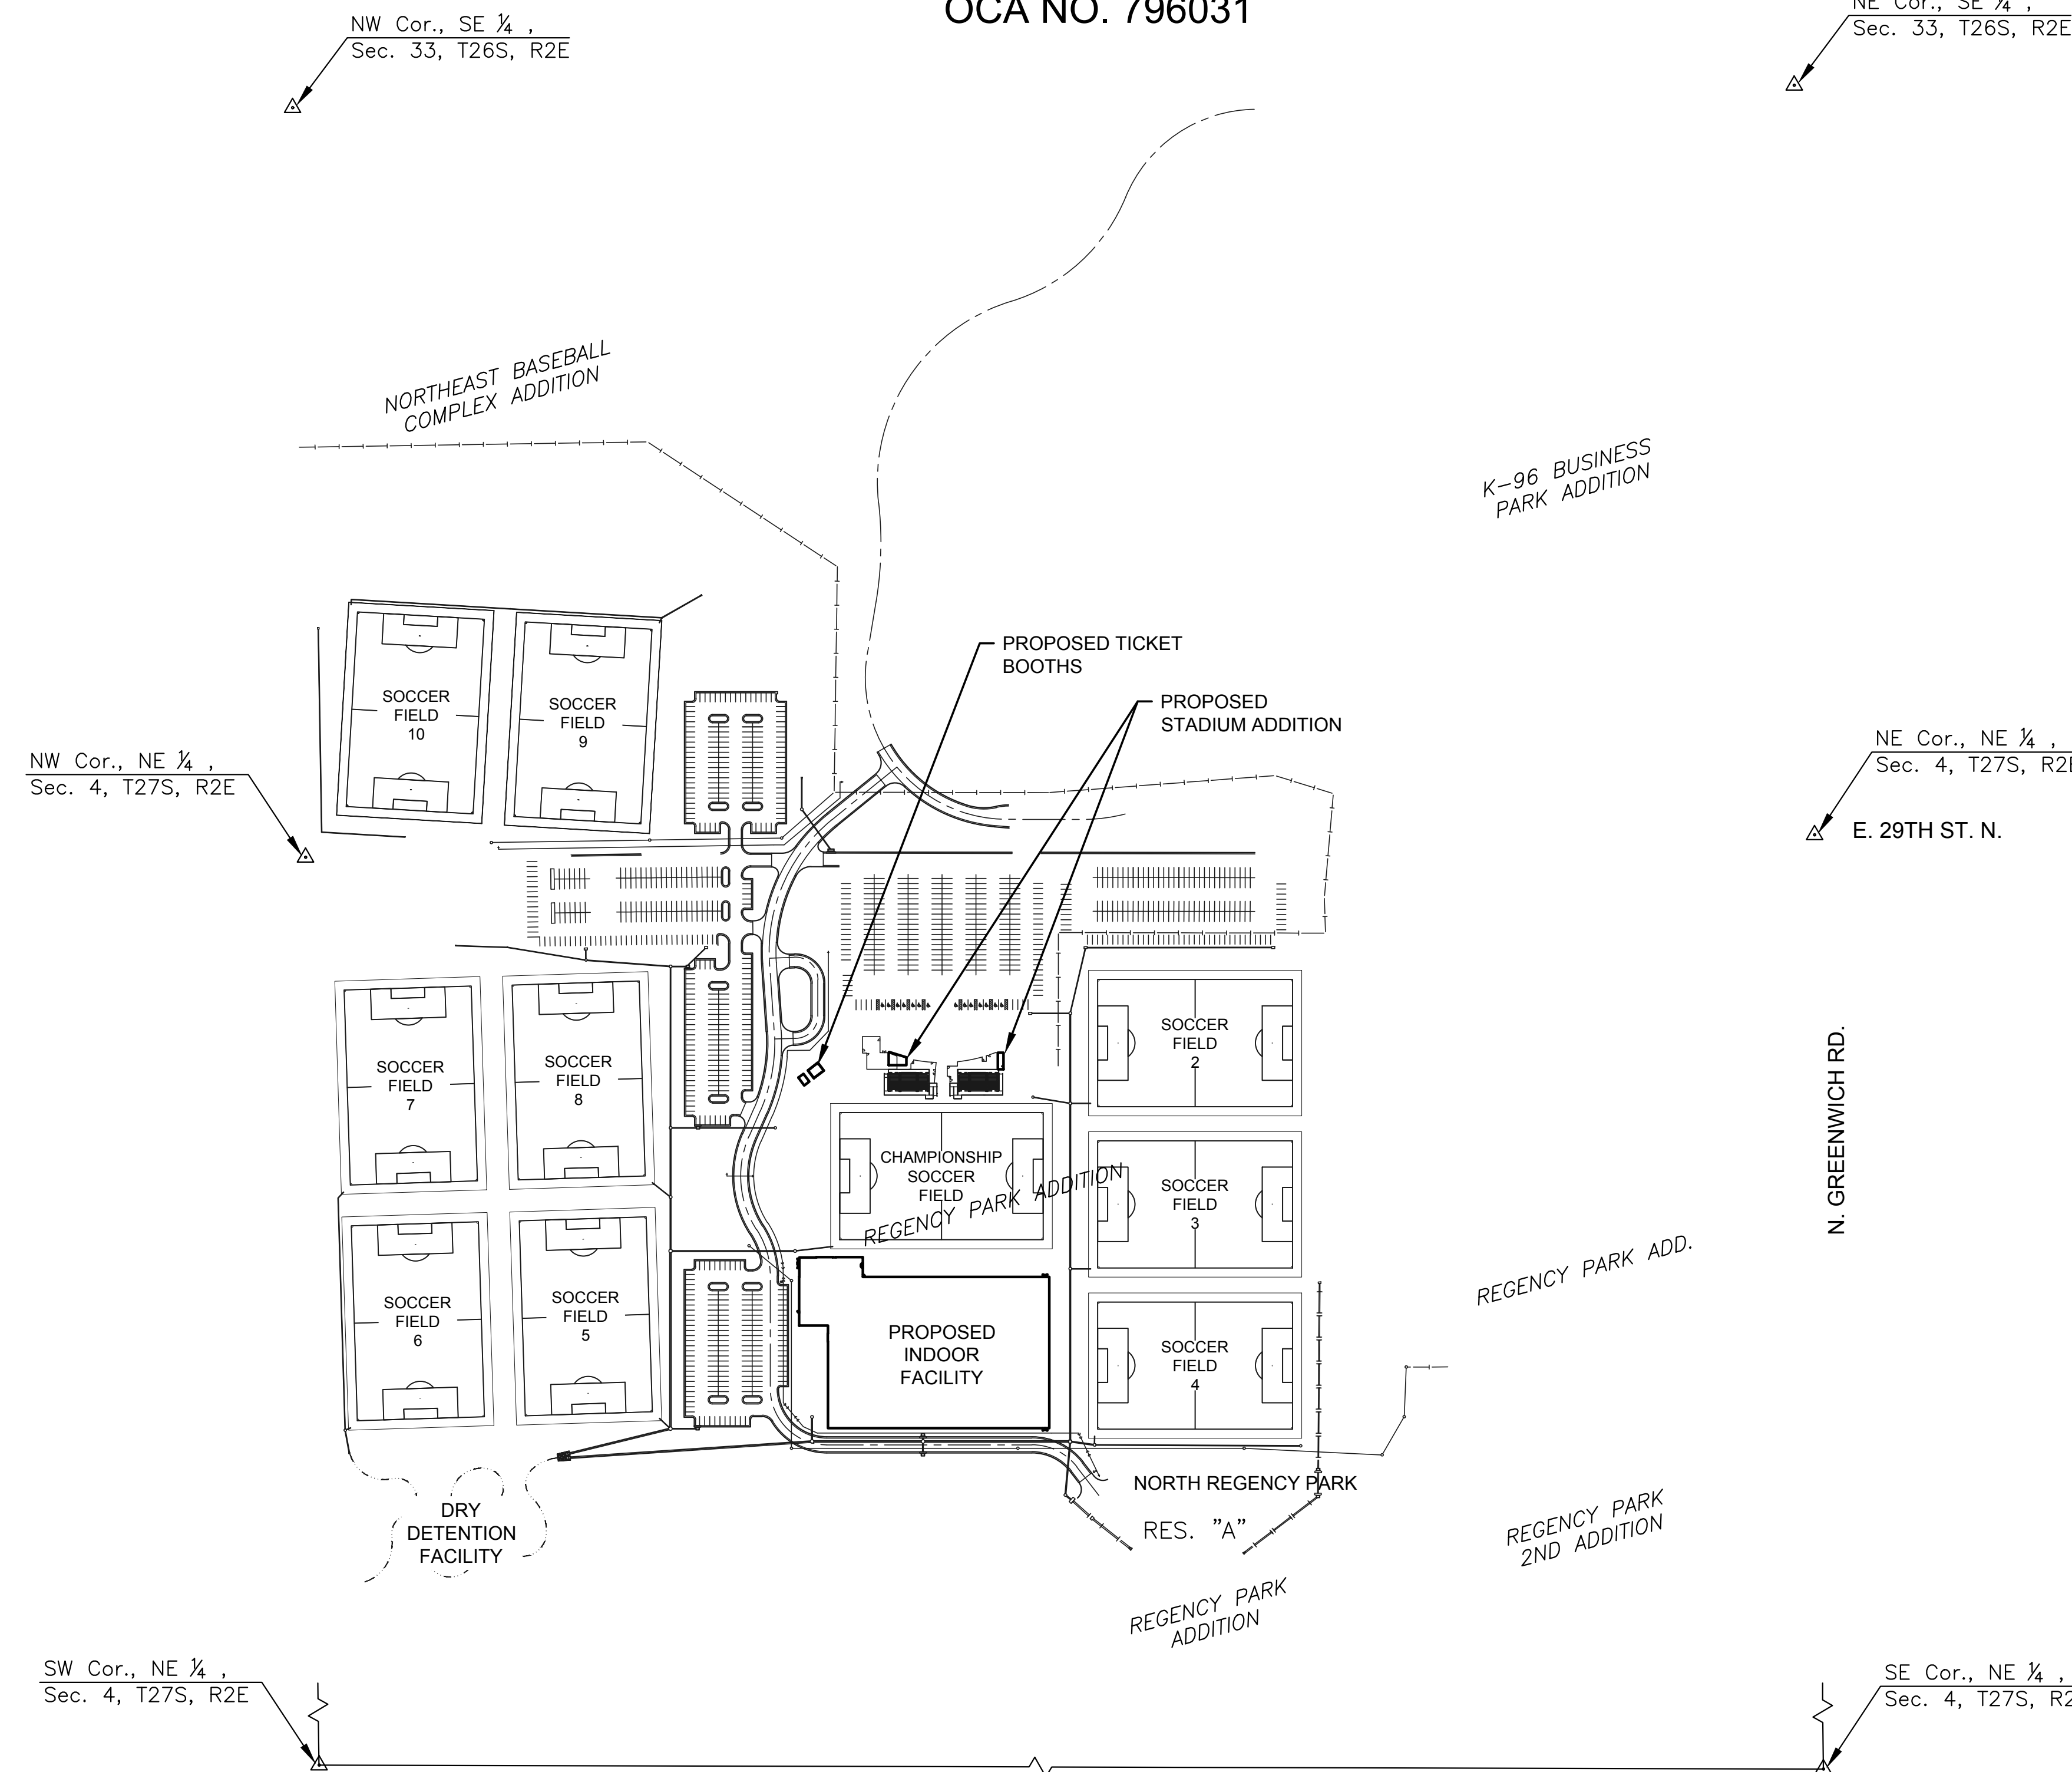

VICINITY MAP
 No Scale

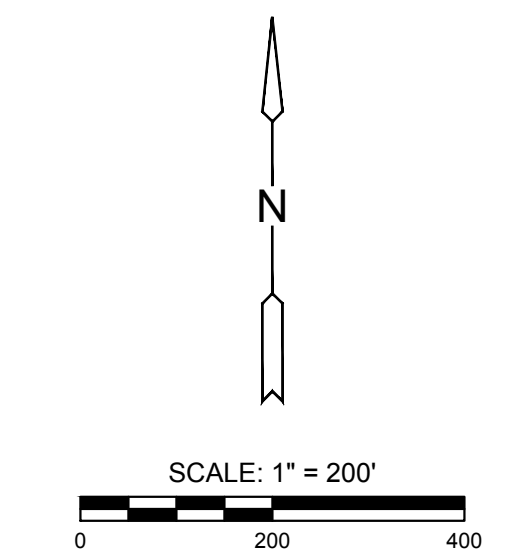

SHEET LIST

SHEET NO.	DESCRIPTION
CV-1	COVERSHEET

INDOOR FACILITY

SHEET NO.	DESCRIPTION
-----------	-------------

CIVIL	
FC1.0	OVERALL UTILITY SHEET
FC2.0	INDOOR FACILITY - AREA A
FC2.1	INDOOR FACILITY - AREA B
FC2.2	INDOOR FACILITY - AREA C
FC2.3	INDOOR FACILITY - AREA D
FC3.0	FIRE WATER LINE 1
FC3.1	WATER DETAILS
FC3.2	BMP 1
FC3.3	BMP 2
FC3.4	BMP 3
FC3.5	BMP 4
FC3.6	BMP 5
STRUCTURAL	
FS0.1	STRUCTURAL GENERAL NOTES
FS1.0	OVERALL FOUNDATION PLAN
FS1.1	FOUNDATION PLAN AREA "A"
FS1.2	FOUNDATION PLAN AREA "B"
FS1.3	FOUNDATION PLAN AREA "C"
FS1.4	FOUNDATION PLAN AREA "D"
FS1.5	FOUNDATION PLAN AREA "E"
FS2.1	ROOF PLAN
FS3.1	FOOTING & FOUNDATION SECTIONS
FS3.2	FOOTING & FOUNDATION SECTIONS
FS4.1	ROOF FRAMING SECTIONS
FS5.1	MECHANICAL UNIT FOUNDATION & SECTIONS
ARCHITECTURAL	
FA0.0	ARCHITECTURAL SYMBOLS AND ABBREVIATIONS
FA0.1	ROOM FINISH SCHEDULE, WALL TYPES, GENERAL NOTES
FA1.1	ORIENTATION FLOOR PLAN
FA1.2	FLOOR PLAN - AREA A
FA1.3	FLOOR PLAN - AREA B
FA1.4	FLOOR PLAN - AREA C

FA1.5	FLOOR PLAN - AREA D
FA1.6	FLOOR PLAN - AREA E
FA2.1	LARGE SCALE PLANS
FA3.1	REFLECTED CEILING PLAN - OVERALL
FA3.2	REFLECTED CEILING PLAN - AREA A
FA4.1	ROOF PLAN AND DETAILS
FA5.1	EXTERIOR ELEVATIONS
FA5.2	EXTERIOR ELEVATIONS
FA6.1	BUILDING SECTIONS
FA7.1	WALL SECTIONS
FA7.2	WALL SECTION DETAILS
FA9.1	DOOR AND FRAME SCHEDULE
FA9.2	DOOR AND FRAME DETAILS
FA10.1	GENERAL BUILDING DETAILS
FA11.1	INTERIOR AND CASEWORK ELEVATIONS
FA12.1	INTERIOR ELEVATIONS
FA12.2	INTERIOR ELEVATIONS
FA13.1	FINISH FLOOR PLAN - AREA A
MECHANICAL	
FM0.1	MECHANICAL COVERSHEET
FM1.1	HVAC PLAN - AREA A
FM1.2	HVAC PLAN - AREA B
FM1.3	HVAC PLAN - AREA C
FM1.4	HVAC PLAN - AREA D
FM1.5	HVAC PLAN - AREA E
FM1.6	MECHANICAL ELEVATIONS
FM2.1	MECHANICAL DETAILS
FM3.1	MECHANICAL SCHEDULES
PLUMBING	
FP1.1	WASTE AND VENT PLAN - AREA A
FP2.1	DOMESTIC WATER PLAN - AREA A
FP2.2	DOMESTIC WATER PLAN - AREA B
FP2.3	DOMESTIC WATER PLAN - AREA C
FP2.4	DOMESTIC WATER PLAN - AREA D

FP2.5	DOMESTIC WATER PLAN - AREA E
FP3.1	PLUMBING DETAILS
FP3.2	PLUMBING SCHEDULES
ELECTRICAL	
FE0.1	ELECTRICAL COVERSHEET
FE1.1	ELECTRICAL POWER/SYSTEMS PLAN - AREA A
FE1.2	ELECTRICAL POWER/SYSTEMS PLAN - AREA B
FE1.3	ELECTRICAL POWER/SYSTEMS PLAN - AREA C
FE1.4	ELECTRICAL POWER/SYSTEMS PLAN - AREA D
FE1.5	ELECTRICAL POWER/SYSTEMS PLAN - AREA E
FE2.1	ELECTRICAL LIGHTING PLAN - AREA A
FE2.2	ELECTRICAL LIGHTING PLAN - AREA B
FE2.3	ELECTRICAL LIGHTING PLAN - AREA C
FE2.4	ELECTRICAL LIGHTING PLAN - AREA D
FE2.5	ELECTRICAL LIGHTING PLAN - AREA E
FE3.1	ELECTRICAL DETAILS
FE4.1	ELECTRICAL SCHEDULES
FE4.2	ELECTRICAL SCHEDULES
FIRE PROTECTION	
FF1.0	FIRE PROTECTION COVER SHEET
FF2.0	FIRE SPRINKLER PIPING PLAN AREA A

STADIUM IMPROVEMENTS

SHEET NO.	DESCRIPTION
-----------	-------------

CIVIL	
SC4.0	DEMOLITION PLAN
SC4.1	STADIUM - WEST AREA
SC4.	STADIUM - EAST AREA
STRUCTURAL	
SS1.0	OVERALL LOCATION PLAN
SS1.1	FOOTING & FOUNDATION PLAN
SS1.2	LOW ROOF FRAMING PLAN
SS2.1	FOOTING & FOUNDATION SECTIONS
SS3.1	ROOF FRAMING SECTIONS
ARCHITECTURAL	
SA0.1	STADIUM ARCHITECTURAL COVER SHEET
SA0.2	CODE ANALYSIS
SA0.3	UL NUMBERS & VARIANCE
SA1.1	DEMOLITION & BLEACHER PLANS
SA1.2	FLOOR & ROOF PLANS
SA1.3	CEILING PLANS & EQUIPMENT PLAN
SA3.1	EXTERIOR ELEVATIONS
SA4.1	BUILDING SECTIONS
SA4.2	WALL SECTIONS
SA4.3	WALL SECTIONS
SA4.4	WALL SECTIONS
SA5.1	DETAILS
SA5.2	DETAILS
SA6.1	SCHEDULES & DETAILS
SA7.1	ENLARGED PLANS & ADA ACCESSIBILITY
SA7.2	INTERIOR ELEVATIONS
SA7.3	INTERIOR ELEVATIONS & CASEWORK DETAILS
MECHANICAL	
SM1.0	MECHANICAL COVERSHEET
SM2.0	MECHANICAL DEMOLITION PLAN
SM3.0	MECHANICAL PLAN
SM4.0	MECHANICAL DETAILS

SM5.0	MECHANICAL SCHEDULES
PLUMBING	
SP1.0	PLUMBING DEMOLITION PLAN
SP2.0	WASTE & VENT IMPROVEMENT PLAN
SP3.0	DOMESTIC WATER IMPROVEMENT PLAN
SP4.0	PLUMBING DETAILS
SP5.0	PLUMBING SCHEDULES
ELECTRICAL	
SE1.0	ELECTRICAL COVERSHEET
SE2.0	POWER/SYSTEMS DEMOLITION PLAN
SE2.1	LIGHTING DEMOTION PLAN
SE3.0	POWER/SYSTEMS PLAN
SE3.1	ENLARGED POWER/SYSTEMS/LIGHTING PLAN
SE4.0	LIGHTING PLAN
SE5.0	ELECTRICAL DETAILS
SE6.0	ELECTRICAL SCHEDULES



INDOOR FACILITY & STADIUM IMPROVEMENTS
STRYKER SPORTS
 WICHITA, KANSAS

TITLE SHEET

PROJECT NO.	1701010567	
DATE	03-07-18	
SCALE	AS NOTED	
DESIGNED	DRAWN	CHECKED
MKEC	MKEC	MKEC
NO.	REVISION	DATE
0	ISSUE FOR CONSTRUCTION	03-07-18
SHEET NO.		
CV-1		