
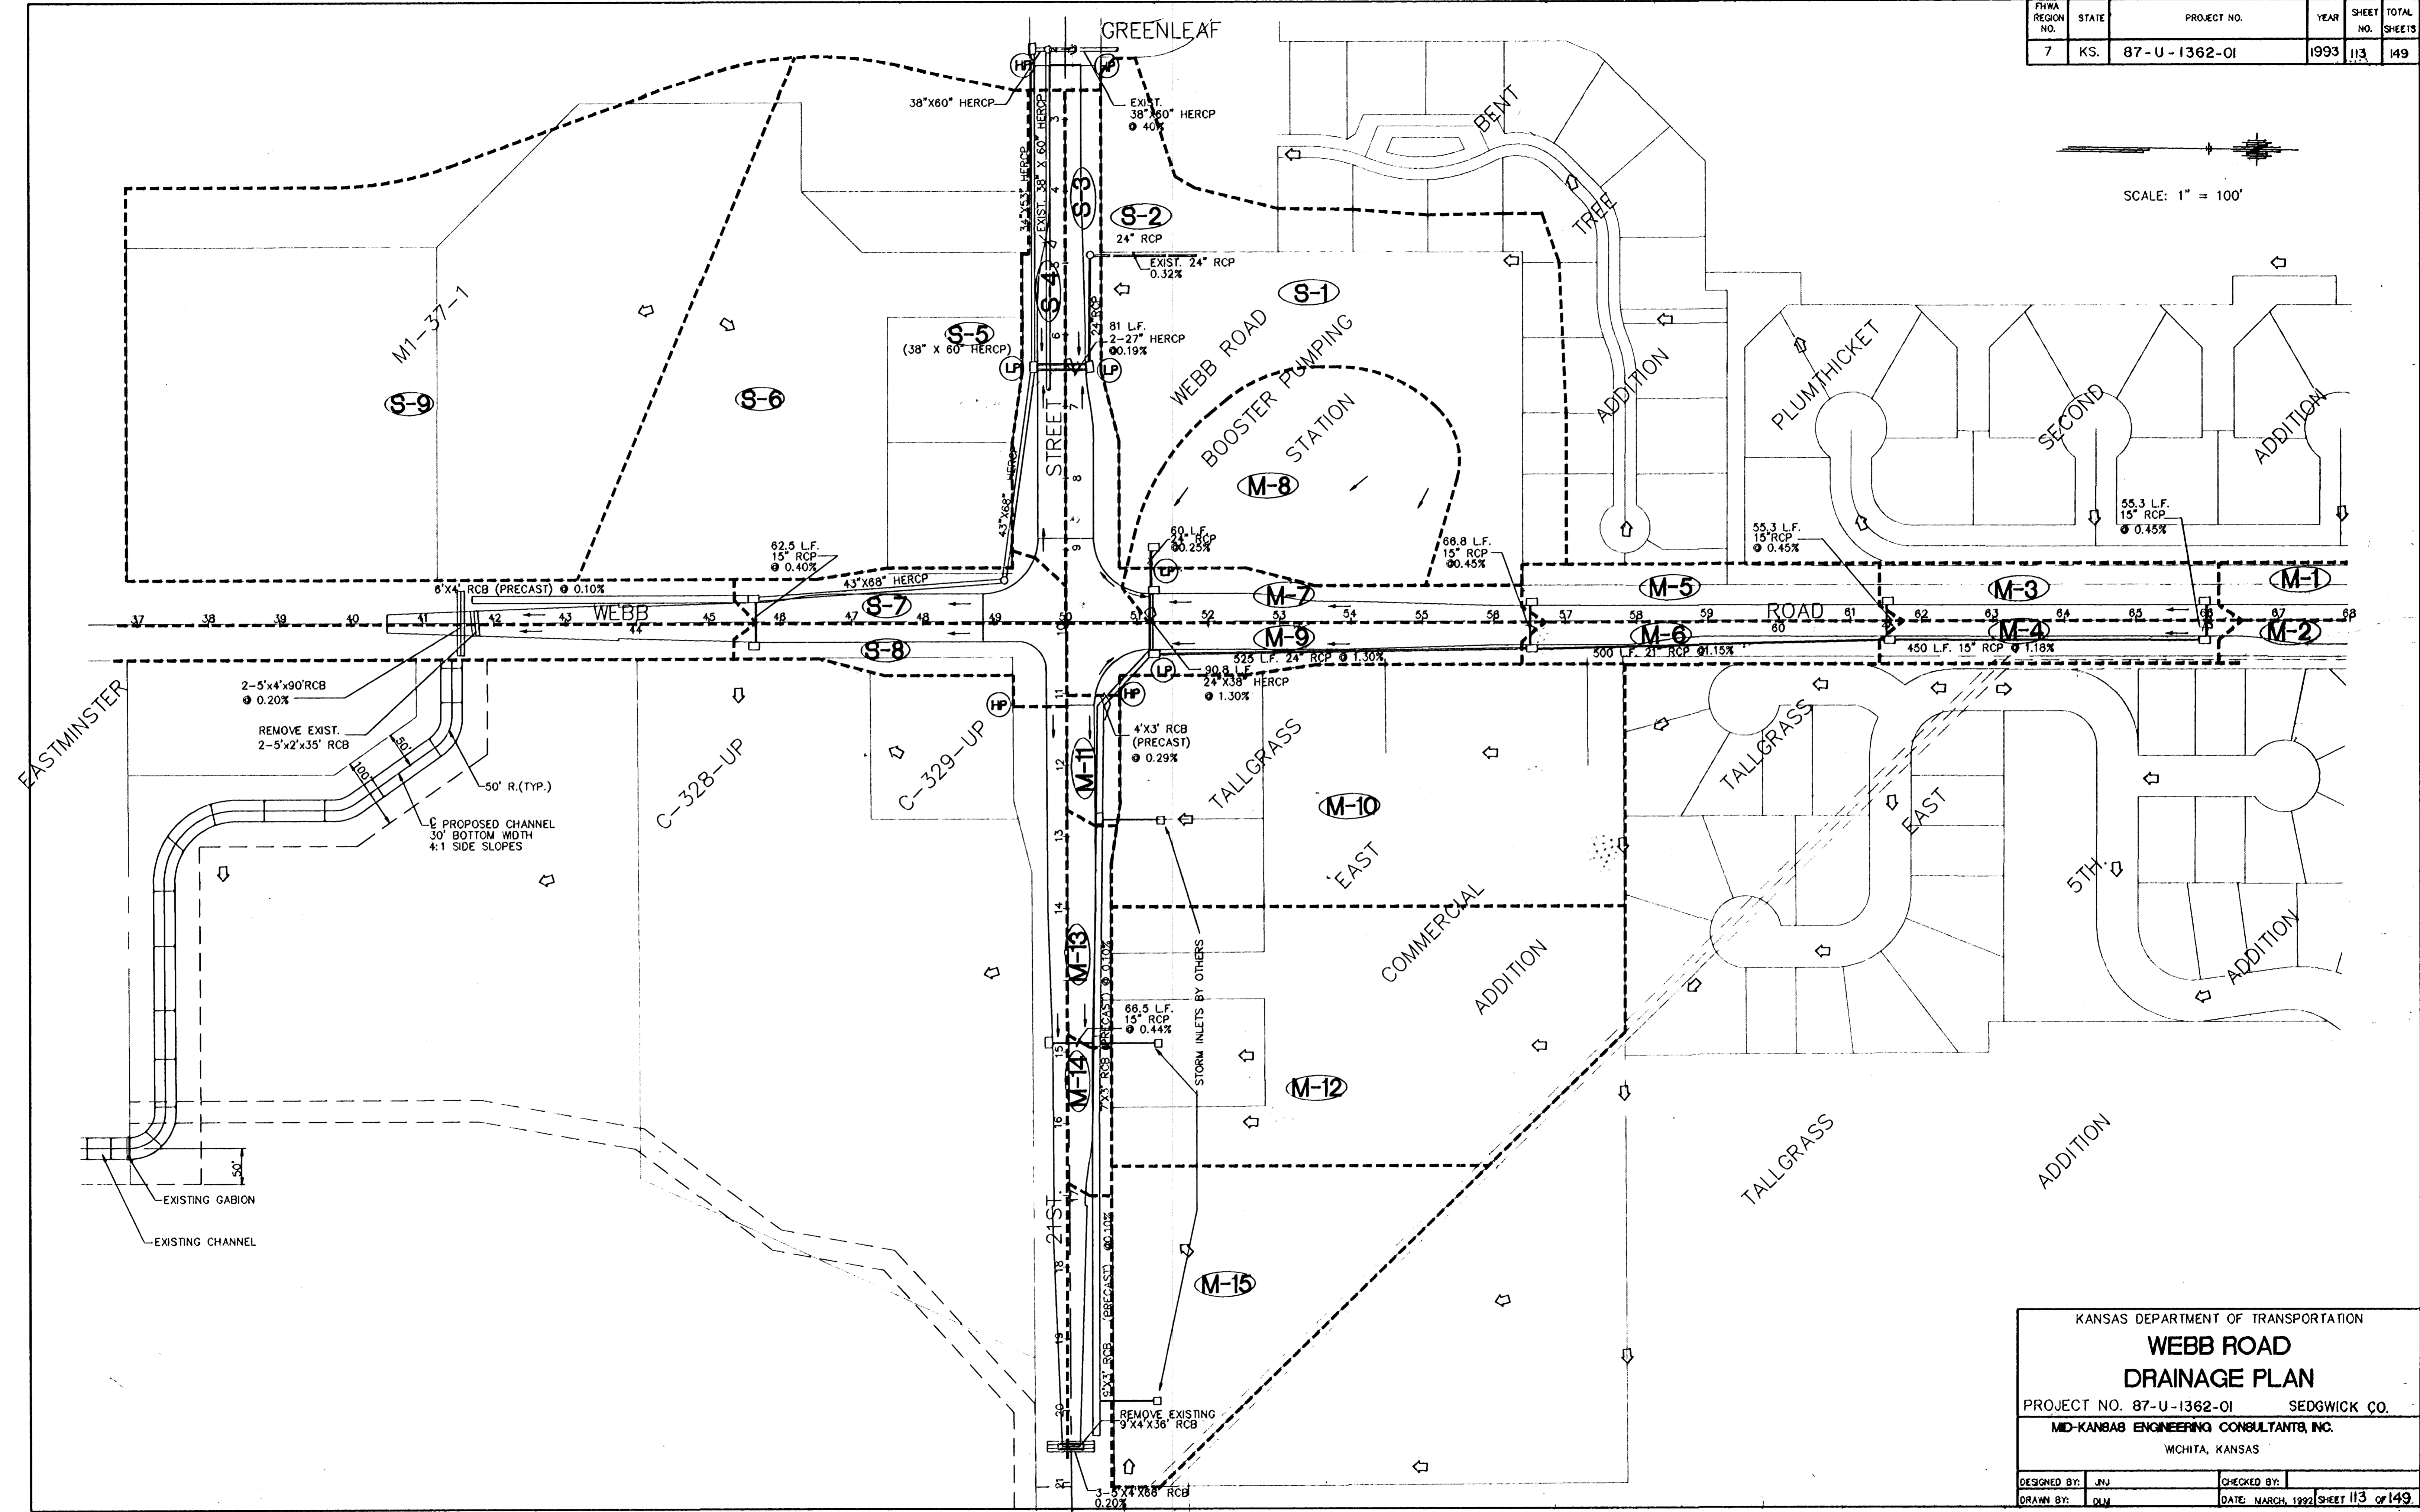


FHWA REGION NO.	STATE	PROJECT NO.	YEAR	SHEET NO.	TOTAL SHEETS
7	KS.	87-U-1362-01	1993	113	149

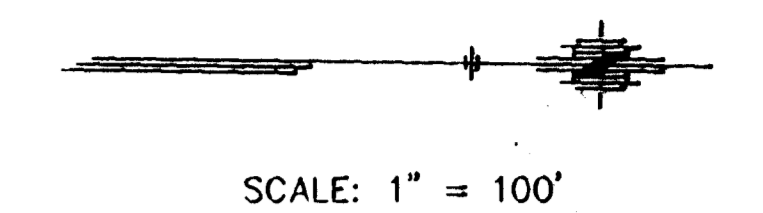

KANSAS DEPARTMENT OF TRANSPORTATION

### WEBB ROAD DRAINAGE PLAN

PROJECT NO. 87-U-1362-01      SEDGWICK CO.  
MID-KANSAS ENGINEERING CONSULTANTS, INC.  
WICHITA, KANSAS

DESIGNED BY: JNJ	CHECKED BY:
DRAWN BY: DJM	DATE: MARCH, 1992 SHEET 113 of 149